


FIRST FLOOR KEY PLAN
SCALE: 1/8" = 1'-0"

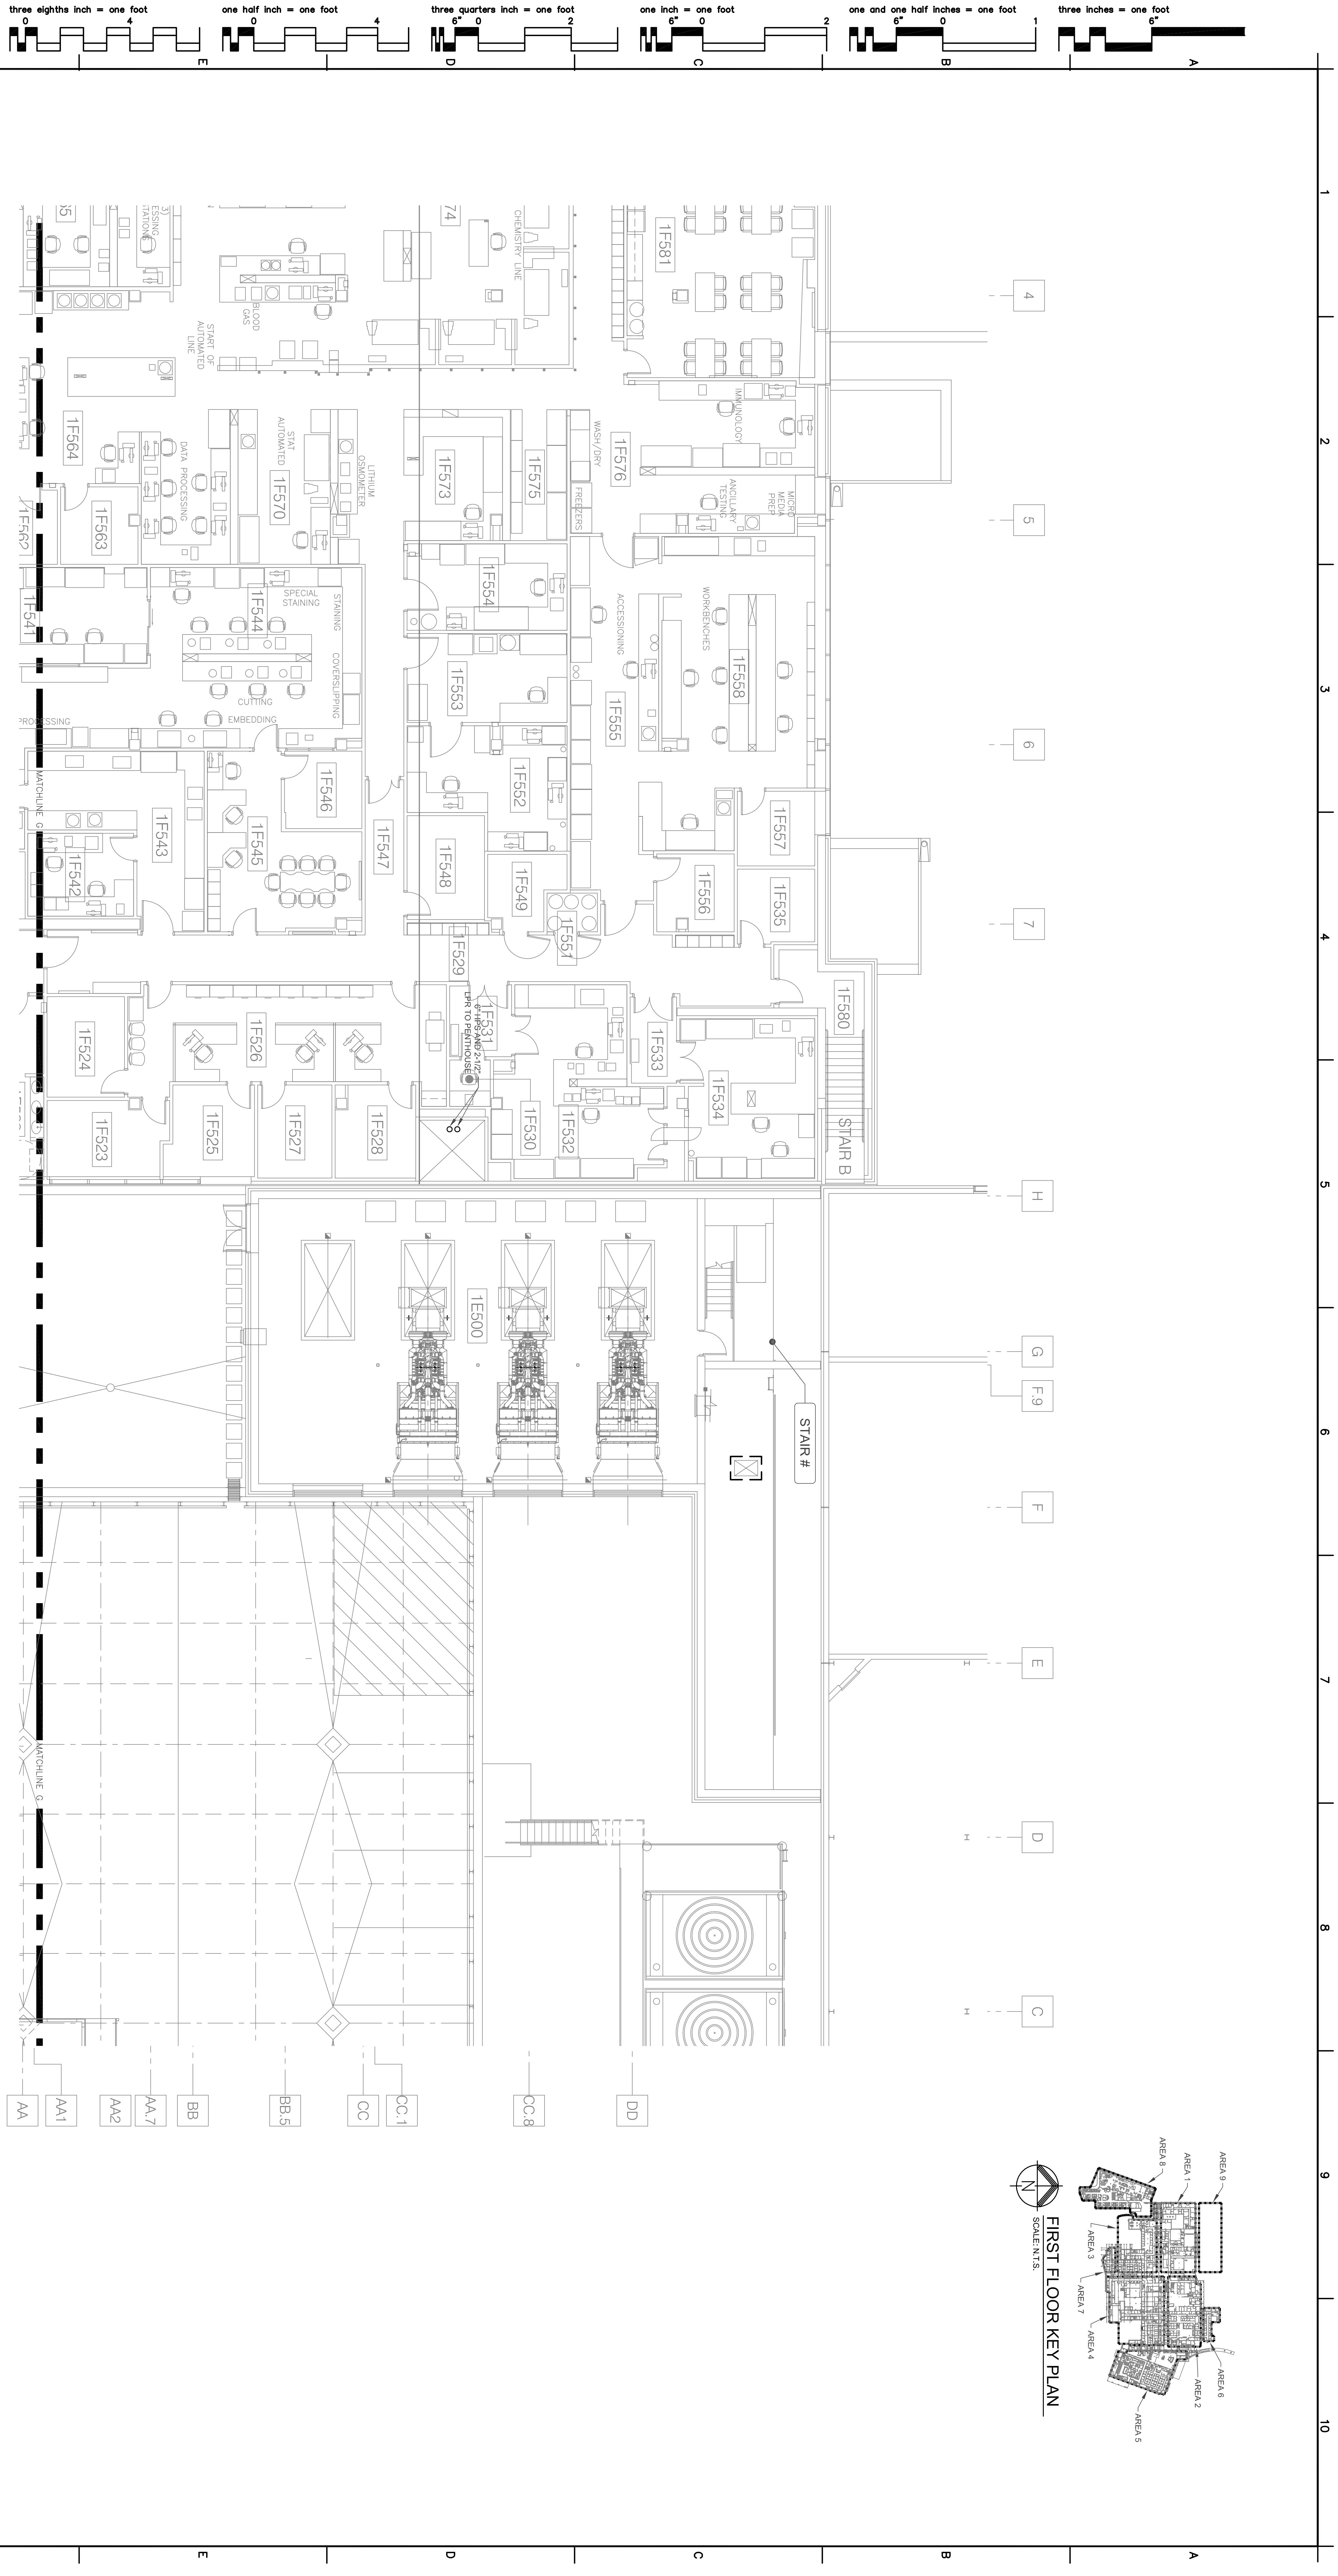

PARTIAL FIRST FLOOR - STEAM PIPING - AREA 9
SCALE: 1/8" = 1'-0"

CONSULTANTS:		ARCHITECT:	
FREDERICK, FREDERICK & HELLER 772 EAST ROYALTON ROAD BROADVIEW HTS., OHIO 44147 Tel. (440) 546-2666 Fax. (440) 546-2666		Project Title FIRST FLOOR PLAN AREA 9	
Revisions: FINAL CD SUBMISSION 95% SUBMISSION 65% SUBMISSION		Project Title STEAM TRAP MONITORING, INSULATION AND PIPING UPGRADES	
Date		Location VAMC - WADE PARK	
Date		Checked WPH	
Date		Drawn JMF	
Date		Drawing Number 3-1-9	
Date		Building Number 541-12-115	
Date		Drawing Number 1	
Date		Office of Facilities Management Department of Veterans Affairs	