


FOURTH FLOOR KEY PLAN
SCALE: N.T.S.



1
NEW 1 1/2" STEAM CONDENSATE FROM
RELOCATED STEAM TRAPS ON AHU-54
ABOVE. SEE DWG. 3-5-4.


PARTIAL FOURTH FLOOR - STEAM PIPING - AREA 3
SCALE: 1/8" = 1'-0"
0 4 8 16 32'

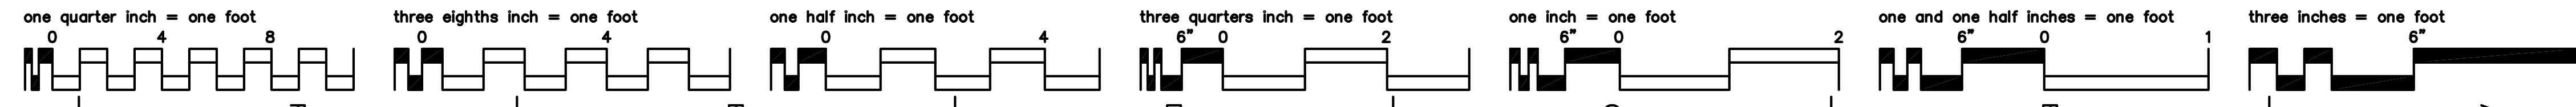

FINAL CD-SUBMISSION	12-21-12
95% SUBMISSION	11-30-12
65% SUBMISSION	11-16-12
Revisions:	Date

CONSULTANTS:

FREDRICK, FREDRICK & HELLER
ARCHITECTS
672 EAST ROYALTON ROAD
BROADVIEW HTS., OHIO 44147
TEL: (440) 546-3666
FAX: (440) 546-3666

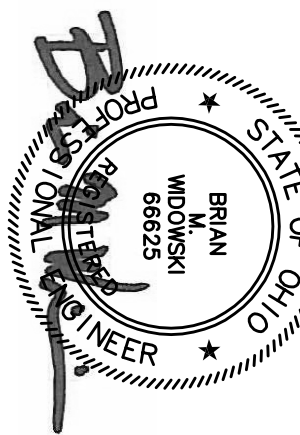

ARCHITECT:

Drawing Title
**FOURTH FLOOR PLAN
AREA 3**

Approved: Project Director

Project Title
**STEAM TRAP MONITORING,
INSULATION AND PIPING
UPGRADES**

Location
VAMC - WADE PARK

Date
12-21-12

Checked
WPH

Drawn
JMF

Project Number
541-12-115

Building Number
1

**Office of
Facilities
Management**

