


FOURTH FLOOR KEY PLAN  
SCALE: N.T.S.

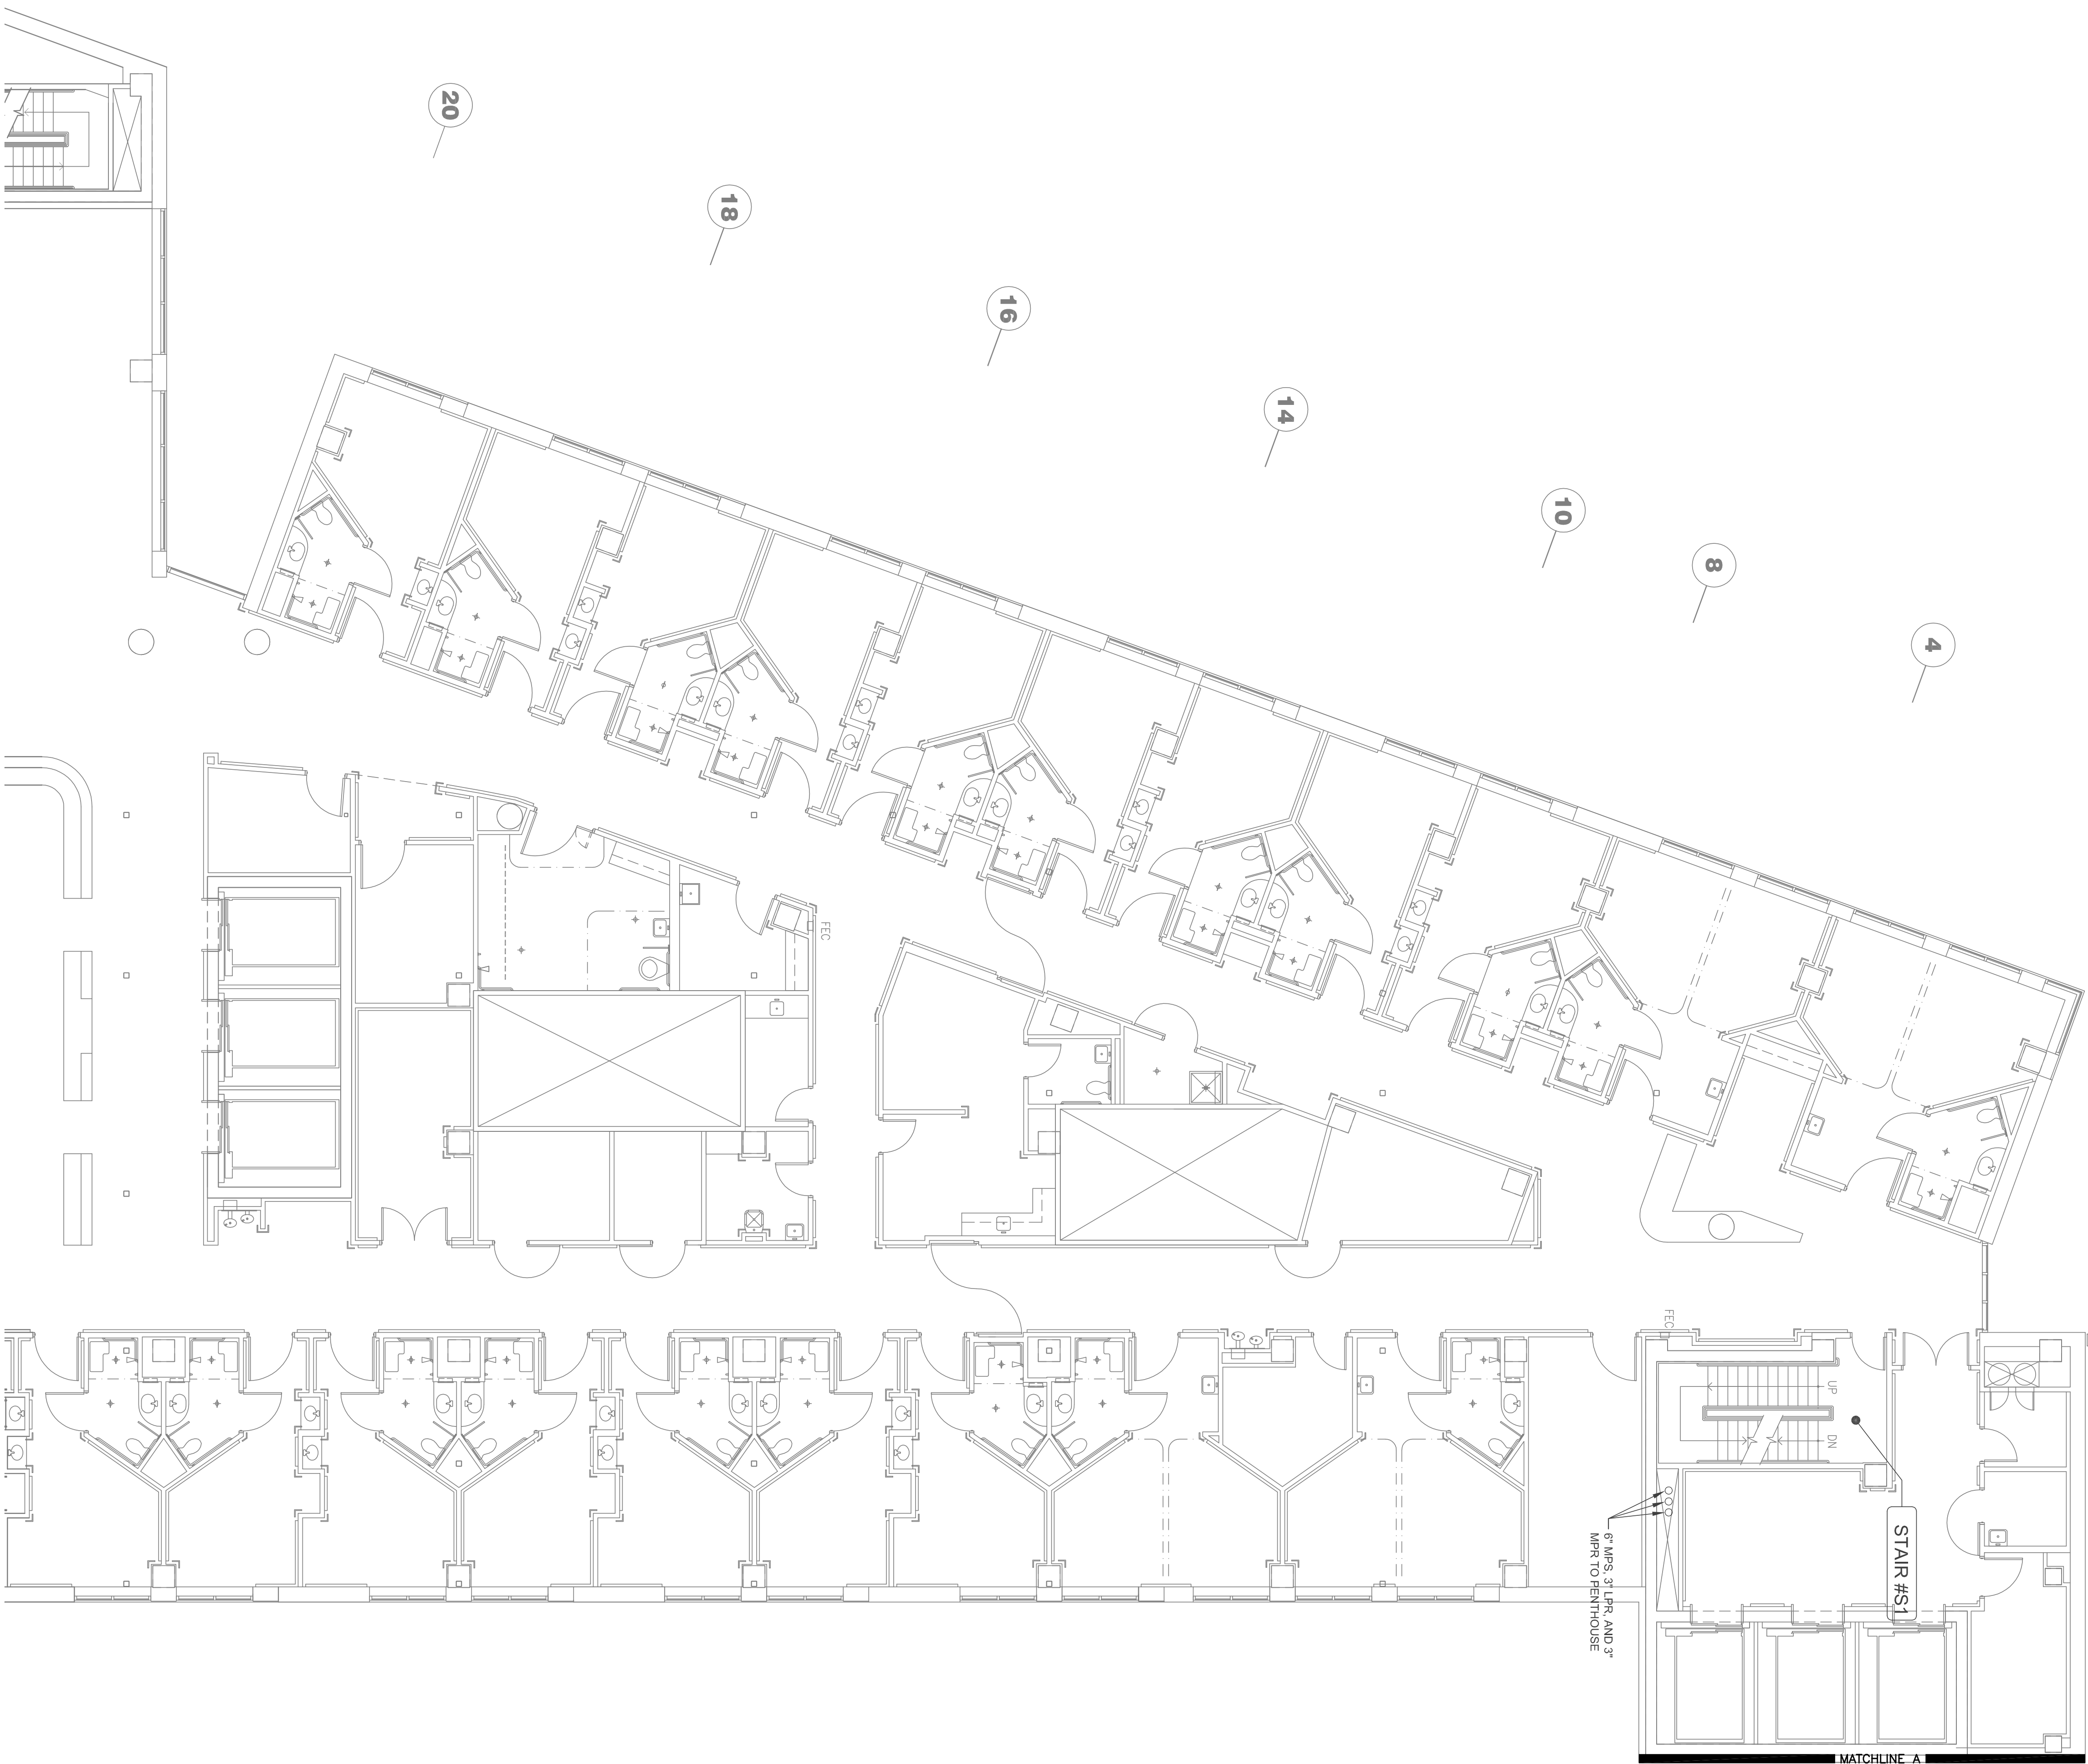

PARTIAL FOURTH FLOOR - STEAM PIPING - AREA 4  
SCALE: 1/8" = 1'-0"  
0 4 8 16 32'

1

Revisions:		Date	
65% SUBMISSION	11-16-12		
95% SUBMISSION	11-30-12		
FINAL CD-SUBMISSION	12-21-12		
CONSULTANTS:			
FREDERICK, FREDERICK & HELLER ARCHITECTS, INC. 672 EAST ROYALTON ROAD BROADVIEW HTS., OHIO 44147 TEL (440) 546-2666 FAX (440) 546-2666			
ARCHITECT:			
Drawing Title FOURTH FLOOR PLAN AREA 4			
Project Title STEAM TRAP MONITORING, INSULATION AND PIPING UPGRADES			
Location VAMC - WADE PARK			
Building Number 541-12-115			
Drawing Number 3-4-4			
Office of Facilities Management Department of Veterans Affairs			