


FIFTH FLOOR KEY PLAN
SCALE: N.T.S.

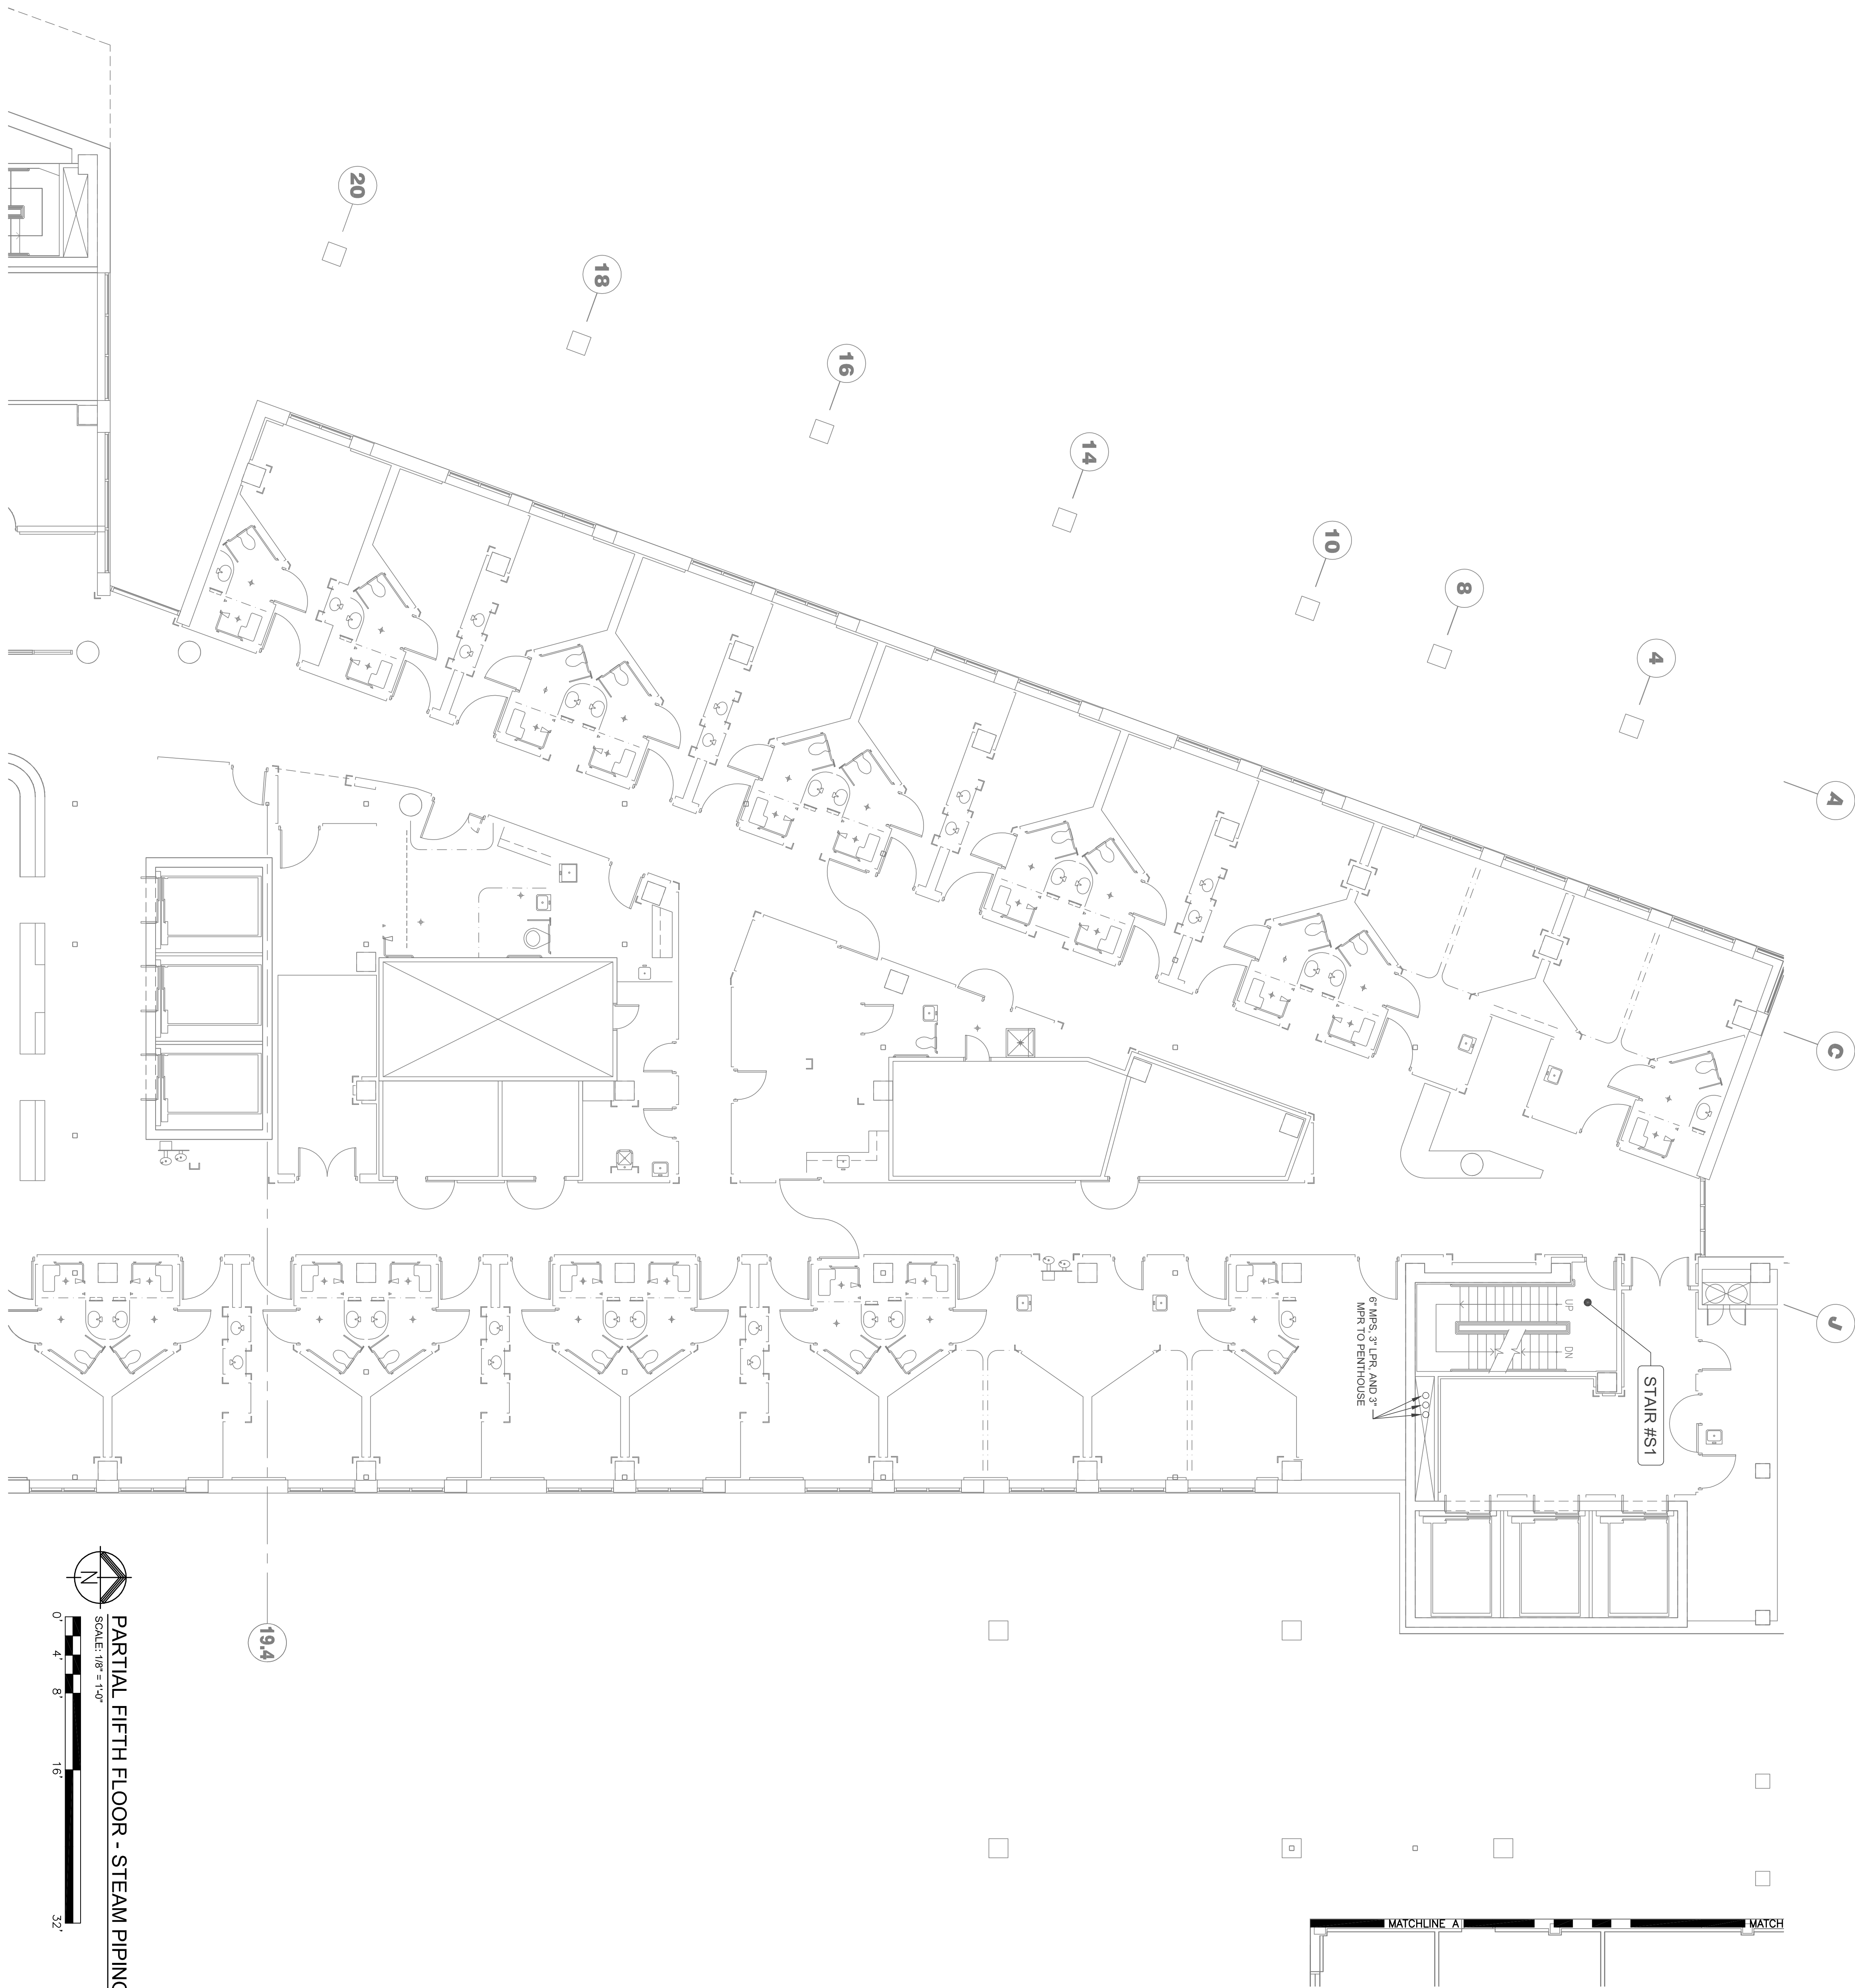


PARTIAL FIFTH FLOOR - STEAM PIPING - AREA 3
SCALE: 1/8\"/>

1

CONSULTANTS:

FREDERICK, FREDERICK & HELLER
ARCHITECTS
672 EAST ROYALTON ROAD
BROADVIEW HTS., OHIO 44147
TEL (440) 546-2666
FAX (440) 546-2666

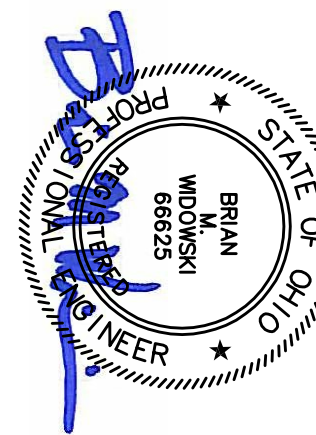

ARCHITECT:

PARTIAL FIFTH FLOOR STEAM
PIPING PLAN - AREA 3

Approved: Project Director

Project Title
STEAM TRAP MONITORING,
INSULATION AND PIPING
UPGRADES
LOCATION
VAMC - WADE PARK

Date
12-21-12
Checked
WPH
Drawn
JMF

Project Number
541-12-115
Building Number
1

Office of
Facilities
Management

