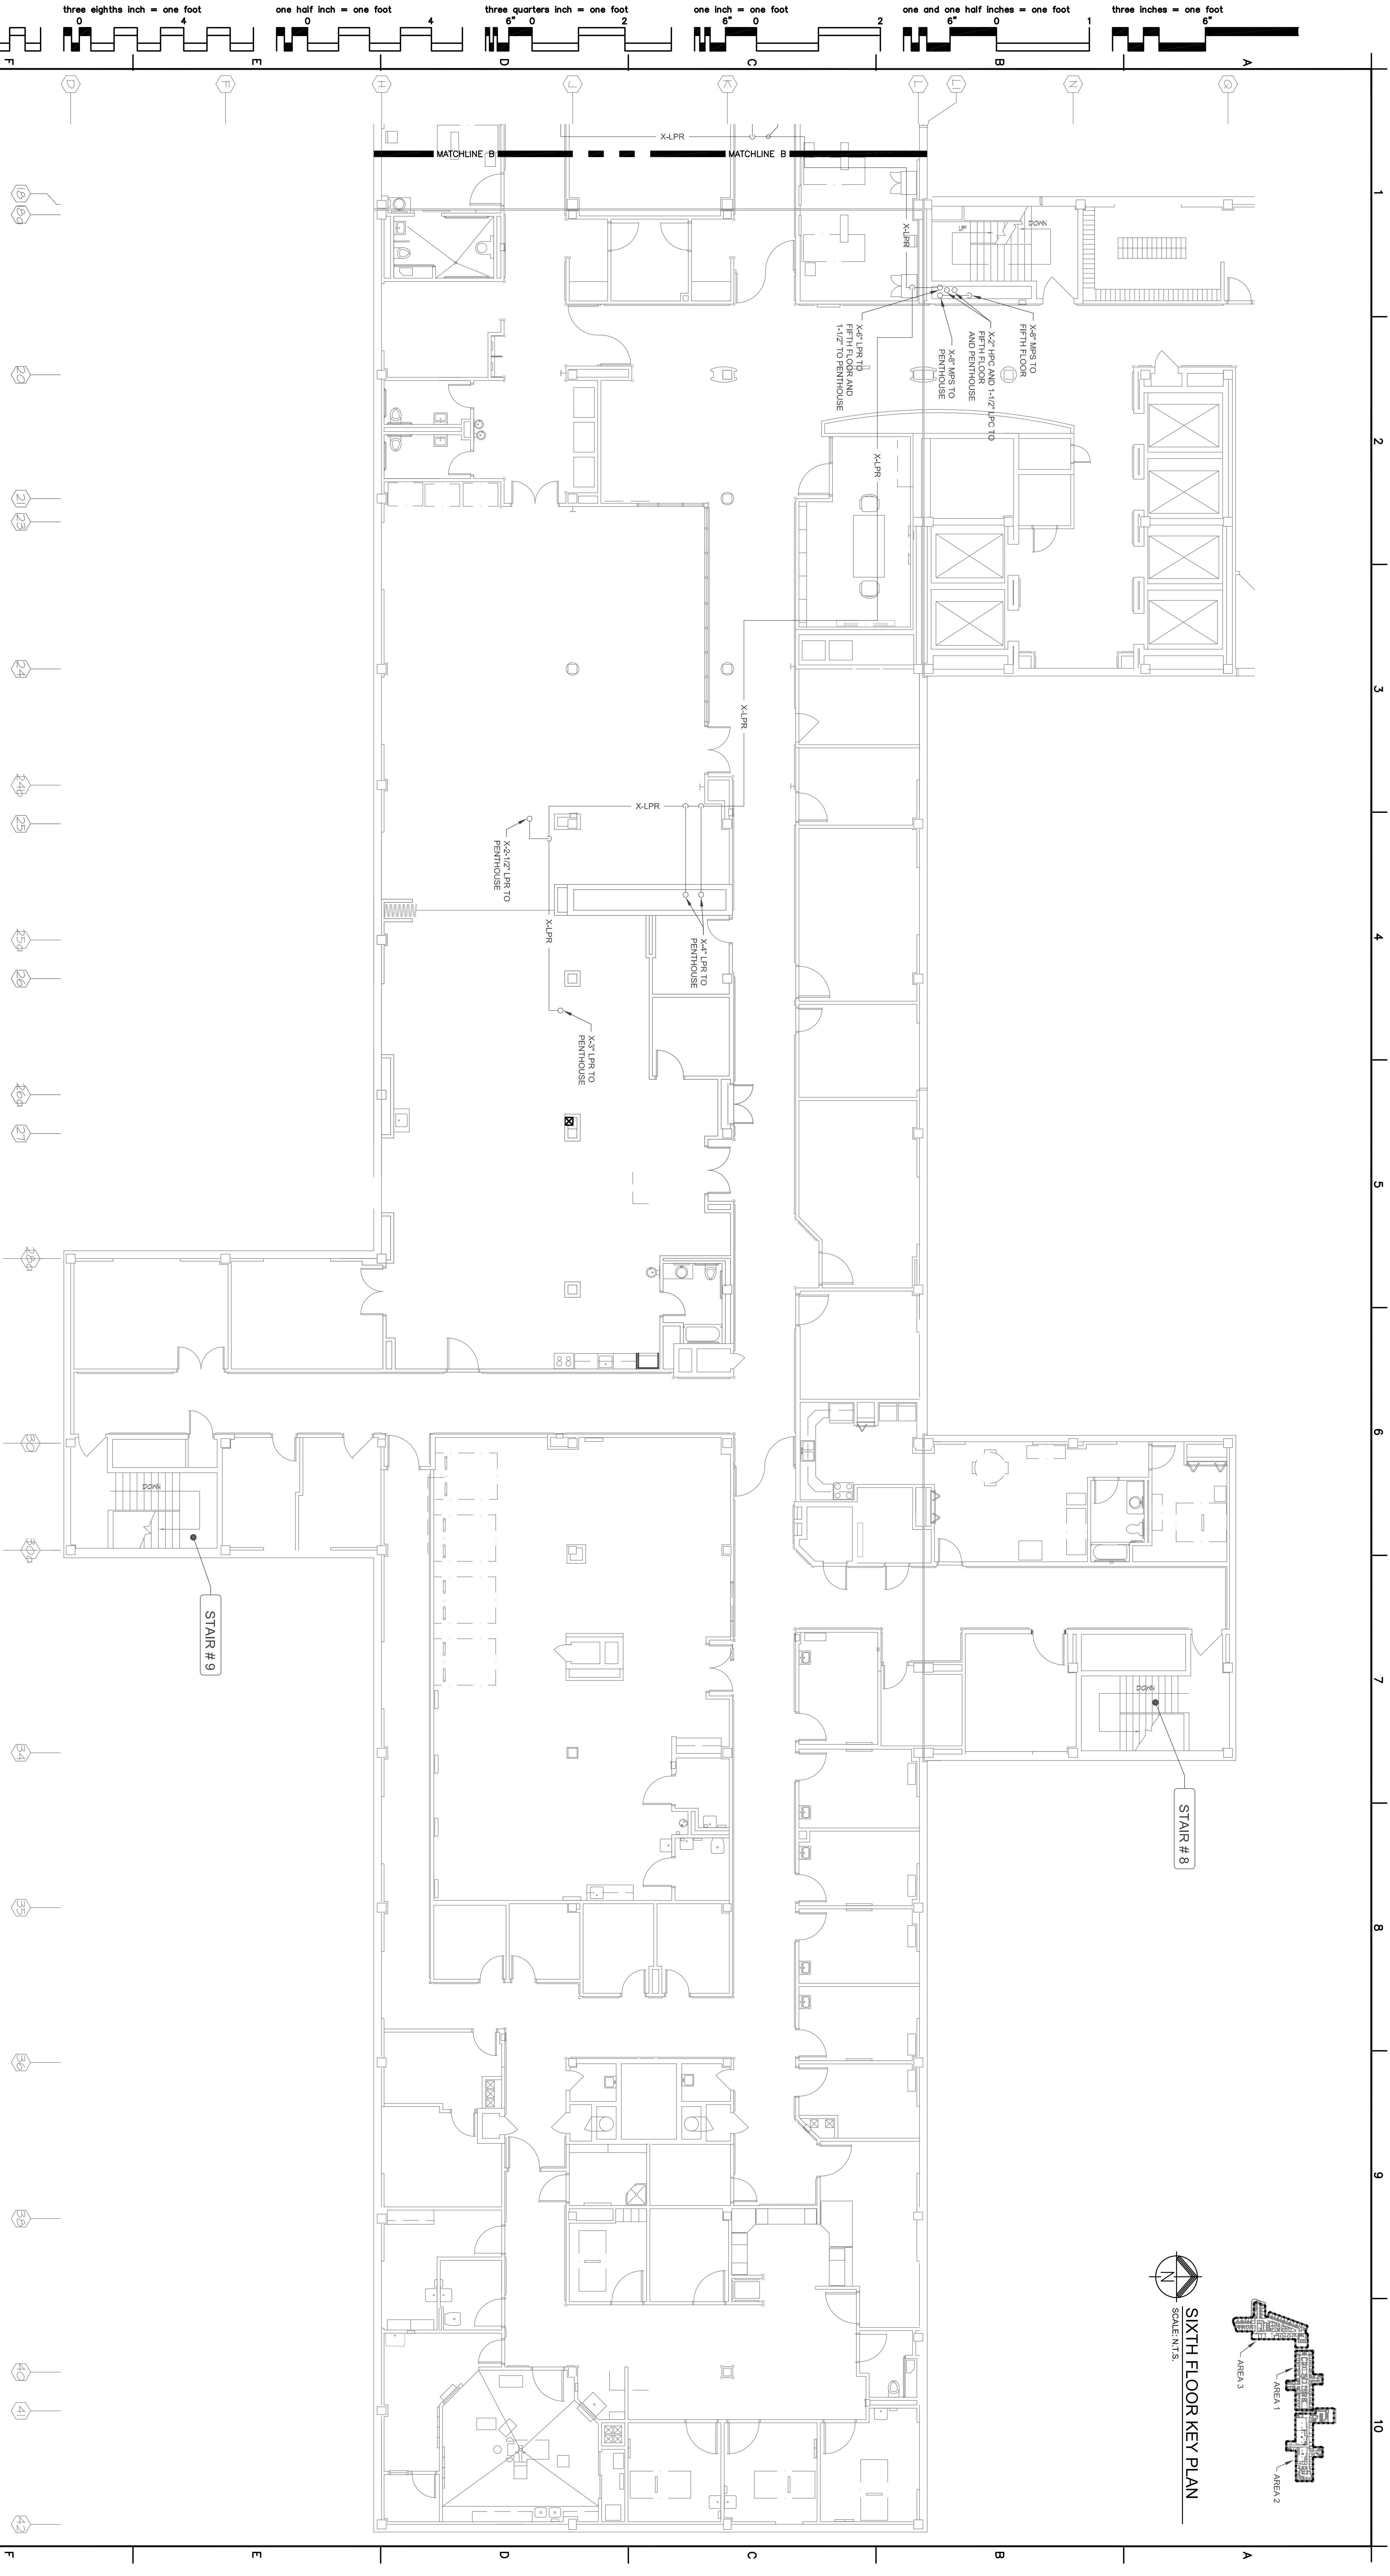

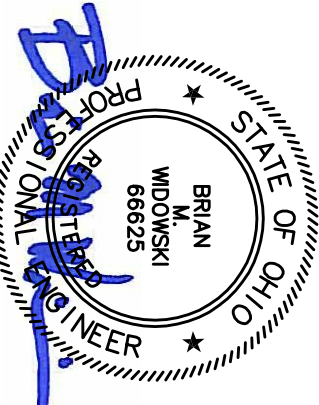







SIXTH FLOOR KEY PLAN  
SCALE: N.T.S.



PARTIAL SIXTH FLOOR - STEAM PIPING - AREA 2  
SCALE: 1/8" = 1'-0"  
0' 4' 8' 16' 32'

<b>CONSULTANTS:</b>		<b>ARCHITECT:</b>																							
<div><b>FREDERICK, ERICKSON &amp; HELLER, INC.</b> 672 EAST ROYALTON ROAD BROADVIEW HTS., OHIO 44147 Tel. (440) 546-3666 Fax. (440) 546-3666</div>		<div></div>																							
<b>Revisions:</b>		<b>Project Title</b> PARTIAL SIXTH FLOOR STEAM PIPING PLAN - AREA 2																							
<table><tr><td>FINAL CD-SUBMISSION</td><td>12-21-12</td></tr><tr><td>95% SUBMISSION</td><td>11-30-12</td></tr><tr><td>65% SUBMISSION</td><td>11-16-12</td></tr></table>		FINAL CD-SUBMISSION	12-21-12	95% SUBMISSION	11-30-12	65% SUBMISSION	11-16-12	<table><tr><td>Approved: Project Director</td><td>Location</td><td>Project Title</td><td>Project Number</td></tr><tr><td><div></div></td><td>VAMC - WADE PARK</td><td>STEAM TRAP MONITORING, INSULATION AND PIPING UPGRADES</td><td>541-12-115</td></tr><tr><td>Date</td><td>Checked</td><td>Drawn</td><td>Building Number</td></tr><tr><td>12-21-12</td><td>WPH</td><td>JMF</td><td>1</td></tr></table>		Approved: Project Director	Location	Project Title	Project Number	<div></div>	VAMC - WADE PARK	STEAM TRAP MONITORING, INSULATION AND PIPING UPGRADES	541-12-115	Date	Checked	Drawn	Building Number	12-21-12	WPH	JMF	1
FINAL CD-SUBMISSION	12-21-12																								
95% SUBMISSION	11-30-12																								
65% SUBMISSION	11-16-12																								
Approved: Project Director	Location	Project Title	Project Number																						
<div></div>	VAMC - WADE PARK	STEAM TRAP MONITORING, INSULATION AND PIPING UPGRADES	541-12-115																						
Date	Checked	Drawn	Building Number																						
12-21-12	WPH	JMF	1																						
<div></div>		<div></div>																							