



SCALE: 1/8" = 1'-0"

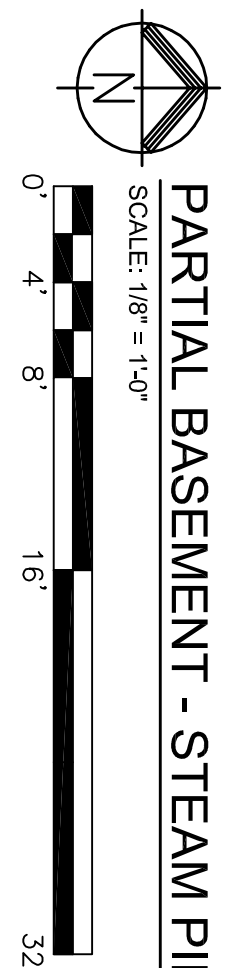

1

CONSULTANTS:

FREDERICK, FREDERICK & HELLER
100 EAST BROADVIEW AVENUE
BROADVIEW HTS., OHIO 44147
Tel. (440) 544-2444
Fax. (440) 544-2444

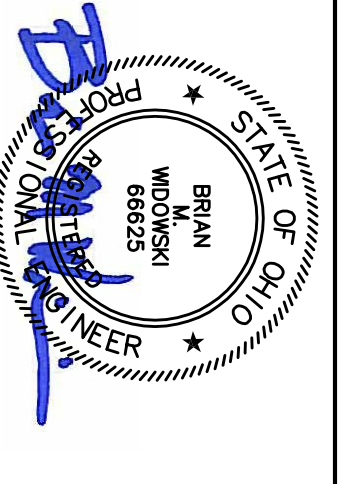

ARCHITECT:

Drawing Title
**BASEMENT FLOOR PLAN
AREA 1**

Project Title
**STEAM TRAP MONITORING,
INSULATION AND PIPING
UPGRADES**

Project Number
541-12-115

Office of
Facilities
Management

Approved: Project Director

Location
VAMC - WADE PARK

Drawing Number
1

Date
12-21-12

WFW

JMF

3-B-1



one eighth inch = one foot

one quarter inch = one foot

three eighths inch = one foot

one half inch = one foot

three quarters inch = one foot

one inch = one foot

one and one half inches = one foot

three inches = one foot

0 4 8 16

0 4 8

0 4 8

0 4

0 2

0 2

0 1

0 6"

1 2 3 4 5 6 7 8 9 10

1 2 3 4 5 6 7 8 9 10

1 2 3 4 5 6 7 8 9 10

1 2 3 4 5 6 7 8 9 10

1 2 3 4 5 6 7 8 9 10

1 2 3 4 5 6 7 8 9 10

1 2 3 4 5 6 7 8 9 10

1 2 3 4 5 6 7 8 9 10

Revisions:	Date
FINAL CD-SUBMISSION	12-21-12
95% SUBMISSION	11-30-12
65% SUBMISSION	11-16-12

VA FORM 08-6231, OCT 1978