



KEY NOTES

1. PROVIDE NEW SEISMIC BRACING ON TRUSSES PLUMB SECTION ON SHEET TH-100. THIS SHALL BE PART OF PHASE 3 WORK.

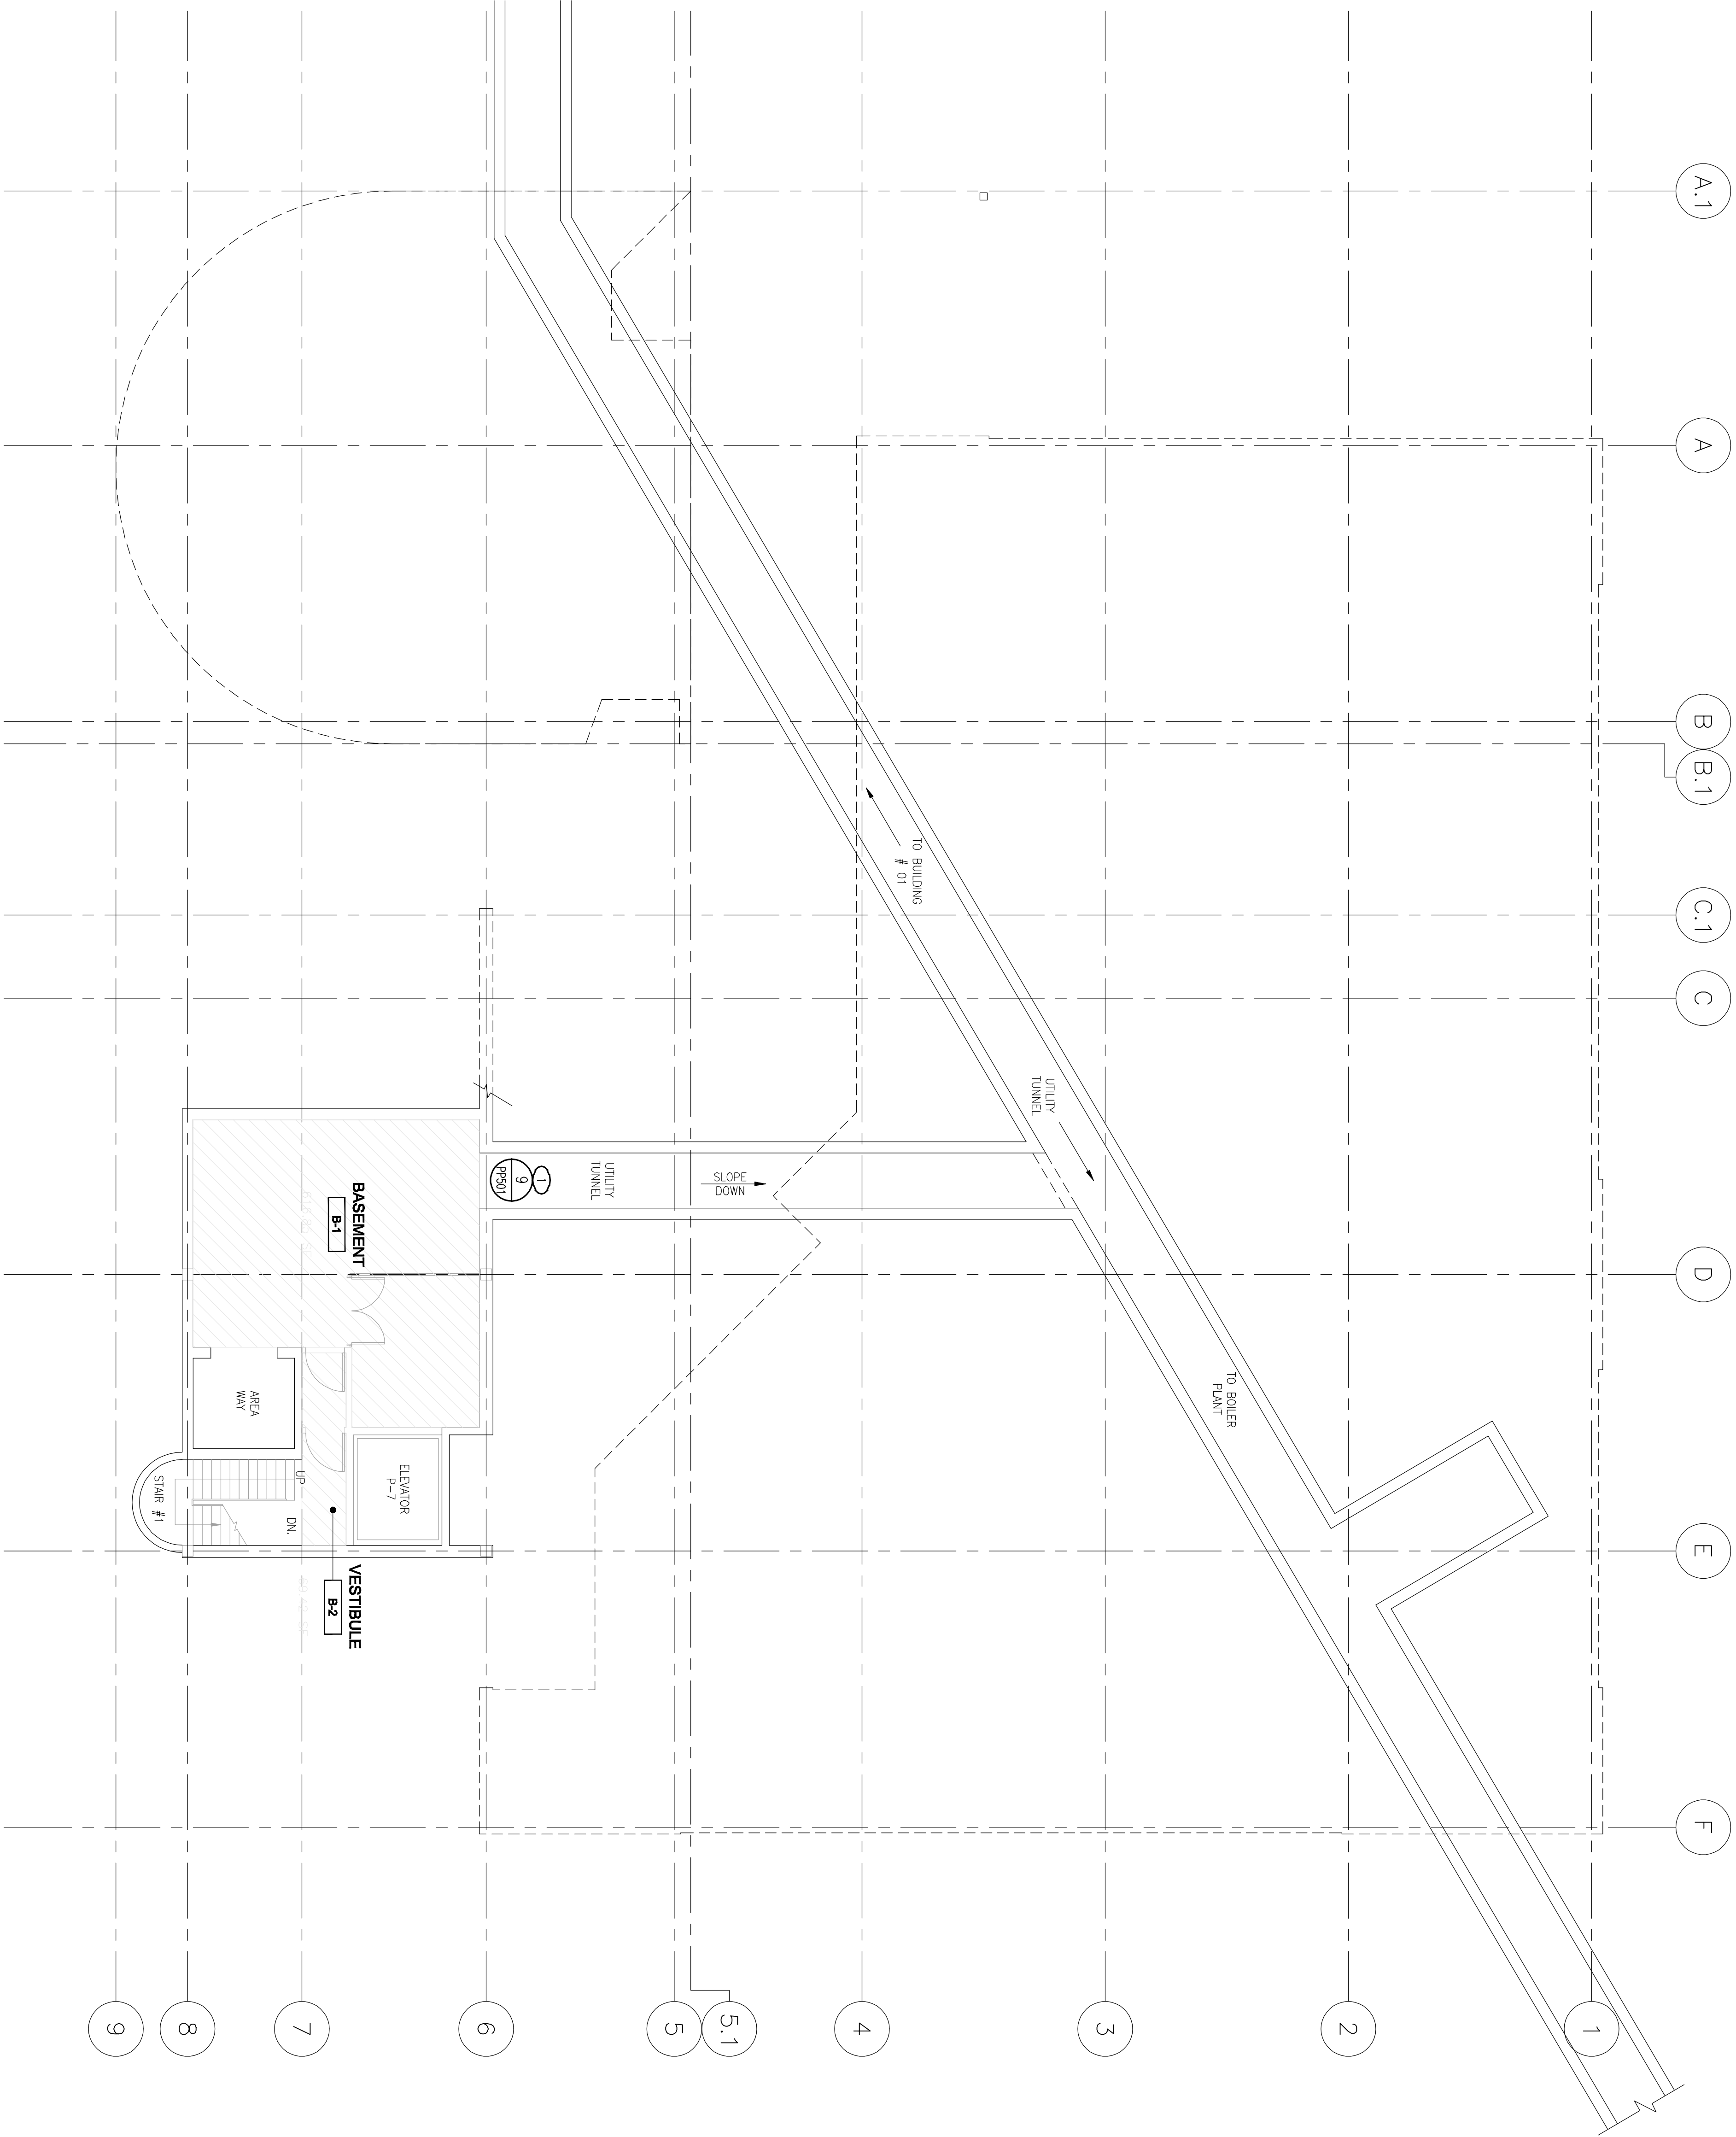

1 BASEMENT PLUMBING REMODEL FLOOR PLAN

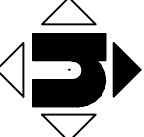

SCALE: 1/8" = 1'-0"

CONSULTANTS:

LP Consulting Engineers, Inc.
685 W. Jackson Ave., Suite 101, Chula, CA 92012
P: 619.426.1511
www.lpengineers.com
John R. 10-1089



ARCHITECT/ENGINEERS:

HMC Architects
1827 E. Palmdale, Suite 103, Palmdale, CA 93550
T: 805.322.2444 / www.hmcarchitects.com



Drawing Title
**BASEMENT PLUMBING
REMODEL FLOOR PLAN**

Approved Project Director

Project Title
**BUILDING 24
SEISMIC CORRECTION
AND ADDITION**

Location
VAMC FRESNO, CA

Date
March 12, 2013

Checked
KK

Drawn
DN

Project Number
570-215

Building Number
24

Drawing Number
PP100
Dwg. 110 of 180

Office of
**Construction
and Facilities
Management**

