



1 BLDG 7 DEMOLITION PLAN
SCALE: 1/4" = 1'-0"

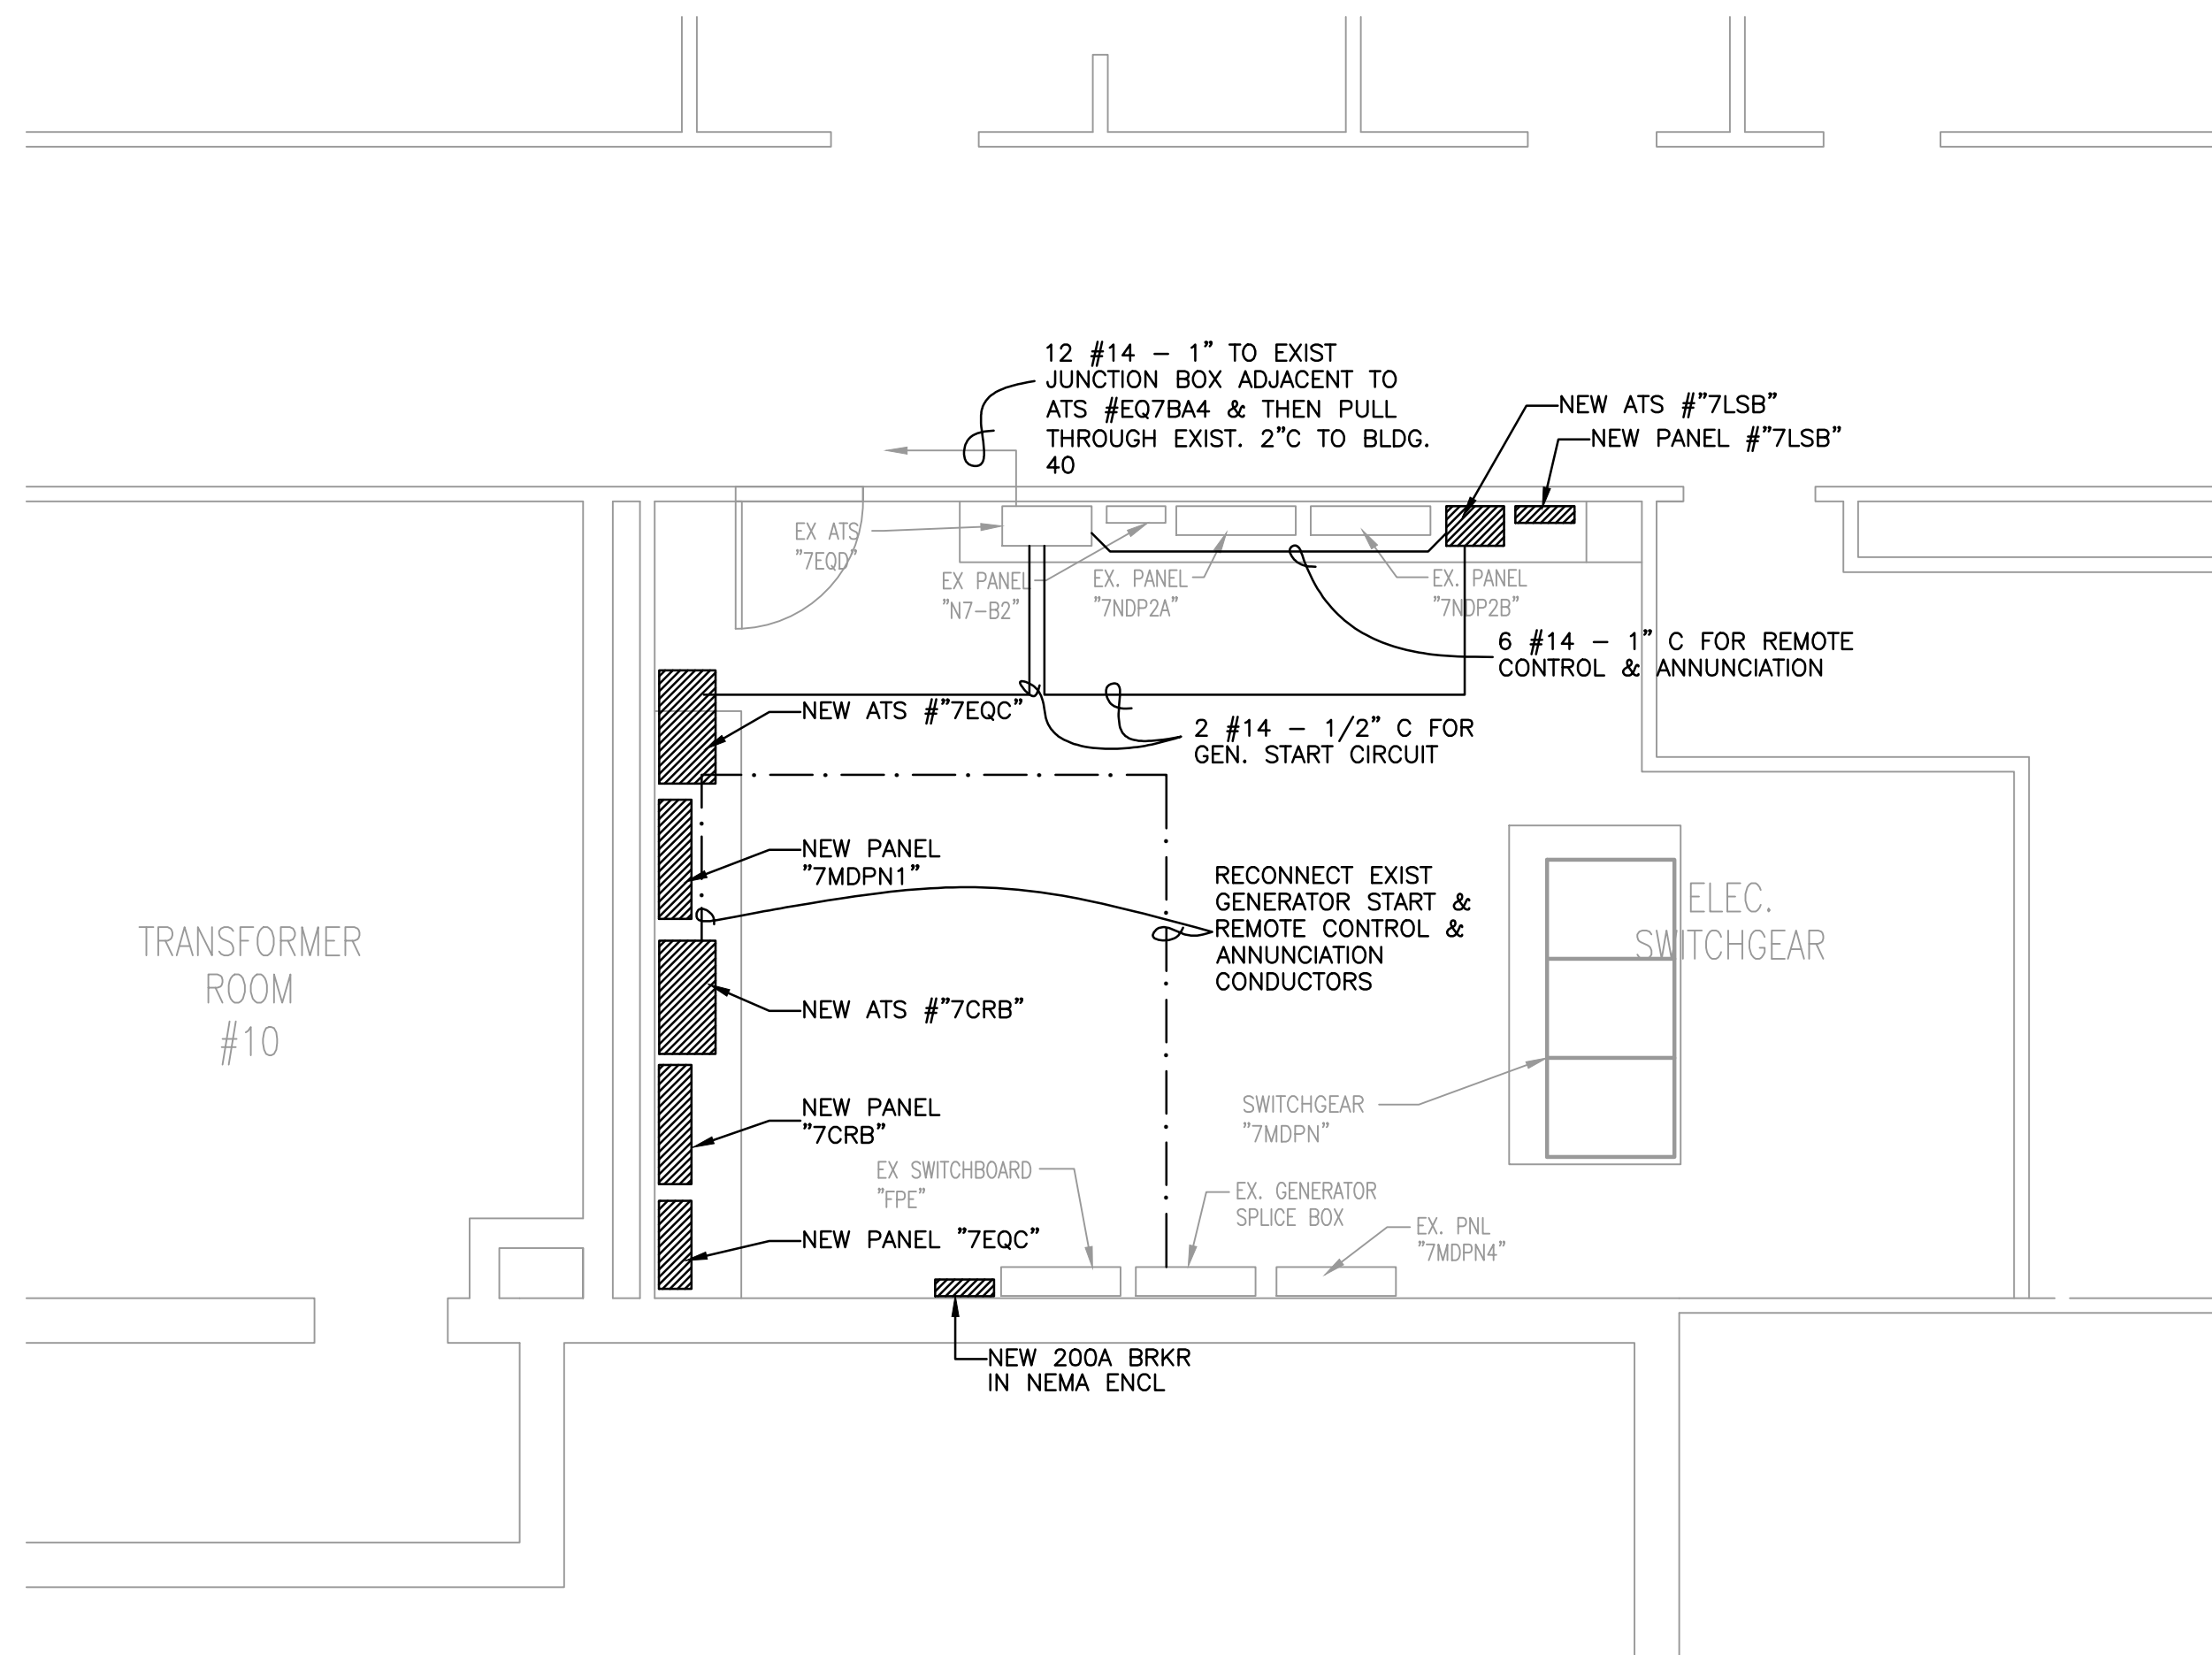


2 BLDG 7 ELECTRICAL PLAN
SCALE: 1/4" = 1'-0"

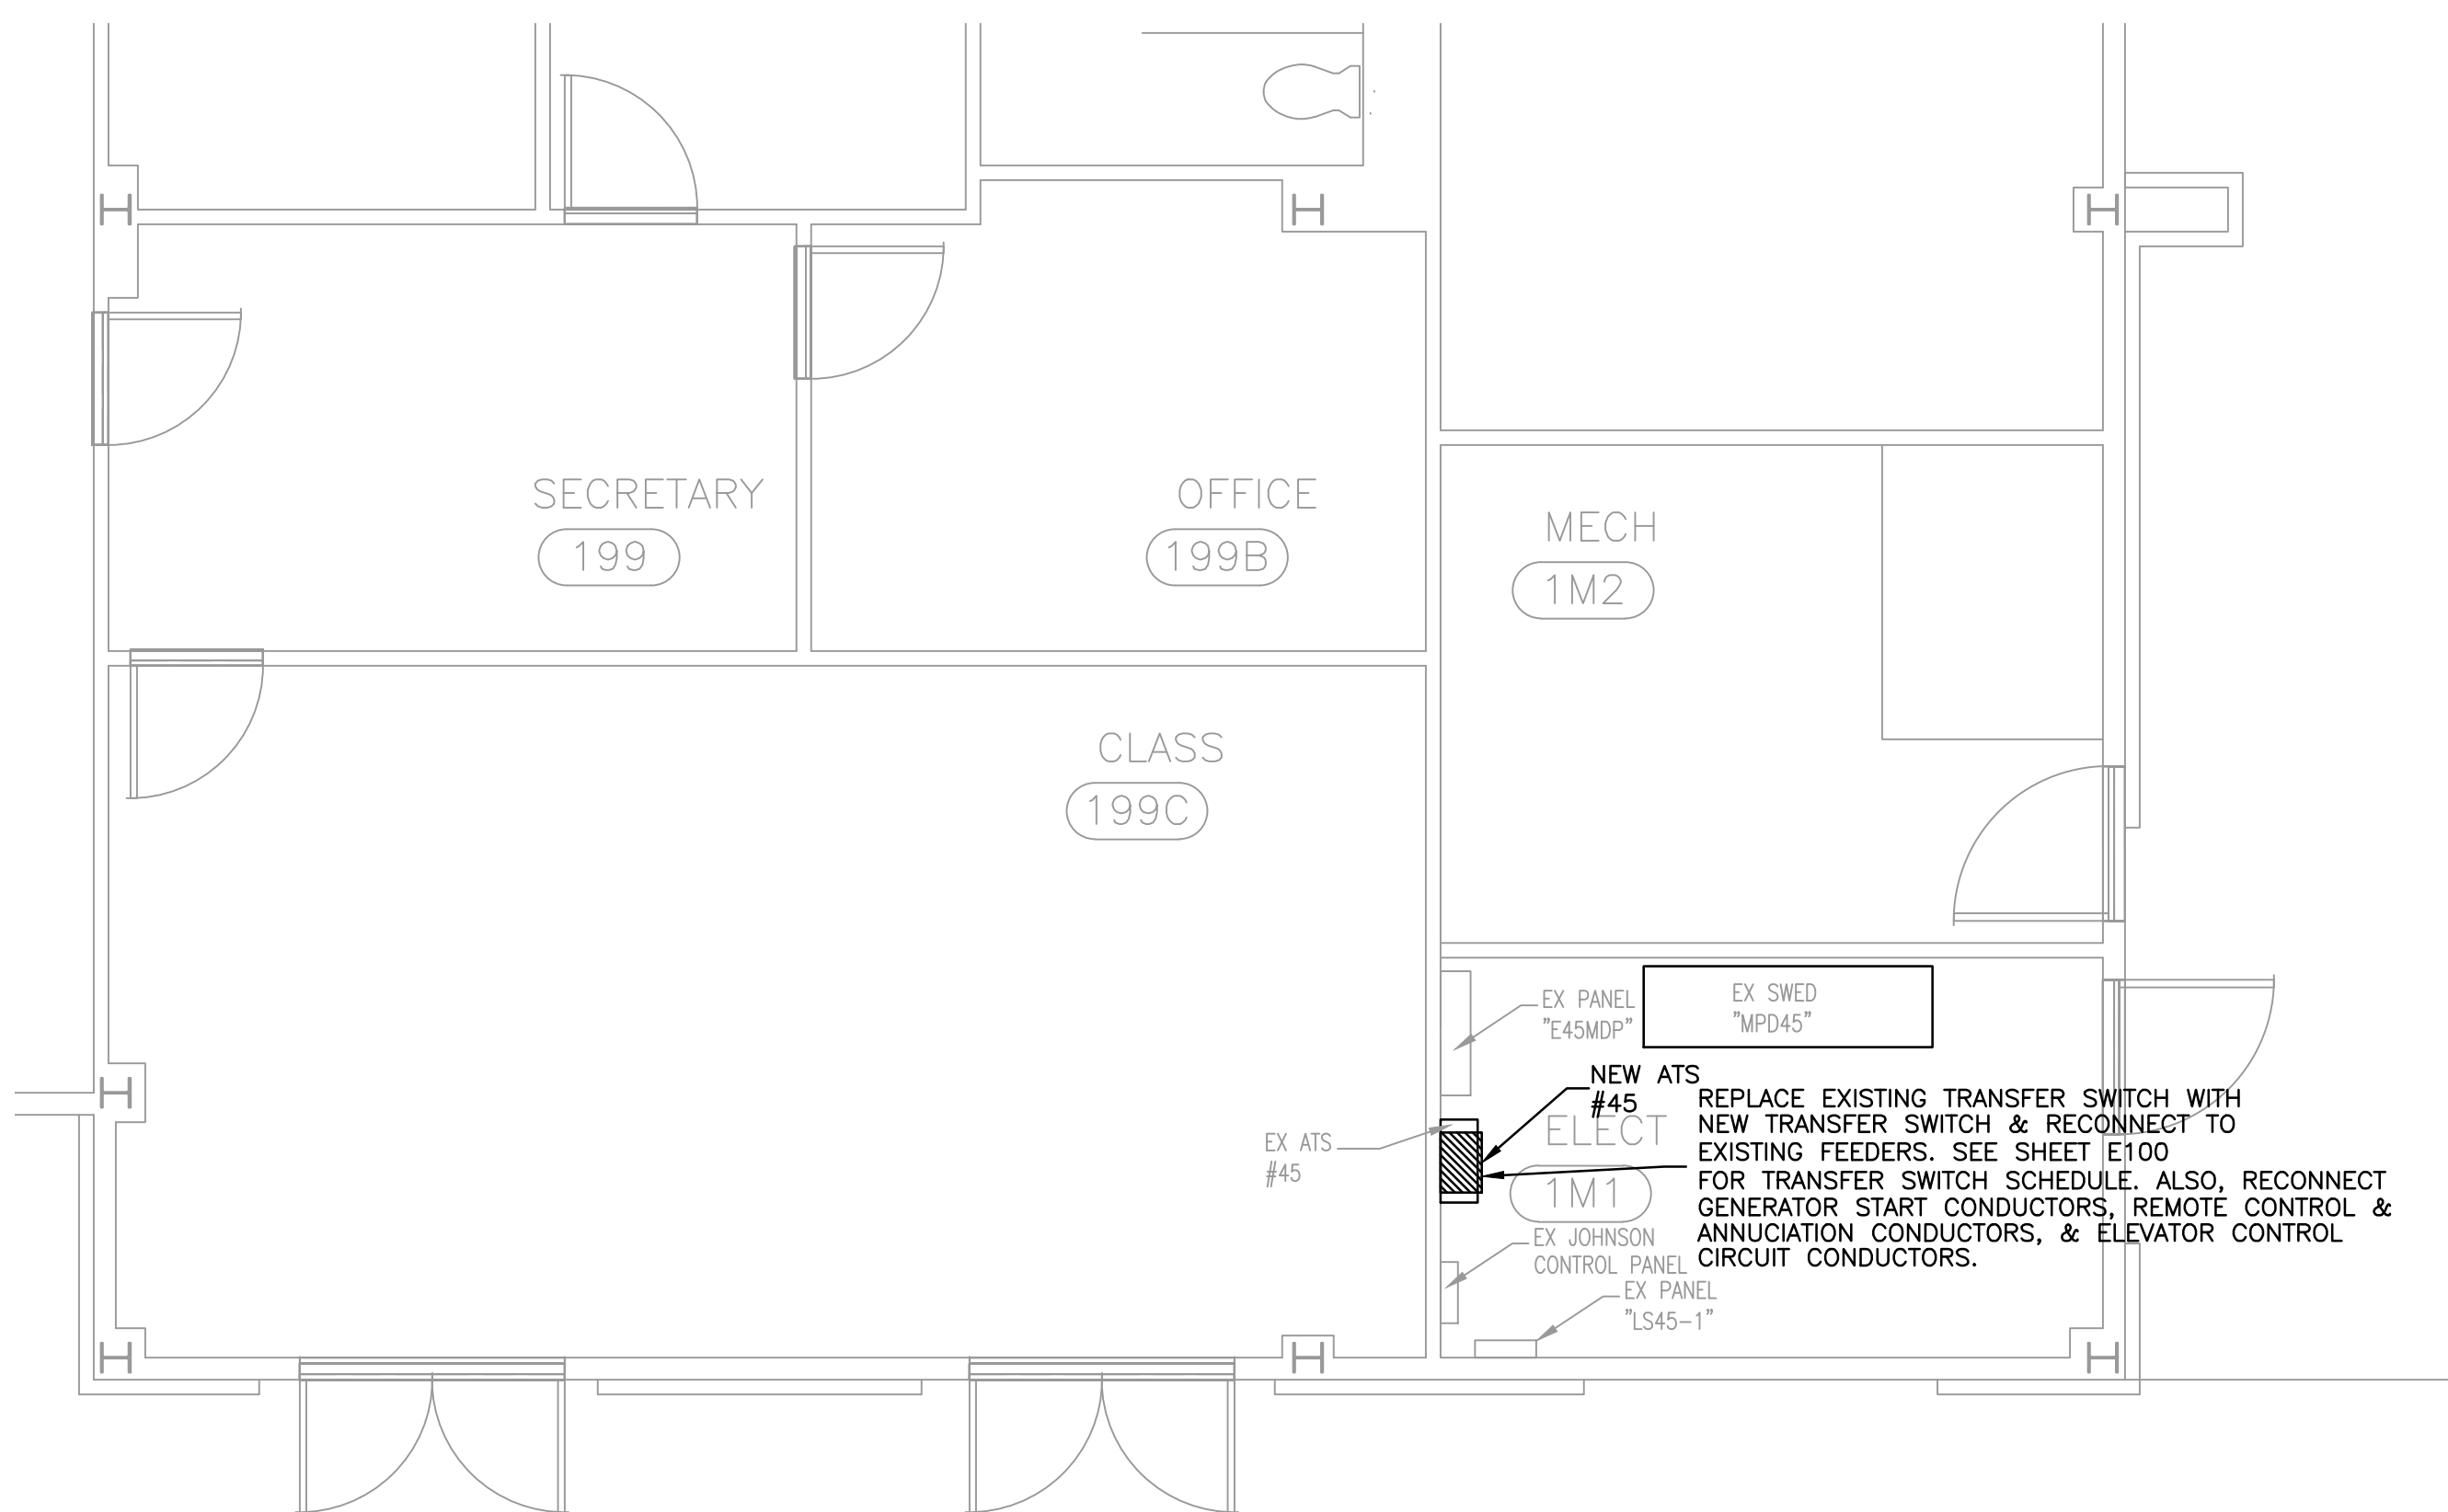


3 BLDG 45 ELECTRICAL PLAN
SCALE: 1/4" = 1'-0"

ATS TEST STATION NOTES

- REPLACE EXISTING PHENOLIC LABEL SHOWN WITH NEW LABEL INDICATING:
ATS 7EQC
AUTO TEST
- REPLACE EXISTING PHENOLIC LABEL SHOWN WITH NEW LABEL INDICATING:
ATS 7CRB
AUTO TEST
- PROVIDE NEW TEST STATION IN NEMA 4 STAINLESS STEEL ENCLOSURE WITH BACKPLATE AND TERMINAL STRIP FOR FIELD WIRING.
- PHENOLIC NAMEPLATE, BLACK WITH WHITE CENTER CORE, AND LABELED AS INDICATED. ATTACH NAMEPLATE WITH SCREWS OR RIVETS.
- TWO POSITION SELECTOR SWITCH
- LED INDICATOR LIGHT; "G" INDICATES GREEN COLOR, "R" INDICATES RED COLOR.

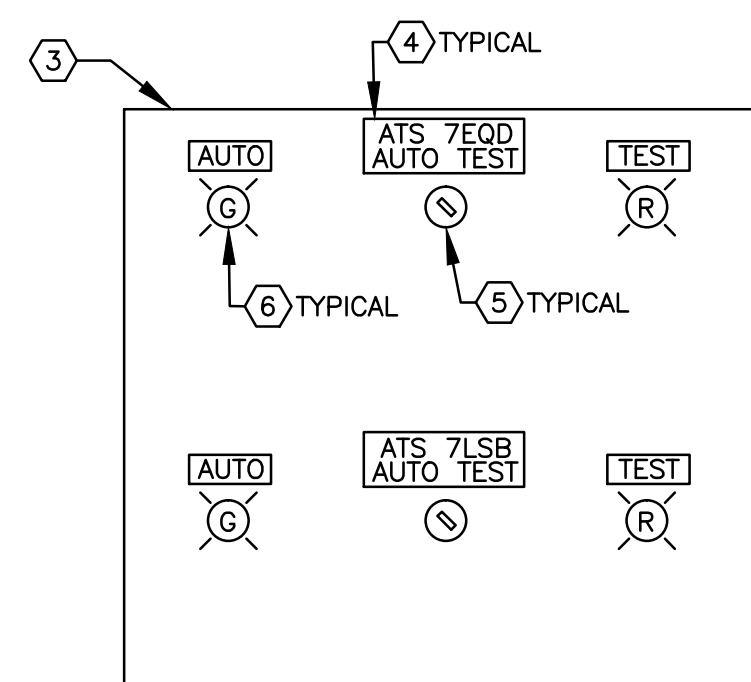

NEW ATS TEST STATION

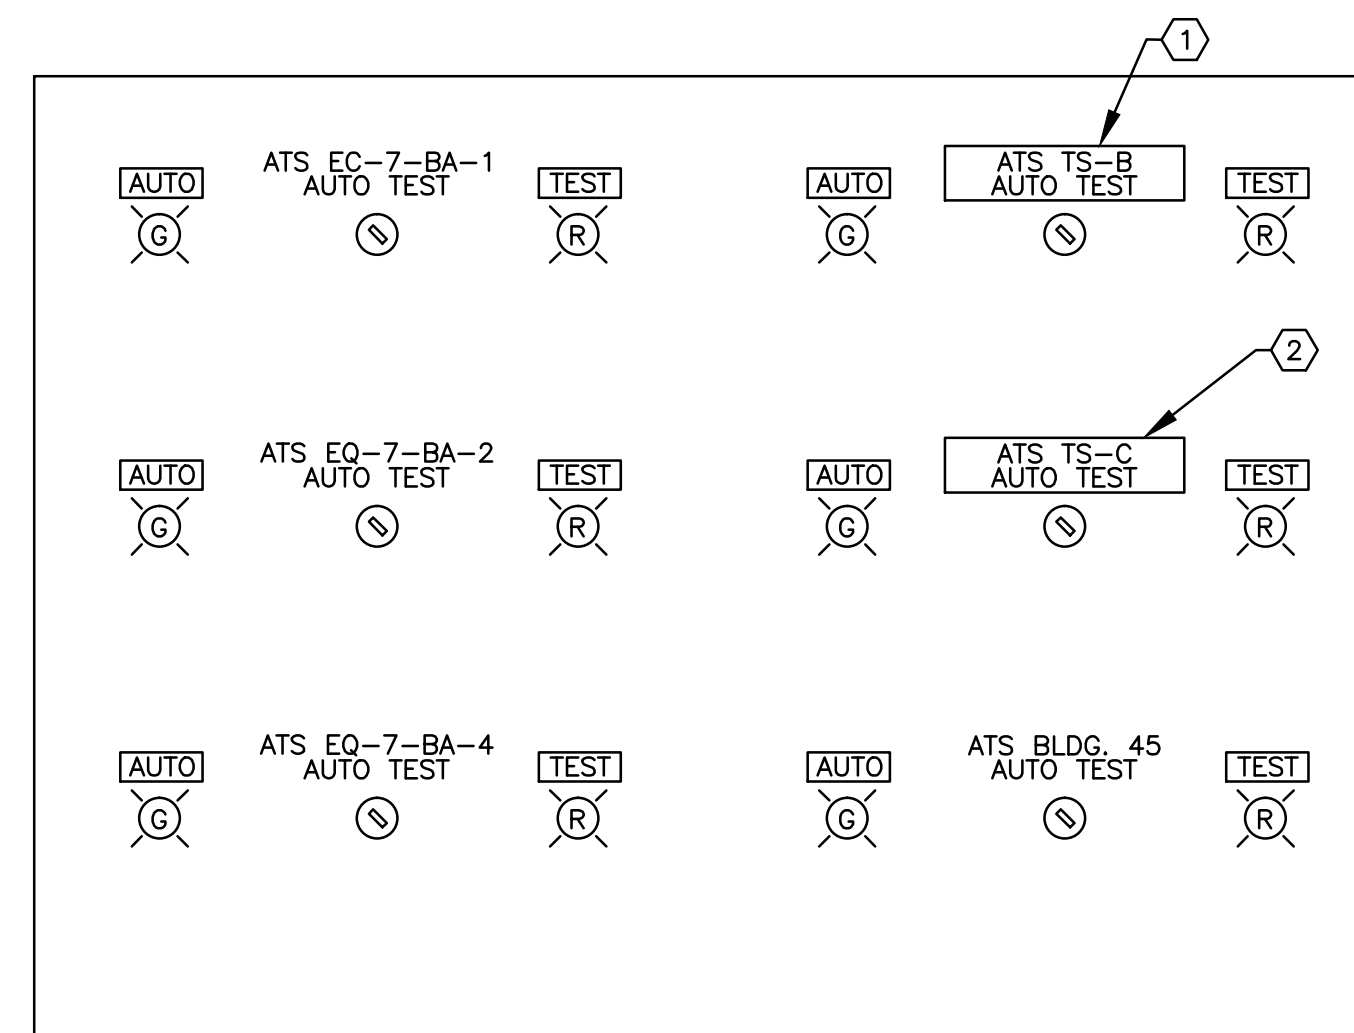

EXISTING ATS TEST STATION

4 ATS TEST STATION - BUILDING 40
SCALE: N.T.S.

Revisions:	Date

CONSULTANTS:

E E Consultants, Inc.
PROFESSIONAL ELECTRICAL ENGINEERS
301 Jackson St. Suite 204
Alexandria, LA 71301
PH: (318) 445-8870
FAX: (318) 445-5350

Professional Seal:

STATE OF LOUISIANA
RAYMOND J. DANN, JR.
REG. NO. 13962
PROFESSIONAL ELECTRICAL ENGINEER
7-73-72

ARCHITECT/ENGINEERS:

12021-CAL

BH&B
Barron Heinberg & Brocato
Architecture, Engineering
Planning, Interior Design
1015 Wisteria Street
Alexandria, Louisiana 71301
Tel: 318-443-7291 Fax: 318-487-0678

Drawing Title

BUILDING 7 & 45 PARTIAL PLANS

Approved: Project Director

Project Title

A&E DESIGN REPLACEMENT OF
TRANSFER SWITCH
FINAL SUBMITTAL

Location

VAMC; ALEXANDRIA, LA.

Date

JULY 13, 2012

Checked

RJD

Drawn

EEC

Project Number

502-11-111

Building Number

7 & 45

Drawing Number

E103
Dwg. 5 of 7

Office of
Facilities
Management

Department of
Veterans Affairs