



FOURTH FLOOR PLAN  
NO SCALE

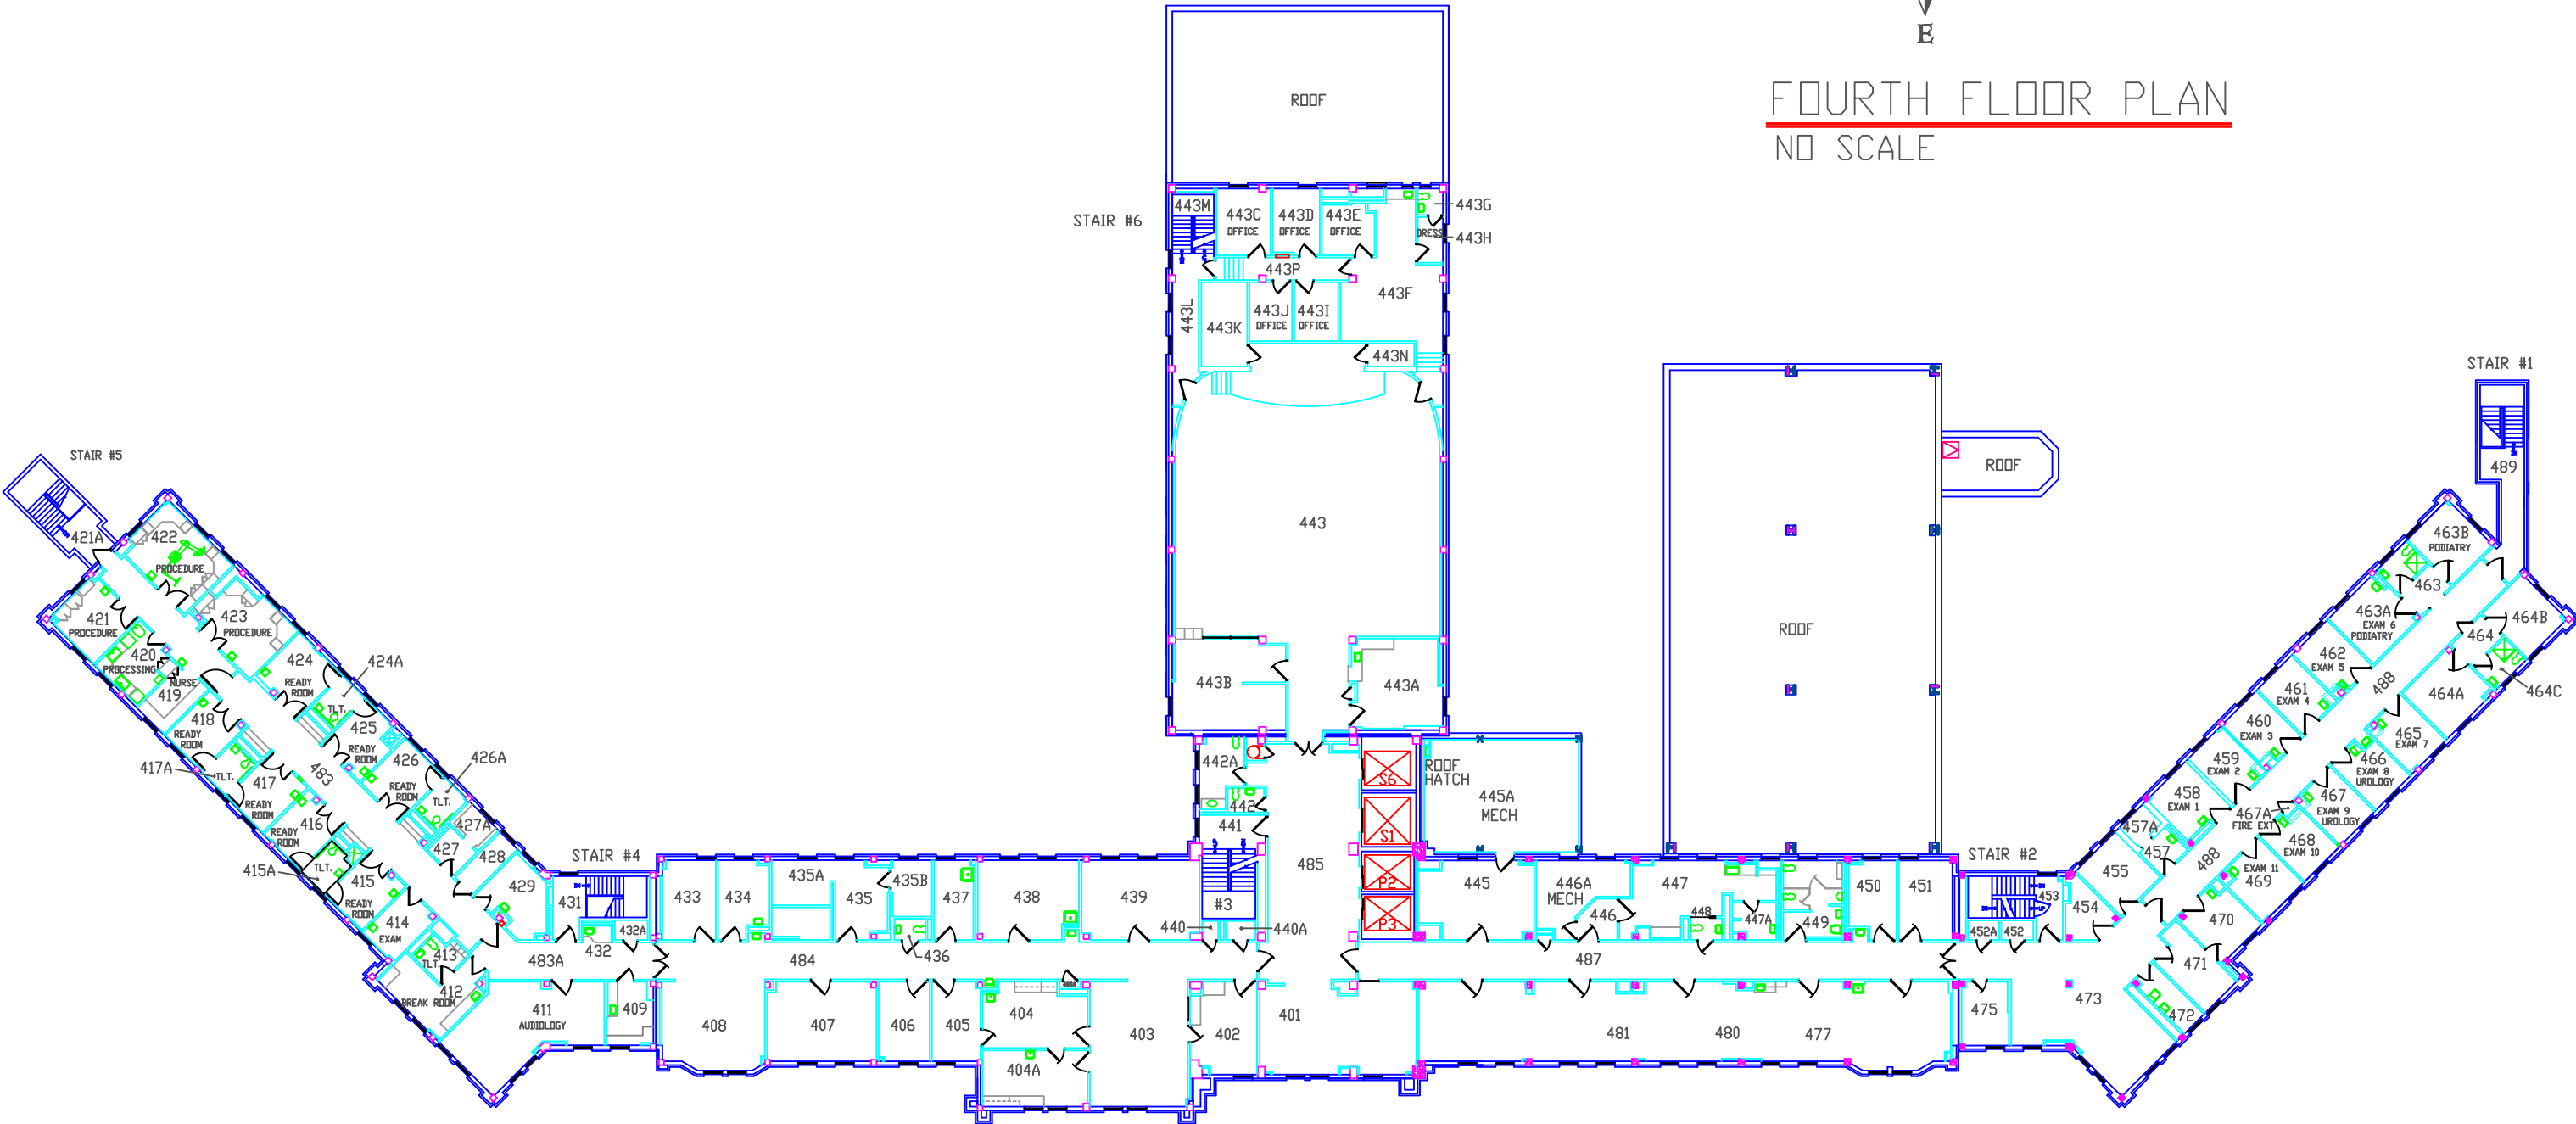

Revisions	Date	Drawing Title	Project Title	Date	
		Approved: Division Chief	Building Number	Checked	Drawn
		Approved: Service Director	Location VAMC SIOUX FALLS, SOUTH DAKOTA		Drawing No.
		Dep. of			

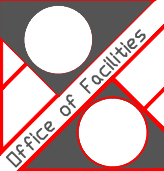

Office of Facilities

Department of Veterans Affairs