
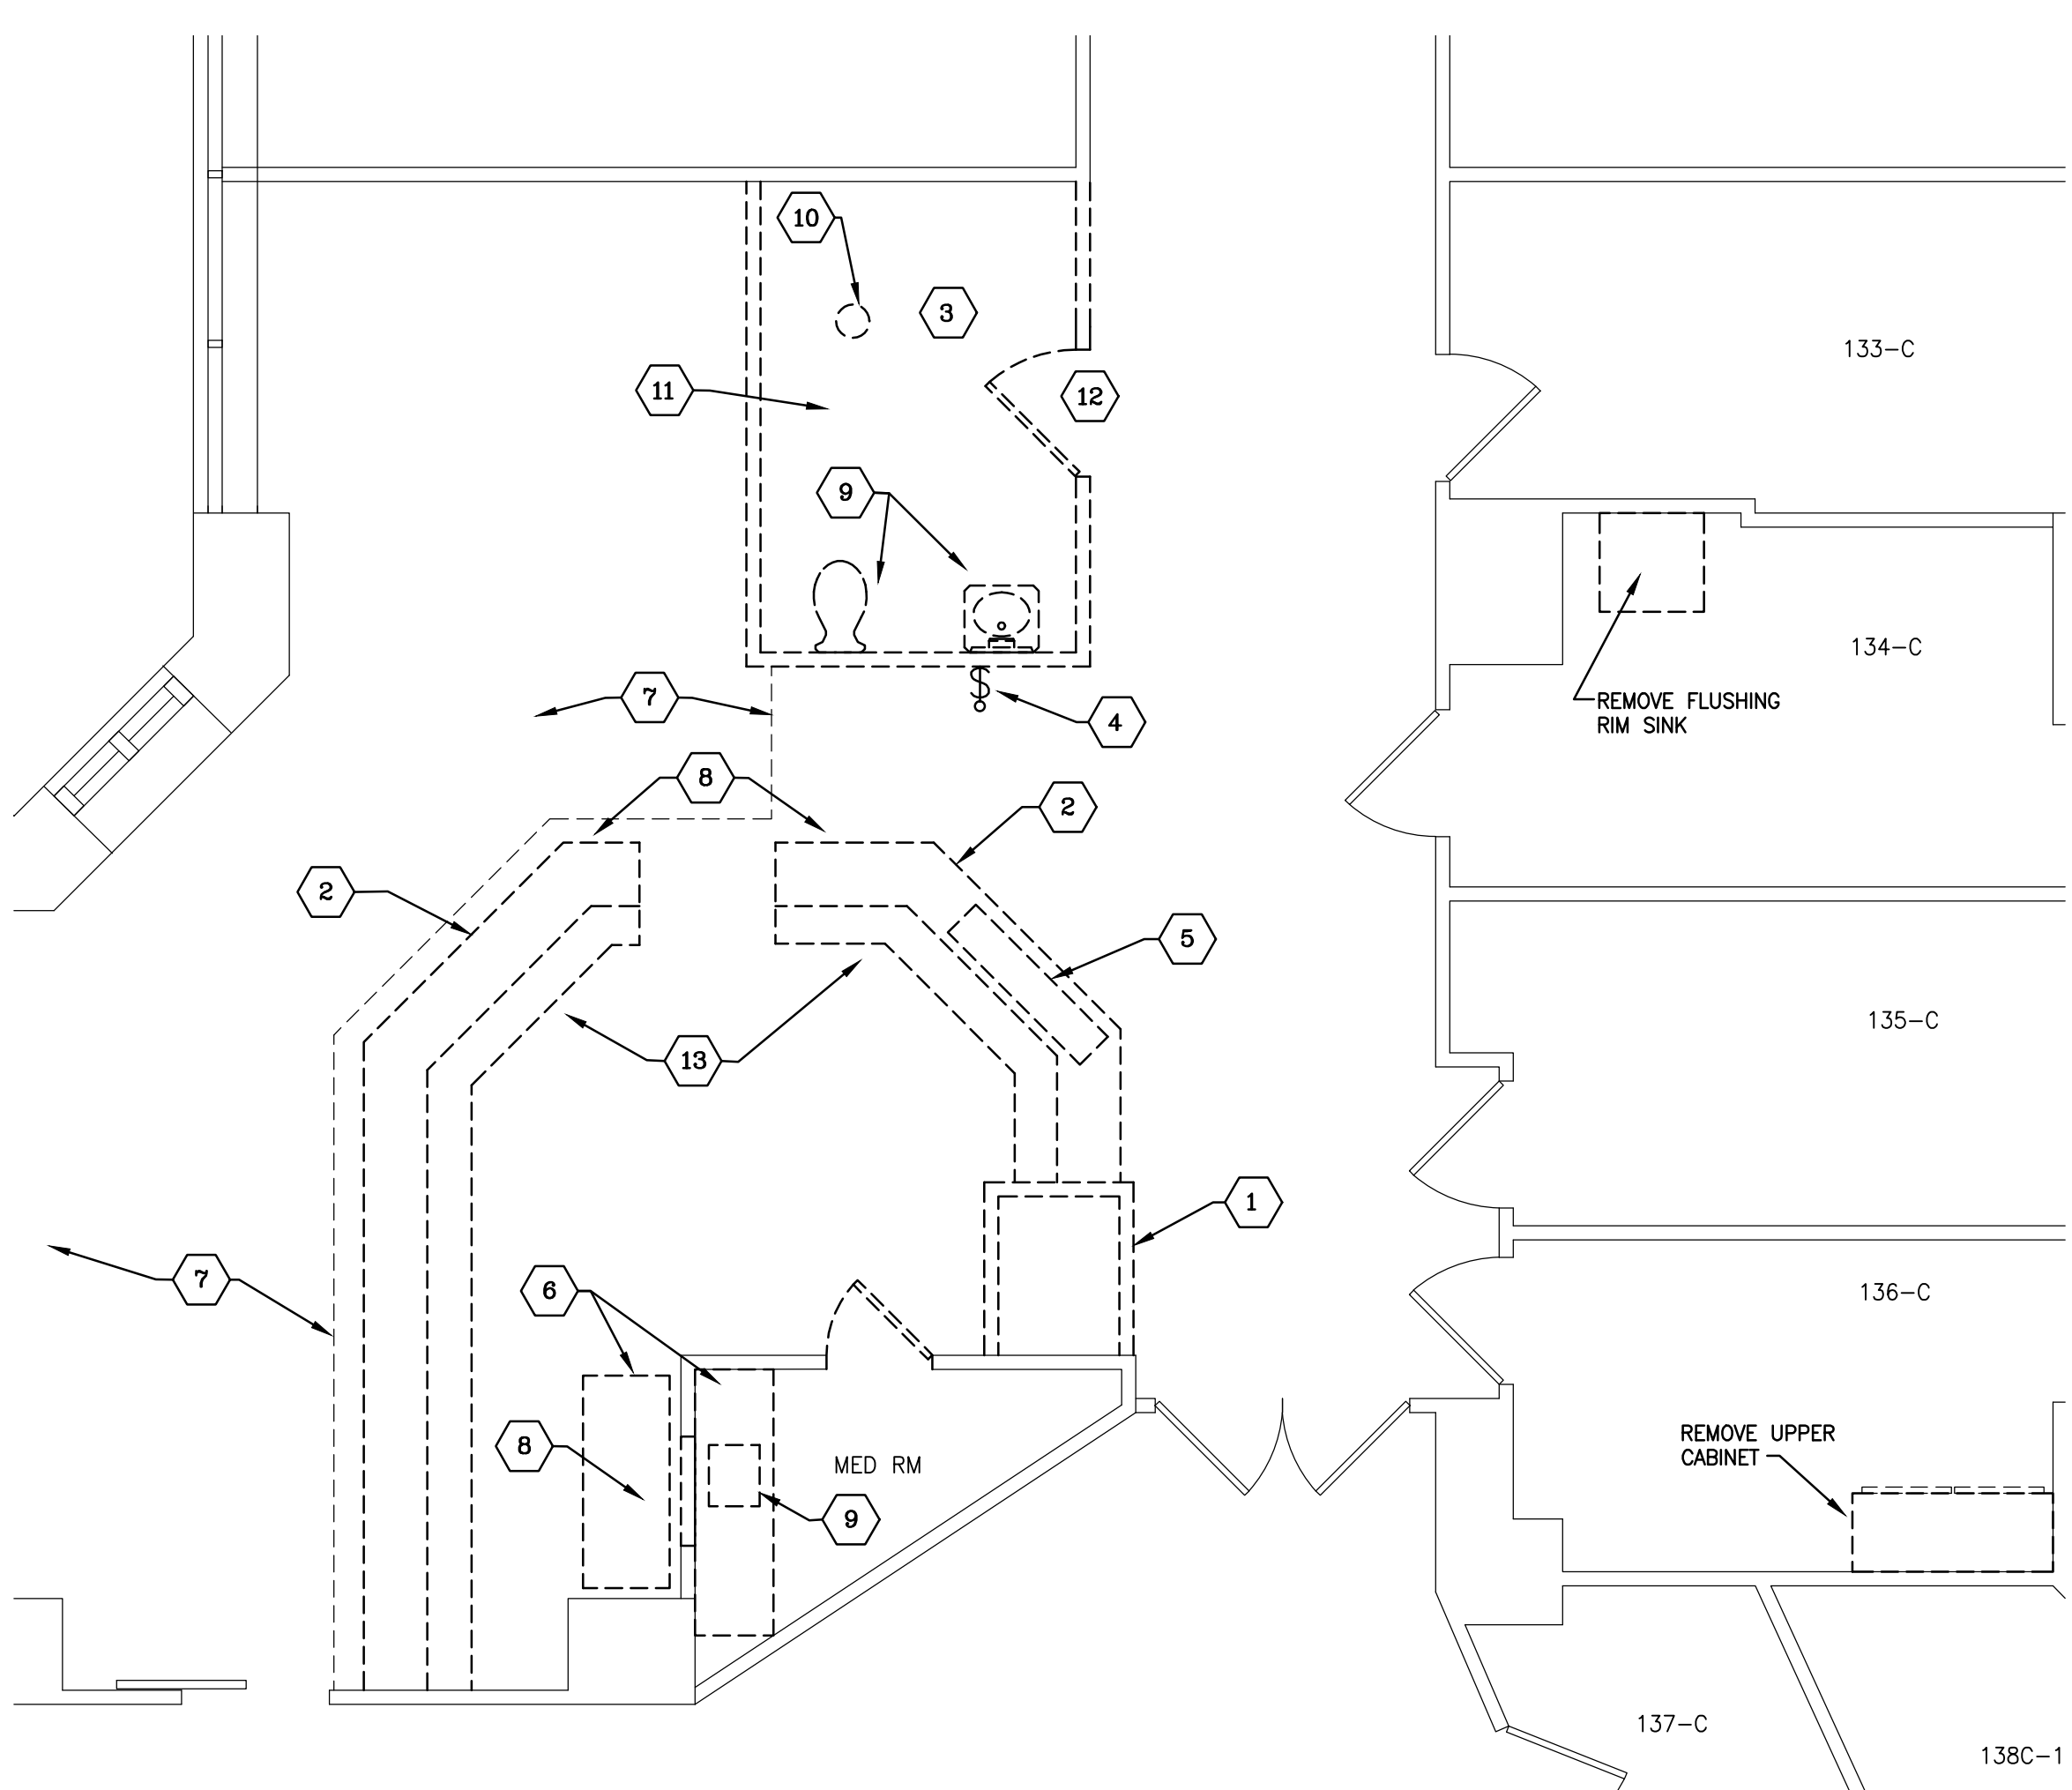
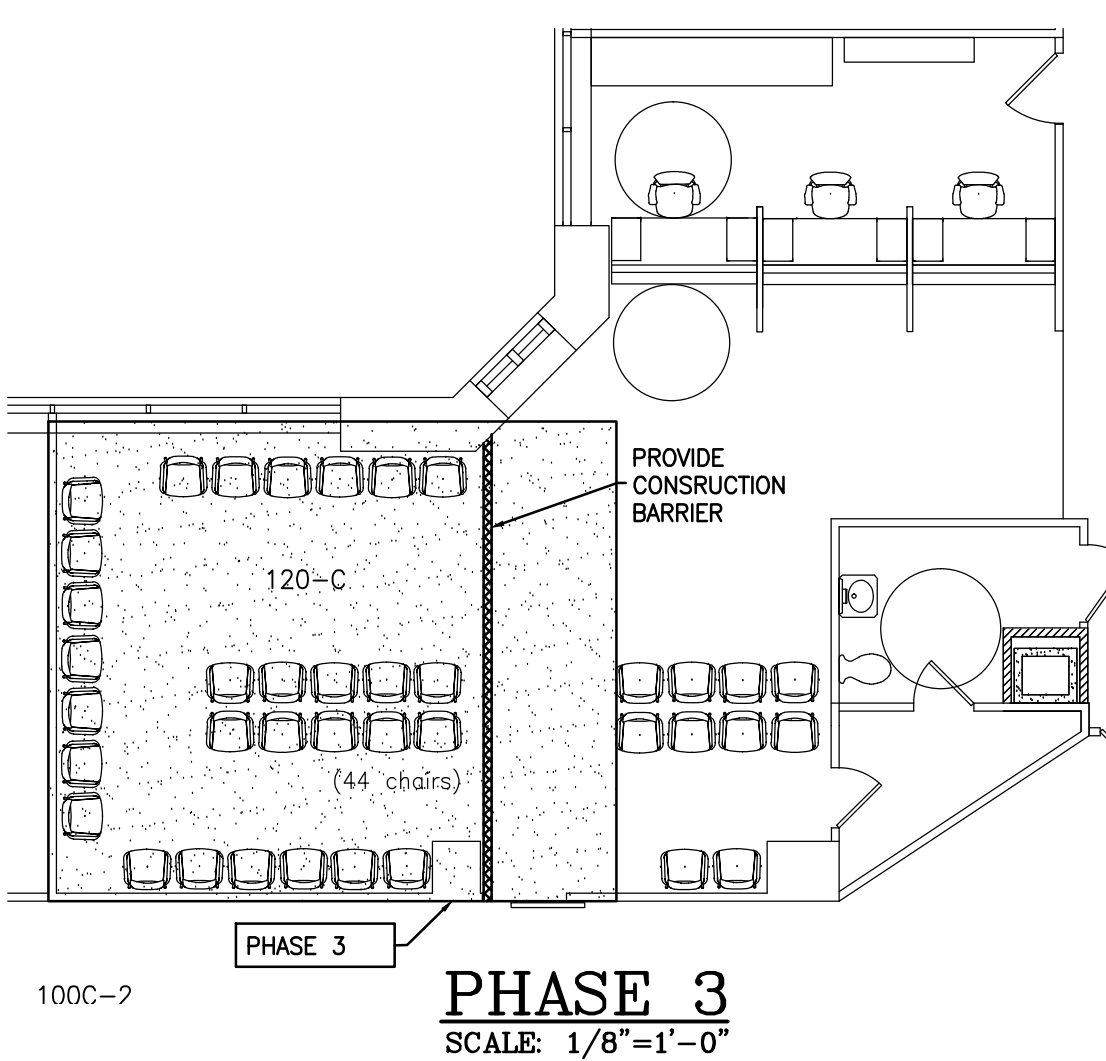
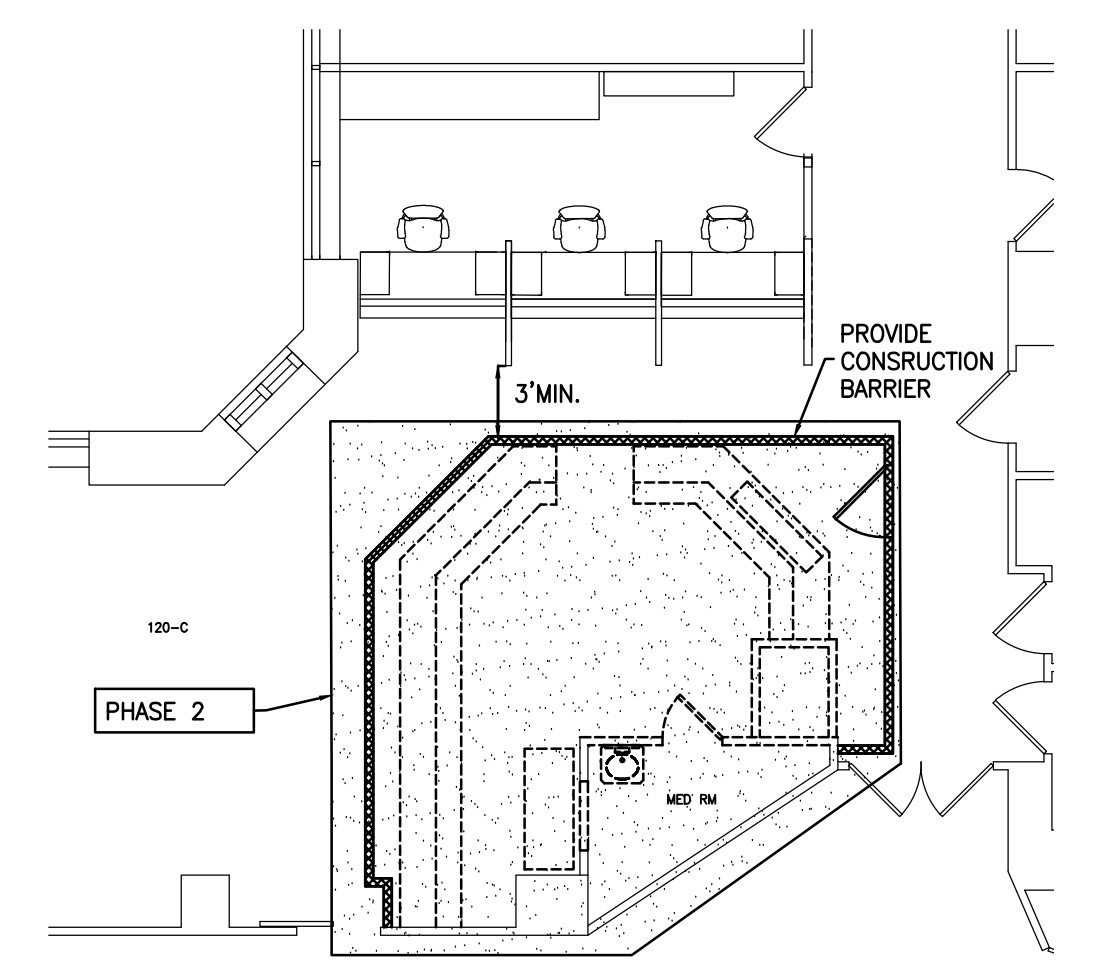


one inch = one foot  
three-quarters inch = one foot  
one-half inch = one foot  
three-eighths inch = one foot  
one-quarter inch = one foot  
one-eighth inch = one foot

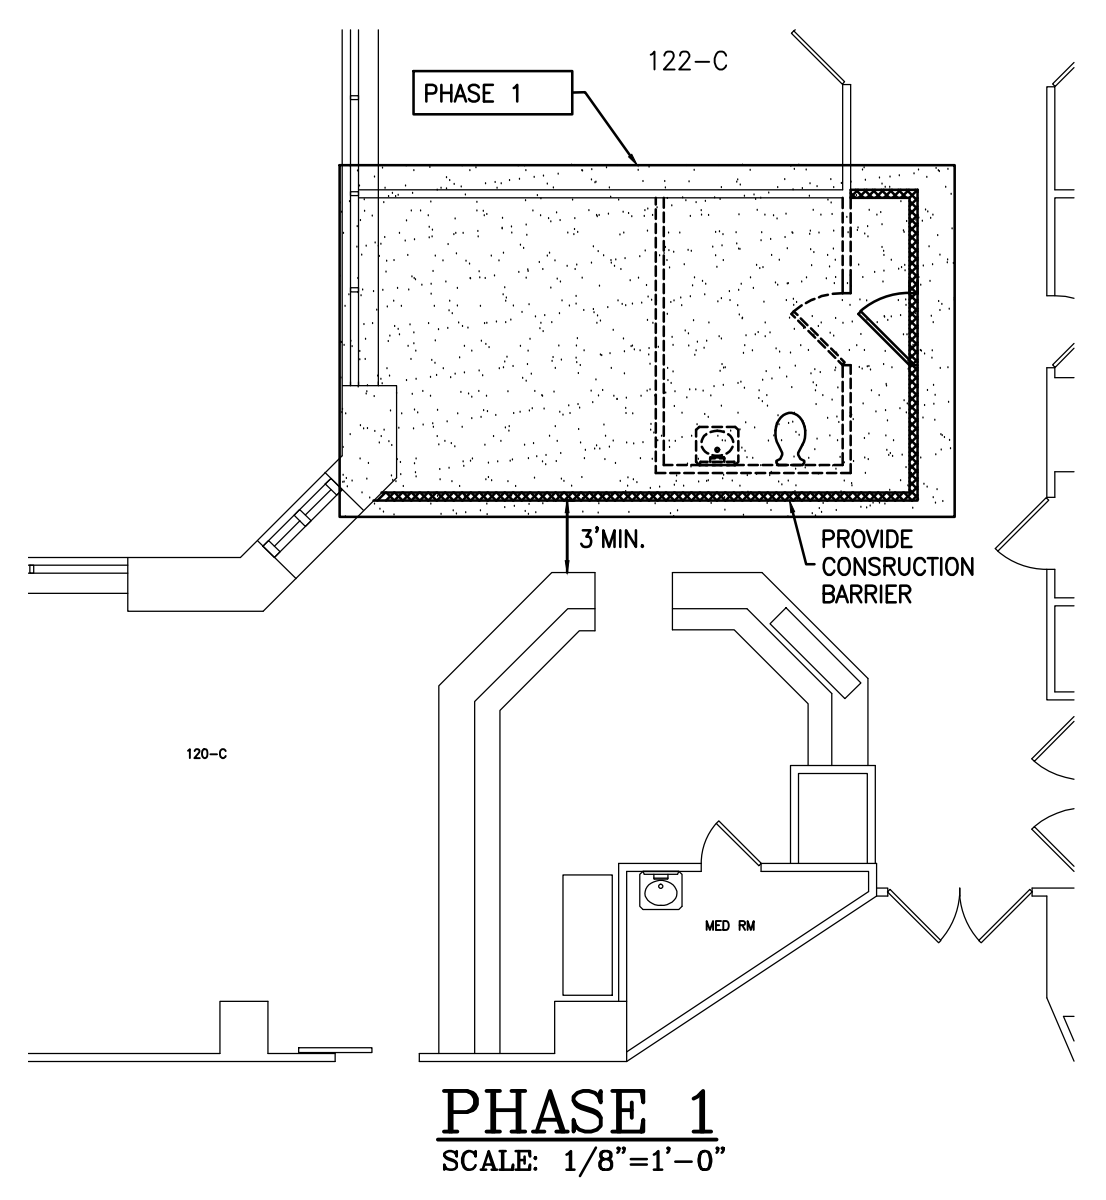


### DEMOLITION NOTES

1. REMOVE WALLS AROUND COLUMN.
2. REMOVE COUNTER/WORKSTATION IN ITS ENTIRETY.
3. REMOVE EXISTING LIGHTING AND POWER TO TOILET ROOM.
4. REMOVE EXISTING SWITCH (REFER TO NEW PLAN FOR NEW LOCATION)
5. REMOVE CHART BOXES AND SAVE FOR REUSE.
6. REMOVE ALL CABINETRY
7. REMOVE ENTIRE CARPET IN SECTIONS DURING EACH PHASE.
8. DISCONNECT AND REMOVE EXISTING RECEPTACLES AND DATA OUTLETS THRU-OUT EXISTING WORK STATIONS.
9. REMOVE PLUMBING FIXTURES AND ALL RELATED PING BACK TO MAINS AND CAP.
10. REMOVE FLOOR DRAIN AND ALL RELATED PIPING BACK TO MAINS AND CAP.
11. REMOVE FLOORING IN ENTIRE TOILET ROOM.
12. REMOVE WALLS, DOOR, CEILINGS RELATED TO EXISTING TOILET ROOM.
13. REMOVE EXISTING DRYWALL SOFFIT ABOVE COUNTER AND RELATED LIGHTING.

### GENERAL NOTES - DEMO

- A. REMOVE ALL WIRING AND CONDUIT NO LONGER IN SERVICE BACK TO PANEL.
- B. REMOVE ALL PIPING BACK TO MAINS AND CAP. DO NOT LEAVE ANY DEAD LEGS FOR ANY SERVICE.
- C. PROPERLY DISPOSE OF ALL REMOVED ITEMS UNLESS OTHERWISE NOTED.

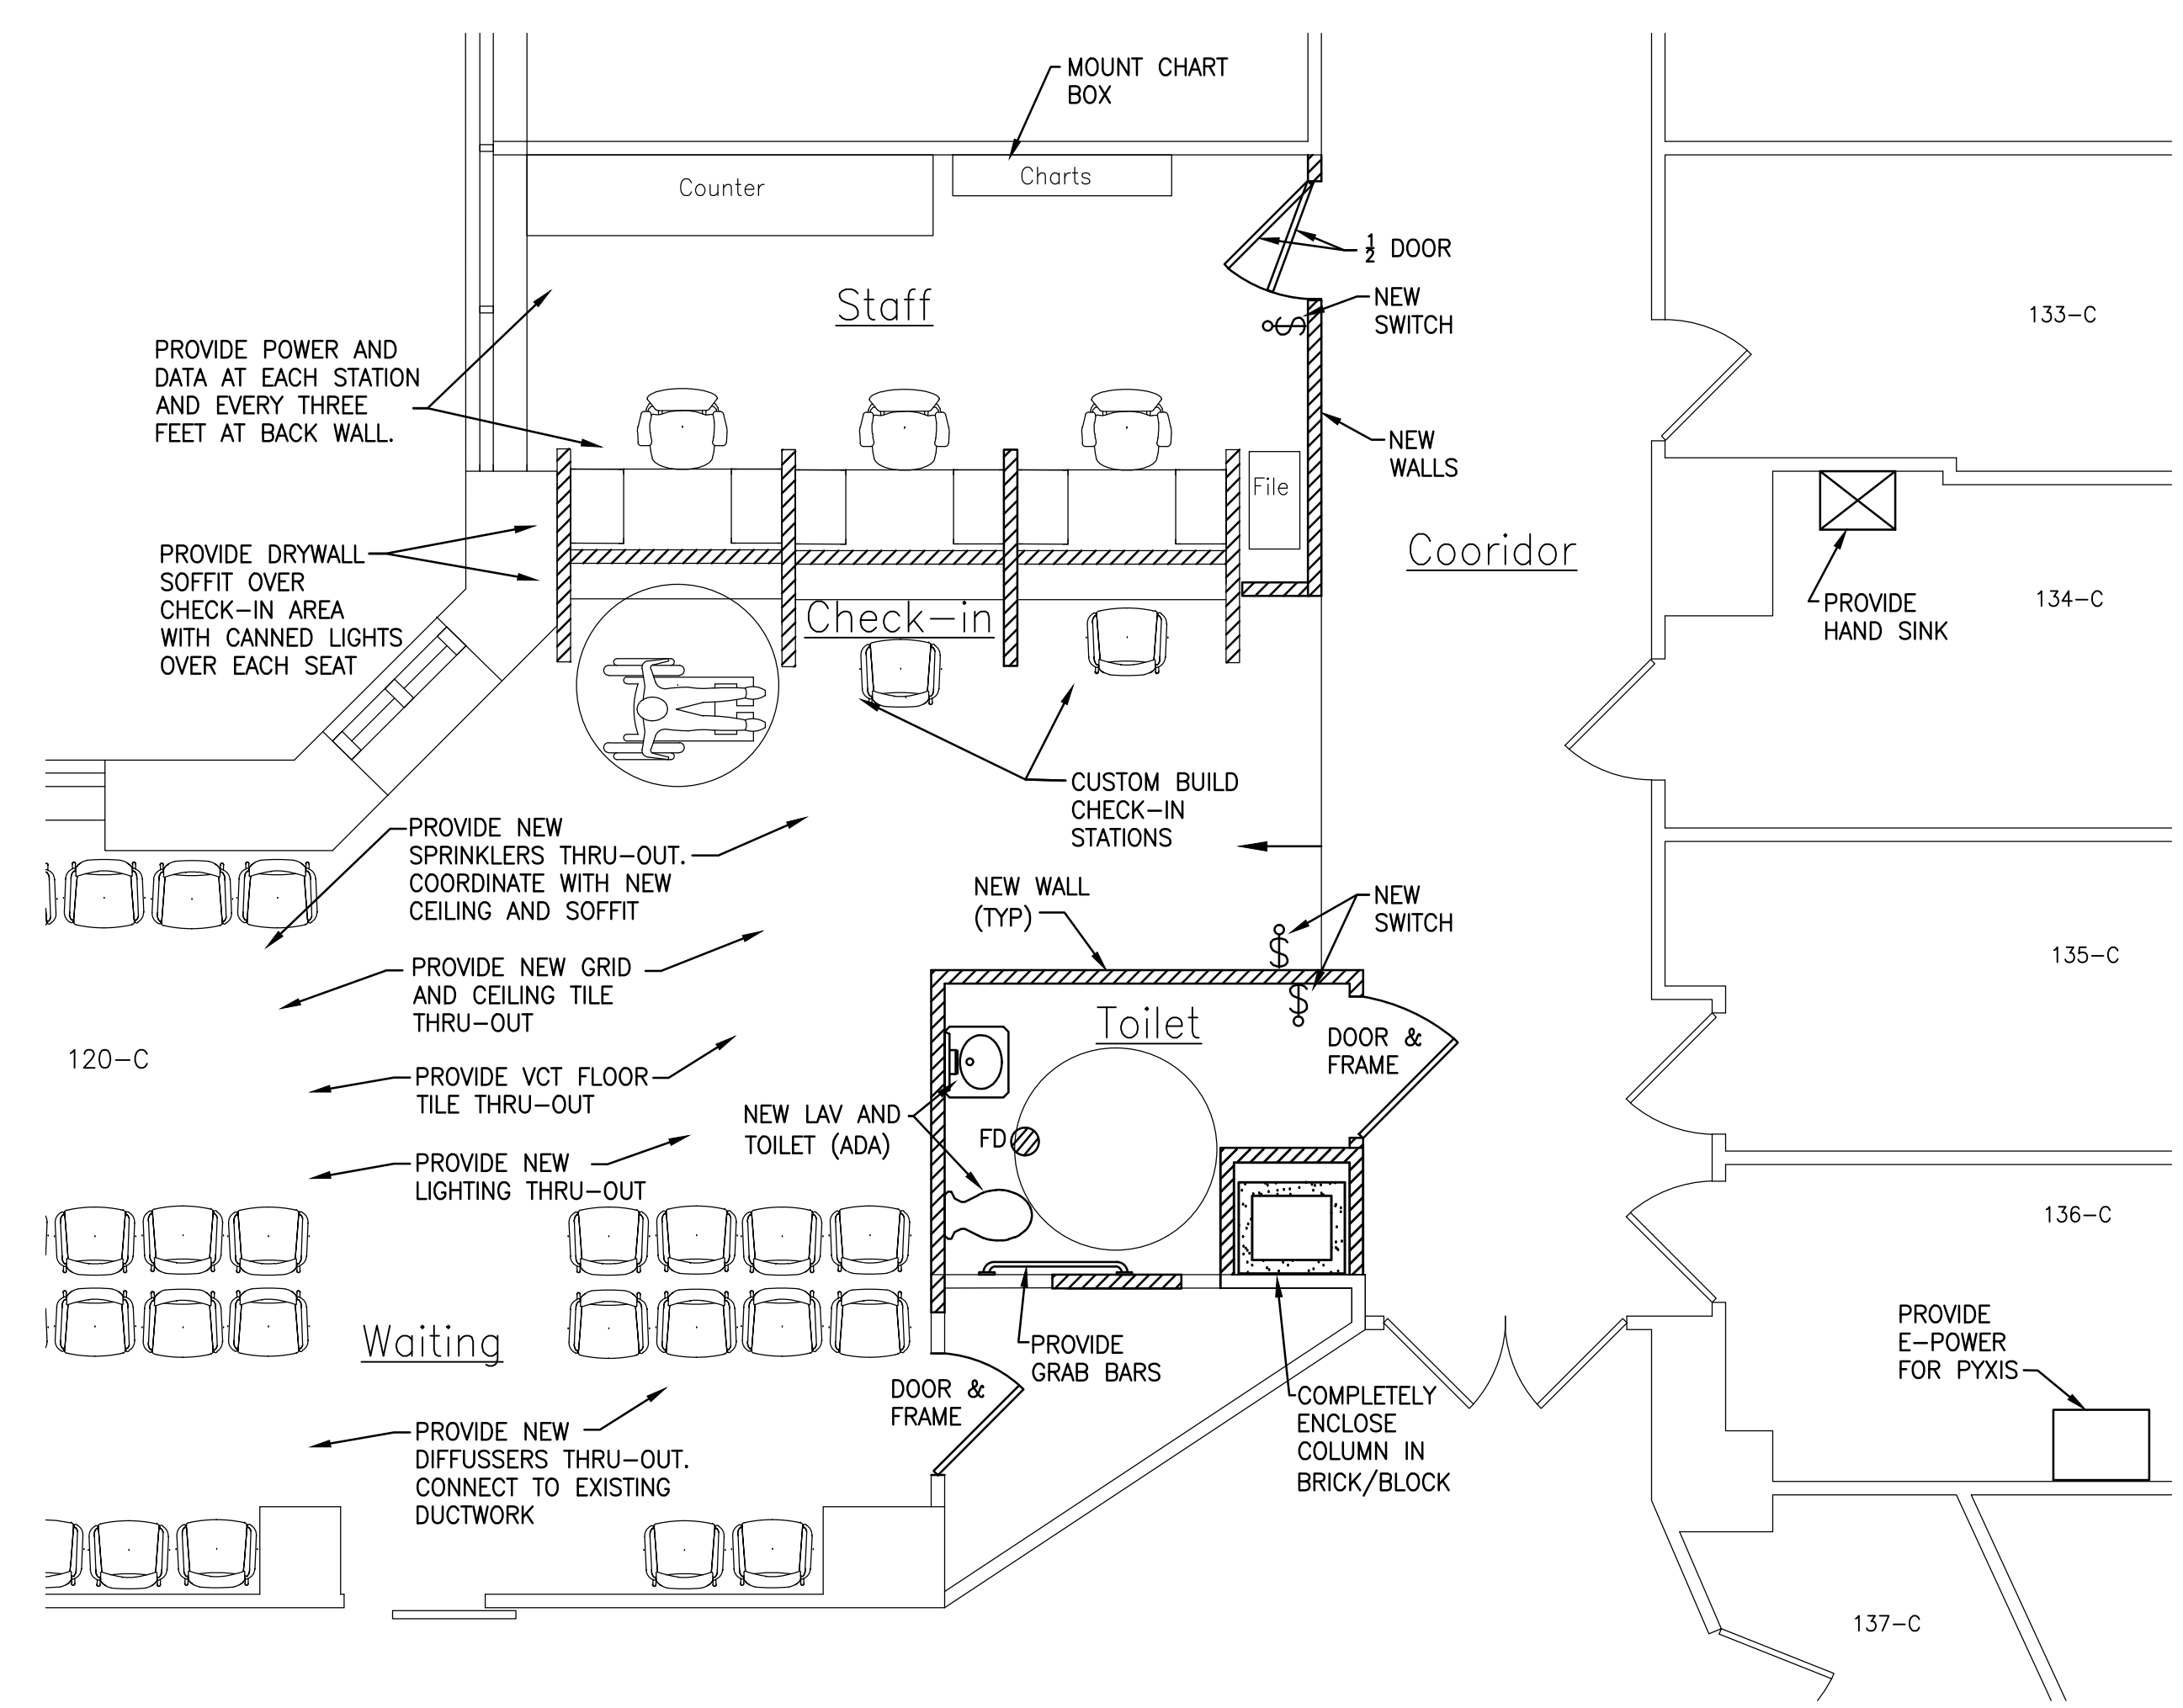


### FLOOR PLAN - NEW WORK

SCALE: 1/4"=1'-0"

### GENERAL NOTES

- A. OFF HOURS AND WEEKEND WORK WILL BE REQUIRED.
- B. ALL DATA OUTLETS ARE TO INCLUDE (2) DATA LINES, (1) PHONE LINE AND (1) SPARE.
- C. VERIFY CIRCUITS TO BE DISCONNECTED FOR EQUIPMENT BEING REMOVED. PROVIDE NEW BREAKERS FOR ALL NEW CONNECTIONS.
- D. PATCH ALL WALL DENTS, HOLES, ETC AND PAINT ALL WALLS WITH PRIMER AND TWO COATS OF PAINT.
- E. PROVIDE EMERGENCY POWER TO PYXIS UNIT.
- F. PROVIDE NEW VCT TILE ON FLOORING THRU-OUT THE WORK AREA WITH NEW COVE BASE.
- G. EXTEND WATER, WASTE AND VENT PIPING TO NEW PLUMBING FIXTURES.

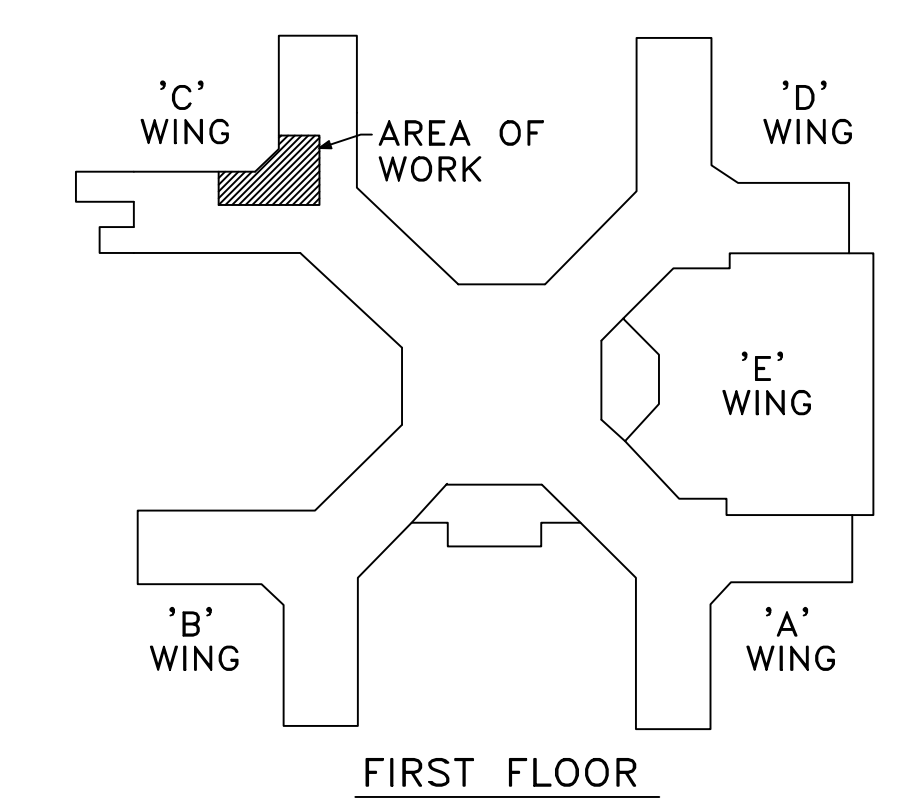

### KEY PLAN

SCALE: NONE

30% SCHEMATIC DRAWING Revisions		3/23/13 Date	VA WESTERN NEW YORK HEALTHCARE SYSTEM 3495 BAILEY AVENUE BUFFALO, NEW YORK 14215				CLINICAL ENGINEERING DATE ENGINEERING MANAGER DATE	INFECTION CONTROL DATE CARELINE MANAGER DATE	SAFETY OFFICER DATE CHIEF OF STAFF DATE	Drawing Title DEMOLITION PLAN, FLOOR PLANS AND NOTES	Project Title DESK 5 & 6 PRIVACY MODIFICATIONS	Date MARCH 23, 2013 Station No. 528	Building Number 1 Checked VR Drawn RLR	Location V.A.M.C. BUFFALO, NEW YORK	12-S32-A101	Office of Facilities Department of Veterans Affairs
------------------------------------	--	-----------------	--	--	--	--	---	---	--	--	--	--	---	--	-------------	--