


- KEYED NOTES: HVAC PIPING DEMO PLAN**
- 1 REMOVE FCU, COMPLETE, REMOVE MEDIUM PRESSURE STEAM AND CONDENSATE PIPING BACK TO "MD" MAINS, VALVE AND CAP PIPING AT MAINS. PATCH AND PAINT WALLS TO MATCH EXISTING TEXTURE AND COLOR.
 - 2 DISCONNECT CHSR AND CONDENSATE PIPING AND REMOVE BACK TO MAIN.

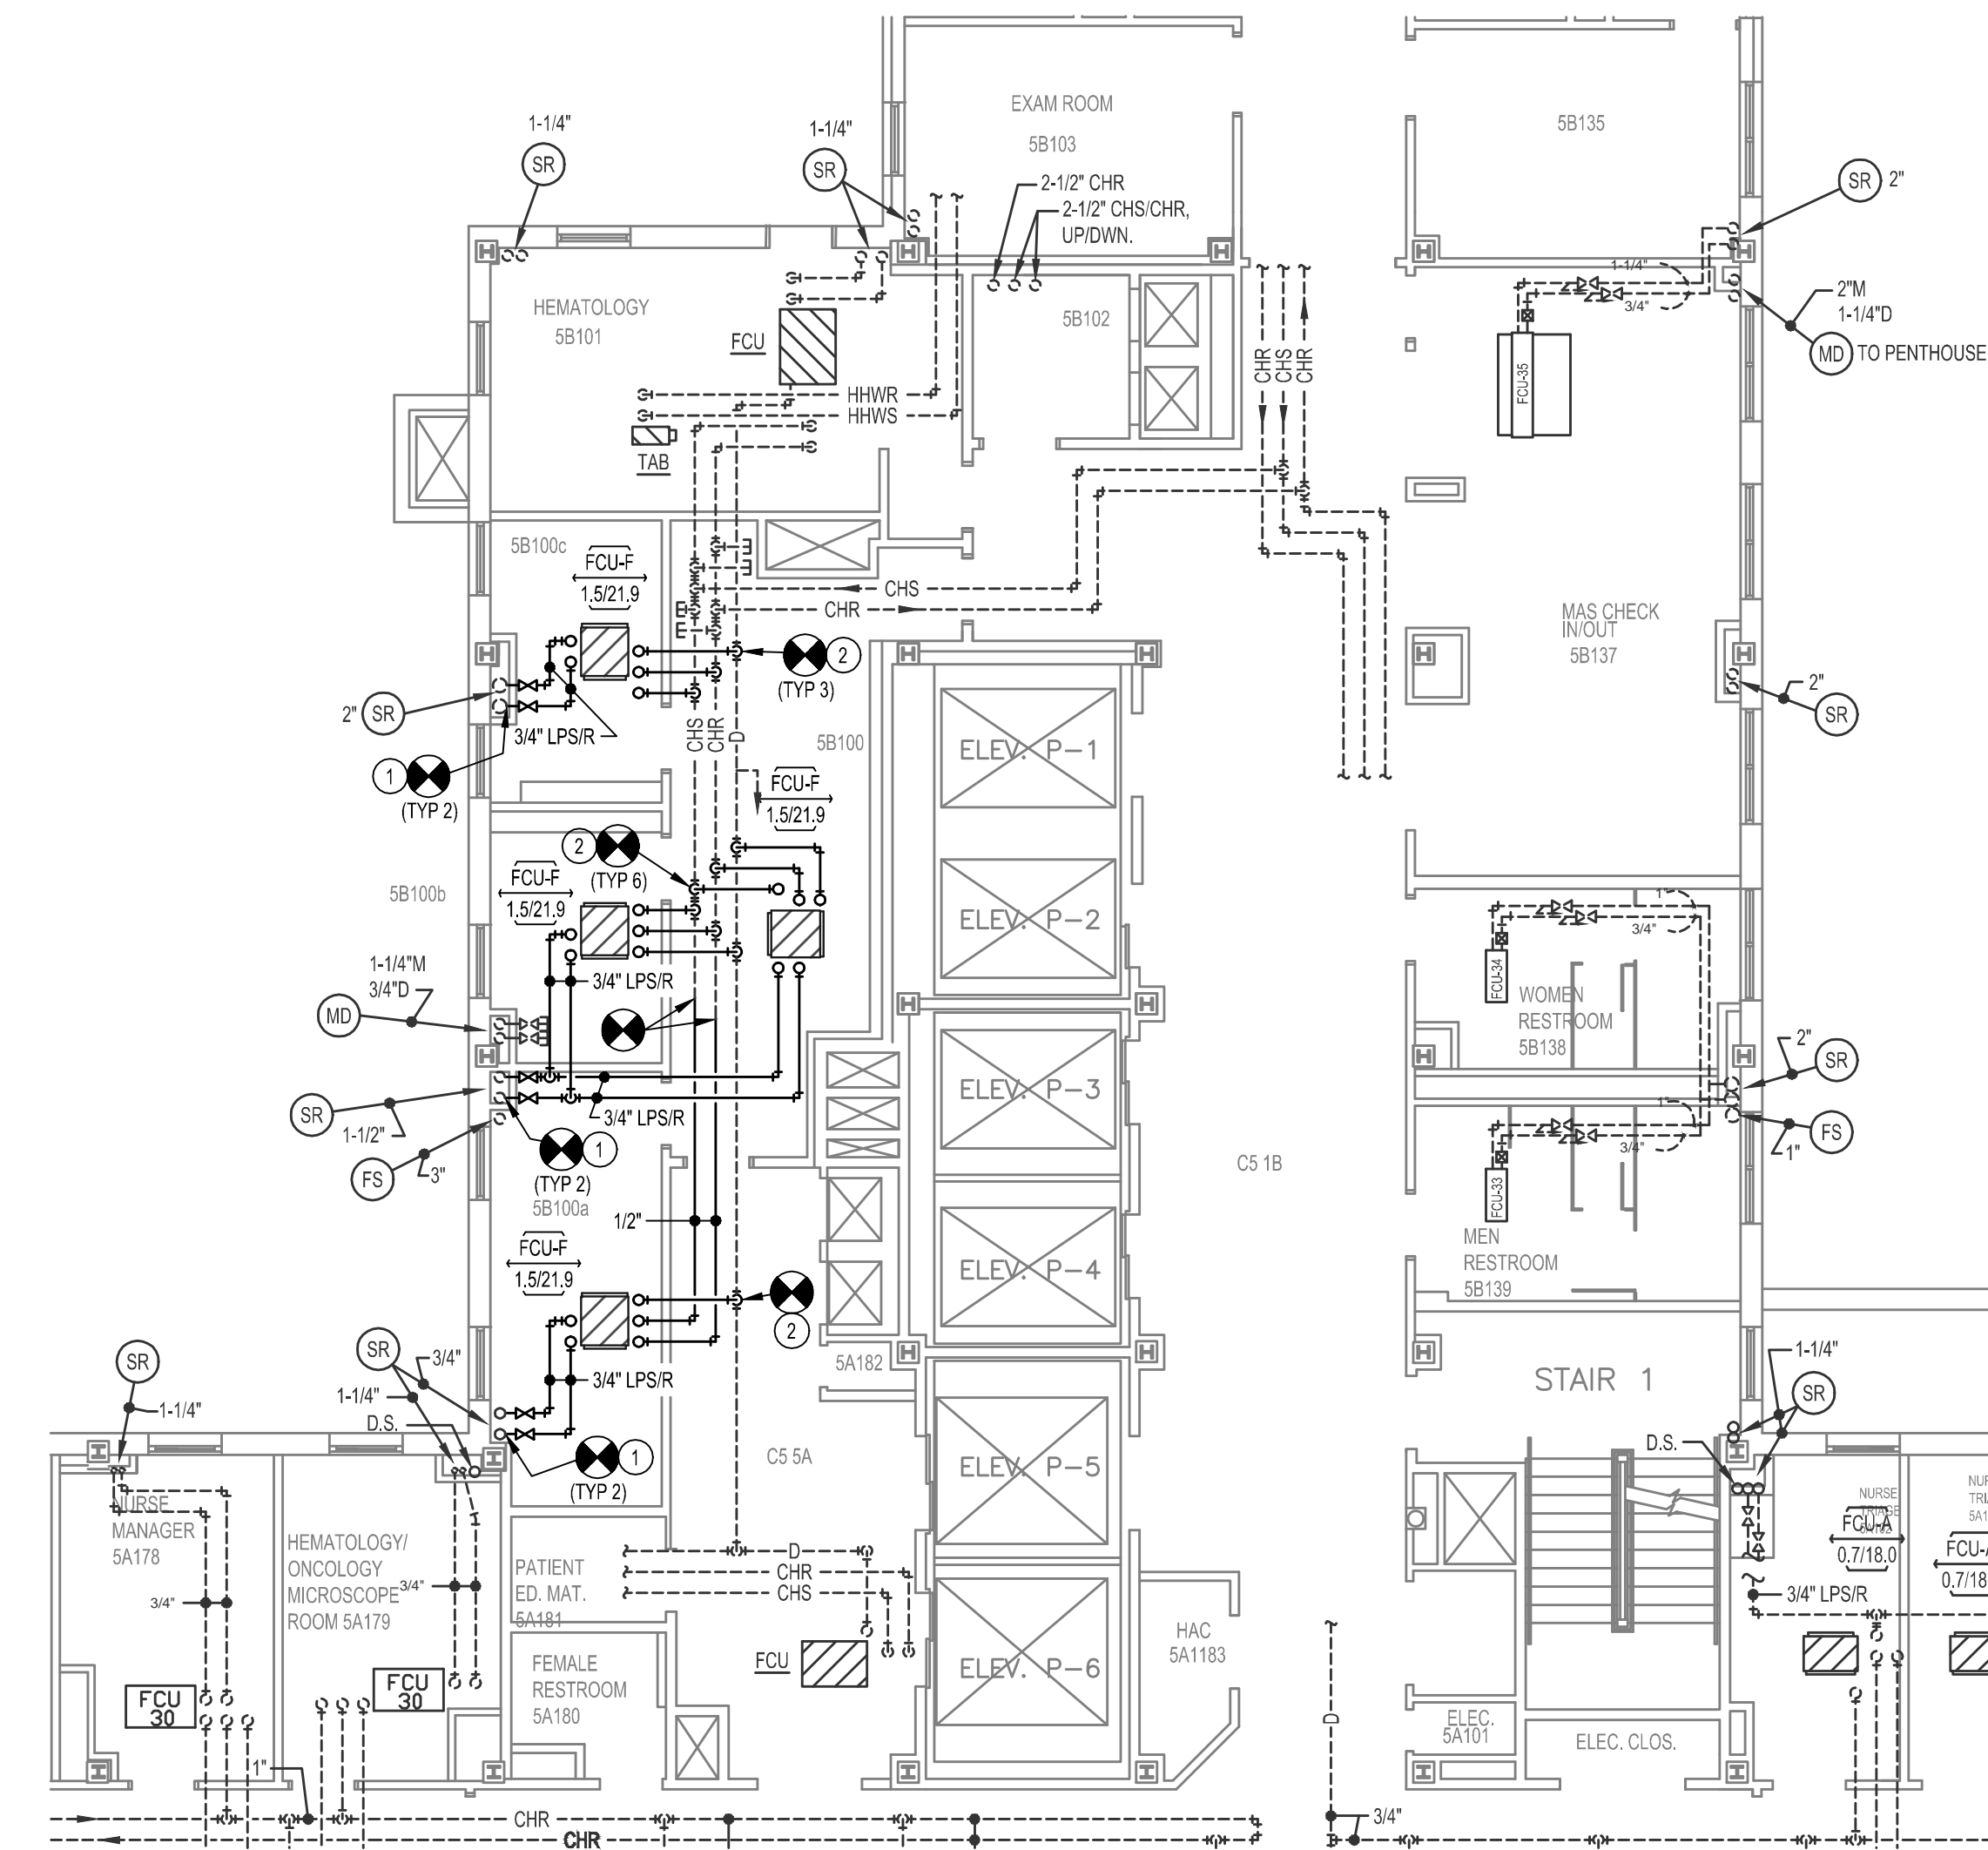


- KEYED NOTES: HVAC PIPING PLAN**
- 1 CONNECT NEW 3/4\"/>

1 LEVEL 5, AREA B: HVAC PIPING DEMO PLAN
1/8\"/>

2 LEVEL 5, AREA B: HVAC PIPING PLAN
1/8\"/>

| REVISIONS: | |
|------------|-----------|
| △ | 3-28-2013 |
| | |
| | |
| | |

- GENERAL NOTES:**
1. EXISTING CONDITIONS SHOWN WERE DERIVED FROM OWNER FURNISHED DRAWINGS AND FIELD OBSERVATIONS. FIELD VERIFY LOCATION, SIZE, ROUTING AND QUANTITY OF ALL EQUIPMENT, PIPING, CONDUIT AND SYSTEMS.
 2. SOME EXISTING SYSTEMS AND EQUIPMENT ARE NOT SHOWN FOR CLARITY. FIELD VERIFY EXISTING CONDITIONS.
 3. REUSE EXISTING HANGERS AS APPLICABLE. REPAIR/REPLACE/PROVIDE NEW HANGERS AS REQUIRED. REMOVE HANGERS NOT UTILIZED DURING CONSTRUCTION.
 4. FIELD VERIFY LOCATION AND ROUTING OF ALL MEDICAL GAS PIPING AND EQUIPMENT. WORK ON THESE SYSTEMS IS NOT INCLUDED IN THE SCOPE OF WORK.

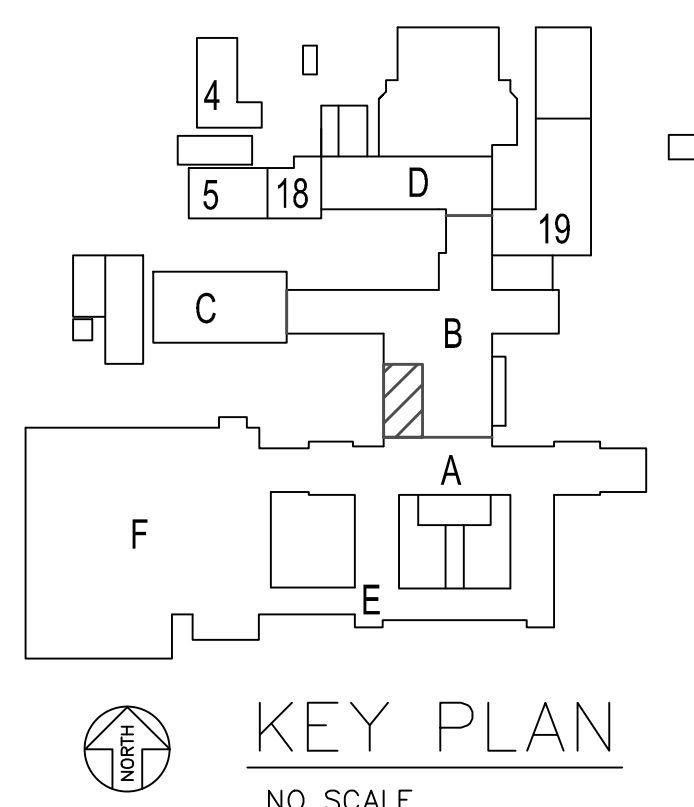

This seal appearing on this document was authorized by Robert M. Dawes, 20079 on 03/25/2013. Alteration of a sealed document without proper notification to the responsible engineer is an offense under the Texas Engineering Practice Act.



RMD CONSULTING, LLC.
2815 VALLEY VIEW, SUITE 214
DALLAS, TEXAS 75234
P. 972-488-8077 F. 972-488-8174
RUDC JOB # 12-3702A © 2013
OKLAHOMA REGISTERED ENGINEERING FIRM: 5183

| | | | | |
|--|--|---|--|-----------------------------------|
| Drawing Title LEVEL 5, AREA B: HVAC PIPING PLAN | | Project Title CORRECT HVAC DEFICIENCIES IN 5B100 AND BREEZEWAYS | | Date MARCH 5, 2013 |
| Approved: Division Chief | | Building Number 1 | | Project No. 635-12-313 |
| Approved: Service Director | | Checked | | DRAWING NO. 1-M3.01 |
| Location VA MEDICAL CENTER OKLAHOMA CITY, OKLAHOMA | | Dwg. 6 of 12 | | DEPARTMENT of VETERANS AFFAIRS |