


PIPE SPACE PLAN-AREA E
SCALE: 1/8" = 1'-0"

- NOTE:
1. ALL LIGHTING FIXTURES TYPE S 160W
 2. LIGHTING AND RECEPTACLES ARE ON SEPARATE CIRCUITS.
 3. REFER TO DWG. J-56 FOR LIGHTING CONTROL DIAGRAM
 4. ON-OFF PUSHBUTTON SWITCH TO CONTROL LIGHTING CONTACTOR.

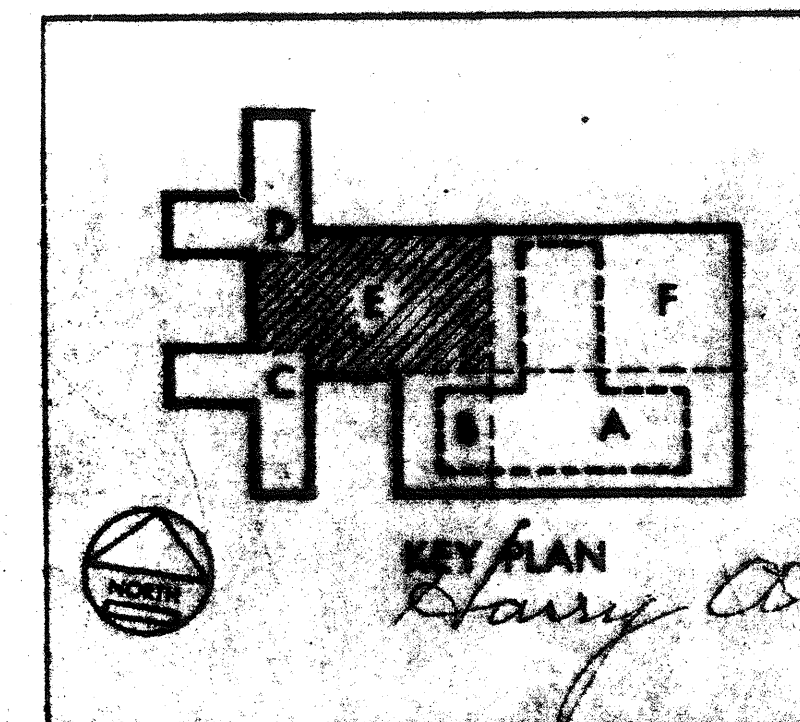

PIPE SPACE PLAN - AREA E
BUILDING No. 1 SCALE 1/8"=1'-0"
760 BED M. S. & N. AND
PSYCHIATRIC HOSPITAL
VETERANS ADMINISTRATION
SAN ANTONIO, TEXAS

GOLEMON & ROLFE ARCHITECTS
SAN ANTONIO ASSOCIATED ARCHITECTS:
MOONAN, KROCKER & ROGERS
ARCHITECTS & ENGINEERS
EDWARD R. GONDECK, ARCHITECT
WILLIAM E. PARRISH, ARCHITECT
ADAMS & ADAMS, ARCHITECTS

Project Director
H. J. D. San

DRAWING NUMBER
7-E9

Sheet 10 of 16

Proj. No. 42-5363

THREE INCHES EQUALS ONE FOOT
ONE AND ONE HALF INCHES EQUALS ONE FOOT
ONE INCH EQUALS ONE FOOT
THREE QUARTER INCH EQUALS ONE FOOT
ONE HALF INCH EQUALS ONE FOOT
THREE EIGHTH INCH EQUALS ONE FOOT
ONE QUARTER INCH EQUALS ONE FOOT
ONE EIGHTH INCH EQUALS ONE FOOT

RETURN 11 TRACINGS TO PLAN LIBRARY

FILE FOLDER NO. 2D