





DEPARTMENT OF VETERANS AFFAIRS  
GRAND JUNCTION MEDICAL CENTER,  
REPLACE ABSORPTION CHILLERS  
PROJECT NO. VA-259-12-C-0219  
2121 NORTH AVENUE  
GRAND JUNCTION, COLORADO 81505

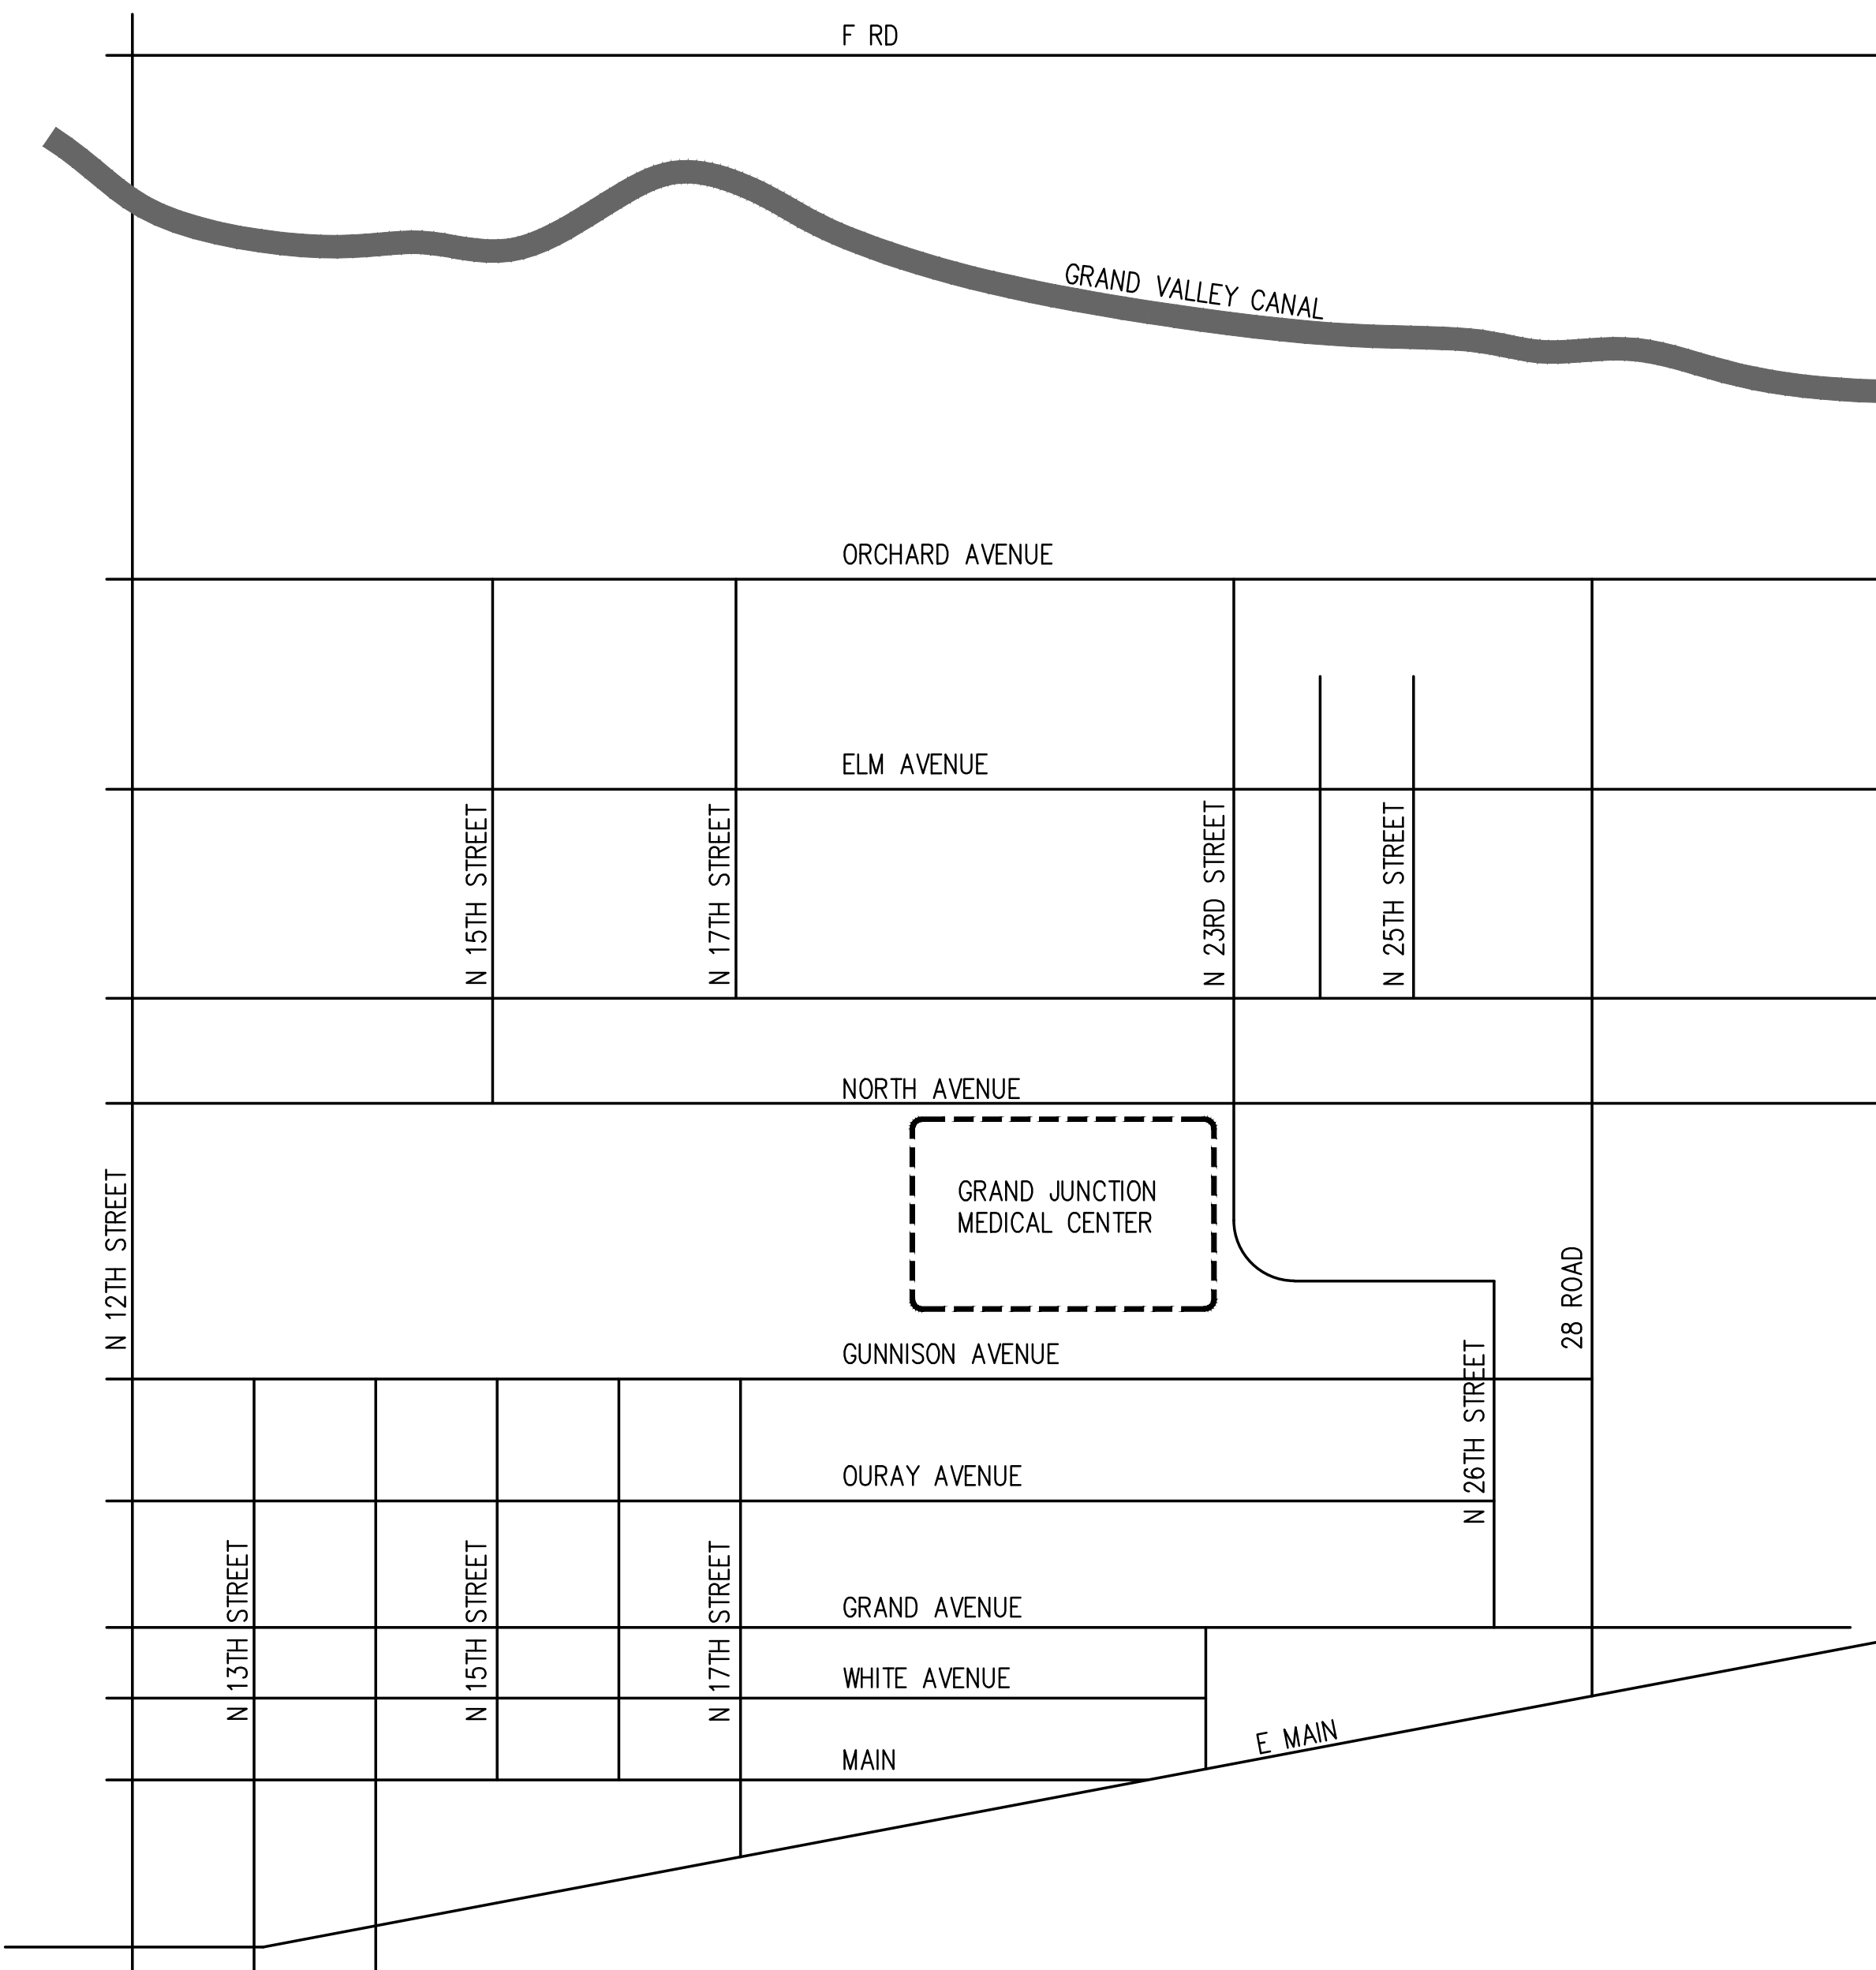

VICINITY MAP  
NO SCALE

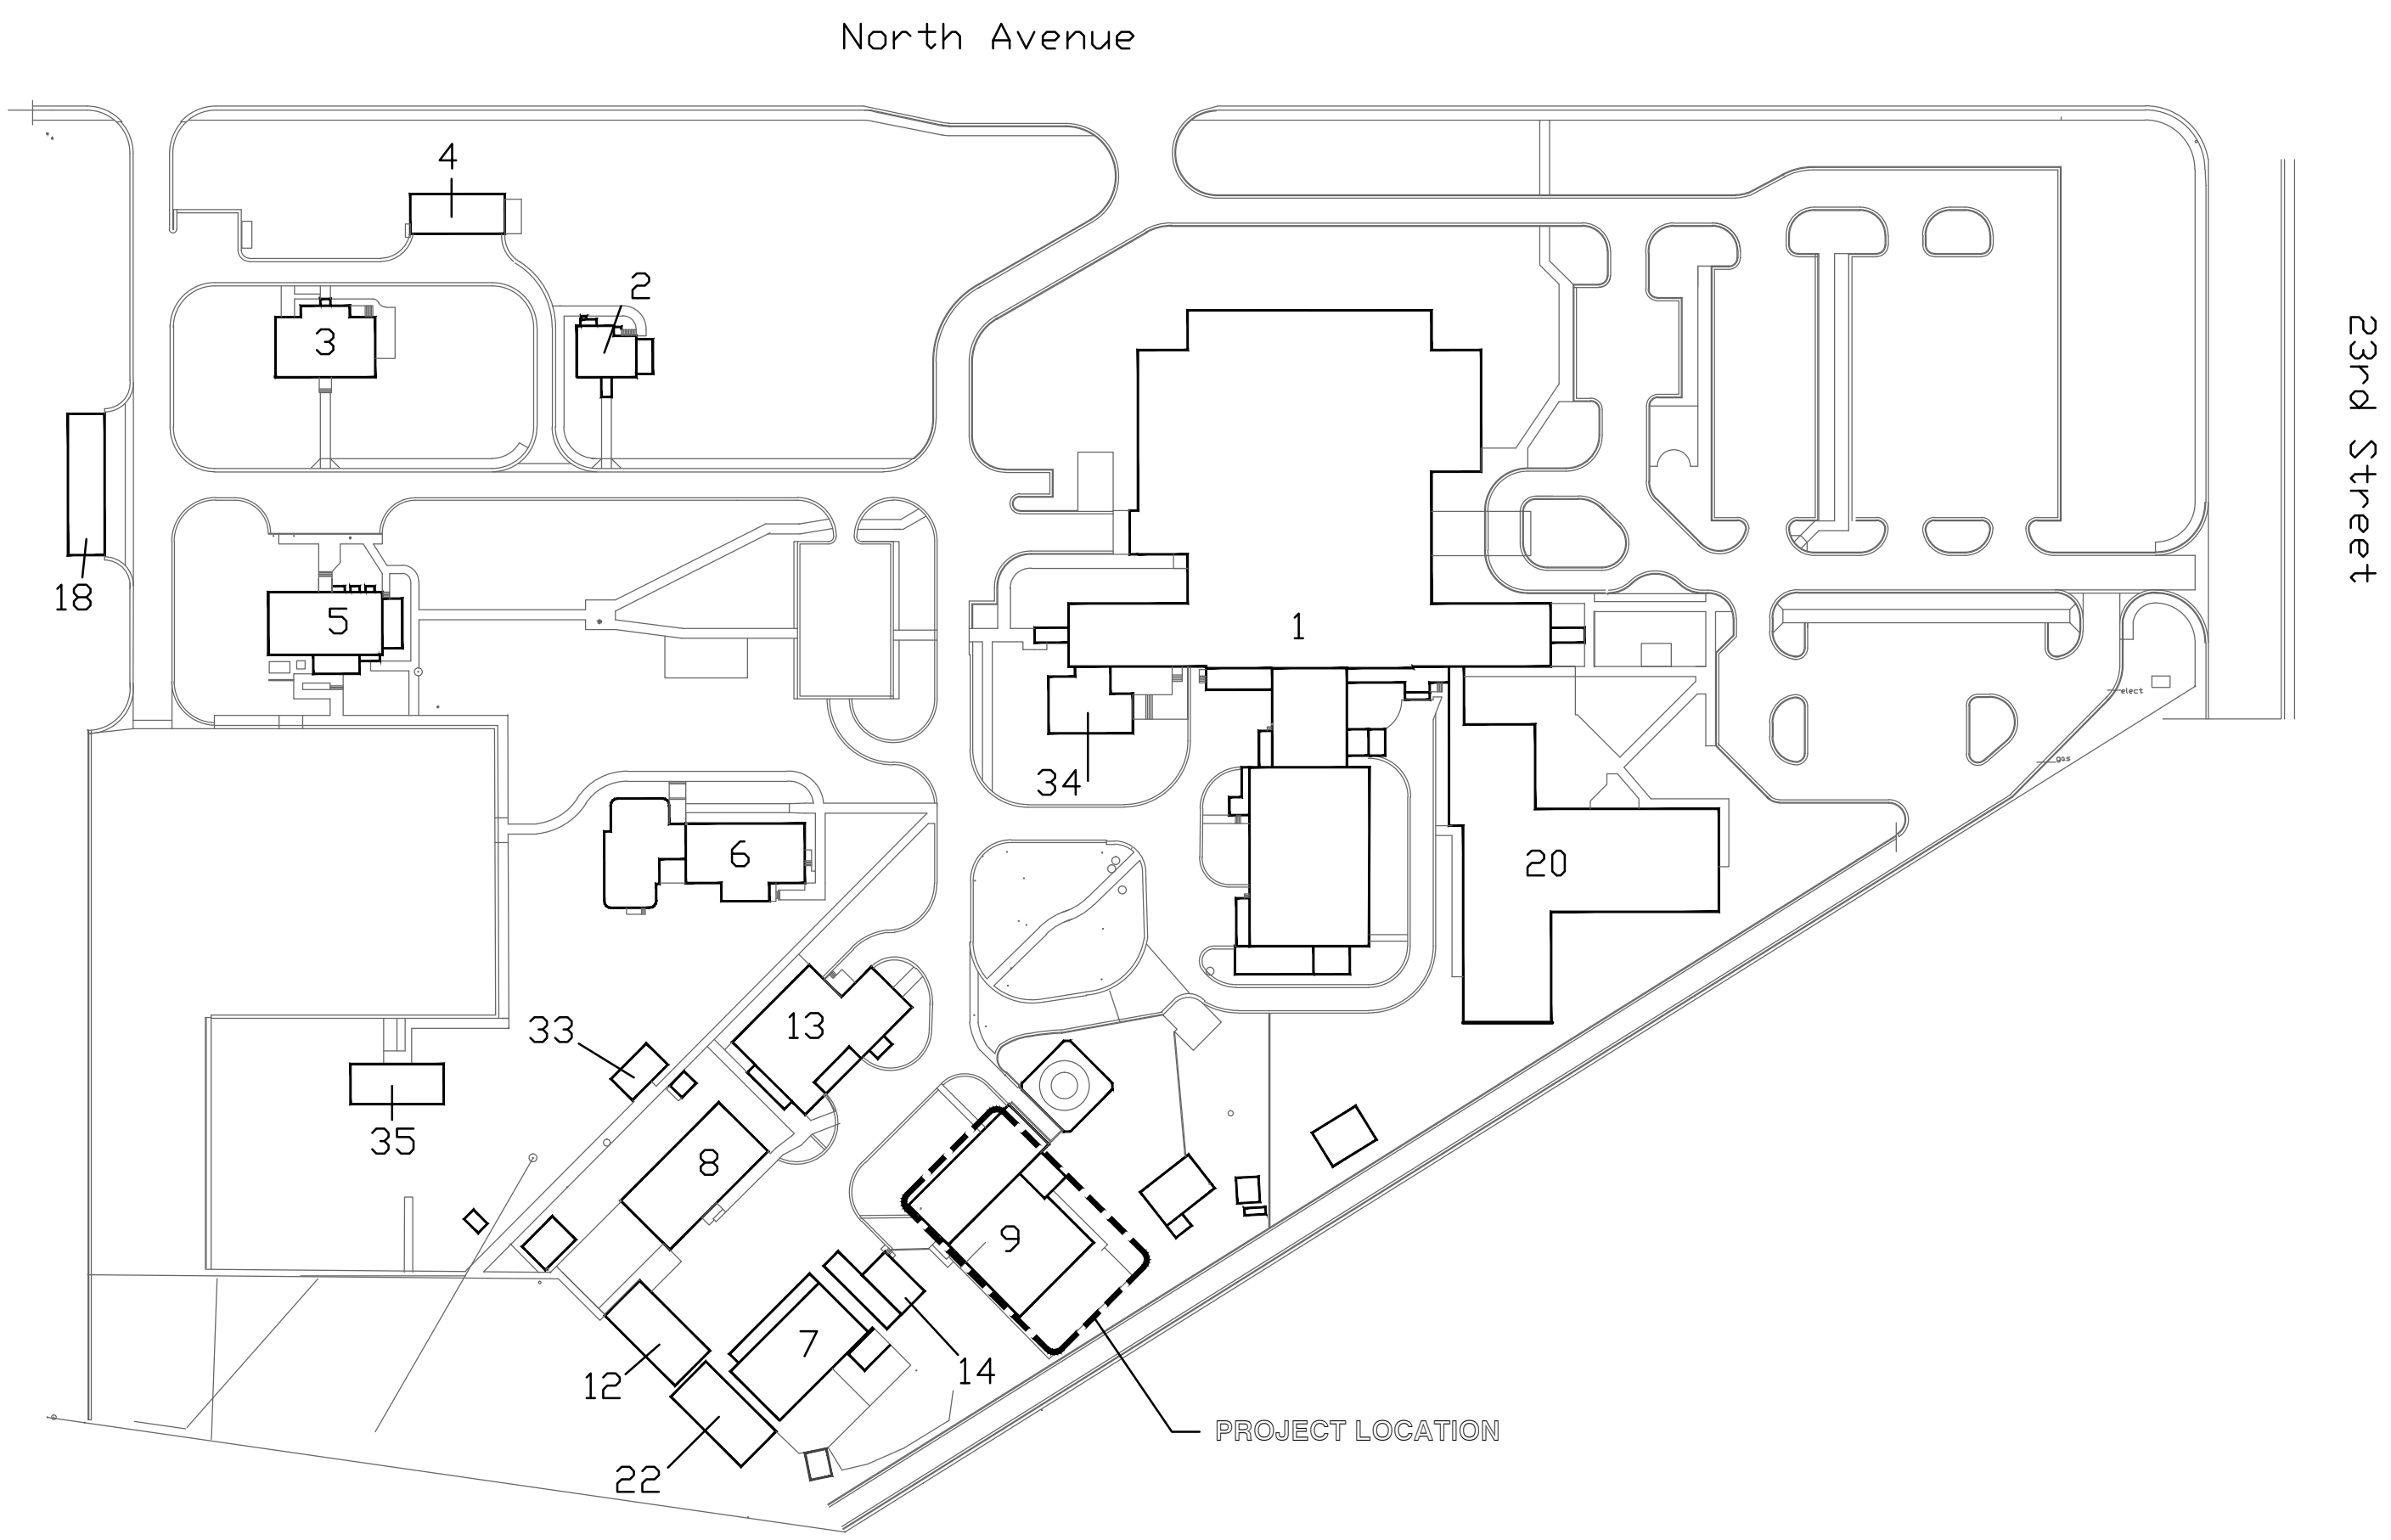

SITE MAP  
NO SCALE



DRAWING INDEX

DRAWING INDEX	
DRAWING NO.	DRAWING TITLE
I-1	COVER
H1	MECHANICAL LEGEND
H2	MECHANICAL ROOM DEMOLITION PLAN
H3	NEW MECHANICAL ROOM PLAN
H4	MECHANICAL SECTION
H5	MECHANICAL DETAILS
H6	MECHANICAL SCHEDULES
H7	MECHANICAL SCHEDULES
H8	MECHANICAL CONTROLS
H9	MECHANICAL CONTROLS
H10	MECHANICAL CONTROLS
H11	MECHANICAL CONTROLS
H12	MECHANICAL CONTROLS
H13	MECHANICAL CONTROLS
EP100	Electrical Layout
EP200	Switchgear Layout

Revisions		Date		 CONSULTING ENGINEERS * PH: (719) 637-8850 * * FAX (719) 632-0300 * 2912 BEACON ST. COLORADO SPRINGS, CO 80907		 GONZALES CONSULTING & ENGINEERING		P.O. Box 17868 GOLDEN, COLORADO 80402 PH: 303.386.3324 FX: 720.920.9004 RICARDO@GCECOLORADO.COM		Drawing Title COVER SHEET		Project Title REPLACEMENT OF ABSORPTION CHILLER		Project Number VA259-12-C-0219		Office of Facilities Management	
										Approved: Medical Center Director		Location 2121 NORTH AVENUE GRAND JUNCTION, CO 81505		Building Number BLDG 9		Drawing Number I-1	
										Approved: Assistant Administrator, Engineering Department		Date 03/13/2013		Checked TBS		Drawn DJS	