


## DEMOLITION FLOOR PLAN

Walls and doors to demo or relocate are shown with dashed lines

VA Department of Veterans Affairs

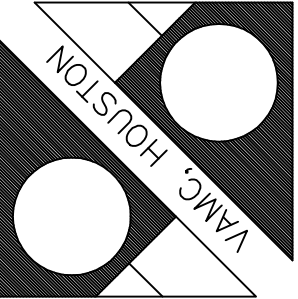


Date 28 SEPT 2011  
xxx  
Drawing No. XXXX

Project Title  
CONCEPTUAL Design  
PHARMACY  
Building Number 100  
Location VAMC, HOUSTON TEXAS.

Drawing Title  
CONCEPTUAL PHASES  
xxxxx  
Approved:  
Approved:

DEMO

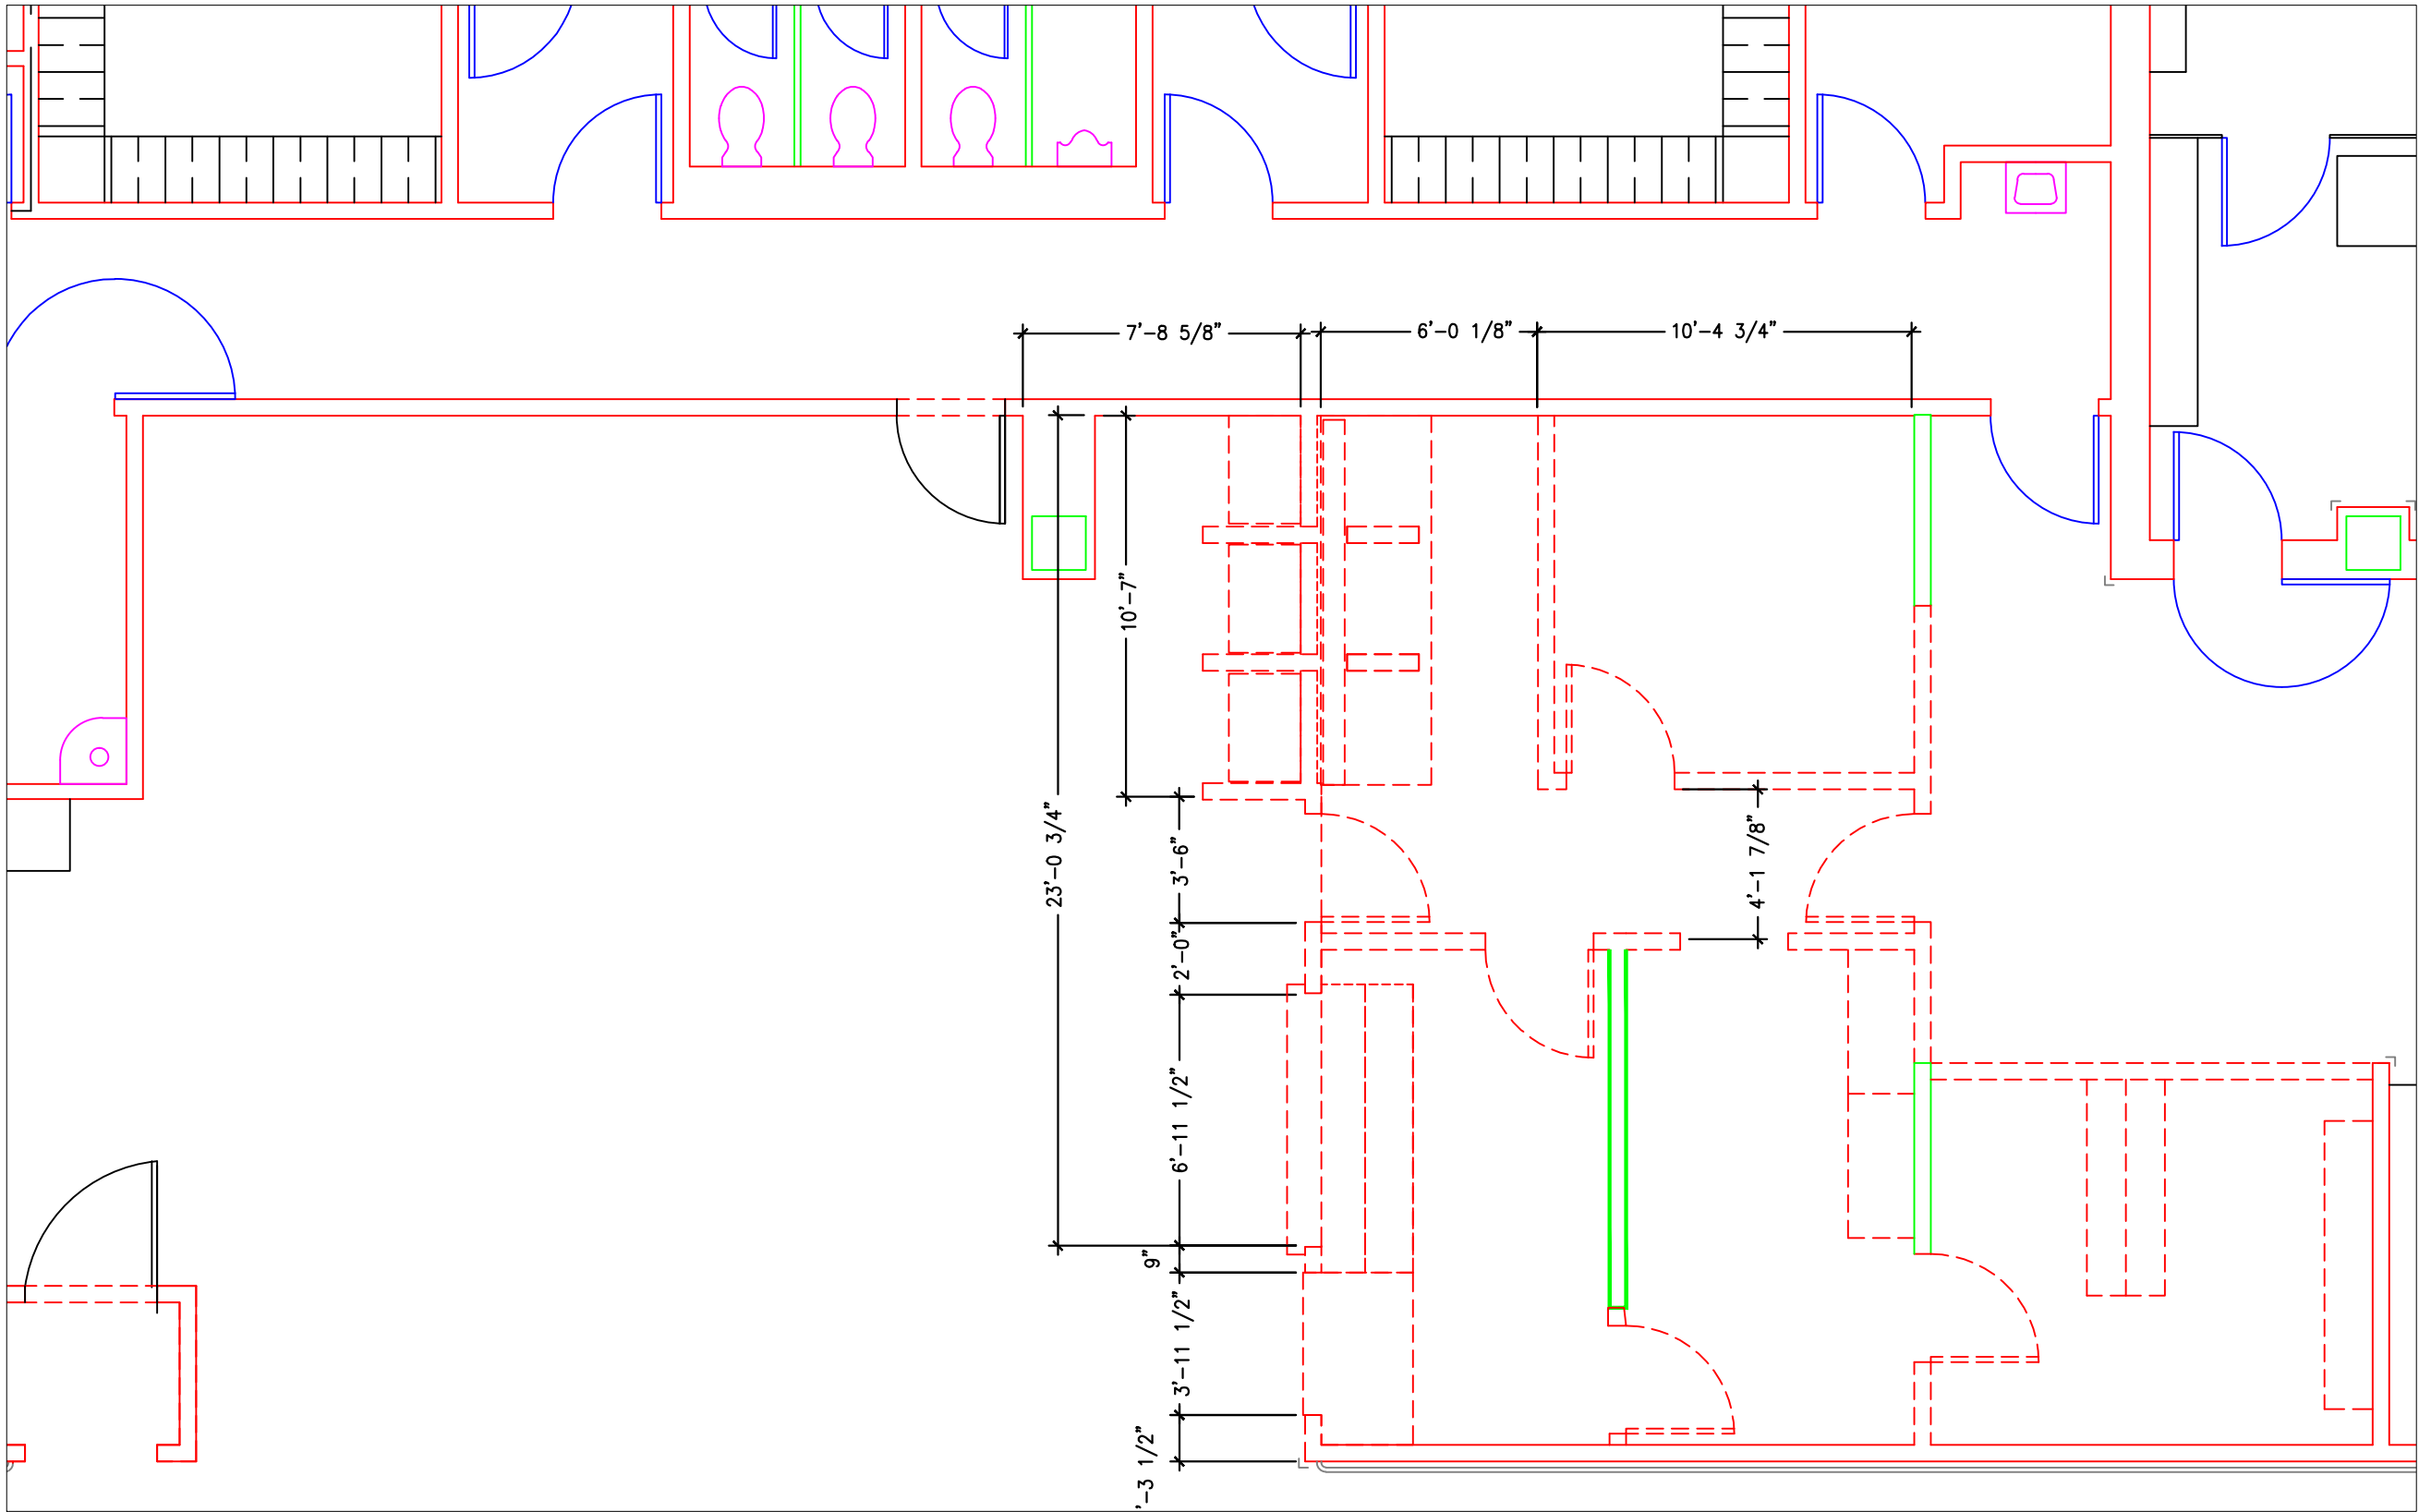

DEMOLITION FLOOR PLAN


Walls and doors to demo or relocate are shown with dashed lines

VA Department of Veterans Affairs

VAMC, HOUSTON


Drawing Title CONCEPTUAL PHASES xxxxx	Project Title CONCEPTUAL Design PHARMACY		Date 28 SEPT 2011	Drawing No. XXXX
	Approved:	Building Number 100	xxx	
Approved:	Location VAMC, HOUSTON TEXAS.		Checked	Drawn

Demo  
PLAN

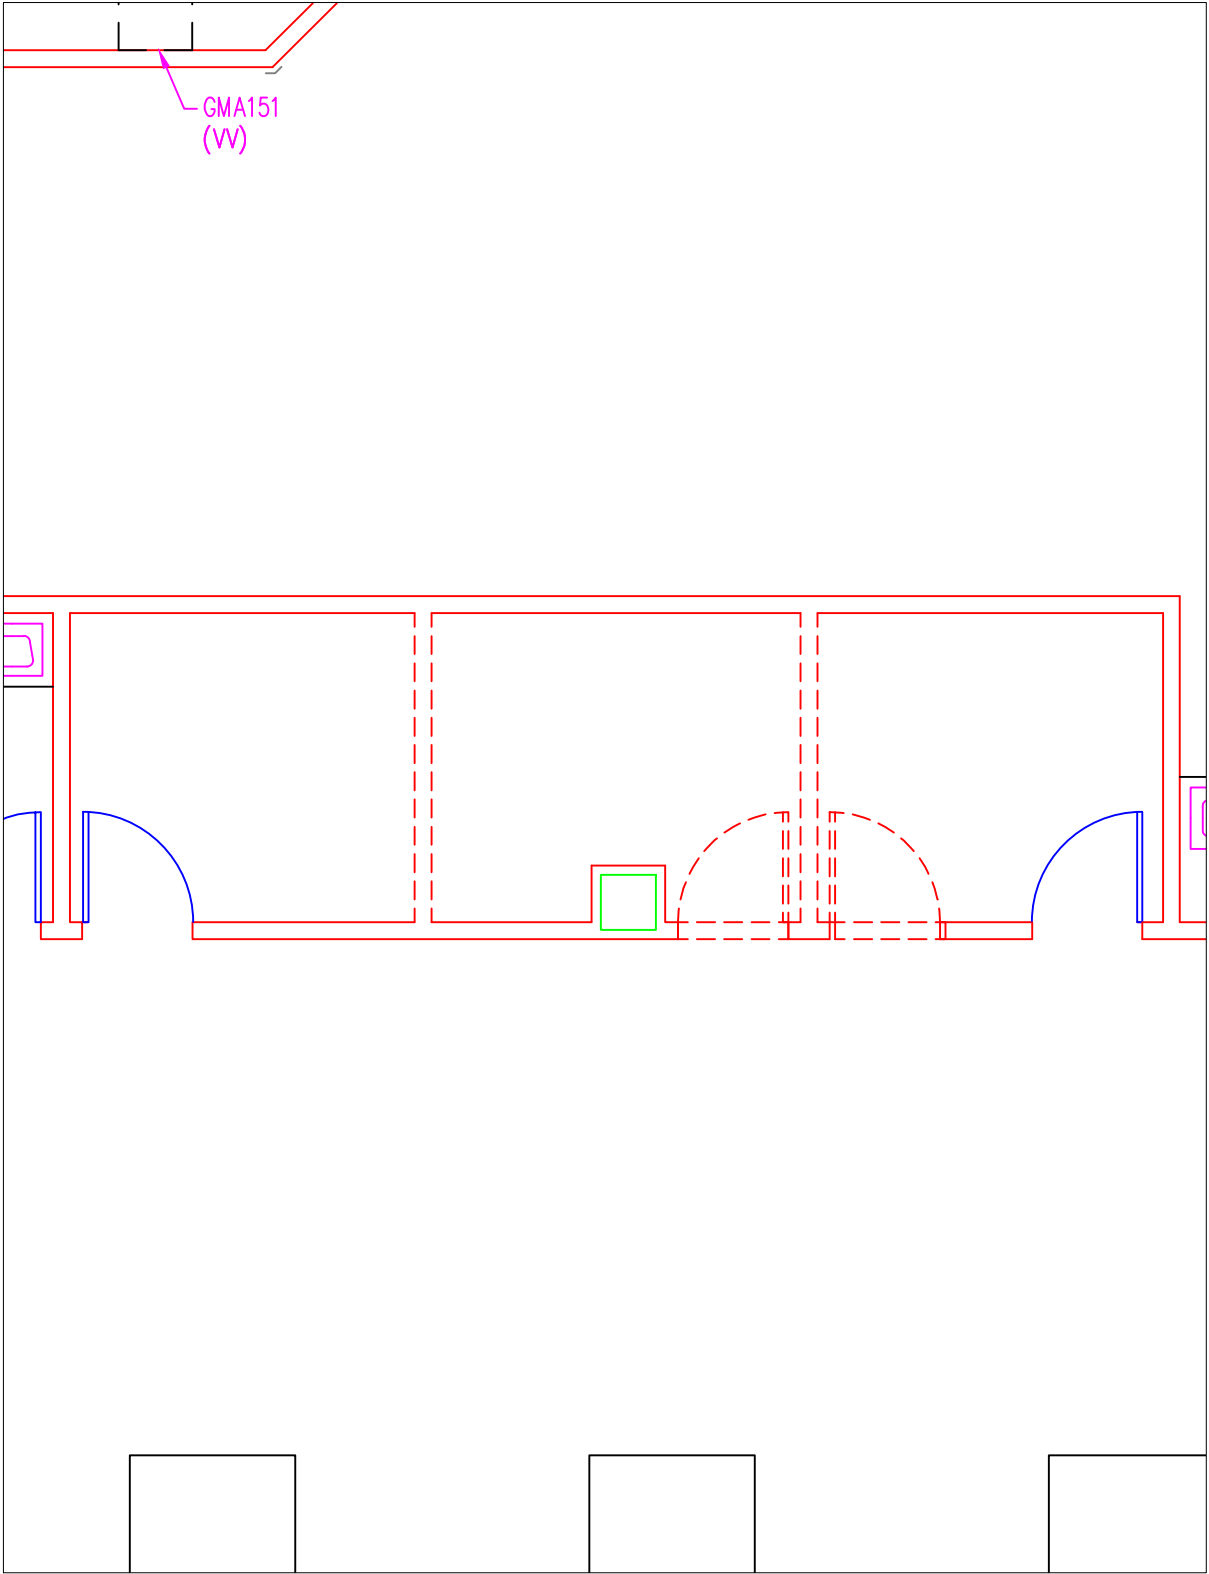


DEMOLITION FLOOR PLAN

Walls and doors to demo or relocate are shown with dashed lines

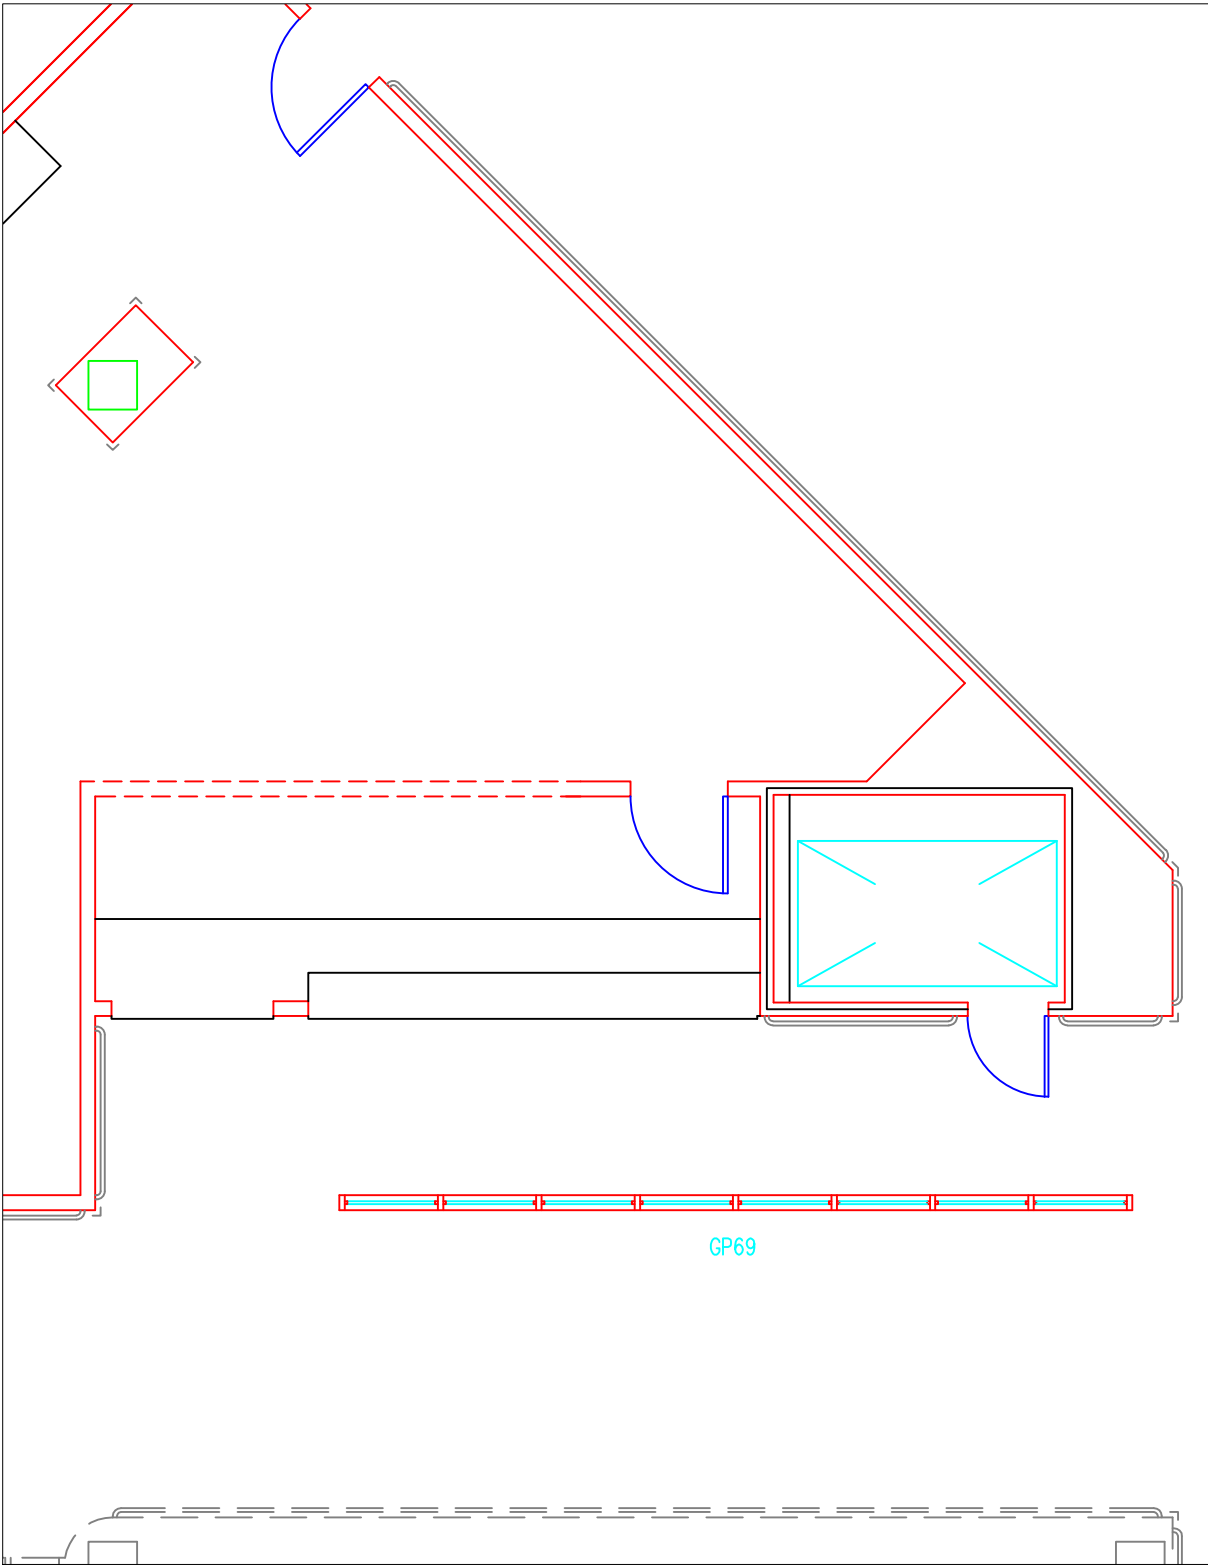

VA Department of Veterans Affairs			
VAMC, HOUSTON			
Date	28 SEPT 2011	Drawing No. XXXX	
Project Title		Building Number	Location
CONCEPTUAL PHASES		100	VAMC, HOUSTON TEXAS.
CONCEPTUAL DESIGN PHARMACY		Checked	Drawn
xxxxx			
Approved:		Approved:	
xxxxx			
Demo PLAN			



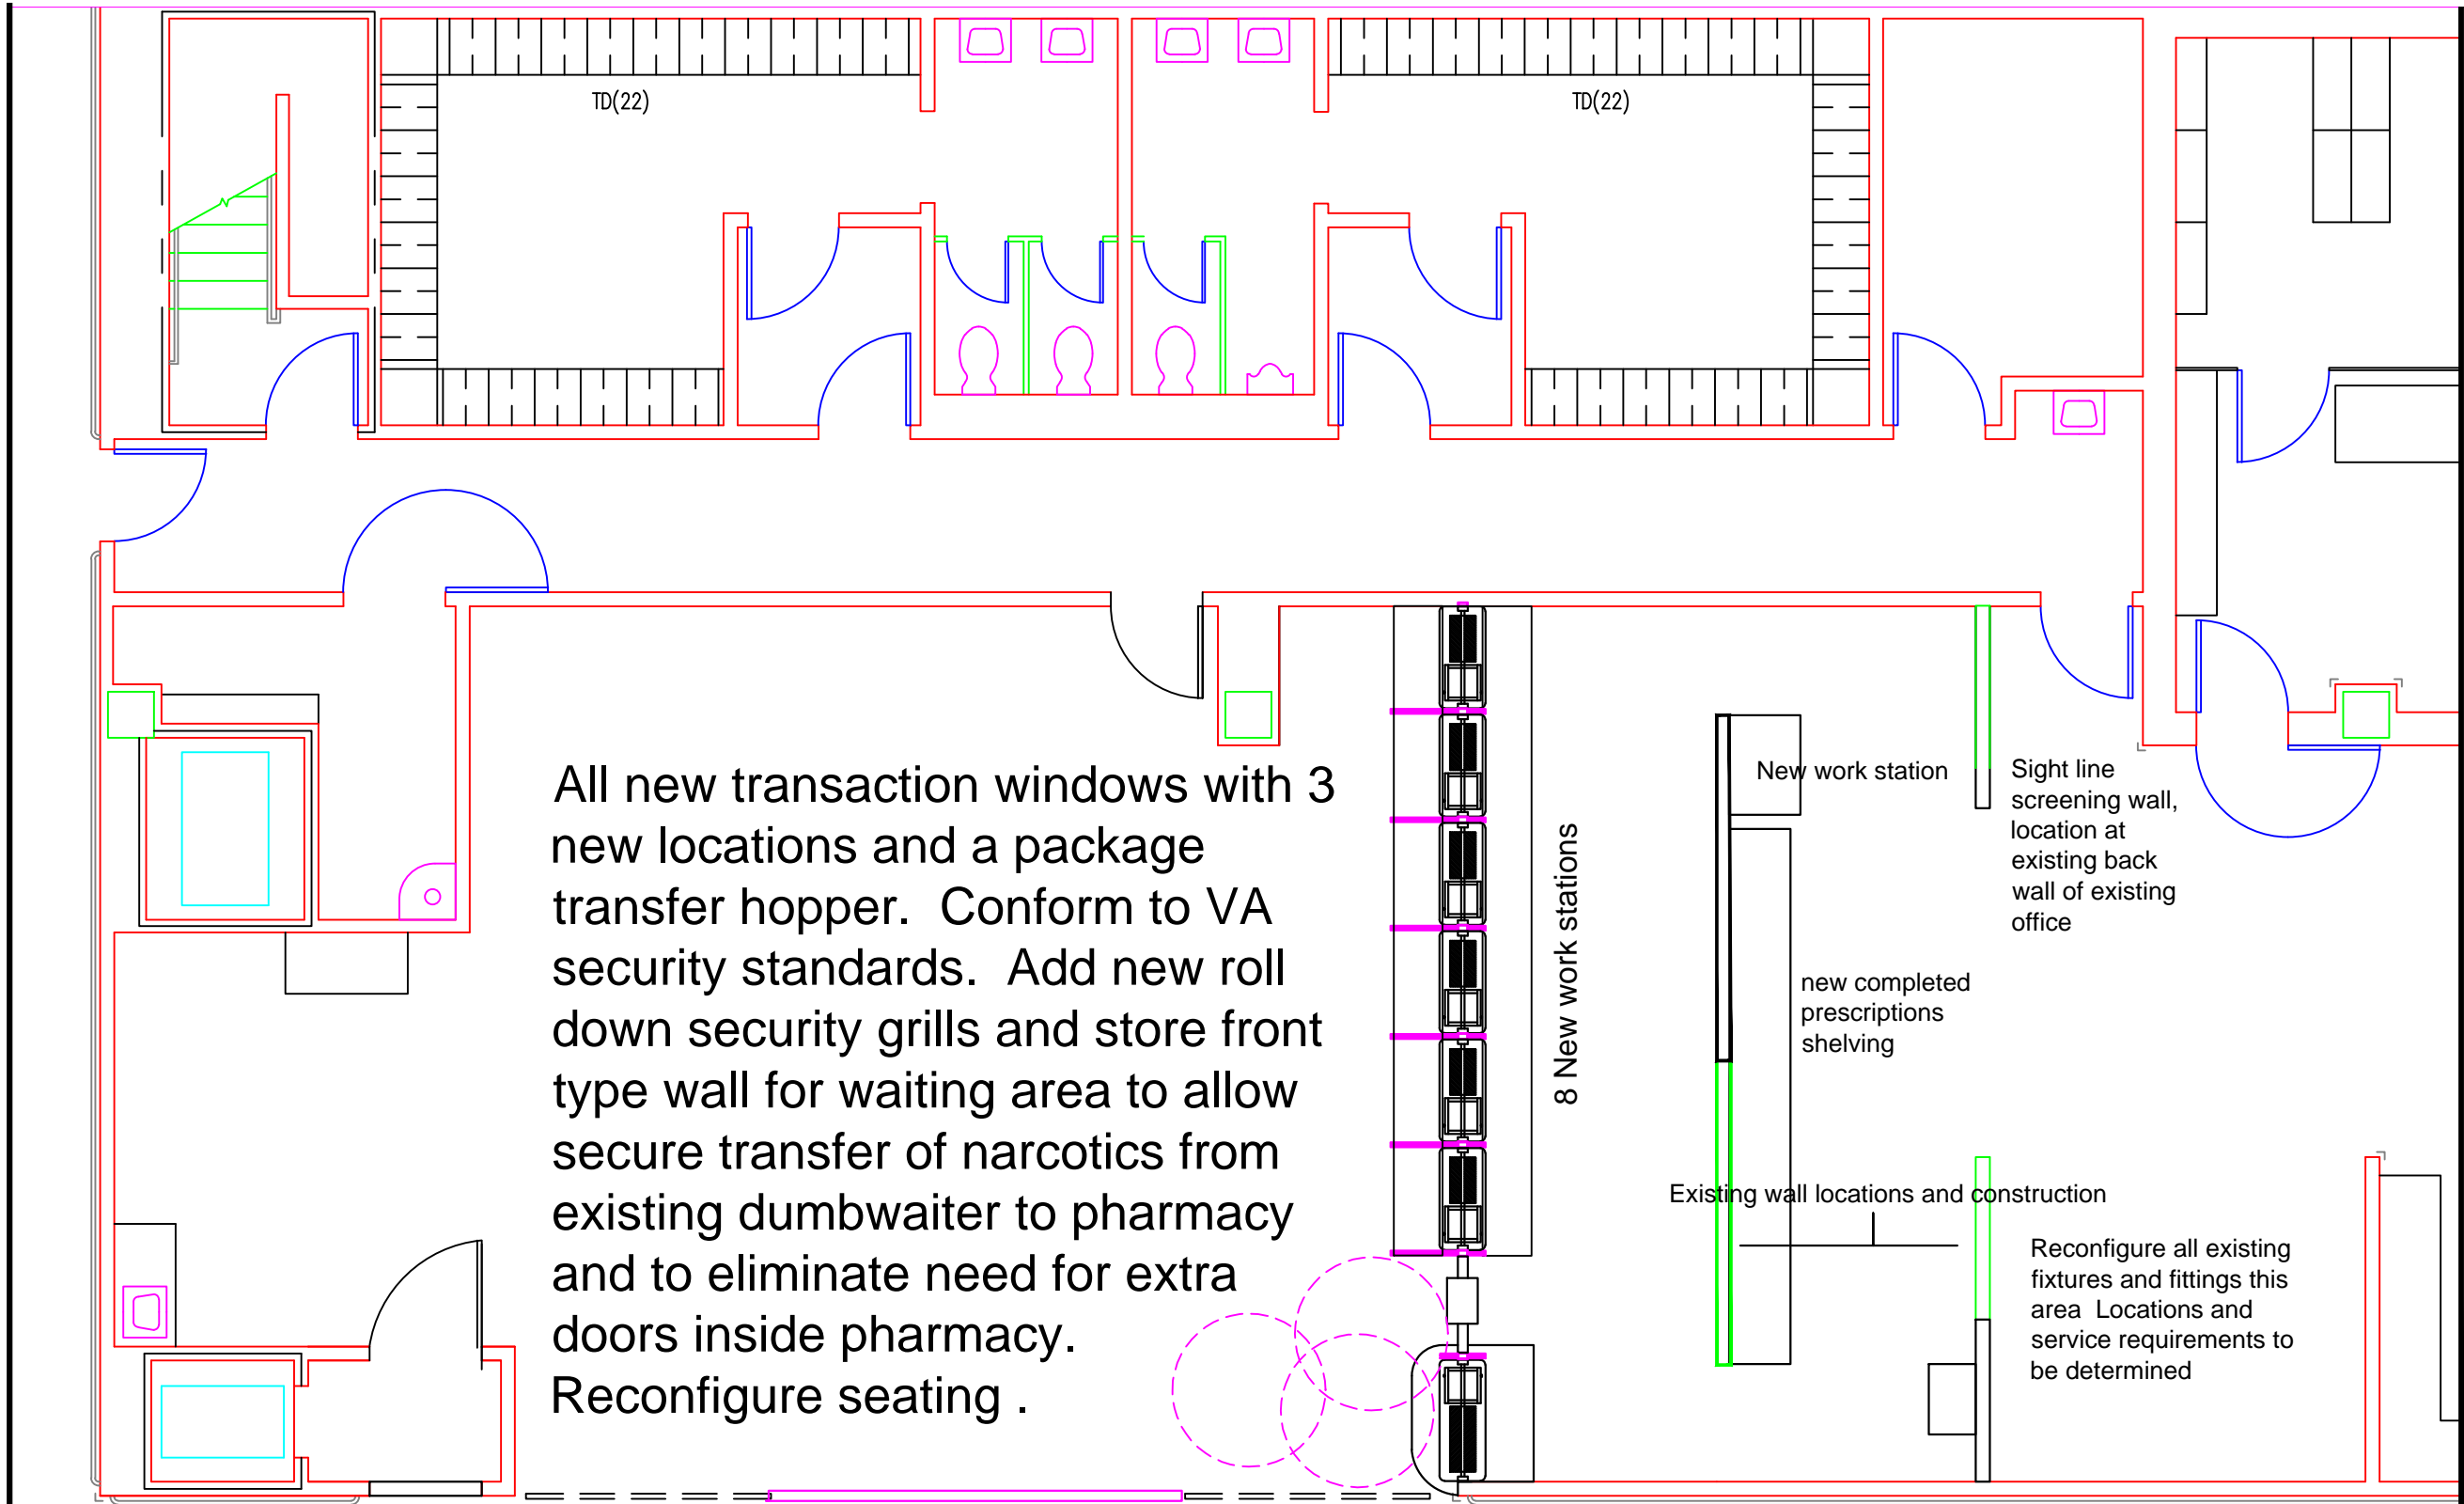


PHASE 2A

VA Department of Veterans Affairs	
VAMC, HOUSTON	
Date 28 SEPT 2011	Drawing No. XXXX
Project Title CONCEPTUAL Design PHARMACY	Building Number 100
Drawing Title CONCEPTUAL PHASES xxxxx	Location VAMC, HOUSTON TEXAS.
Approved:	Approved:





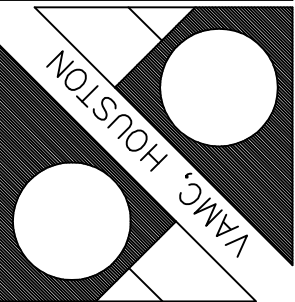


Date	28 SEPT 2011
xxx	xxx
Drawing No.	XXXX

Project Title	CONCEPTUAL Design PHARMACY
Building Number	100
Location	VAMC, HOUSTON TEXAS.
Checked	Drawn


Drawing Title	CONCEPTUAL PHASES
Approved:	xxxxx
Approved:	

New Delivery Windows
A-4-a

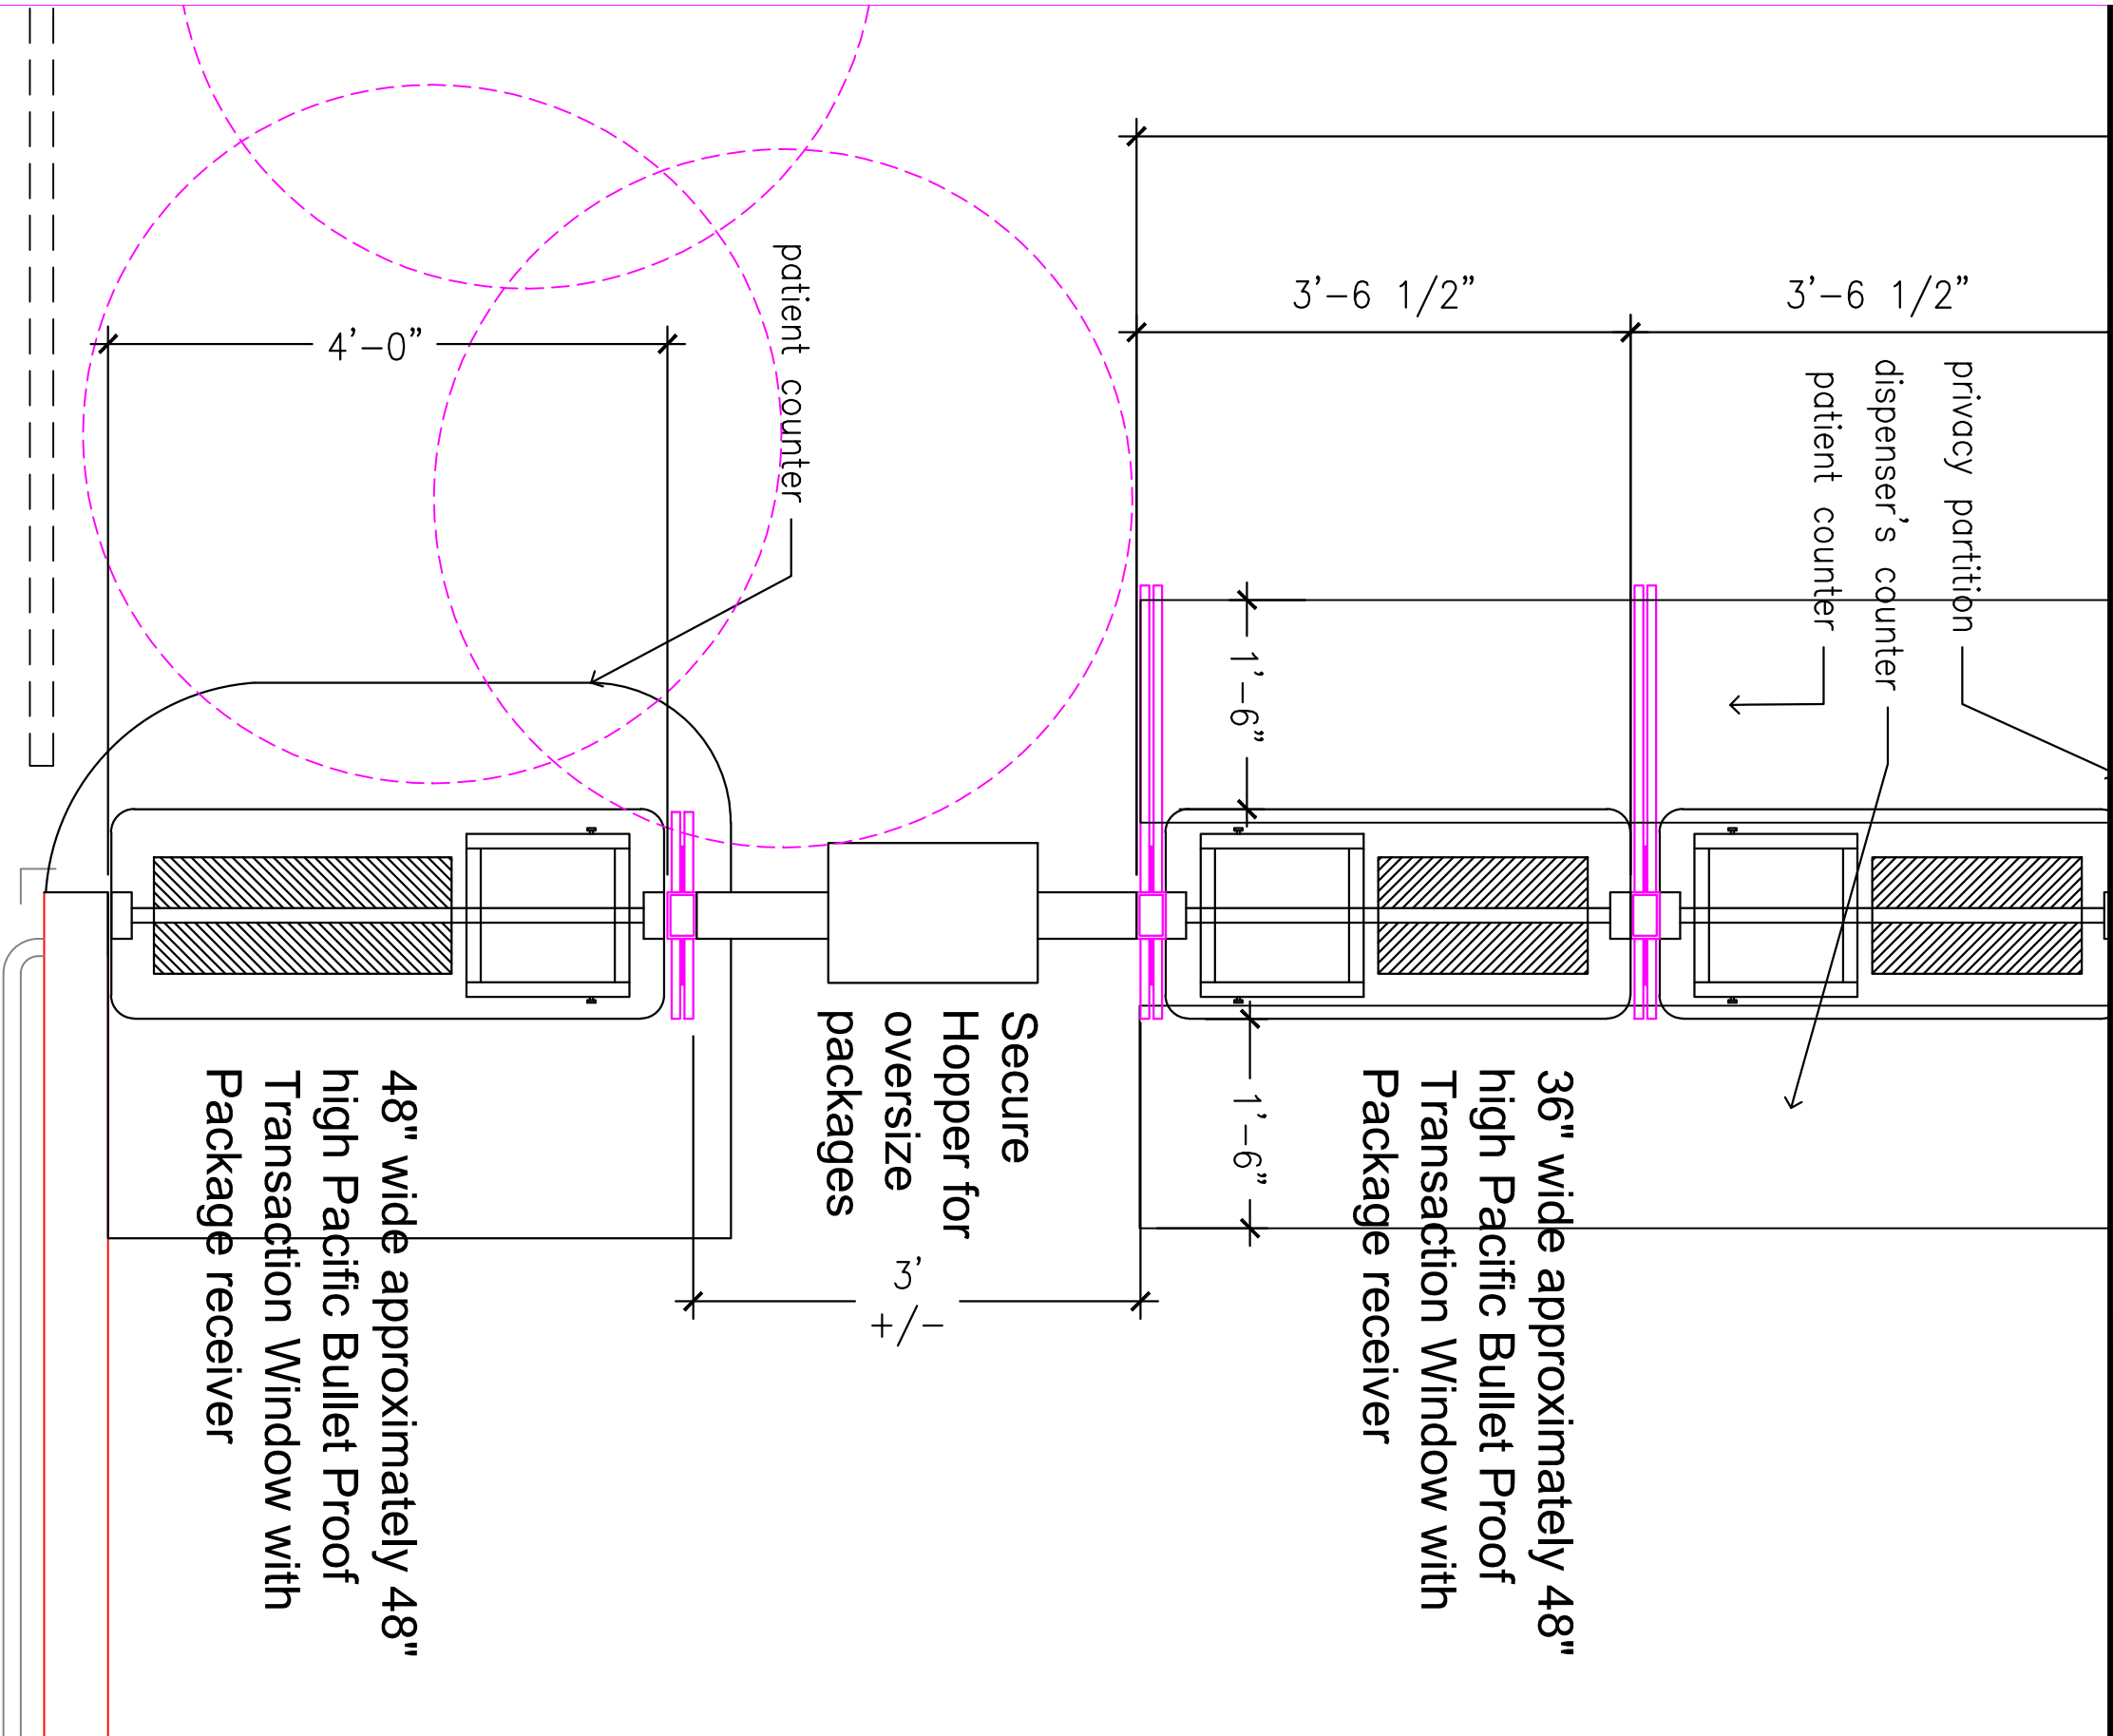


PHASE 2A



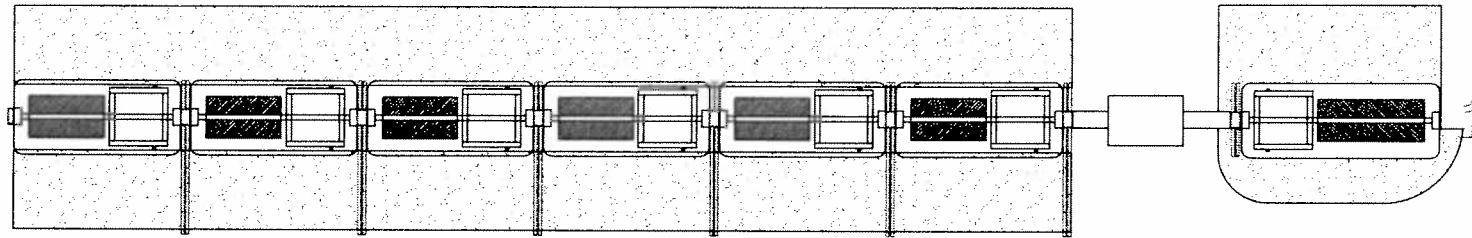


PLAN VIEW

SOLID  
SURFACE  
PARTITION  
(SSI)

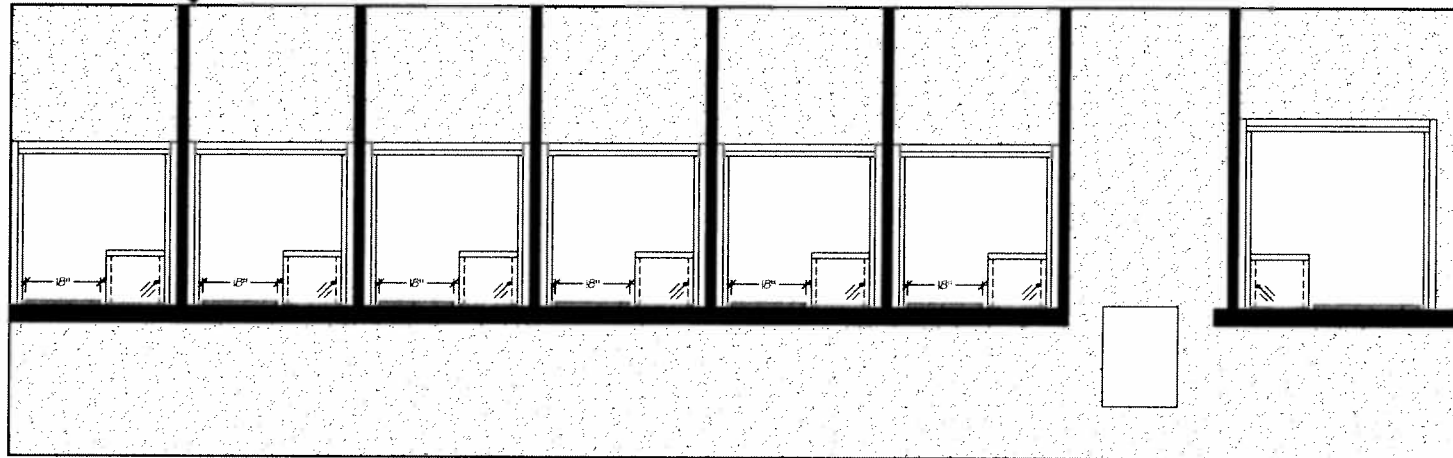


ELEVATION

TRANSACTION WINDOWS

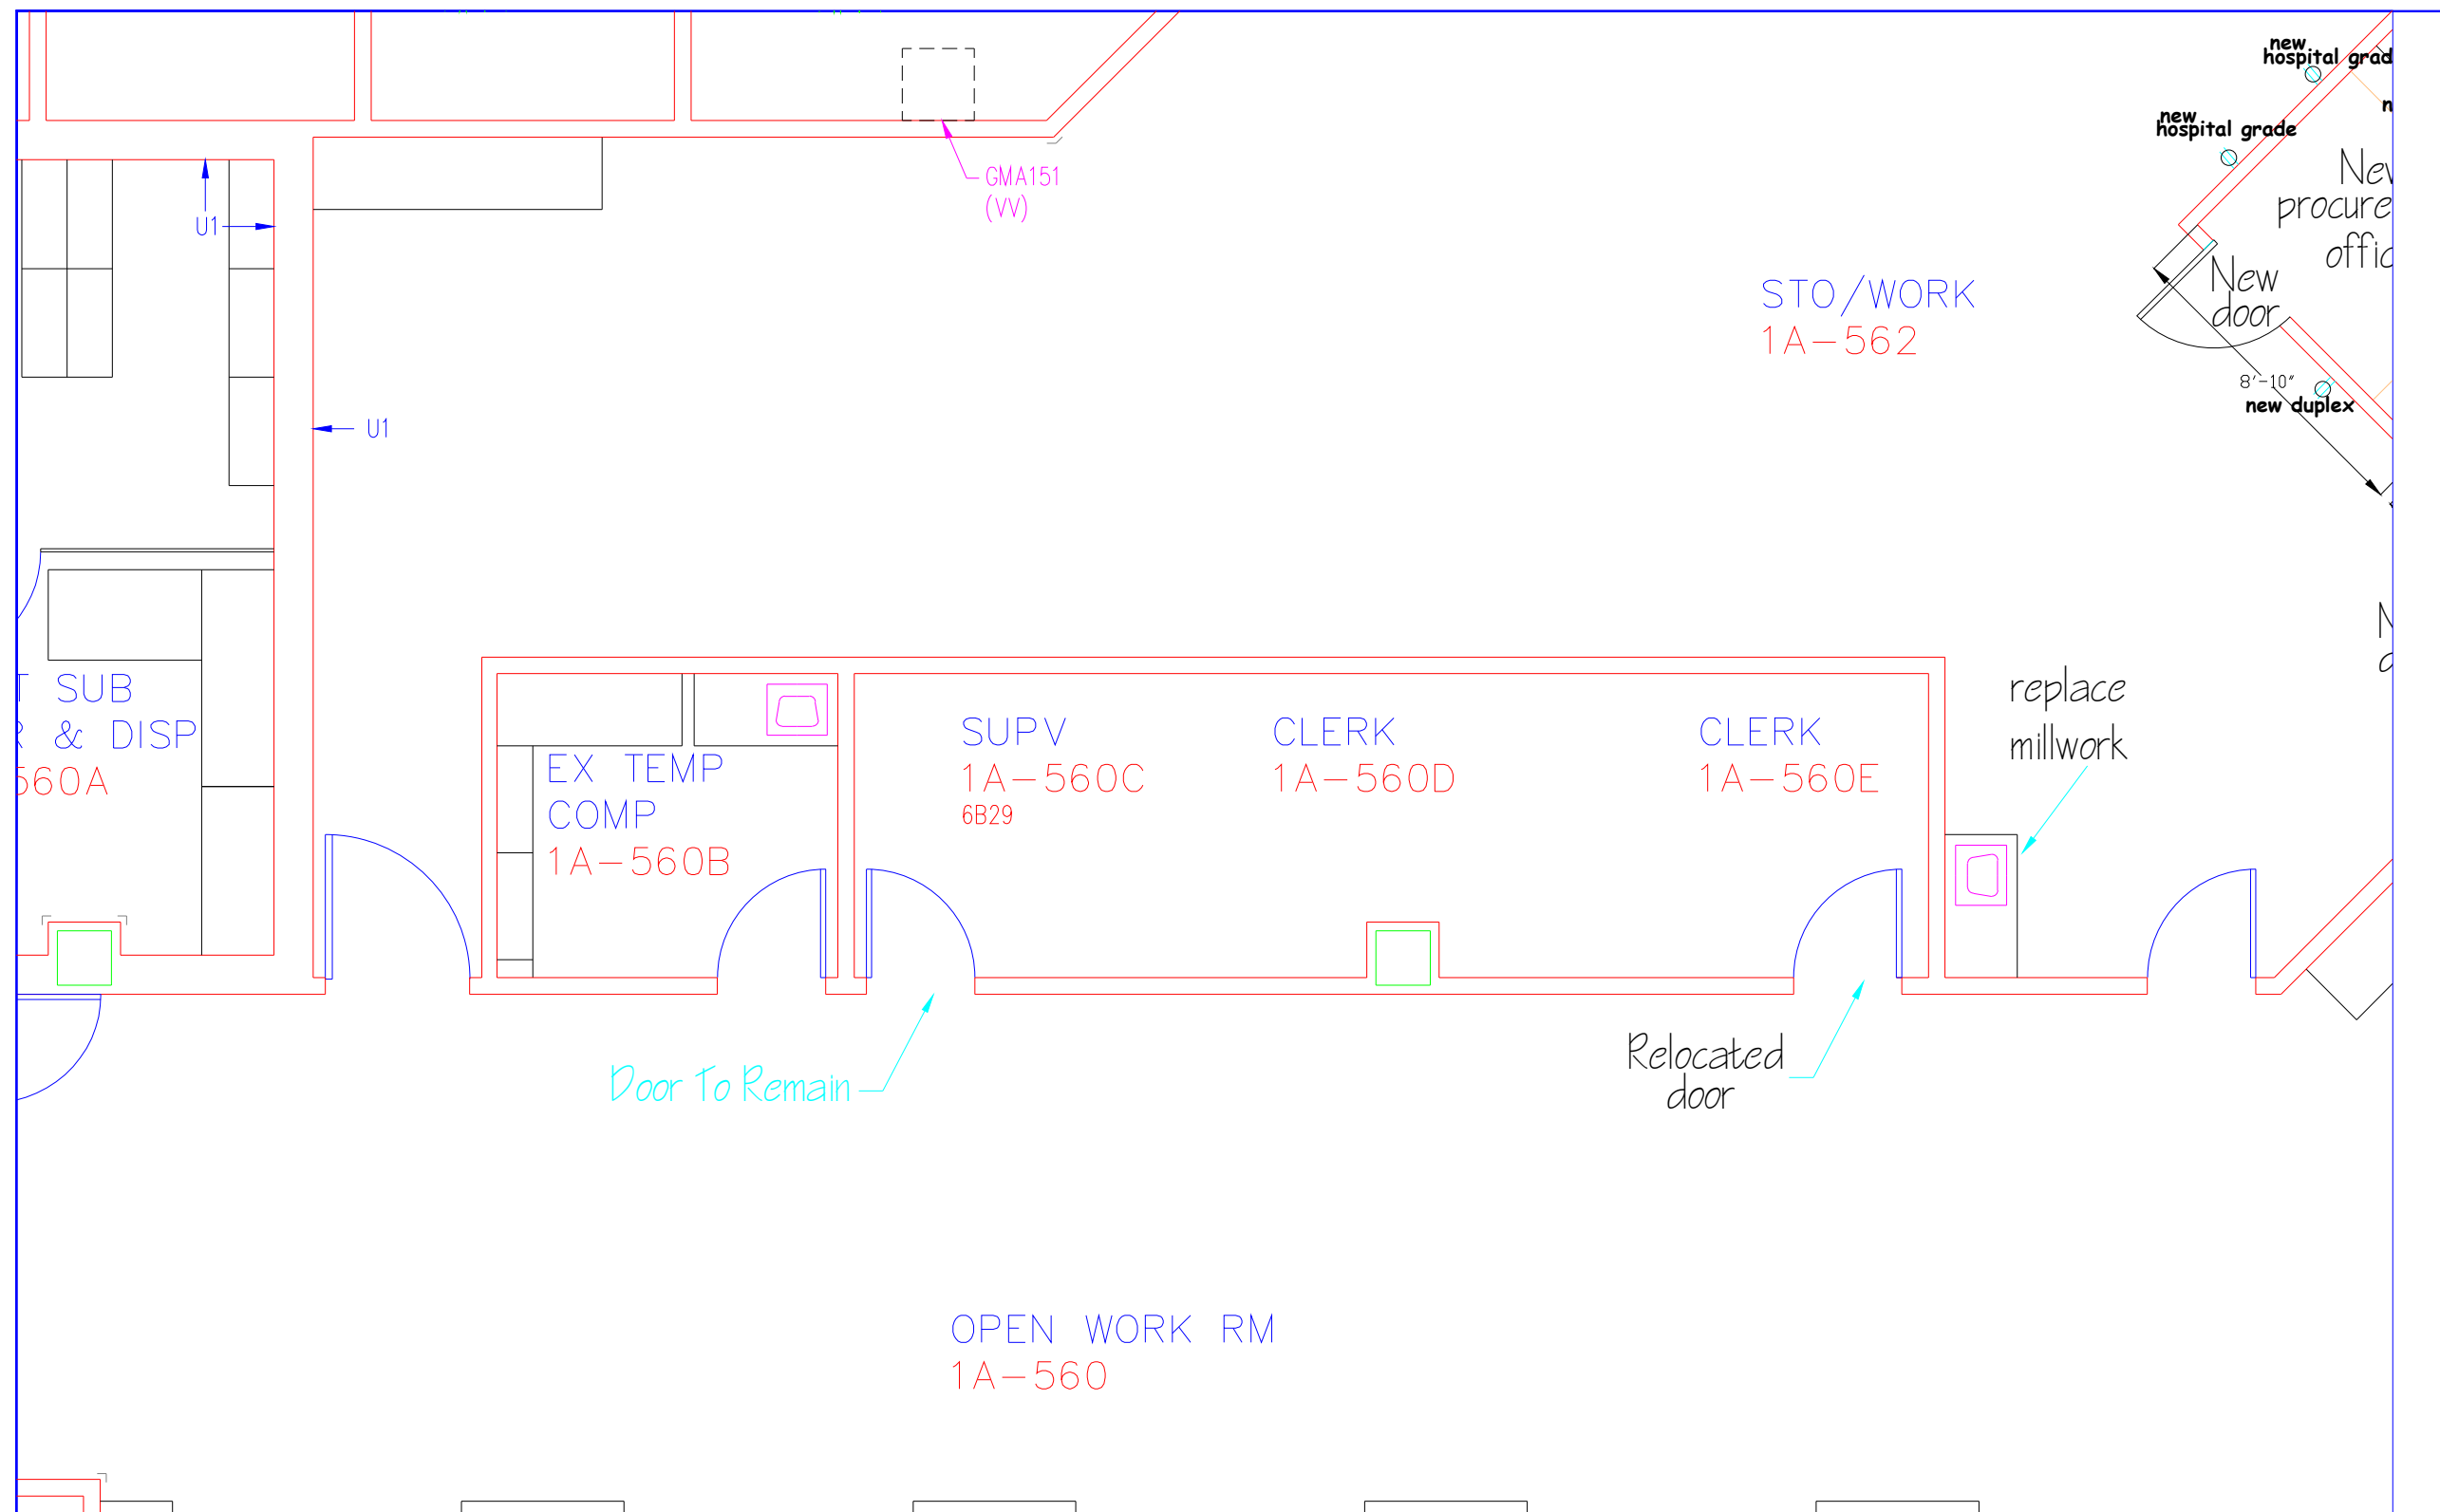

## PHASE 3A

REVISIONS 1. REVISED NO. 2 2. NO. A-05 3. NO. A-08 4. NO. A-03 5. NO. A-04 6. NO. A-05 7. NO. A-266 268. NO. A-	
---	--

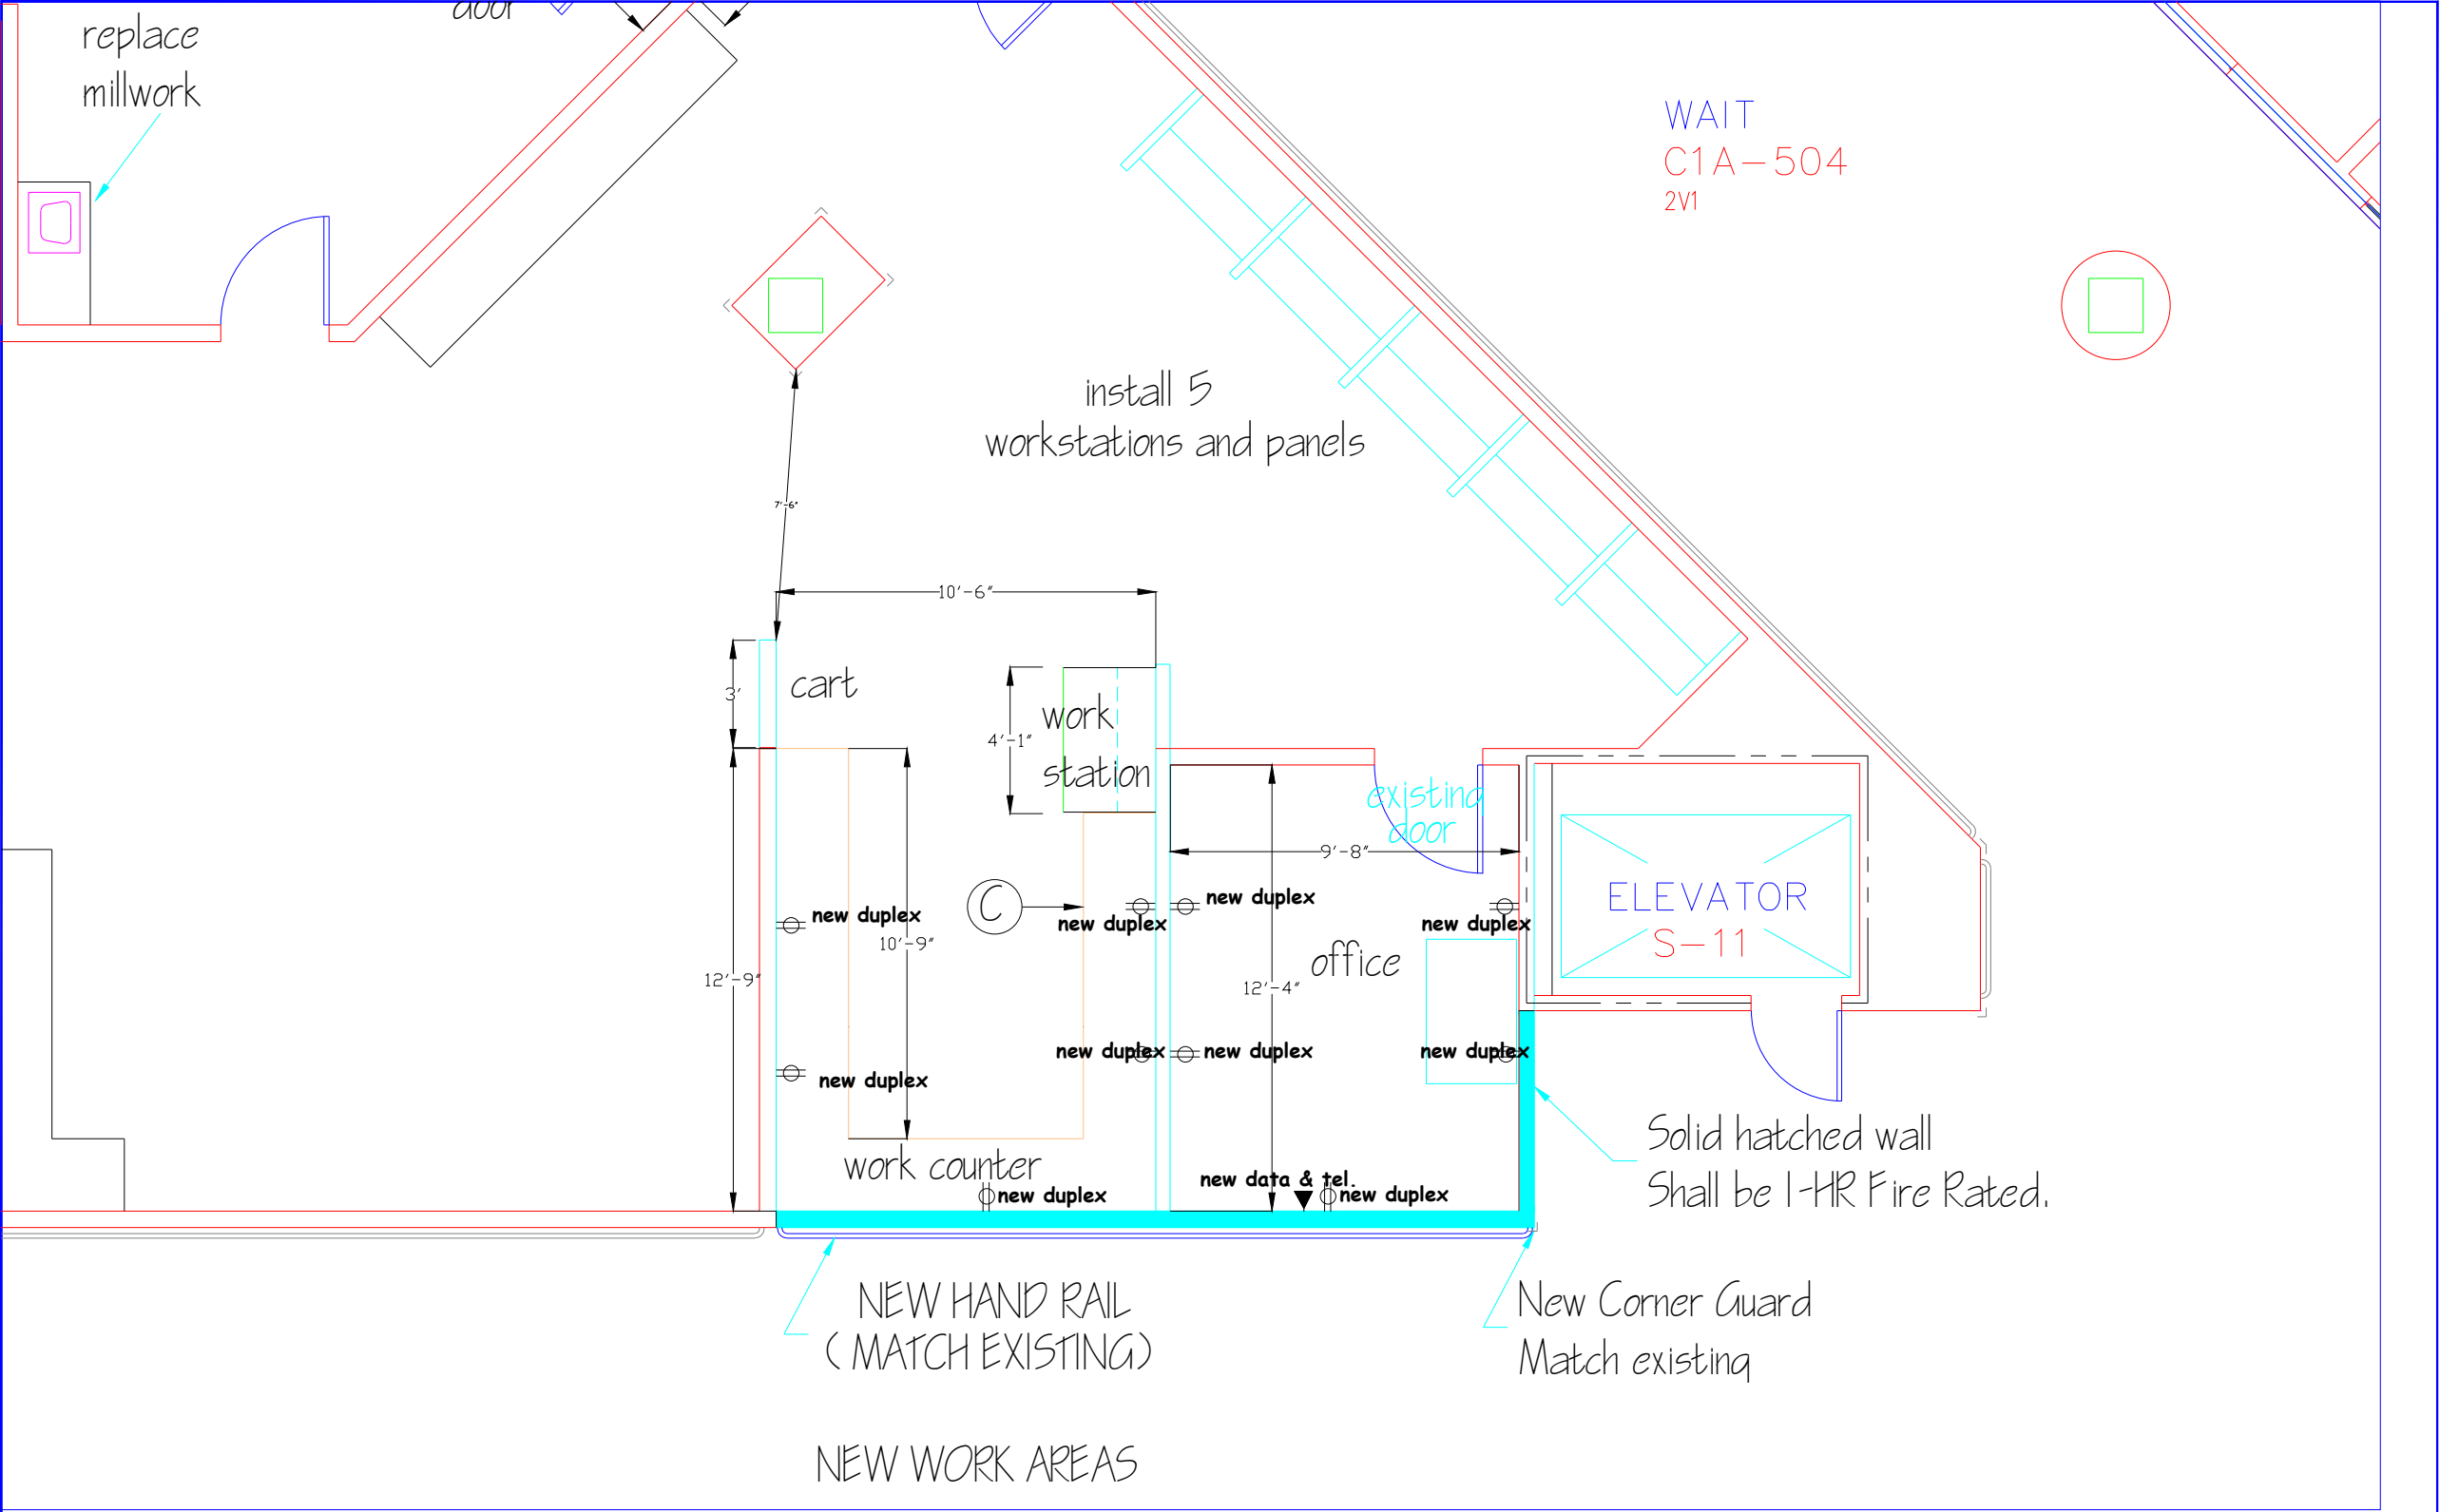

PHASE 3B

<div>REVISIONS</div> <table><tr><td>1</td><td>100-4-02</td><td>27 FEB 07</td></tr><tr><td>2</td><td>100-4-03</td><td>10 MAY 07</td></tr><tr><td>3</td><td>100-4-04</td><td>20 JUN 08</td></tr><tr><td>4</td><td>100-4-05</td><td>4 FEB 09</td></tr><tr><td>5</td><td>100-4-06</td><td>-</td></tr><tr><td>6</td><td>100-4-07</td><td>-</td></tr><tr><td>7</td><td>100-4-08</td><td>5 FEB 10</td></tr><tr><td>8</td><td>100-4-09</td><td>18 JUN 2010</td></tr></table>	1	100-4-02	27 FEB 07	2	100-4-03	10 MAY 07	3	100-4-04	20 JUN 08	4	100-4-05	4 FEB 09	5	100-4-06	-	6	100-4-07	-	7	100-4-08	5 FEB 10	8	100-4-09	18 JUN 2010	<div>DATE</div> <table><tr><td>27 FEB 07</td></tr><tr><td>10 MAY 07</td></tr><tr><td>20 JUN 08</td></tr><tr><td>4 FEB 09</td></tr><tr><td>-</td></tr><tr><td>-</td></tr><tr><td>5 FEB 10</td></tr><tr><td>18 JUN 2010</td></tr></table>	27 FEB 07	10 MAY 07	20 JUN 08	4 FEB 09	-	-	5 FEB 10	18 JUN 2010	<div>PROFESSIONAL SEAL</div> <table><tr><td></td><td></td></tr><tr><td></td><td></td></tr><tr><td></td><td></td></tr><tr><td></td><td></td></tr></table>									<div>DRAWING TITLE</div> <table><tr><td>FIRST FLOOR PLAN - AREA F</td></tr></table>	FIRST FLOOR PLAN - AREA F	<div>PROJECT TITLE</div> <table><tr><td>AS-BUILT Drawings</td></tr></table>	AS-BUILT Drawings	<div>DATE</div> <table><tr><td>30 JUL 07</td></tr></table>	30 JUL 07	<div>PROJECT NO.</div> <table><tr><td>580-040</td></tr></table>	580-040	<div>DRAWING NO.</div> <table><tr><td>100-33R</td></tr></table>	100-33R	<div>VAMC HOUSTON</div> <table><tr><td>VA Department of Veterans Affairs</td></tr></table>	VA Department of Veterans Affairs
	1	100-4-02	27 FEB 07																																																			
	2	100-4-03	10 MAY 07																																																			
	3	100-4-04	20 JUN 08																																																			
	4	100-4-05	4 FEB 09																																																			
	5	100-4-06	-																																																			
	6	100-4-07	-																																																			
	7	100-4-08	5 FEB 10																																																			
8	100-4-09	18 JUN 2010																																																				
27 FEB 07																																																						
10 MAY 07																																																						
20 JUN 08																																																						
4 FEB 09																																																						
-																																																						
-																																																						
5 FEB 10																																																						
18 JUN 2010																																																						
FIRST FLOOR PLAN - AREA F																																																						
AS-BUILT Drawings																																																						
30 JUL 07																																																						
580-040																																																						
100-33R																																																						
VA Department of Veterans Affairs																																																						
<div>Approved:</div> <table><tr><td></td></tr></table>		<div>Building Number</div> <table><tr><td>100</td></tr></table>	100	<div>Checked</div> <table><tr><td></td></tr></table>		<div>Drawn</div> <table><tr><td></td></tr></table>																																																
100																																																						
<div>Approved:</div> <table><tr><td></td></tr></table>		<div>Location</div> <table><tr><td>VAMC, HOUSTON TEXAS</td></tr></table>			VAMC, HOUSTON TEXAS																																																	
VAMC, HOUSTON TEXAS																																																						





