


FARGO VA HEALTH CARE SYSTEM REPLACE SMOKING SHELTERS

Fargo, North Dakota

Project Number: 437-13-117

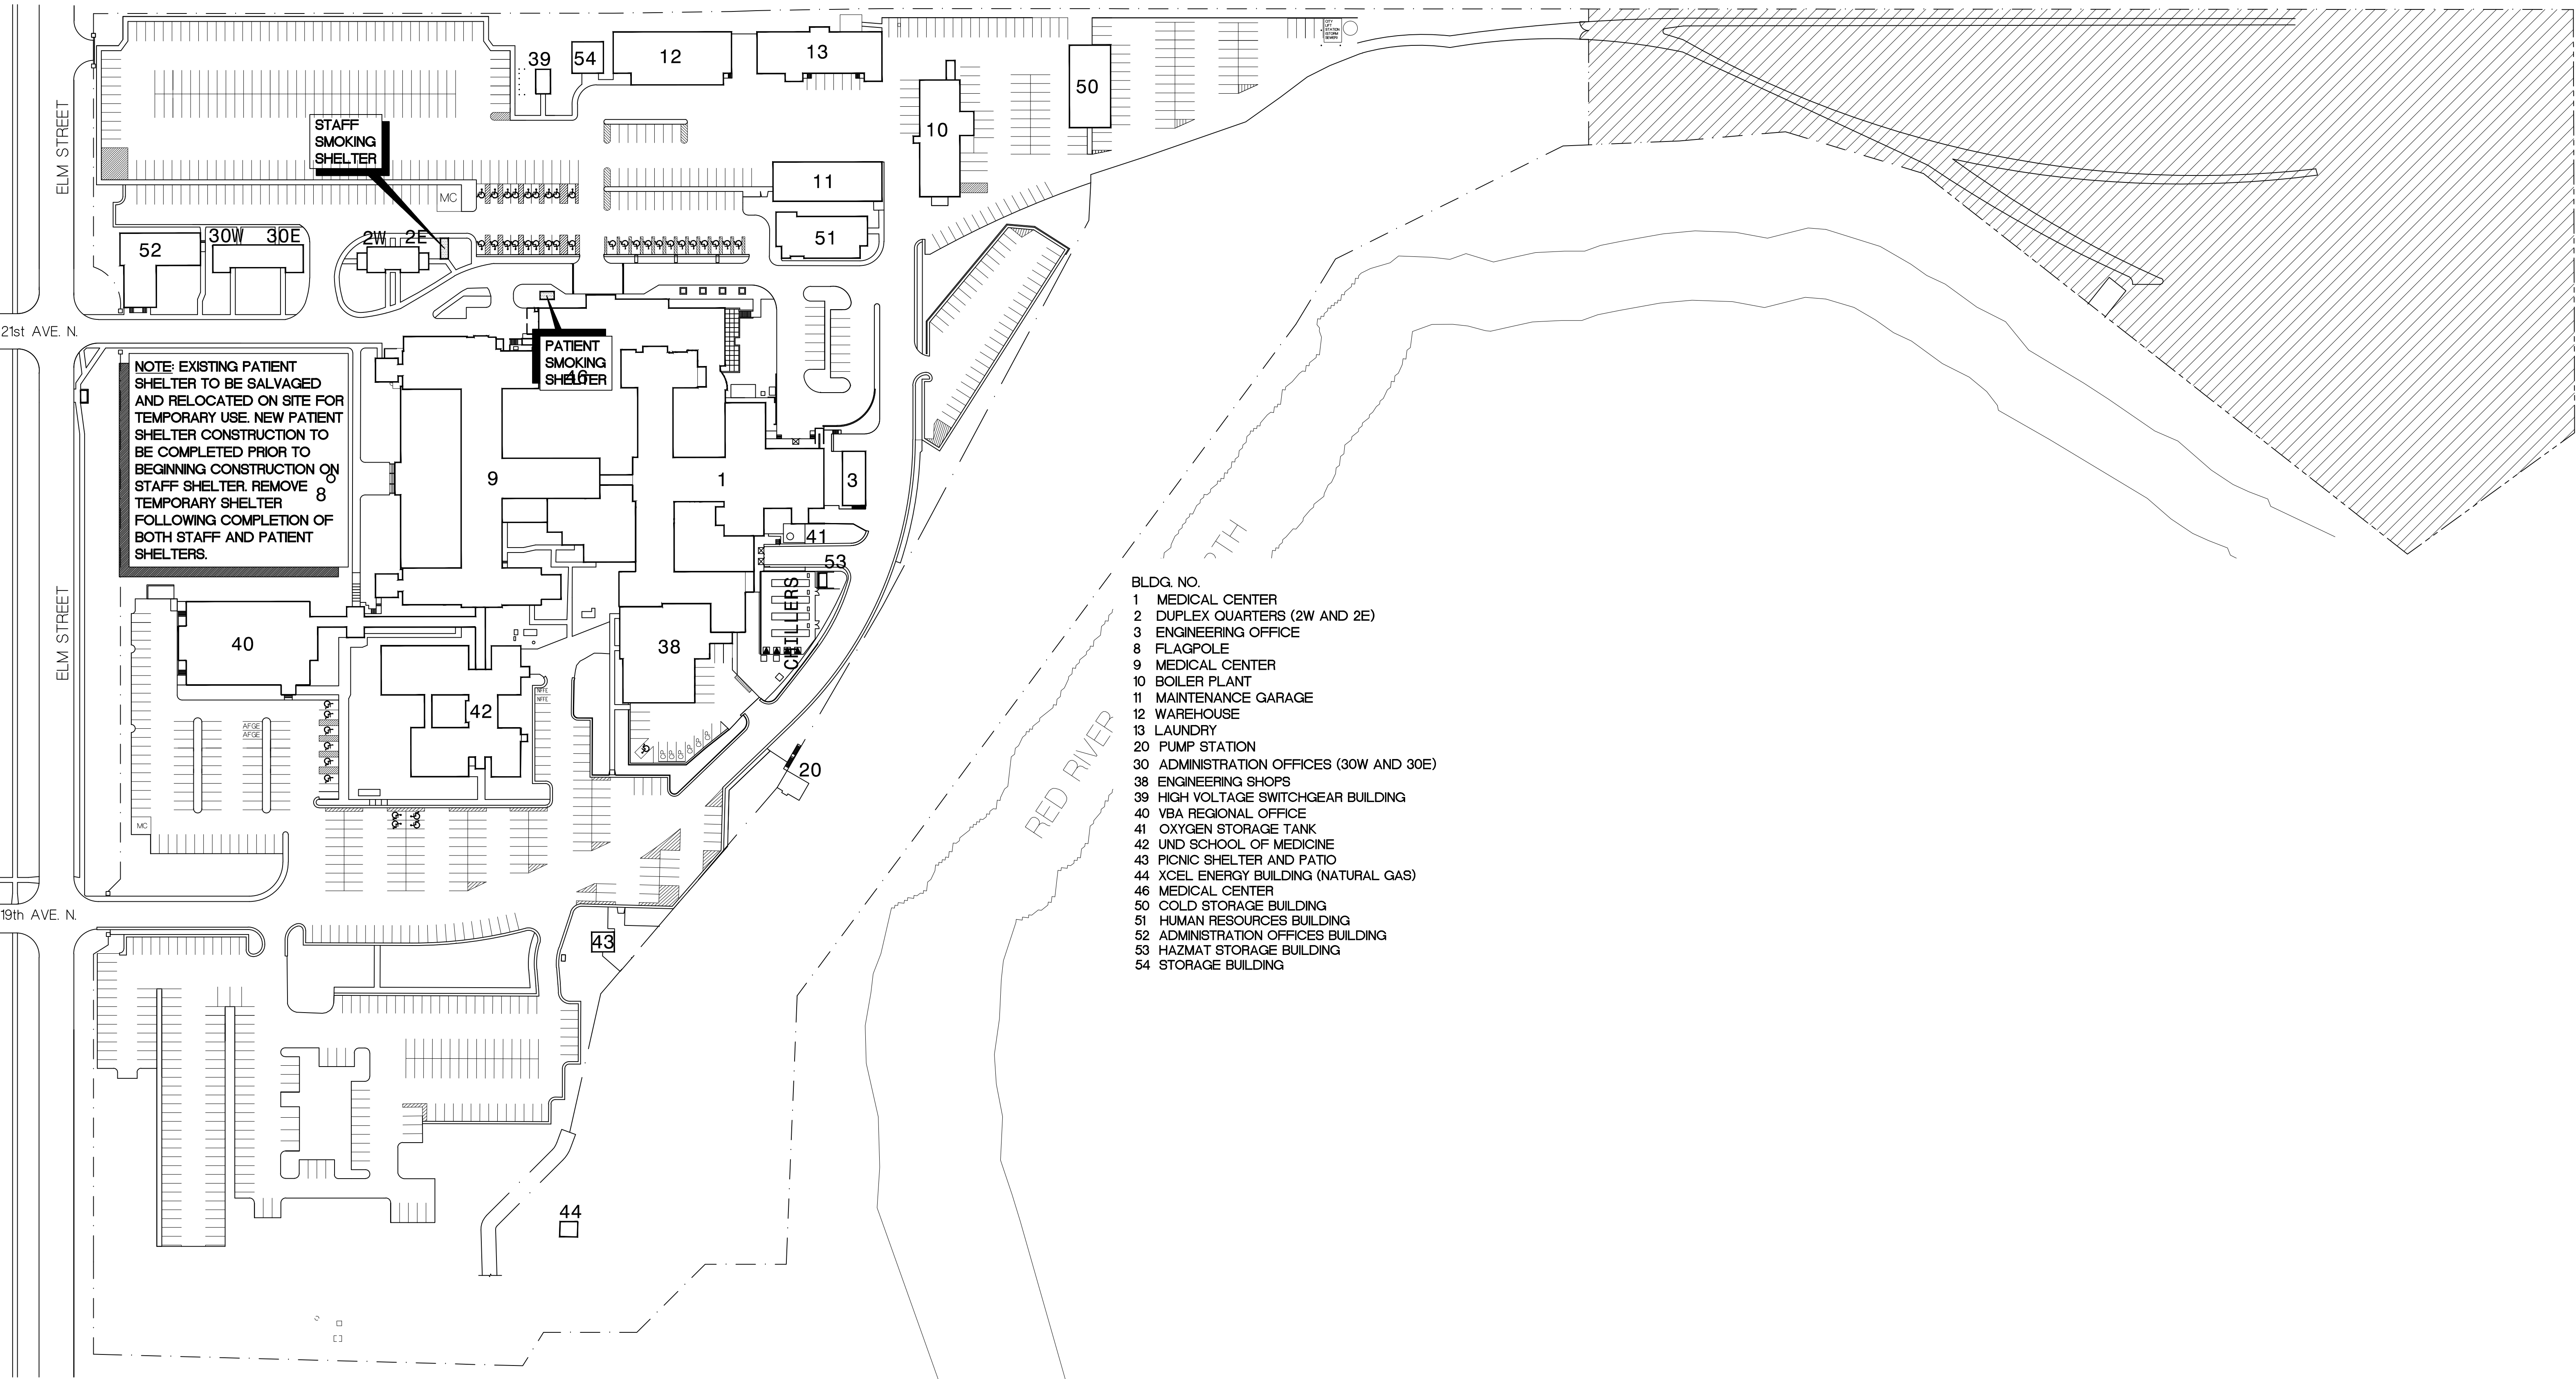

- GENERAL
- X1 COVER SHEET
- CIVIL
- C1 CIVIL PLANS AND DETAILS
- ARCHITECTURAL
- A1 SITE PLANS
- A2 FLOOR PLANS AND ELEVATIONS
- MECHANICAL
- H1 MECHANICAL SITE PLAN AND SCHEDULES
- ELECTRICAL
- E1 ELECTRICAL DEMOLITION PLANS
- E2 ELECTRICAL REMODELING PLANS

- KEY TO SITE PLAN
- CONTRACTOR STAGING AREA. SHARED WITH VA AND OTHER CONTRACTORS.
- CONSTRUCTION AREA

SITE PLAN

1"=80'-0"

- PHASING LEGEND:
- PHASE 1: PREPARE TEMPORARY UTILITY FEEDS TO TEMPORARY SHELTER LOCATION. NOTIFY AND DEMONSTRATE TO PROJECT ENGINEER THAT MATERIALS AND EQUIPMENT ARE ON SITE TO MOVE PATIENT SHELTER TO TEMPORARY LOCATION. UPON PROJECT ENGINEER'S AUTHORIZATION DISCONNECT, RELOCATE AND RECONNECT EXISTING PATIENT SHELTER TO TEMPORARY UTILITIES AND HAVE FULLY OPERATIONAL WITHIN 24 HOURS.
- PHASE 2: BEGIN CONSTRUCTION OF NEW PATIENT SMOKING SHELTER. PATIENTS TO UTILIZE TEMPORARY SMOKING SHELTER UNTIL COMPLETION. STAFF SMOKING SHELTER TO REMAIN OPERATIONAL AT EXISTING LOCATION FOR STAFF ONLY.
- PHASE 3: BEGIN CONSTRUCTION OF NEW STAFF SMOKING SHELTER FOLLOWING COMPLETION OF NEW PATIENT SMOKING SHELTER. STAFF TO UTILIZE TEMPORARY SMOKING SHELTER UNTIL COMPLETION. PATIENTS TO UTILIZE NEW PATIENT SMOKING SHELTER ONLY.
- PHASE 4: REMOVE TEMPORARY SMOKING SHELTER FOLLOWING COMPLETION OF BOTH NEW STAFF AND PATIENT SMOKING SHELTERS. DISCONNECT AND REMOVE TEMPORARY SERVICE FEEDS. REFER TO ELECTRICAL DRAWINGS FOR DETAILS. PATCH TO MATCH ANY SITE DAMAGE INCURRED DURING CONSTRUCTION.



Dept. of Veterans Affairs  
Health Care System  
2101 Elm Street North  
Fargo, ND 58102



IMAGE GROUP INC.  
403 CENTER AVENUE, SUITE 300  
MOORHEAD, MN 56560

IMAGE GROUP INC., Architecture & Interiors  
OBERMILLER NELSON ENGINEERING, Mechanical Engineers  
MEN ENGINEERING, Civil and Electrical Engineers

I hereby certify that this plan specification, or report was prepared by me or under my direct supervision, and that I am duly Registered Architect under the laws of the State of North Dakota.

Date 5/8/2013 Reg. No. 378

Drawing Title COVER SHEET		Project Title FARGO VA HEALTH CARE SYSTEM REPLACE SMOKING SHELTERS		Date MAY 8, 2013
VA Project No. 437-13-117	Contract No. VA263-P-1217 VA263-C-	Designed By RM	Checked By RM	Drawn By MO
Building No. SITE	AutoCAD File Name Cover.dwg	Location FARGO VA HEALTH CARE SYSTEM FARGO, ND	Drawing No. X1	Dwg. 1 of 7

