


# VA MEDICAL CENTER HUNTINGTON, WV

PROJECT NO: 13-109  
RESURFACE ROADS PHASE 2 & SITE LIGHTING

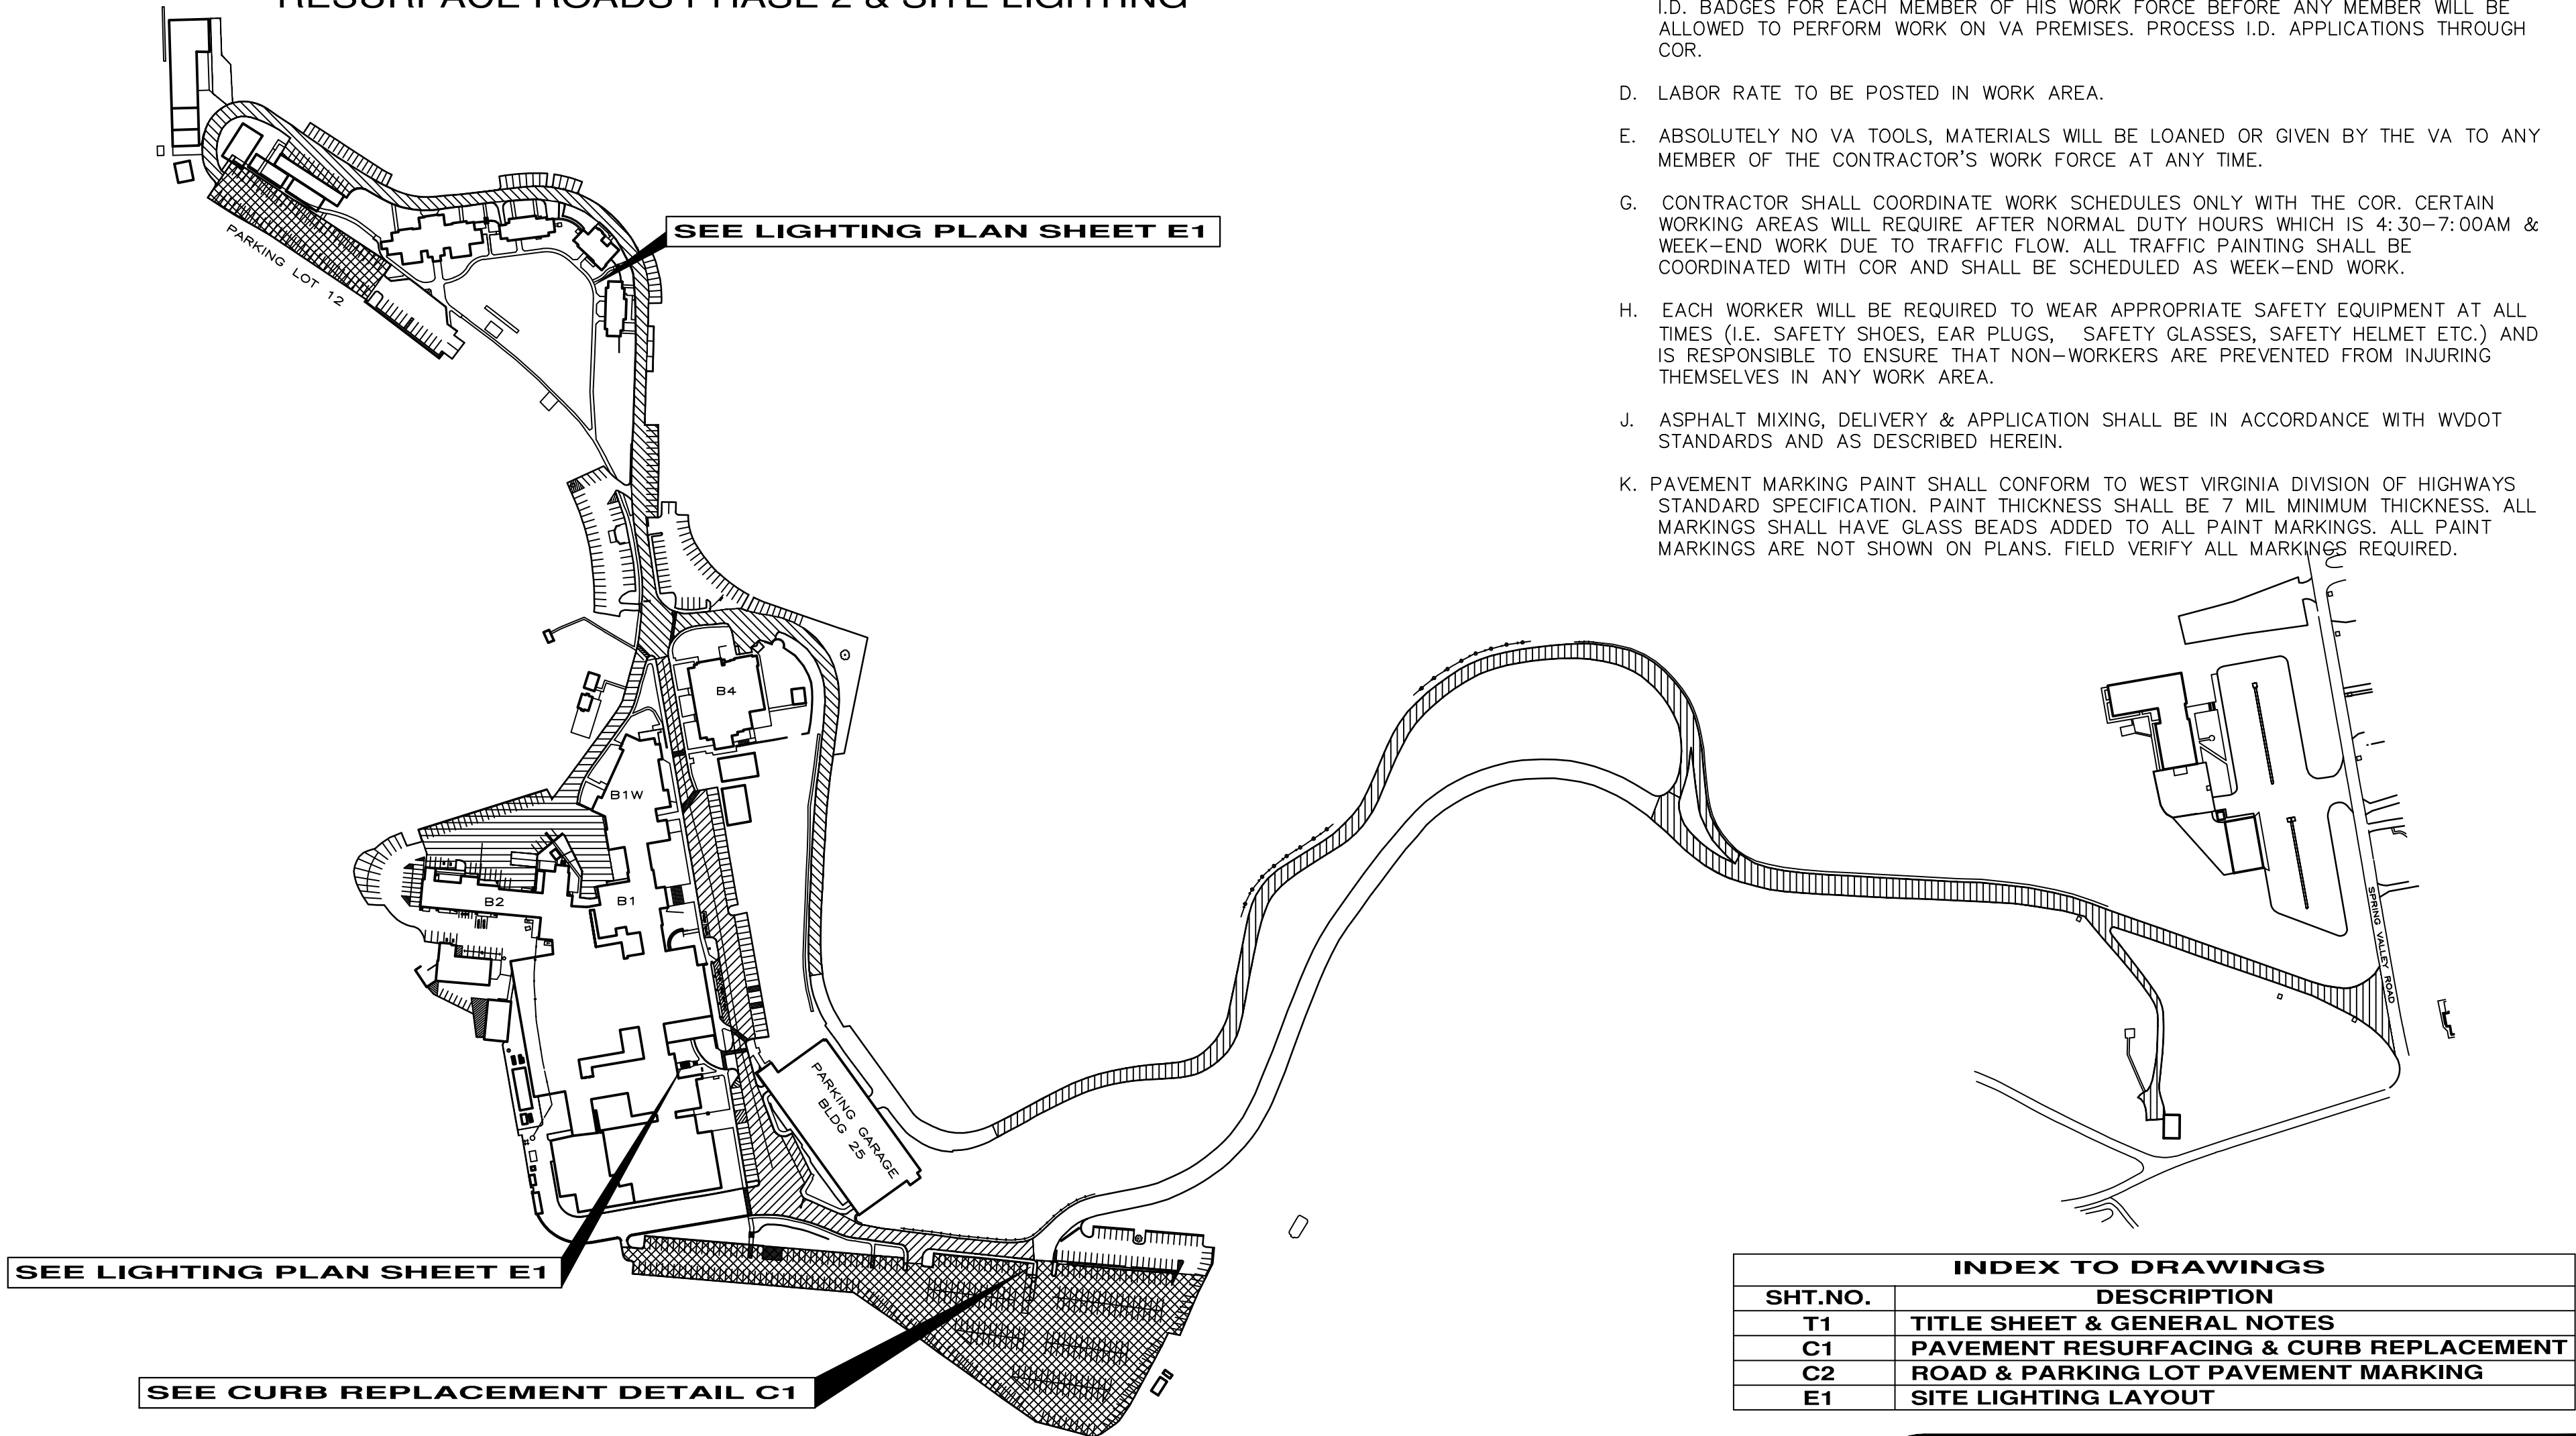

## GENERAL NOTES

- CONTRACTOR SHALL VERIFY WORK AREA CONDITIONS AND REQUIREMENTS. PROVIDE SUBMITTALS OF ALL PRODUCTS UNLESS BRAND SPECIFIED HEREIN.
- ALL TOOLS USED IN THIS PROJECT SHALL BE PROPERLY SECURED AT ALL TIMES BY THE CONTRACTOR TO PREVENT ANY OF THESE TOOLS BEING A HAZARD TO PATIENTS.
- THE CONTRACTOR AT HIS EXPENSE WILL BE RESPONSIBLE FOR ACQUIRING VA PICTURE I.D. BADGES FOR EACH MEMBER OF HIS WORK FORCE BEFORE ANY MEMBER WILL BE ALLOWED TO PERFORM WORK ON VA PREMISES. PROCESS I.D. APPLICATIONS THROUGH COR.
- LABOR RATE TO BE POSTED IN WORK AREA.
- ABSOLUTELY NO VA TOOLS, MATERIALS WILL BE LOANED OR GIVEN BY THE VA TO ANY MEMBER OF THE CONTRACTOR'S WORK FORCE AT ANY TIME.
- CONTRACTOR SHALL COORDINATE WORK SCHEDULES ONLY WITH THE COR. CERTAIN WORKING AREAS WILL REQUIRE AFTER NORMAL DUTY HOURS WHICH IS 4:30-7:00AM & WEEK-END WORK DUE TO TRAFFIC FLOW. ALL TRAFFIC PAINTING SHALL BE COORDINATED WITH COR AND SHALL BE SCHEDULED AS WEEK-END WORK.
- EACH WORKER WILL BE REQUIRED TO WEAR APPROPRIATE SAFETY EQUIPMENT AT ALL TIMES (I.E. SAFETY SHOES, EAR PLUGS, SAFETY GLASSES, SAFETY HELMET ETC.) AND IS RESPONSIBLE TO ENSURE THAT NON-WORKERS ARE PREVENTED FROM INJURING THEMSELVES IN ANY WORK AREA.
- ASPHALT MIXING, DELIVERY & APPLICATION SHALL BE IN ACCORDANCE WITH WVDOT STANDARDS AND AS DESCRIBED HEREIN.
- PAVEMENT MARKING PAINT SHALL CONFORM TO WEST VIRGINIA DIVISION OF HIGHWAYS STANDARD SPECIFICATION. PAINT THICKNESS SHALL BE 7 MIL MINIMUM THICKNESS. ALL MARKINGS SHALL HAVE GLASS BEADS ADDED TO ALL PAINT MARKINGS. ALL PAINT MARKINGS ARE NOT SHOWN ON PLANS. FIELD VERIFY ALL MARKINGS REQUIRED.

INDEX TO DRAWINGS	
SHT.NO.	DESCRIPTION
T1	TITLE SHEET & GENERAL NOTES
C1	PAVEMENT RESURFACING & CURB REPLACEMENT
C2	ROAD & PARKING LOT PAVEMENT MARKING
E1	SITE LIGHTING LAYOUT

UNITED STATES DEPARTMENT OF VETERANS AFFAIRS VA MEDICAL CENTER - 1540 SPRING VALLEY DRIVE - HUNTINGTON WV 25704			
DRAWING TITLE: <b>TITLE SHEET, GEN. NOTES INDEX &amp; SITE PLAN</b>		PROJECT TITLE: <b>RESURFACE ROADS PH 2 &amp; SITE LIGHTING</b>	
APPROVED: CHRIS ECKLES ASST. CHIEF, ENGINEERING		BUILDING: -	PROJECT NUMBER: 13-109
APPROVED: JOHN KLIM CHIEF, ENGINEERING		DRAWN: STEVE ELROD	DATE: JAN '13
			DRAWING NUMBER: <b>T1</b> DWG.