



REFERENCE NOTES:

- ① ADD ONE SPRINKLER HEAD TO CONFERENCE ROOM. THE ROOM AREA IS 295 SF - TOO LARGE FOR A SINGLE SPRINKLER HEAD.
- ② REPLACE THE TEST AND DRAIN VALVE FOR ZONE 1-9-3.
- ③ MOVE SPRINKLER HEAD FROM ABOVE THE ICE MACHINE INTO THE MIDDLE AREA OF ROOM 9W-13. PATCH AND PAINT THE GYPSUM CEILING IN THIS ROOM. RE-PAINT THE ENTIRE CEILING.

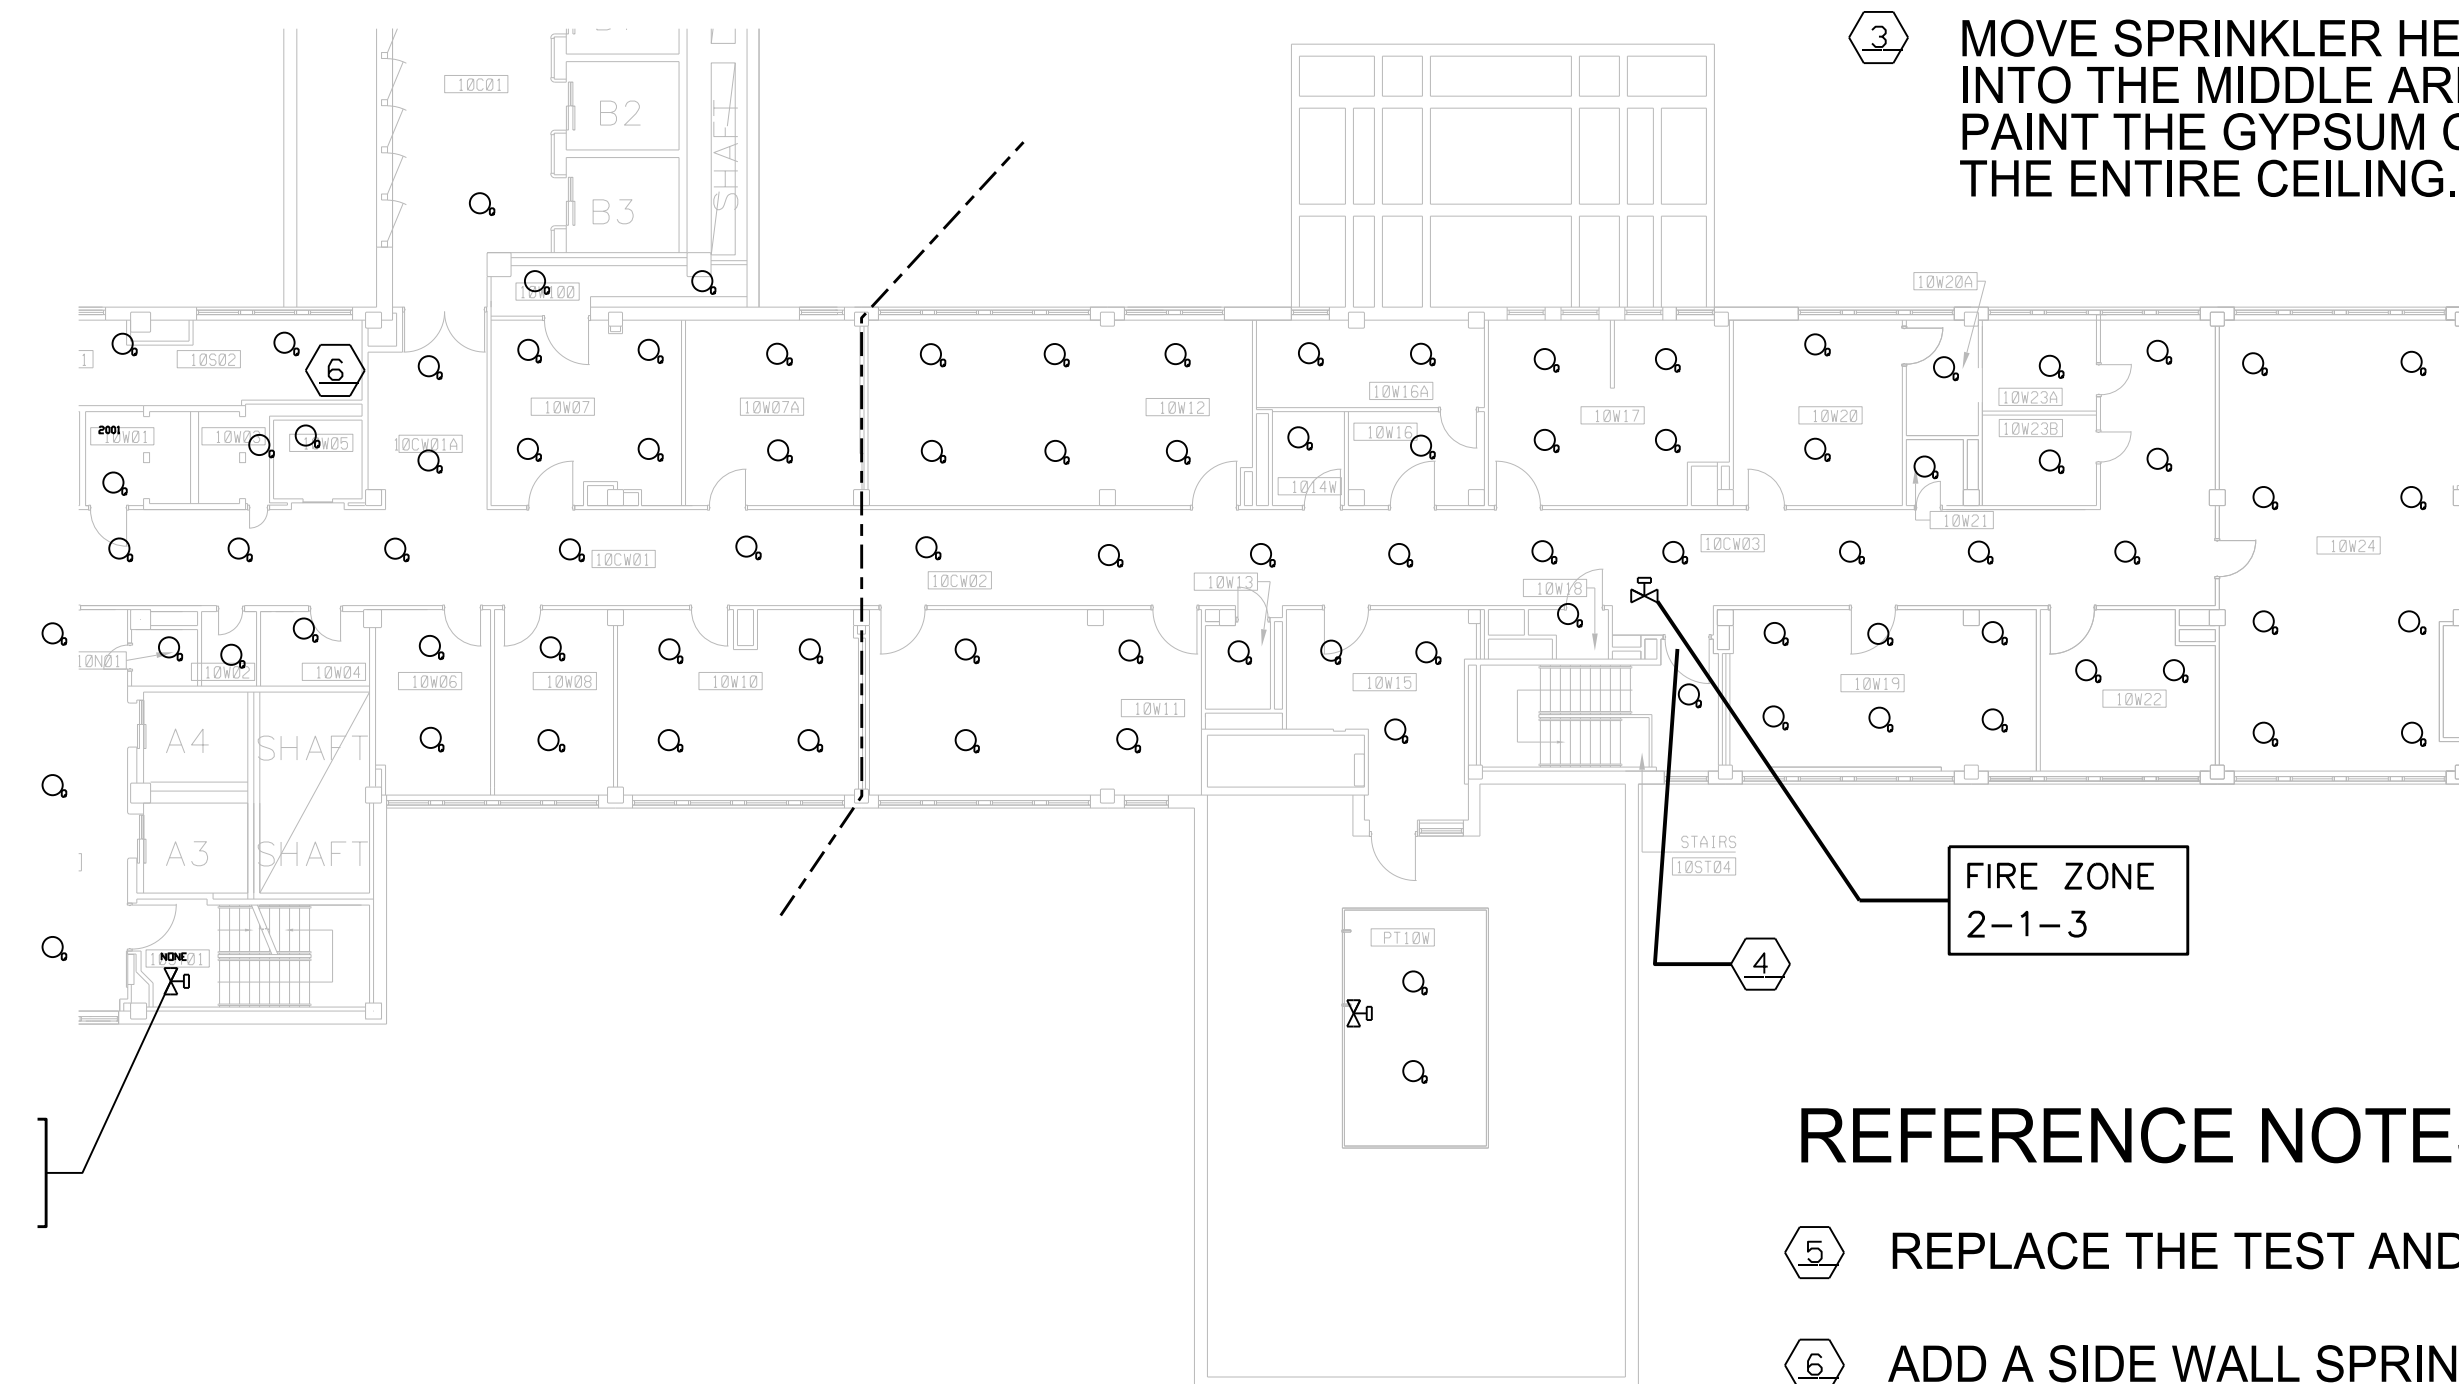

REFERENCE NOTES:

5. REPLACE THE TEST AND DRAIN VALVE FOR ZONE 2-1-3.
6. ADD A SIDE WALL SPRINKLER HEAD IN THE BULKHEAD FOR THE ACCESS DOOR TO THE ELEVATOR.

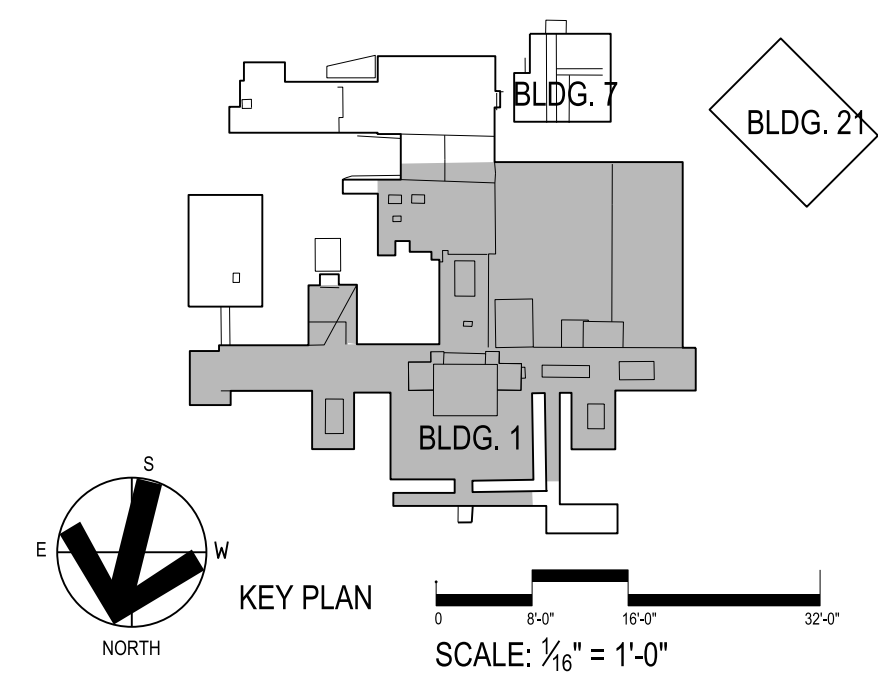[illegible]

HEERY

Heery International Inc.
125 South Dubuque Street,
Suite 500,
Iowa City, IA 52240-4003
319-354-4700

project number
11-25505

DRAWING TITLE
**FIRE SPRINKLER PLAN
LEVEL 9 & 10**

PROJECT TITLE	REPLACE SPRINKLER HEADS
---------------	--------------------------------

BUILDING NO.

LOCATION
ICVA HEALTH CARE SYSTEM

DATE **05/21/2013**

PROJECT NO.
636A8-13-001

DRAWING NO.
1-F8

DWG. 9 OF 9



DEPARTMENT OF
VETERANS AFFAIRS