


three inches = one foot  
one and one-half inch = one foot  
one inch = one foot  
three-quarters inch = one foot  
one-half inch = one foot  
three-eighths inch = one foot  
one-quarter inch = one foot  
one-eighth inch = one foot

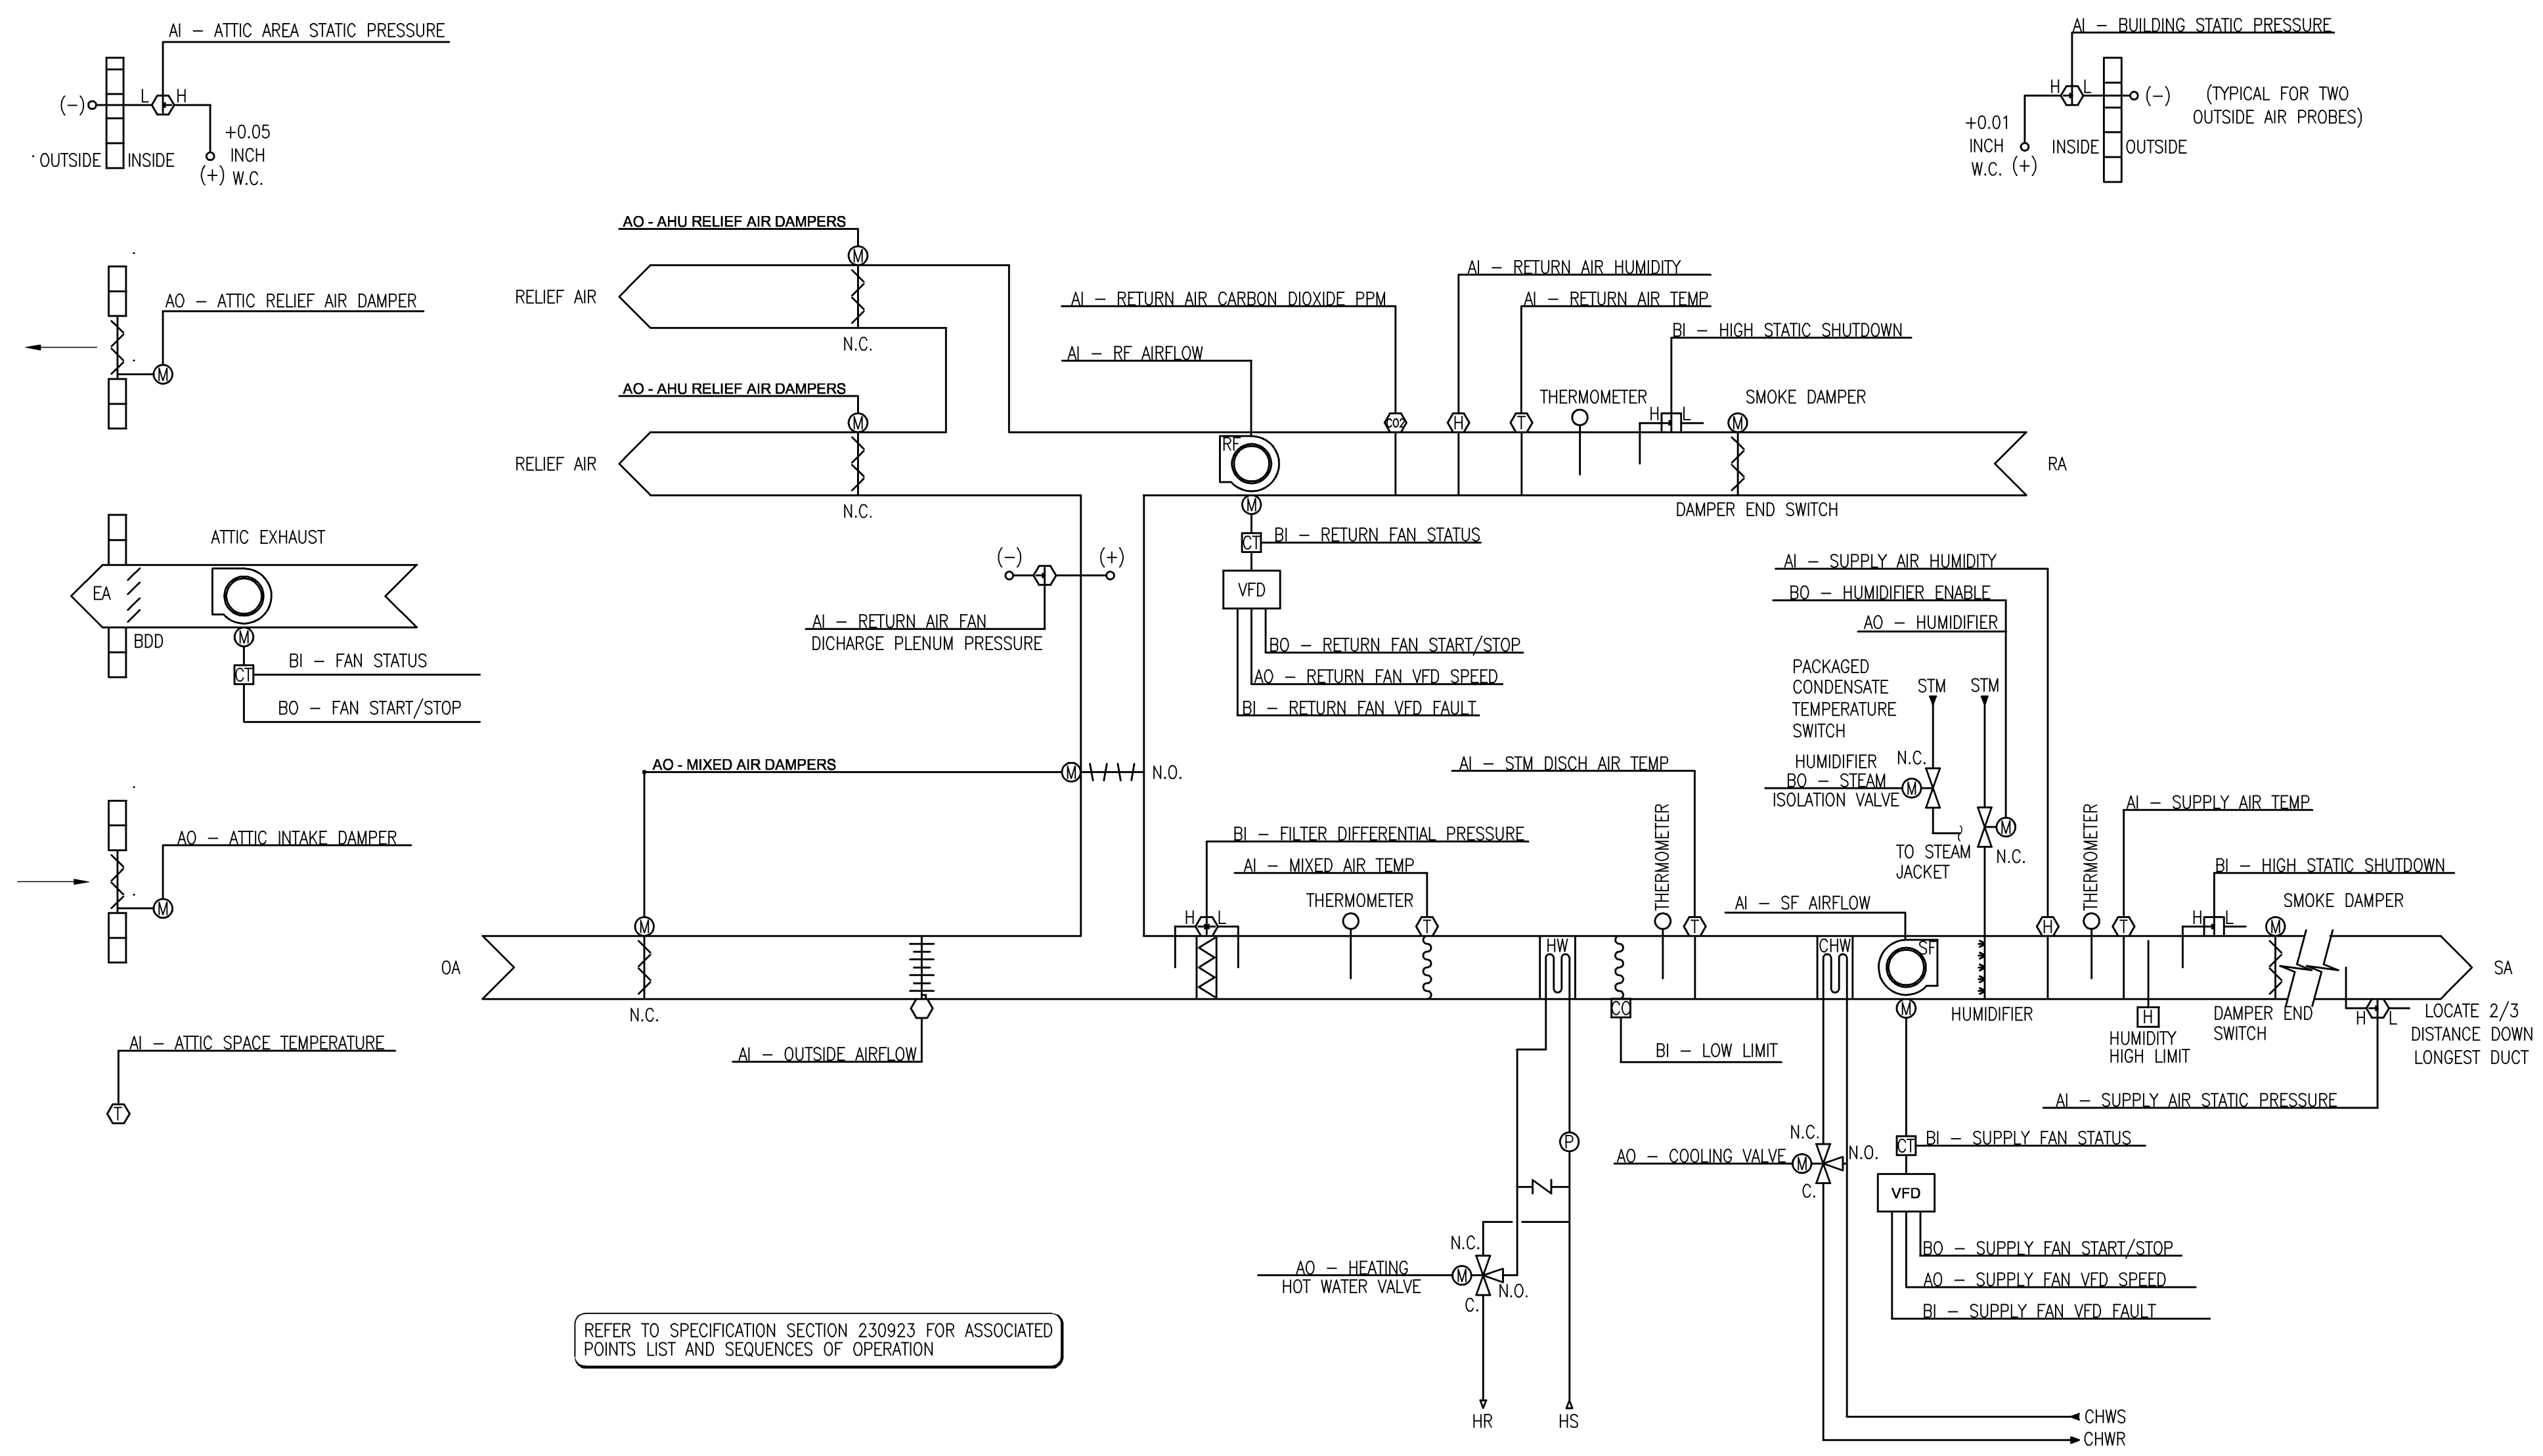

AIR HANDLING UNIT CONTROL DIAGRAM (TYPICAL)  
NOT TO SCALE



ATTIC UNIT HEATER (TYPICAL)  
NOT TO SCALE

TYPICAL HOT WATER  
COIL CIRCULATING PUMP  
NOT TO SCALE

100% DOCUMENTS Revisions		11/30/2011 Date		3950 SPARKS DRIVE, SE GRAND RAPIDS, MI 49508 816-574-8500 PROJ. NO. 12942721		URSArchitect		stamp		INFECTION CONTROL SAFETY OFFICER		DATE DATE		ENGINEERING MANAGER CARELINE MANAGER CHIEF OF STAFF		DATE DATE DATE		Drawing Title TEMPERATURE CONTROL DIAGRAMS		Project Title FCA - REPLACE HVAC SYSTEM PROJ. NO. 515-10-109 CONTRACT NO. VA251-P-0592		Date 11/30/2011 Station No. 515		MH800		Office of Facilities Department of Veterans Affairs	
-----------------------------	--	--------------------	--	---	--	--------------	--	-------	--	-------------------------------------	--	--------------	--	---	--	----------------------	--	--	--	---	--	--	--	-------	--	--	--