
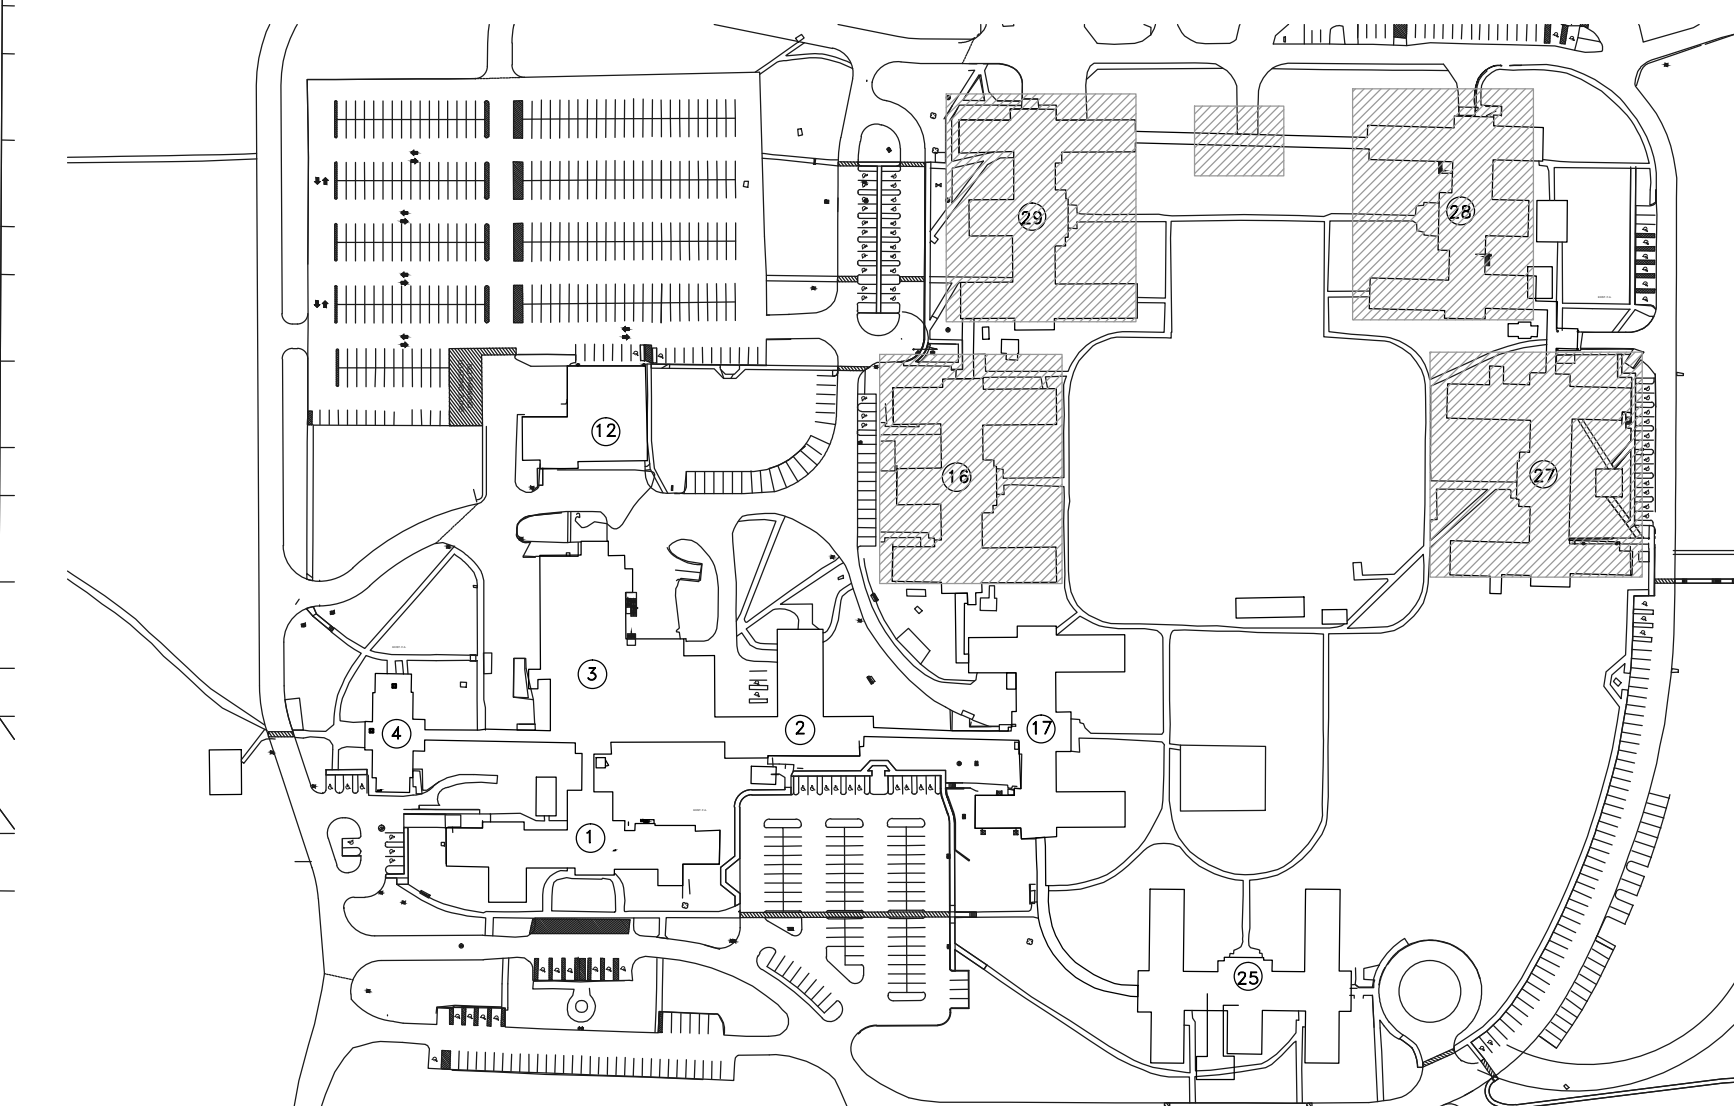




- 




**SITE PLAN - 28-29 CONNECTOR**  
**SCALE: 1" = 20'**



**KEY PLAN**  
**SCALE: NONE**

[illegible]

CONSULTANTS:

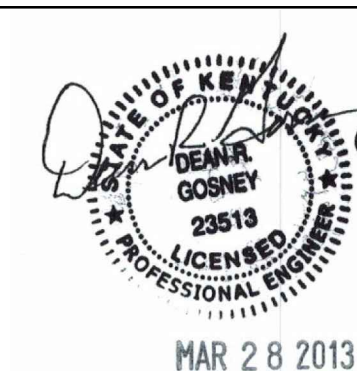


823 Scott Blvd.  
Covington, KY 41011-2447  
(859) 431-6083 (office)  
(859) 431-6136 (fax)  
[www.halpeinc.com](http://www.halpeinc.com)



Approved for Design Concept Only

*J. M. O'Connell*

100% CONSTRUCTION DOCUMENTS				
Project Title		Project Number		
REPLACE EXTERIOR BUILDING LIGHTING		596-12-101		
		Building Number		
		16,27,28,29		
Location		Drawing Number		
LEESTOWN ROAD LEXINGTON, KENTUCKY		EL003		
Date	Checked	Drawn	 Department of Veterans Affairs	
03-28-2013	DRG	LDG		