

DEPARTMENT OF VETERAN AFFAIRS  
VA MEDICAL CENTER - LEESTOWN ROAD DIVISION  
2250 LEESTOWN ROAD  
LEXINGTON, KENTUCKY 40511

REPLACE EXTERIOR LIGHTING AT THE VAMC  
PROJECT # 596-12-101


VA CONTRACT NO. VA-249-12-C-1121



LEXINGTON VAMC  
DEPARTMENT OF VETERANS AFFAIRS  
Engineering, Building 2, Room 223  
2250 Leestown Road  
Lexington, Kentucky 40511

INDEX OF DRAWINGS

SHEET NO.	DRAWING TITLE
GI-001	COVER SHEET - GENERAL INDEX, SITE PLAN
EL-001	EXTERIOR EGRESS LIGHTING ON BLDGS 1,2,3,4
EL-002	EXTERIOR EGRESS LIGHTING ON BLDGS 12,17,25
EL-003	EXTERIOR EGRESS LIGHTING ON BLDGS 16,27,28,29
EL-004	EMERGENCY POWER / EXTERIOR EGRESS LIGHTING ON BLDGS 22,37,39,47
EL-005	PHOTOMETRICS
EL-006	LUMINAIRE SCHEDULE
EL-007	PANEL SCHEDULES AND SINGLE-LINE DIAGRAM
PP-001	GENERATOR GAS PIPING & SPECIFICATIONS

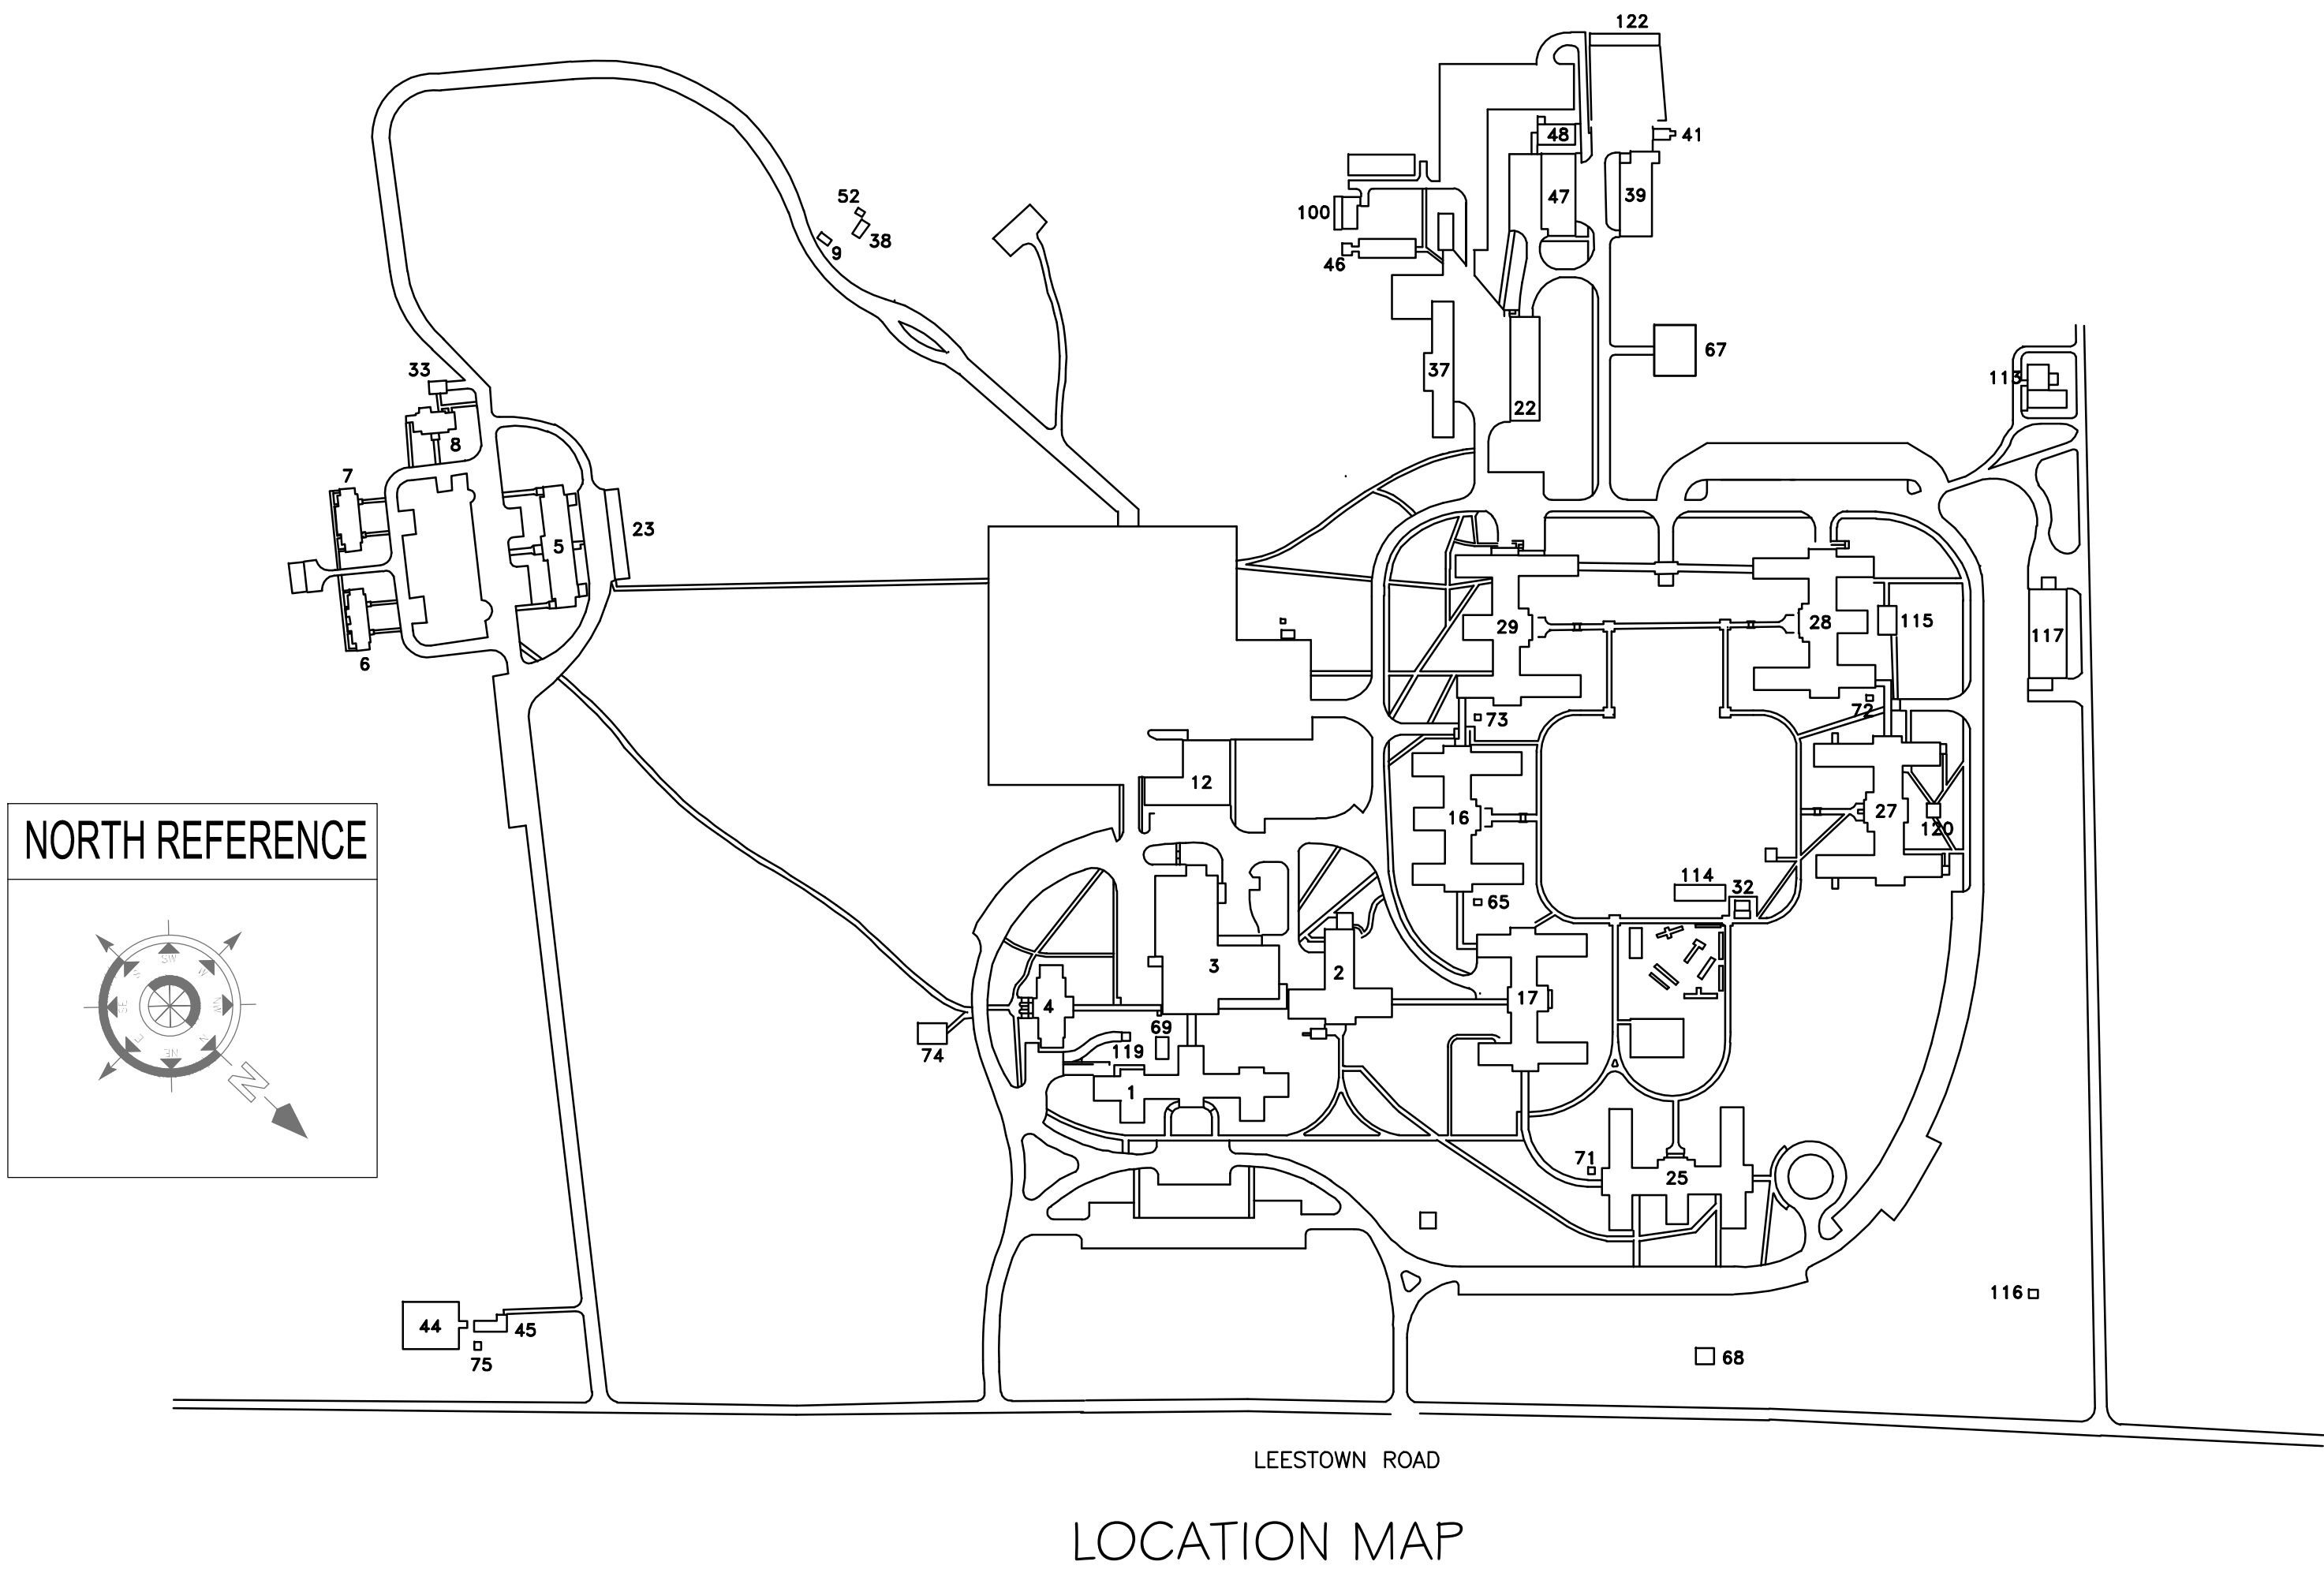

PROJECT CONTACTS

ENGINEER HAL-PE Associates Engineering Service, Inc. 823 Scott Boulevard Covington, Kentucky 41011 859-431-6083  Dean R. Gosney, P.E. dgosney@halpeinc.com	RESIDENT ENGINEER VA Medical Center 2250 Leestown Road Lexington, Kentucky 40511 859-223-4511 x 3362  David A. Carroll DavidA.Carroll@va.gov
---	---

		CONSULTANTS:				ARCHITECT/ENGINEERS: <b>HAL-PE ASSOCIATES</b> ENGINEERING SERVICES, INC. 823 Scott Blvd. Covington, KY 41011-2447 (859) 431-6083 (office) (859) 431-6136 (fax) www.halpeinc.com 		Drawing Title Cover & Index of Drawings  Approved for Design Concept Only 		100% CONSTRUCTION DOCUMENTS		
								Project Title REPLACE EXTERIOR BUILDING LIGHTING		Project Number 596-12-101		
								Location LEESTOWN ROAD LEXINGTON, KENTUCKY		Building Number		
								Date 03-28-2013		Checked DRG		
								Drawn LDG		Drawing Number GI001		
										Dwg. 1 of 9		