



A three inches = one foot
 B one and one-half inches = one foot
 C one inch = one foot
 D three-quarters inch = one foot
 E one-half inch = one foot
 F three-eighths inch = one foot
 G one-quarter inch = one foot
 H one-eighth inch = one foot

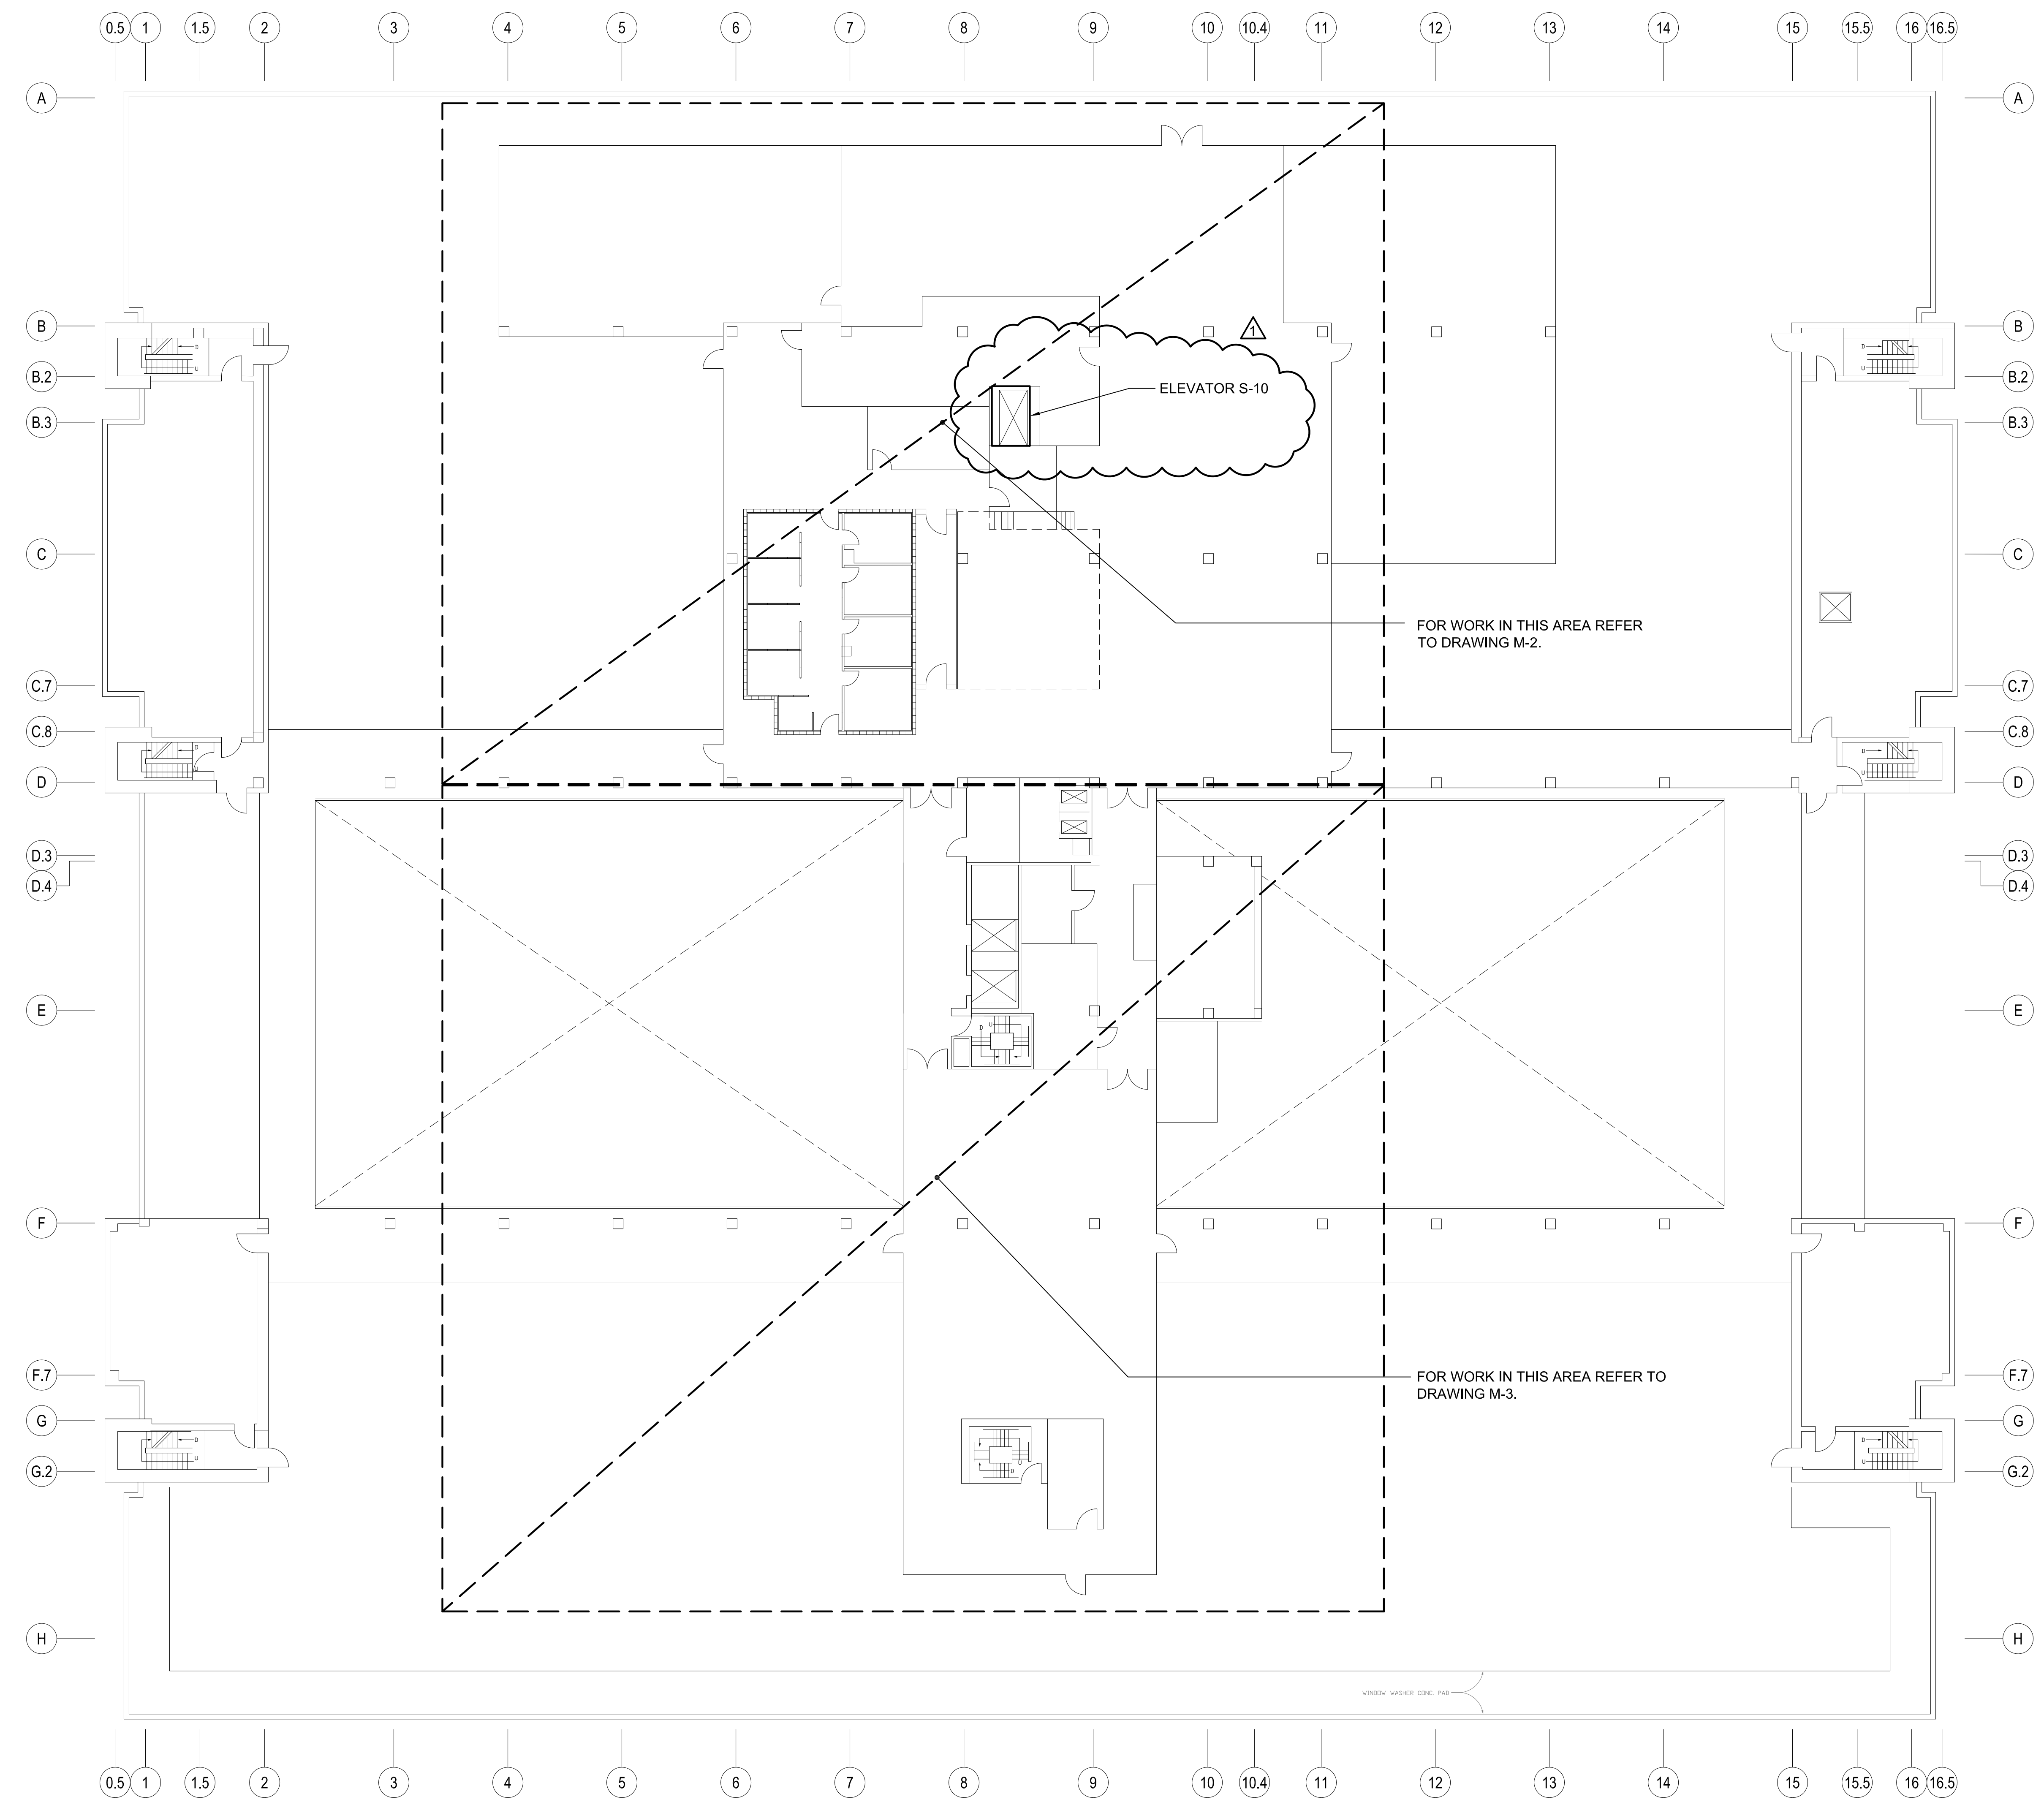

1 SEVENTH FLOOR PLAN - MECHANICAL - FLOOR PLAN
 SCALE: 1/16" = 1'-0"

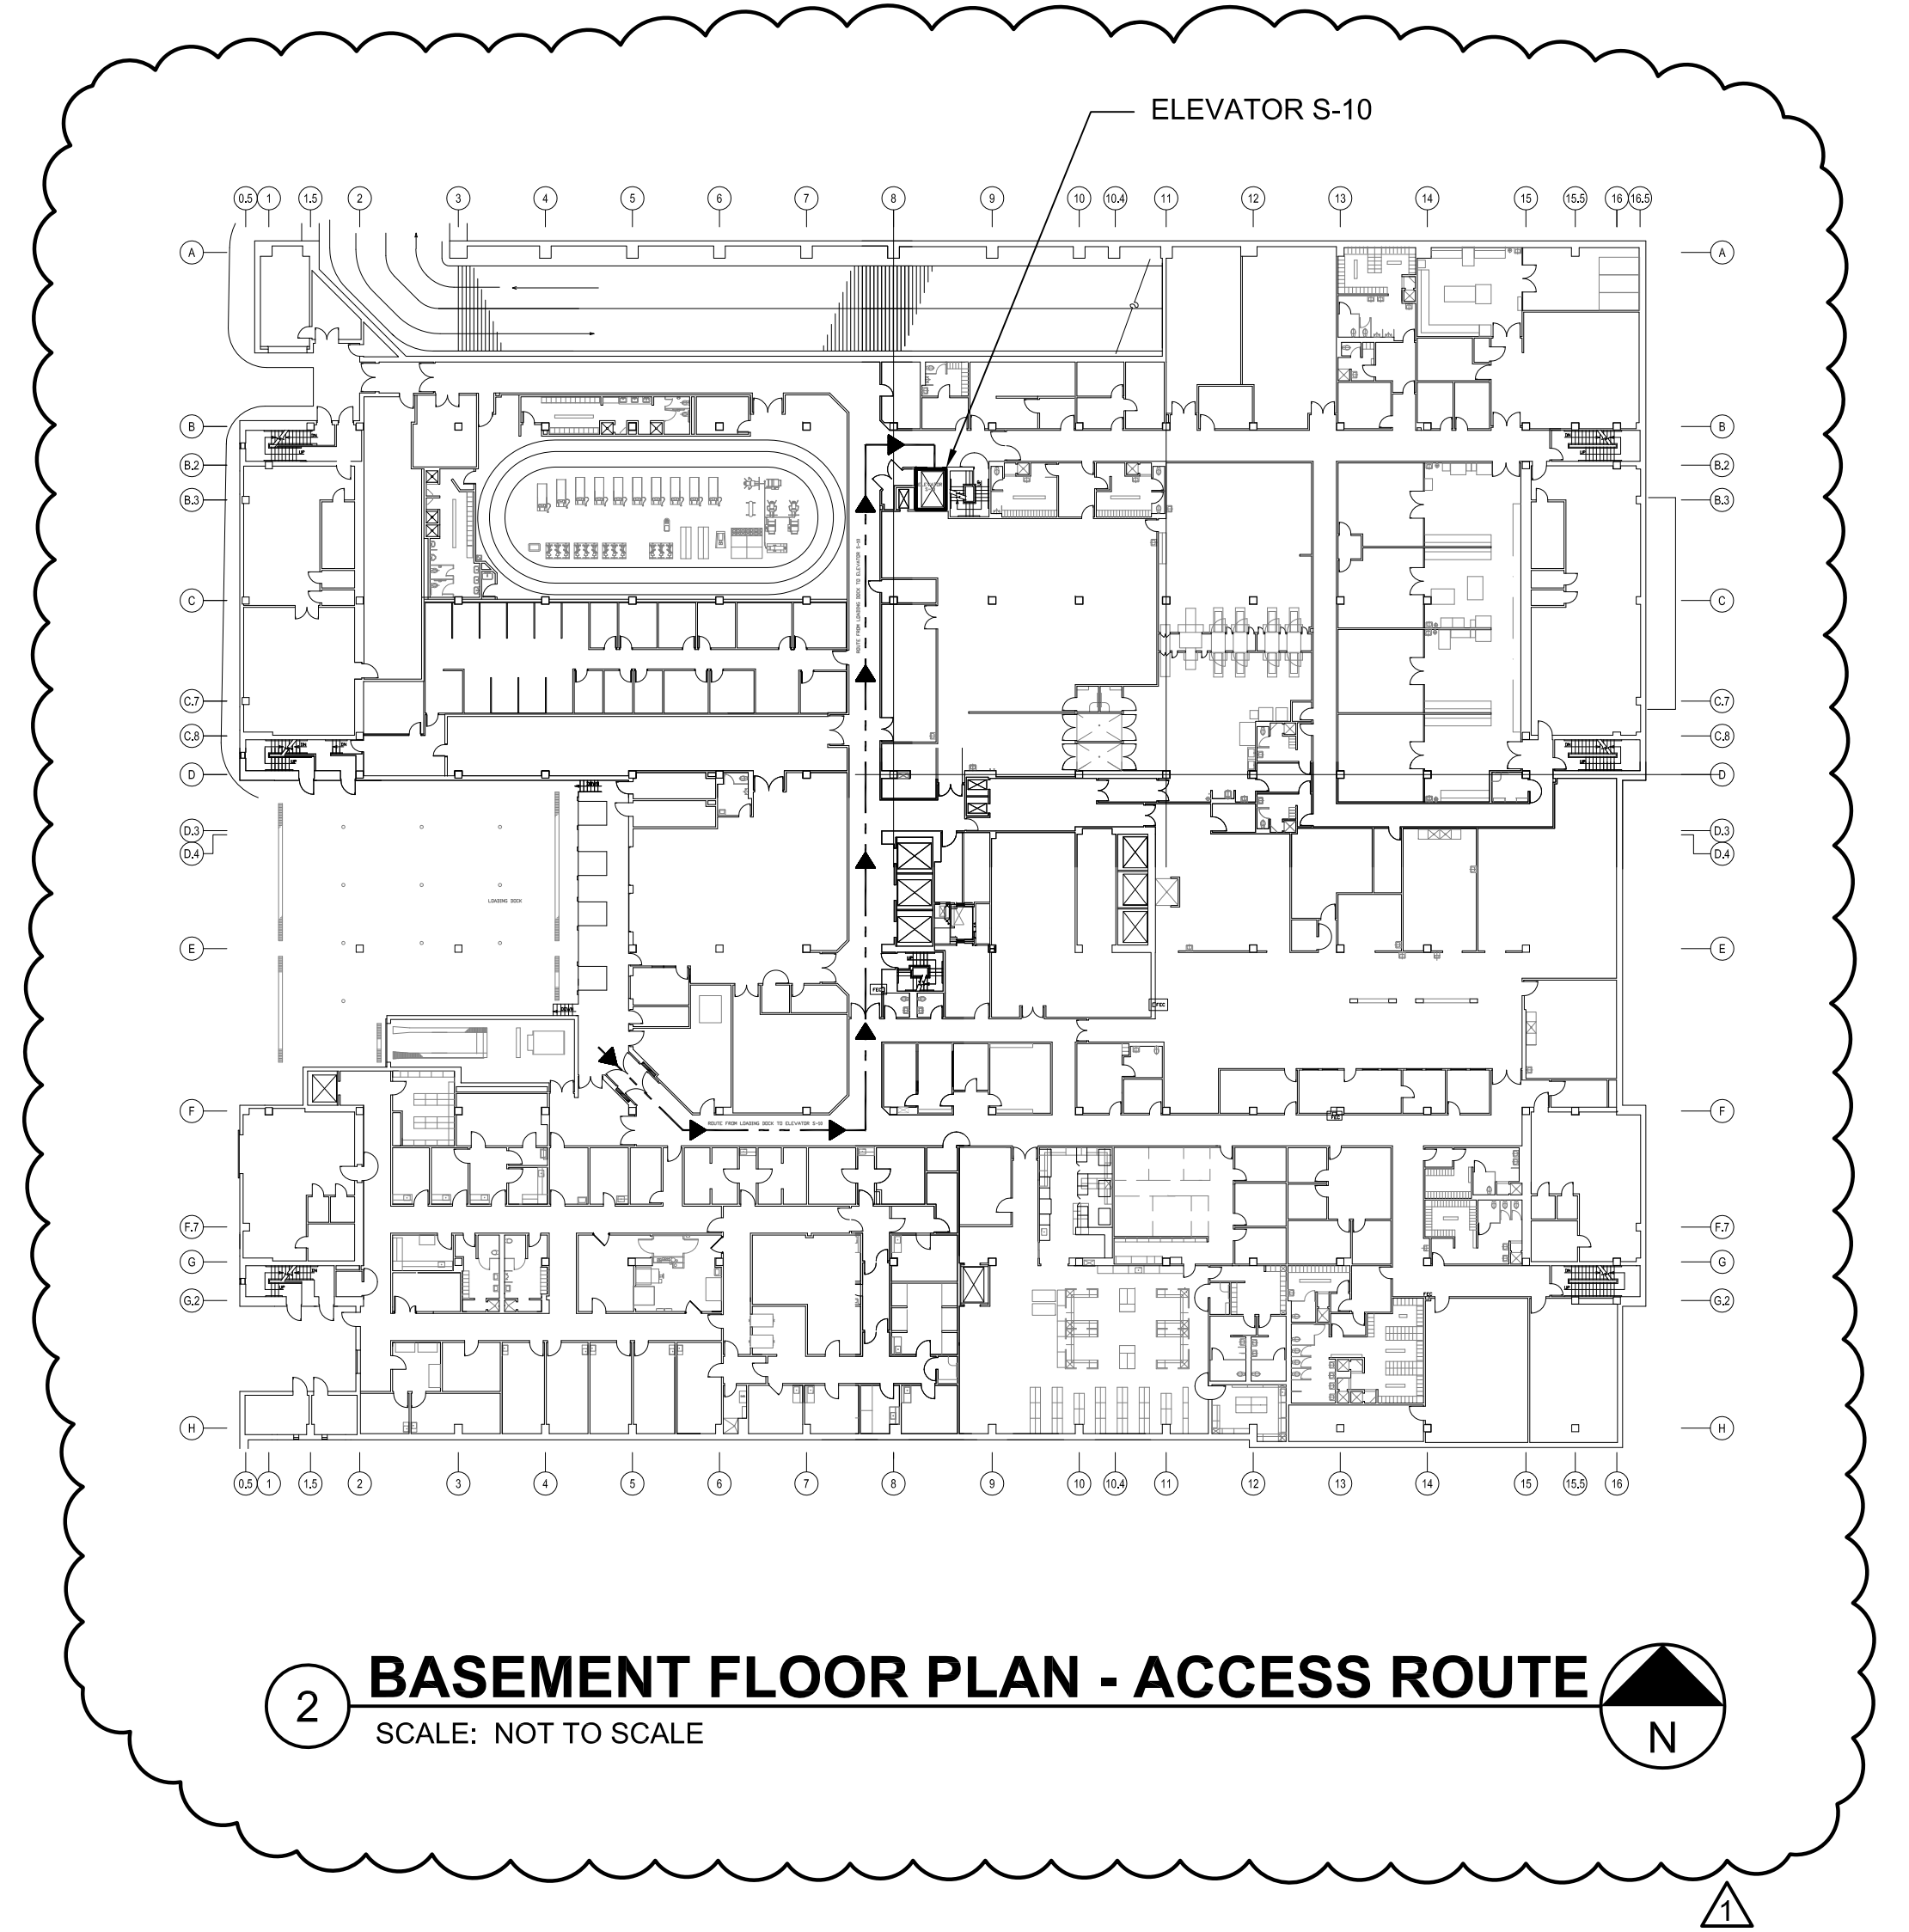

ADDENDUM-1 Revisions Date	6/3/13 Consultants	BURDETTE KOEHLER MURPHY & ASSOCIATES, INC. 1423 CLARKVIEW ROAD, SUITE 500 BALTIMORE, MARYLAND 21209 410.323.0600 - FAX 410.377.2543	 KEY PLAN	Seal 	 1301 Enterprise Court, Suite 103-C1 Bel Air, Maryland 21014-1847 410.803.0099 fax 410.838.1603	Drawing Title SEVENTH FLOOR PLAN MECHANICAL FLOOR PLAN	Project Title HVAC IMPROVEMENTS 7TH FLOOR	Date 03/29/13 Project No. 512-12-103	DRAWING NO. M-1 Dwg. 5 of 11
	Approved: Associate Director of Operations					Building Number 1	Checked MAF	Drawn CMD	

