




DEPARTMENT OF VETERANS AFFAIRS
VA MEDICAL CENTER
COATESVILLE, PA

REPLACE
FIRE ALARM SYSTEM
PROJECT NO. 542-07-103


DRAWING LIST

1.	COVER PAGE	X-00	21.	BUILDING 59 ALL FLOORS	FA-17
2.	DETAILS	X-01	22.	BUILDING 139 ALL FLOORS	FA-18
3.	SITE PLAN	X-02	23.	BUILDING 10, 11 ALL FLOORS	FA-19
4.	PHOTO DETAIL PAGE	X-03	24.	BUILDINGS 12, 13, 14, 15 ALL FLOORS	FA-20
5.	BUILDING 1 BASEMENT, GROUND, FIRST FLOORS	FA-1	25.	BUILDINGS 16, 17 ALL FLOORS	FA-21
6.	BUILDING 1 THIRD, FOURTH, FIFTH FLOORS	FA-2	26.	BUILDINGS 18, 40, 70, 151 ALL FLOORS	FA-22
7.	BUILDING 2 BASEMENT, FIRST, SECOND, THIRD FLOORS	FA-3	27.	BUILDINGS 69, 70, 74 ALL FLOORS	FA-23
8.	BUILDINGS 3 & 5 ALL FLOORS	FA-4	28.	BUILDING 138 ALL FLOORS	FA-24
9.	BUILDING 4 ALL FLOORS	FA-5			
10.	BUILDING 6 ALL FLOORS	FA-6			
11.	BUILDING 7 ALL FLOORS	FA-7			
12.	BUILDING 8 ALL FLOORS	FA-8			
13.	BUILDINGS 9 & 72 ALL FLOORS	FA-9			
14.	BUILDINGS 19, 26, 27, & 28 ALL FLOORS	FA-10			
15.	BUILDING 38 ALL FLOORS	FA-11			
16.	BUILDING 39 ALL FLOORS	FA-12			
17.	BUILDING 57 & 81 BASEMENT, FIRST FLOORS	FA-13			
18.	BUILDING 57 SECOND, PENTHOUSE FLOORS	FA-14			
19.	BUILDING 58 BASEMENT, FIRST FLOORS	FA-15			
20.	BUILDING 58 SECOND, PENTHOUSE FLOORS	FA-16			

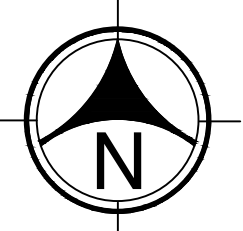




VICINITY MAP

NO SCALE

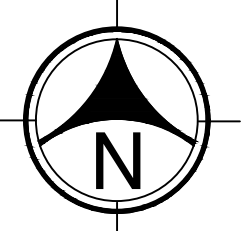


LOCATION MAP

NO SCALE

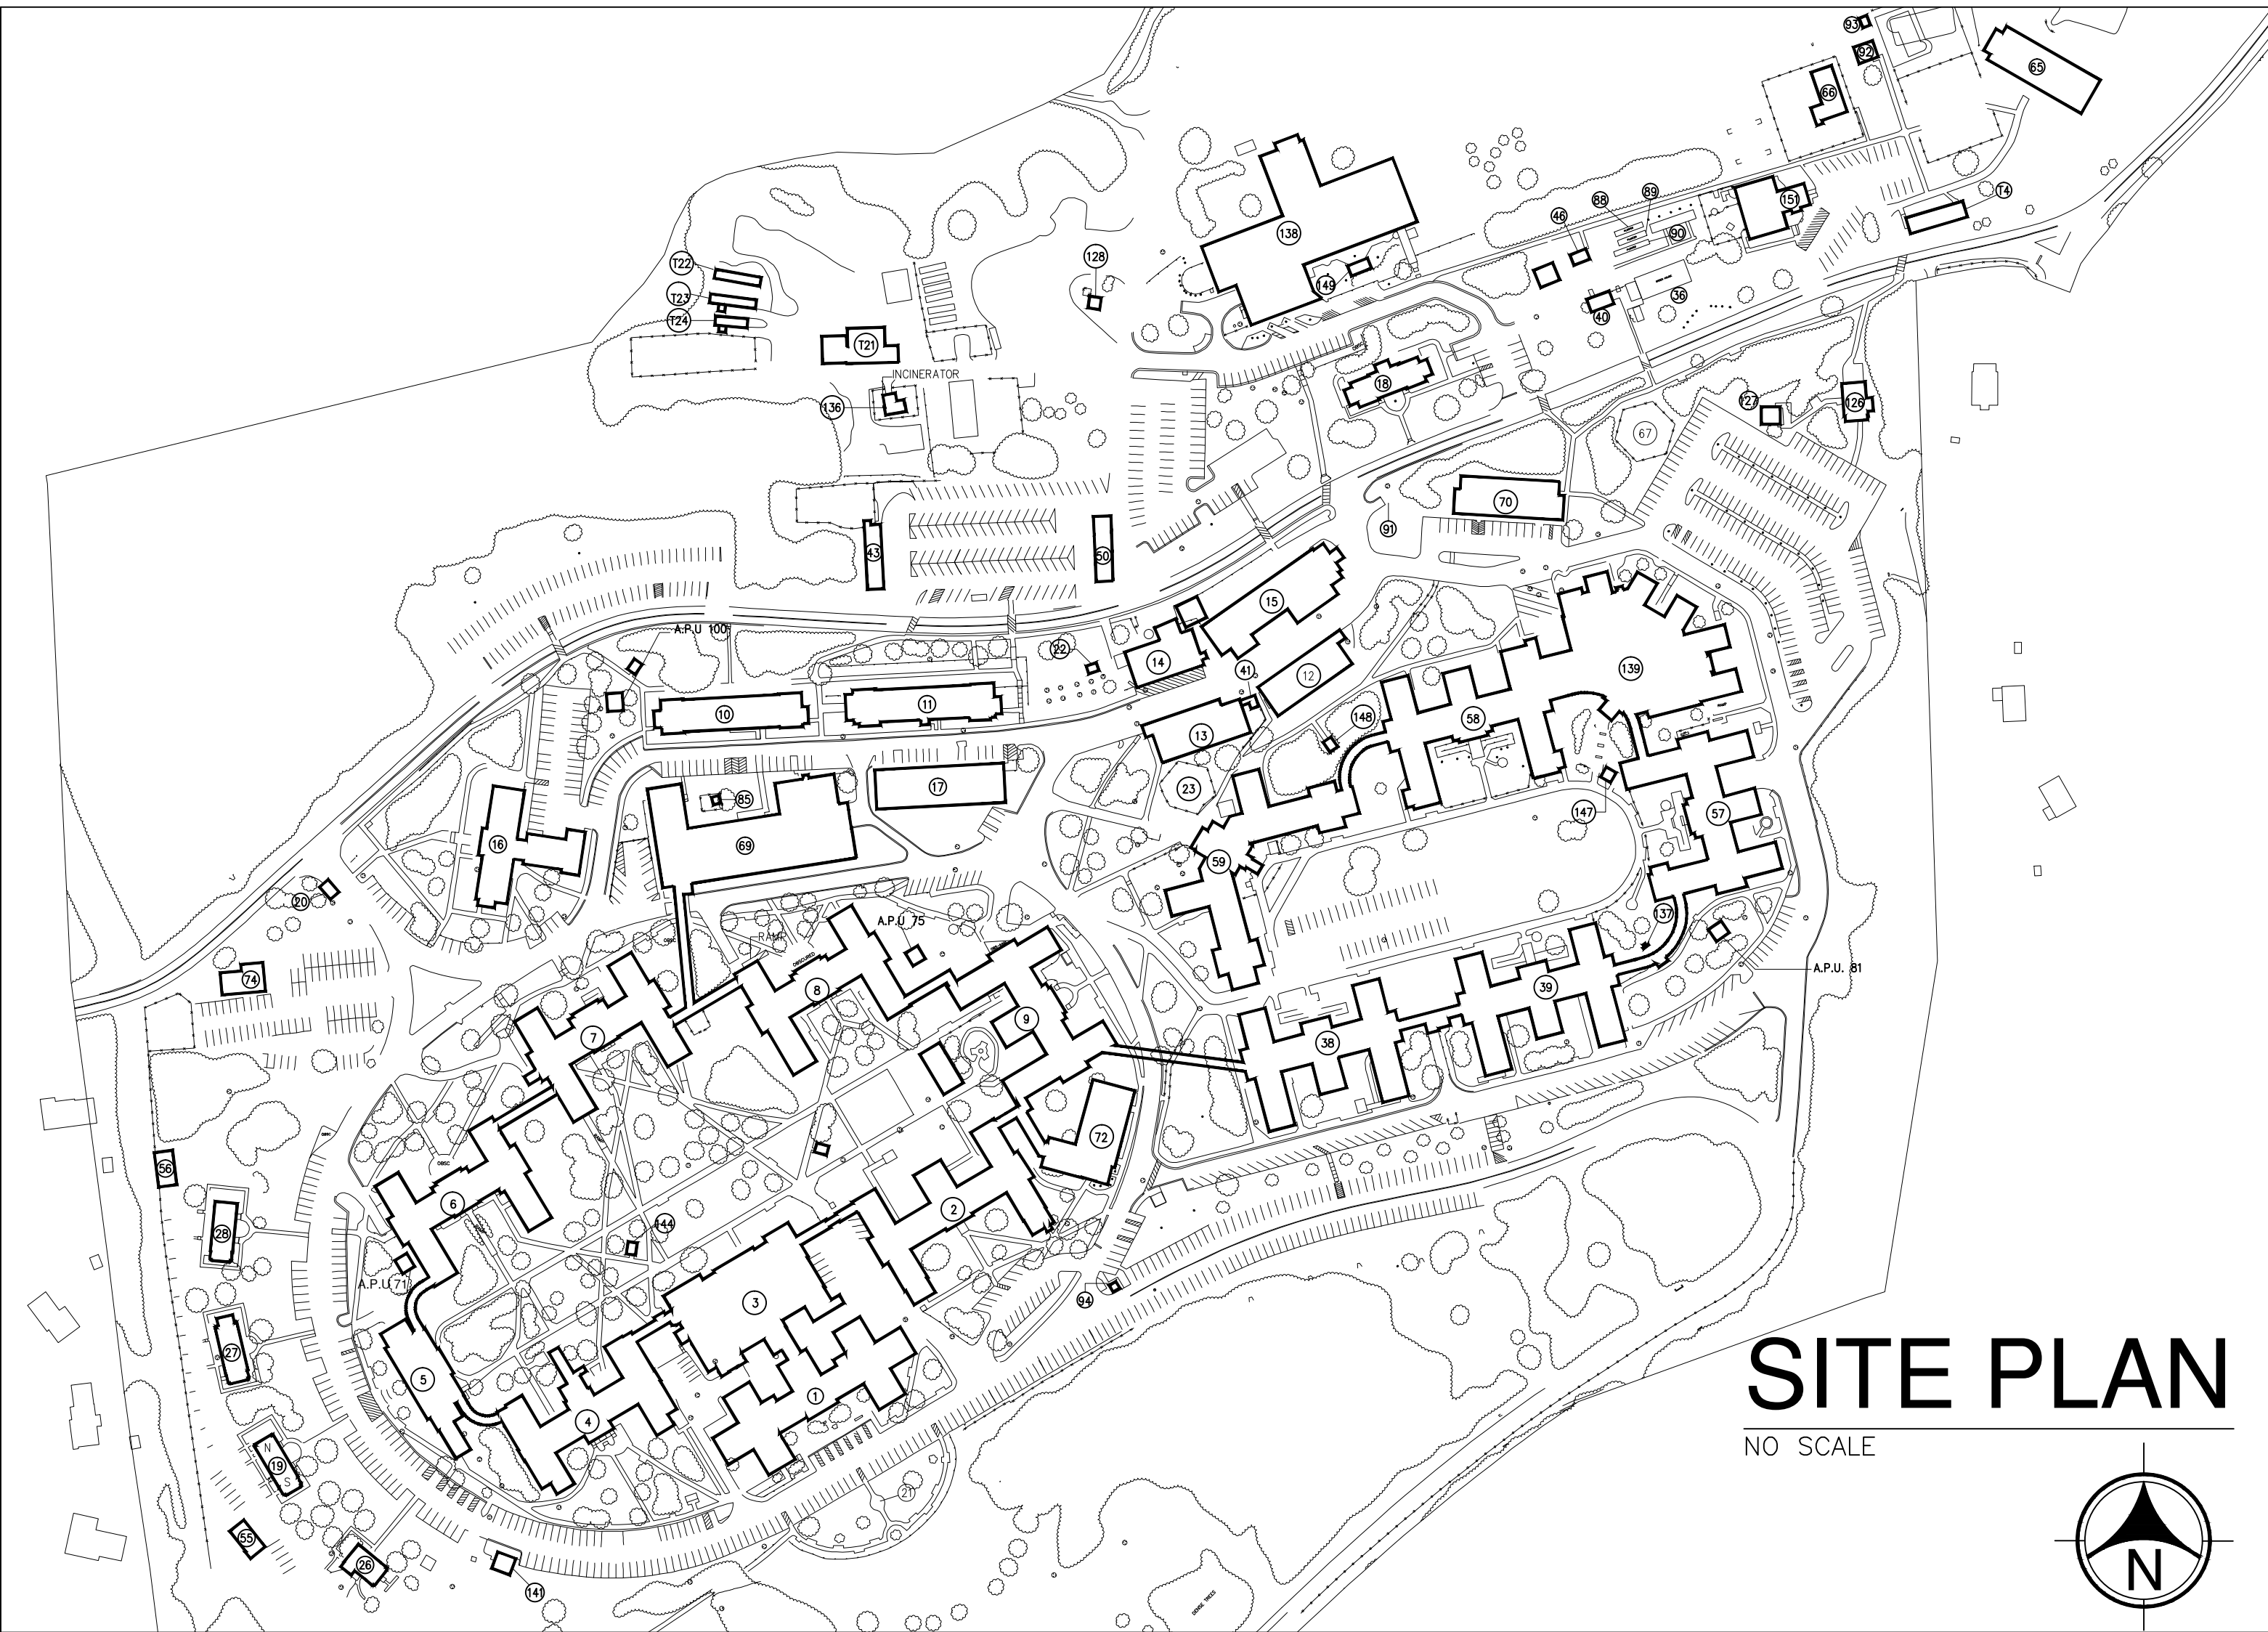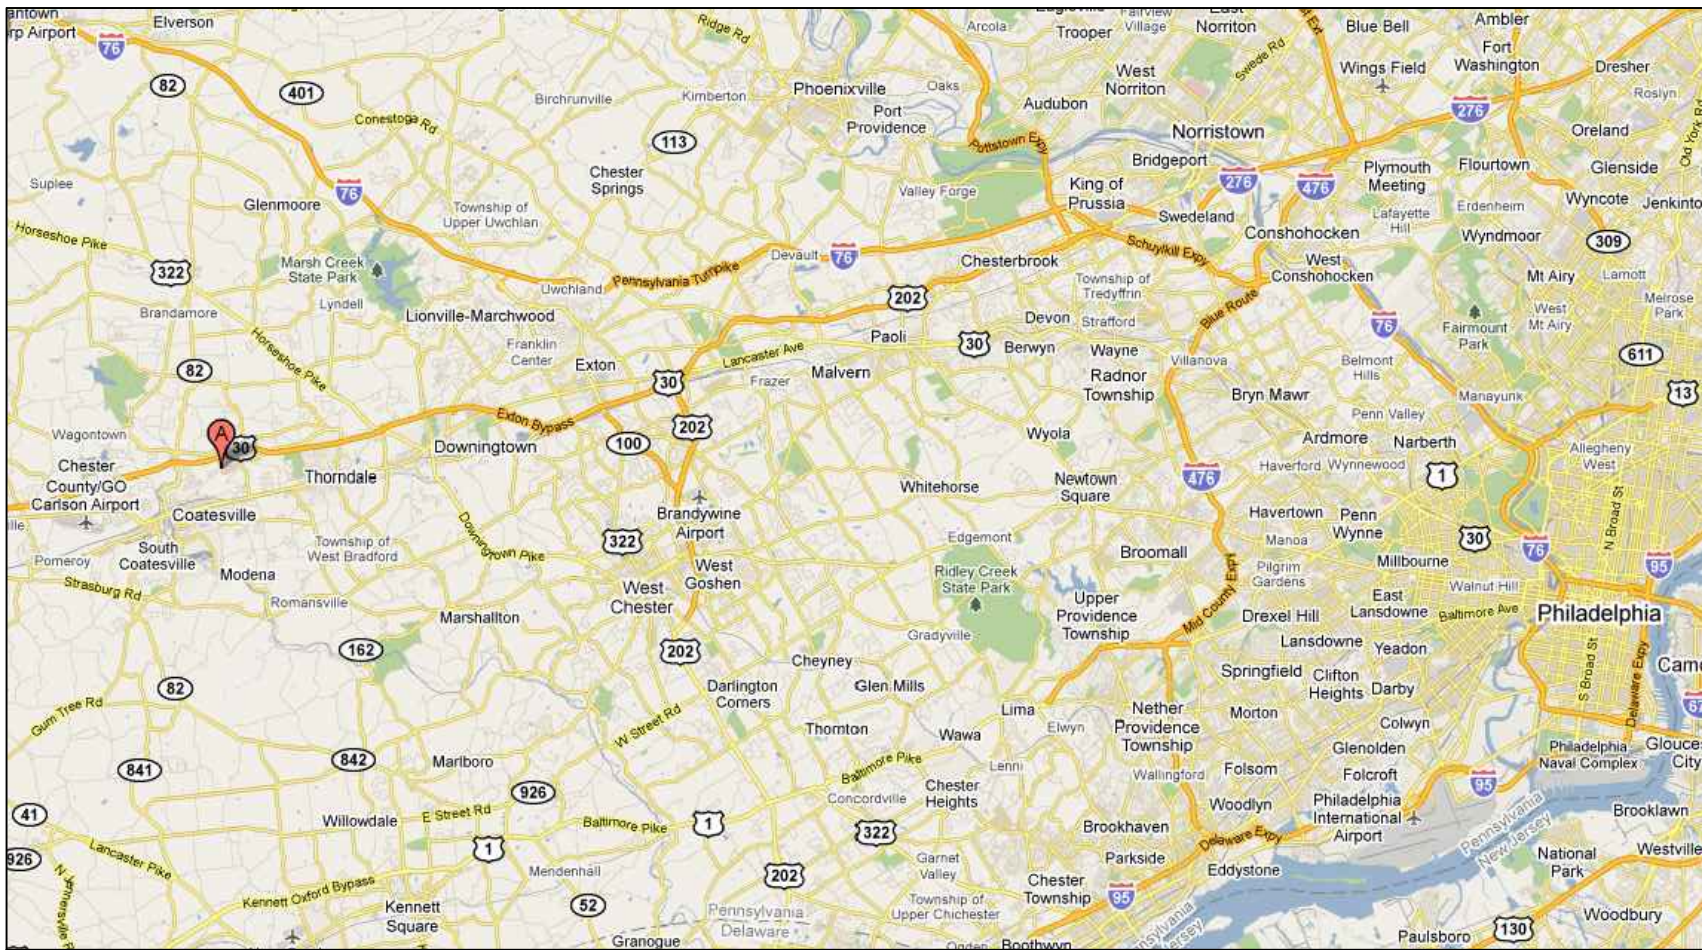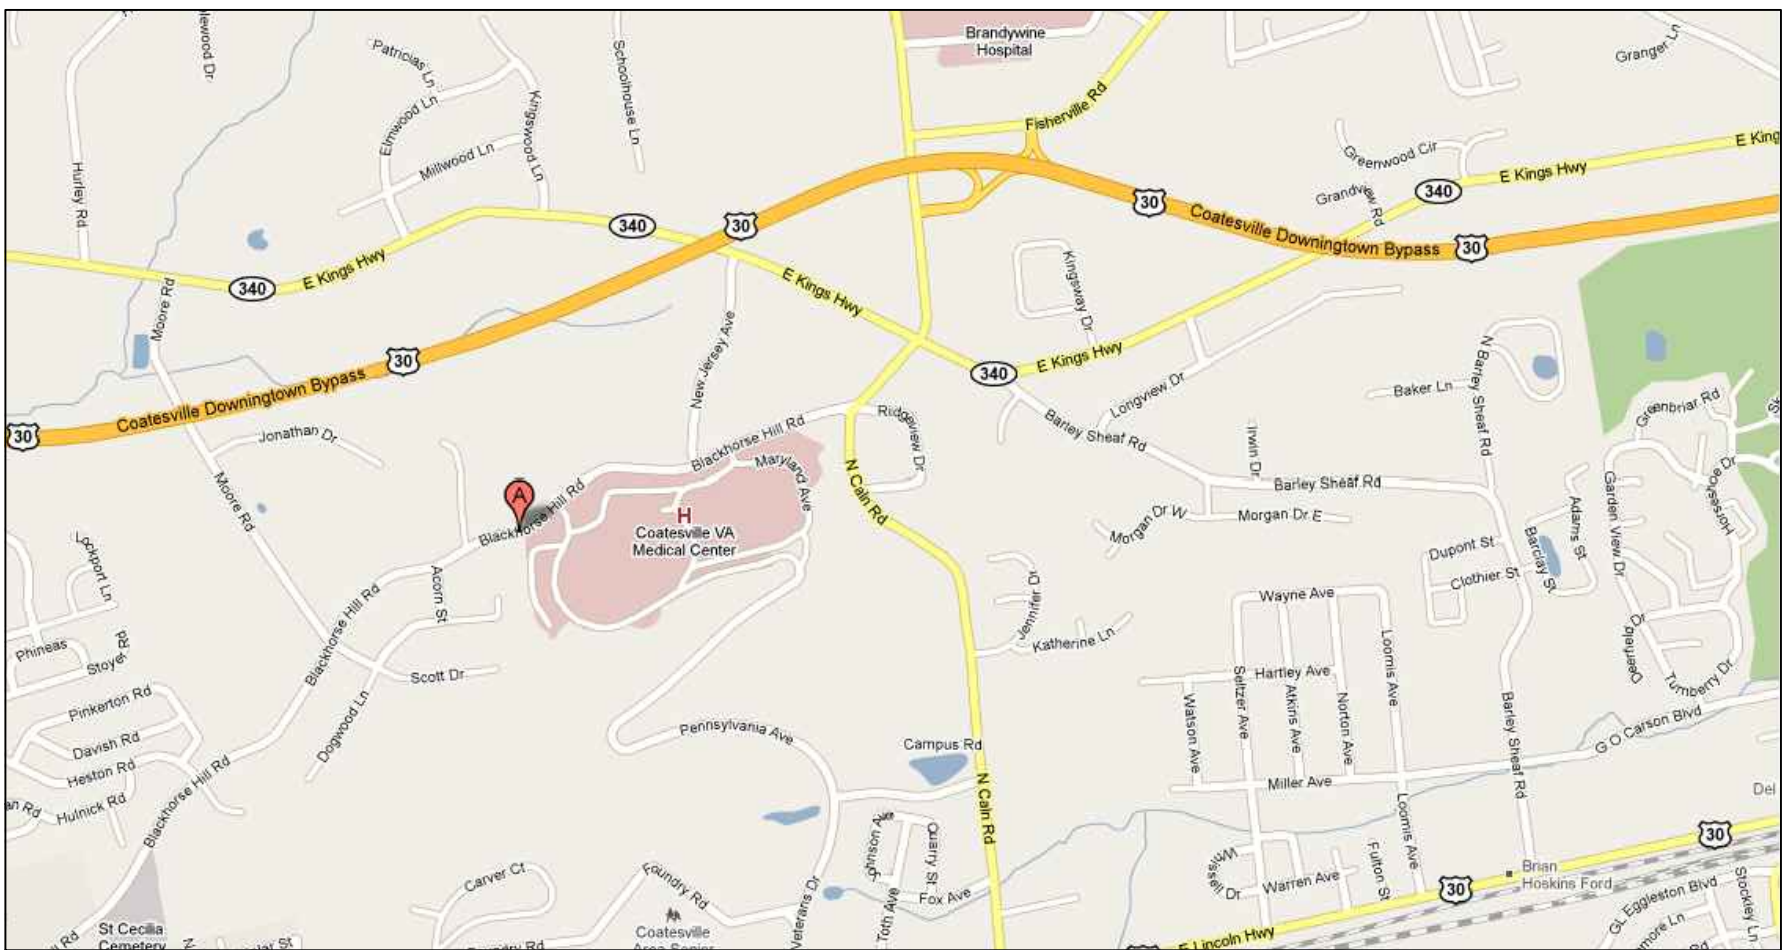




SITE PLAN

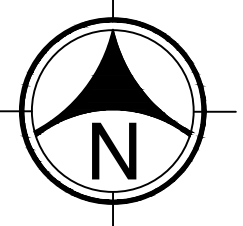NO SCALE



Fire Chief	Chief Information Officer	Acquisitions Chief / Contracting Officer
Police Chief	Infection Control Coordinator	FES M&O Supervisor
Safety / Occupational Health Manager	FES Project Section Supervisor,	Patient Care Facilities Foreman
Patient Safety Manager	Project Manager	General Utilities Foreman

General Properties Foreman

Revisions	Date	 <div>Dept. of Veterans Affairs VA Medical Center 1400 Black Horse Hill Road Coatesville, PA 19320</div>	 <div>1st FIRE PROTECTION & CODE CONSULTANTS, INC. 1520 MAIN STREET INDIANAPOLIS, IN 46224 (317)486-5188</div>	Approved: Chief, Facilities Management Services	Drawing Title	Project Title	Date				
				Approved: Medical Center Director	COVER PAGE	REPLACE FIRE ALARM SYSTEM	1/25/11				
				Approved:	Client Project No. 542-07-103	Contract No. VA244-P-1473	Designed By SCR		Checked By SCR	Drawn By SF/DN/JV	Scale: NO SCALE
				Approved:	Building No. ALL	AutoCAD File Name X00 COATESVILLE FA COVER	Location VA MEDICAL CENTER COATESVILLE, PENNSYLVANIA		Drawing No. X-00	Dwg. 1 of 28	