


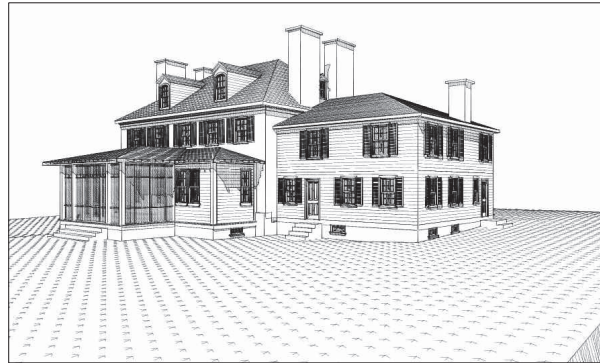

RENOVATE MANSION HOUSE AND GRIST MILL VA MEDICAL CENTER PERRY POINT, MARYLAND PROJECT NO. 512A5-10-335 BUILDING 501 - MANSION HOUSE



VICINITY MAP
NOT TO SCALE



INDEX OF DRAWINGS		
SHEET NAME	SHEET No.	DRAWING TITLE
GENERAL		
501-G10.01	1	COVER SHEET
501-G10.02	2	DRAWING LEGEND, ABBREVIATIONS & SYMBOLS
CIVIL		
501-CD1.01	1	CIVIL SITE PLAN - DEMOLITION PLAN
501-CS1.01	2	SITE PLAN - EXISTING CONDITIONS
501-CS1.02	3	CIVIL SITE PLAN - NEW WORK - EROSION CONTROL PLAN
501-CS1.03	4	CIVIL SITE PLAN - NEW WORK - SITE CONSTRUCTION STAGING PLAN
501-CG1.01	5	CIVIL SITE PLAN - NEW WORK - GRADING PLAN
501-CU1.01	6	CIVIL SITE PLAN - NEW WORK - SITE UTILITIES
ARCHITECTURAL		
501-A01.01	1	DEMOLITION BASEMENT FLOOR PLAN
501-A01.02	2	DEMOLITION FIRST FLOOR PLAN
501-A01.03	3	DEMOLITION SECOND FLOOR PLAN
501-A01.04	4	DEMOLITION ATTIC PLAN
501-A01.05	5	DEMOLITION ROOF PLAN
501-A01.06	6	DEMOLITION REFLECTED CEILING PLAN FIRST FLOOR
501-A01.07	7	DEMOLITION REFLECTED CEILING PLAN SECOND FLOOR
501-AE1.01	8	BASEMENT FLOOR PLAN
501-AE1.02	9	FIRST FLOOR PLAN
501-AE1.03	10	SECOND FLOOR PLAN
501-AE1.04	11	ATTIC PLAN
501-AE1.05	12	ROOF PLAN

INDEX OF DRAWINGS		
SHEET NAME	SHEET No.	DRAWING TITLE
ARCHITECTURAL (CONTINUED)		
501-AE1.06	13	REFLECTED CEILING PLAN FIRST FLOOR
501-AE1.07	14	REFLECTED CEILING PLAN SECOND FLOOR
501-AE2.01	15	NORTH ELEVATION
501-AE2.02	16	SOUTH ELEVATION
501-AE2.03	17	EAST AND WEST ELEVATION
501-AE2.05	18	PORCH PLANS, ELEVATIONS AND DETAILS
501-AE4.01	19	STAIR PLANS, SECTIONS AND DETAILS
501-AE5.01	20	ROOF DETAILS
501-AE6.01	21	WINDOW SCHEDULES
501-AE6.02	22	DOOR SCHEDULE AND DETAILS
501-AE6.03	23	FINISH SCHEDULE
501-AF6.01	24	PARTITION AND TRIM DETAILS
501-AF6.02	25	PORCH WINDOW WALL DETAILS
501-AF6.03	26	PORCH BRACKET DETAILS
501-ES.01	27	INTERIOR ELEVATIONS MEETING ROOM, LIBRARY AND HALL
501-ES.02	28	INTERIOR ELEVATIONS FRONT HALL, DINING ROOM, AND BREAK OUT ROOM
501-ES.03	29	INTERIOR ELEVATIONS HALL ADDITION, UNISEX RESTROOM, PREP SPACE, AND KITCHEN
501-ES.04	30	CASEWORK/ELEVATIONS/DETAILS
501-ES.05	31	INTERIOR ELEVATIONS PORCH, OFFICE #18 AND OFFICE #28
501-ES.06	32	INTERIOR ELEVATIONS OFFICE #58, OFFICE #78 AND HALL 2ND FLOOR
501-ES.07	33	INTERIOR ELEVATIONS MEN'S/WOMEN'S RESTROOM, WORK SPACE 1, 2

INDEX OF DRAWINGS		
SHEET NO.	SHEET No.	DRAWING TITLE
STRUCTURAL		
501-SD1.01	1	FOUNDATION PLAN - DEMOLITION
501-SD1.02	2	FIRST FLOOR STRUCTURAL PLAN - DEMOLITION
501-SD1.03	3	SECOND FLOOR STRUCTURAL PLAN - DEMOLITION
501-SD1.04	4	THIRD FLOOR STRUCTURAL PLAN - DEMOLITION
501-SE1.01	5	FOUNDATION PLAN
501-SE1.02	6	FIRST/SECOND FLOOR FRAMING PLAN
501-SE2.01	7	STRUCTURAL DETAILS
HVAC		
501-MD1.00	1	MECHANICAL PLAN - DEMOLITION - BASEMENT
501-MD1.01	2	MECHANICAL PLAN - DEMOLITION - FIRST FLOOR
501-MD1.02	3	MECHANICAL PLAN - DEMOLITION - SECOND FLOOR
501-MD1.03	4	MECHANICAL PLAN - DEMOLITION - ATTIC
501-MD1.00	5	MECHANICAL SITE PLAN - NEW WORK
501-ME1.00	6	MECHANICAL PLAN - NEW WORK - BASEMENT
501-ME1.01	7	MECHANICAL PLAN - NEW WORK - FIRST FLOOR
501-ME1.02	8	MECHANICAL PLAN - NEW WORK - SECOND FLOOR
501-ME1.03	9	MECHANICAL PLAN - NEW WORK - ATTIC
501-ME1.04	10	MECHANICAL PLAN - NEW WORK - HYDRONIC PIPING
501-ME1.05	11	MECHANICAL PLAN - NEW WORK - HYDRONIC PIPING
501-ME1.06	12	HVAC SCHEDULES
501-ME1.07	13	HVAC RISER DIAGRAM, DETAILS & DDC CONTROLS
PLUMBING		
501-PD1.00	1	PLUMBING PLAN - DEMOLITION - BASEMENT
501-PD1.01	2	PLUMBING PLAN - DEMOLITION - FIRST FLOOR
501-PD1.02	3	PLUMBING PLAN - DEMOLITION - SECOND FLOOR
501-PD1.03	4	PLUMBING PLAN - DEMOLITION - ATTIC
501-PL1.00	5	PLUMBING PLAN - NEW WORK - WATER/DWV - BASEMENT
501-PL1.01	6	PLUMBING PLAN - NEW WORK - HOT/COLD WATER - FIRST FLOOR
501-PL1.02	7	PLUMBING PLAN - NEW WORK - DWV - FIRST FLOOR
501-PL1.03	8	PLUMBING PLAN - NEW WORK - HOT/COLD WATER - SECOND FLOOR
501-PL1.04	9	PLUMBING PLAN - NEW WORK - DWV - SECOND FLOOR
501-PL1.05	10	PLUMBING DETAILS
501-PL1.06	11	PLUMBING RISER DIAGRAM
ELECTRICAL		
501-ES1.01	1	ELECTRICAL SITE PLANS - DEMOLITION AND NEW WORK
501-ED1.01	2	ELECTRICAL PLAN - BASEMENT - DEMOLITION
501-ED1.02	3	ELECTRICAL PLAN - FIRST FLOOR - DEMOLITION
501-ED1.03	4	ELECTRICAL PLAN - SECOND FLOOR - DEMOLITION
501-EP1.01	5	POWER PLAN - BASEMENT - NEW WORK
501-EP1.02	6	POWER PLAN - FIRST FLOOR - NEW WORK
501-EP1.03	7	POWER PLAN - SECOND FLOOR - NEW WORK
501-EP1.04	8	POWER PLAN - THIRD FLOOR - NEW WORK
501-EL1.01	9	LIGHTING PLAN - BASEMENT - NEW WORK
501-EL1.02	10	LIGHTING PLAN - FIRST FLOOR - NEW WORK
501-EL1.03	11	LIGHTING PLAN - SECOND FLOOR - NEW WORK
501-EL1.04	12	LIGHTING PLAN - THIRD FLOOR - NEW WORK
501-ET1.01	13	DATA/COMM PLAN - BASEMENT - NEW WORK
501-ET1.02	14	DATA/COMM PLAN - FIRST FLOOR - NEW WORK
501-ET1.03	15	DATA/COMM PLAN - SECOND FLOOR - NEW WORK
501-ES.01	16	ELECTRICAL LEGEND, SCHEDULES, NOTES AND DETAILS
501-ES.02	17	ELECTRICAL DETAILS
FIRE PROTECTION		
501-FX1.01	1	FIRE PROTECTION ATTIC AND 2ND FLOOR
501-FX1.02	2	FIRE PROTECTION - FIRST FLOOR AND BASEMENT
501-FX1.03	3	FIRE PROTECTION - FIRST FLOOR AND BASEMENT
FIRE ALARM		
501-FAX1.01	1	FIRE ALARM - BASEMENT
501-FAX1.02	2	FIRE ALARM - 1ST FLOOR
501-FAX1.03	3	FIRE ALARM - 2ND FLOOR
501-FAX1.04	4	FIRE ALARM - ATTIC
501-FAX1.05	5	FIRE ALARM - RISER

FINAL

BES DESIGN/BUILD 1612 K Street, NW, Suite 900 Washington, DC 20006 Phone: 202-223-1234 Fax: 202-223-1212		Drawing Scale: AS NOTED	Approved: Chief, Facilities and Engineering:	Drawing Title: COVER SHEET	Project Title: RENOVATE MANSION HOUSE AND GRIST MILL VA MEDICAL CENTER	Date: 10/15/2012
Drawing Start Date: 03/01/2012		Approved: Associate Chief for Maintenance and Operations, Perry Point:	Approved: Associate Director for Operations:	Building No: 501	Checked: RWC	Project No: 512A5-10-335
Drawing Finish Date: 10/15/2012		Approved: Director, Medical Center:	Location: PERRY POINT MARYLAND	Drawn: JMA	Drawing No: 501-G10.0	Dwg. 1 of 2
Drawing Approved: JOE BANACH						