

one eighth inch = one foot
0 4 8 16
one quarter inch = one foot
0 4 8
three eighths inch = one foot
0 4
one half inch = one foot
0 4
one inch = one foot
0 2 4
three quarters inch = one foot
0 2 4
one inch = one foot
0 2 4
one and one half inches = one foot
0 6 12
three inches = one foot
0 6 12
6"

VAMC-WADE PARK CLEVELAND
TR HOUSE IMPROVEMENTS

FINAL CD SUBMISSION - 01-14-13

DEPARTMENT OF VETERANS AFFAIRS
10701 EAST BOULEVARD
CLEVELAND, OHIO 44106

VAMC PROJECT NO.: 541-12-125

INDEX OF DRAWINGS:

1-X1 COVER SHEET

CIVIL

- C-1 DEMOLITION PLAN
- C-2 SITE PLAN
- C-3 MISCELLANEOUS DETAILS

ARCHITECTURAL

- 1-0 ARCHITECTURAL SITE PLAN / PHASING PLANS
- 1-1 STORAGE BUILDING PLANS / BUILDING CODE SUMMARY
- 1-2 STORAGE BUILDING EXTERIOR ELEVATIONS, BUILDING SECTION
- 1-3 WALL SECTIONS
- 1-4 DUMPSTER ENCLOSURE PLANS, ELEVATIONS, DETAILS

MECHANICAL

- M1 MECHANICAL LEGEND, SCHEDULES, DETAILS AND NOTES
- M2 MECHANICAL PLAN

ELECTRICAL

- E1 ELECTRICAL SITE PLAN AND LEGEND
- E2 GARAGE AND SHELTER ELECTRICAL PLANS

ARCHITECT:
MAKOVICH & PUSTI
ARCHITECTS, INC.

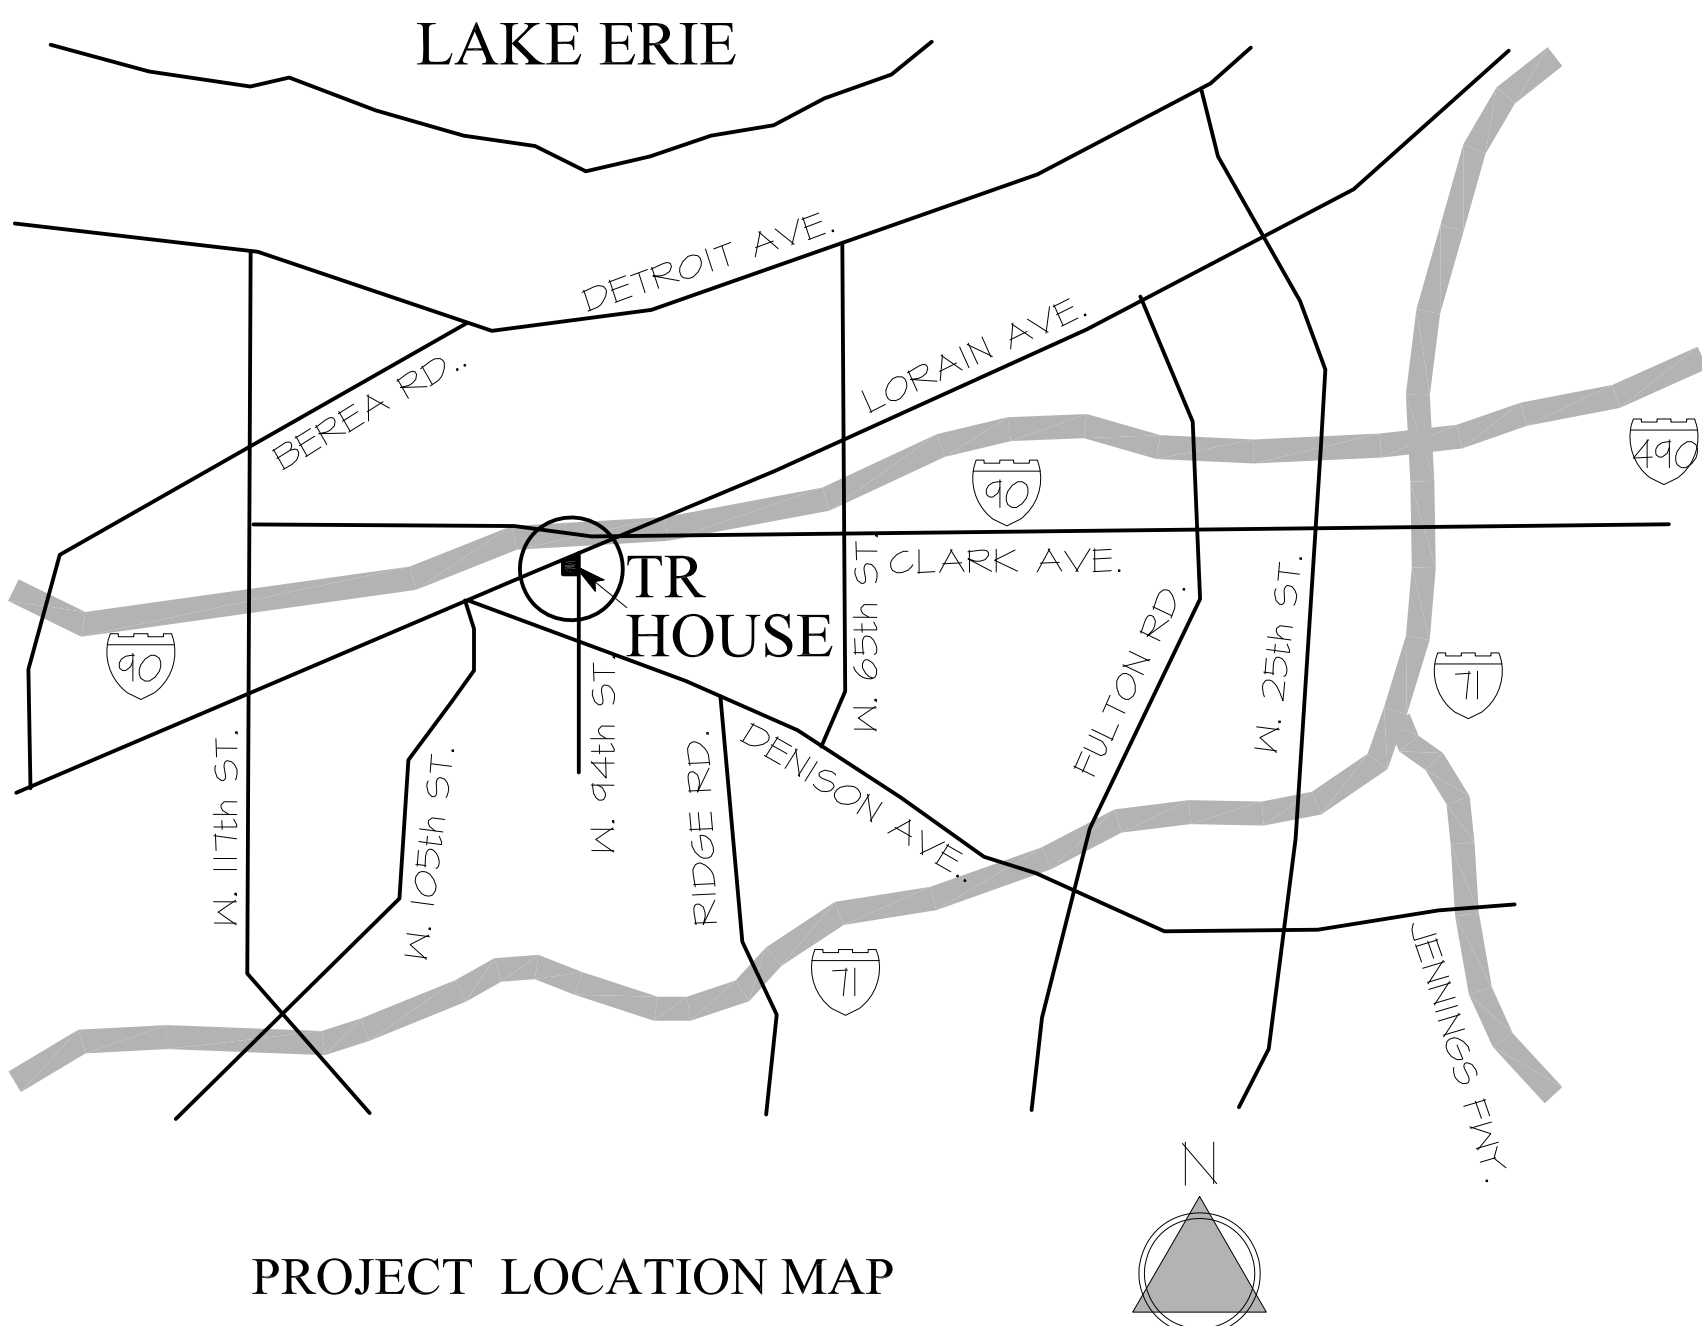
111 FRONT STREET
BEREA, OHIO 44017
Ph.: 440-891-8910
Fax: 440-891-0086
EMAIL: mmolchan@mparc.com

CIVIL ENGINEER
EUTHENICS, INC.

8235 MOHAWK DRIVE
STRONGSVILLE, OHIO 44136
Ph.: 440-260-1555
Fax: 440-260-1544
EMAIL: arpiatak@euthenics-inc.com




MECHANICAL & ELECTRICAL ENGINEERS
FREDRICK, FREDRICK & HELLER ENGINEERS, INC.

672 EAST ROYALTON ROAD
BROADVIEW HEIGHTS, OHIO 44147
Ph.: 440-546-9696
Fax: 440-546-9699
EMAIL: FFH@FFHEngineers.com



FOR CONSTRUCTION

FULLY SPRINKLERED

		CONSULTANTS:		ARCHITECT/ENGINEERS:	Drawing Title		Project Title		Project Number		Office of Construction and Facilities Management	
					COVER SHEET		VAMC WADE PARK CLEVELAND TR HOUSE IMPROVEMENTS		541-12-125			
					Approved: Project Director		Location 9401 LORAIN AVE., CLEVELAND, OHIO 44102		Building Number			
				 MAKOVICH & PUSTI ARCHITECTS, INC. 111 FRONT STREET, BEREA, OHIO 44017 (440) 891-8910 (440) 891-0086 F			Drawing Number		1-X1		 Department of Veterans Affairs	
FINAL CD SUBMISSION	01-14-13						Date		Checked By			
Revisions:	Date								-			