

NOTE:
FOR BASIC FIRE PROTECTION DIAGRAM.
SEE FIRE PROTECTION PLANS, FP PREFIX
DRAWINGS. FOR SPECIFIC PARTITION TYPES
SEE ARCHITECTURAL DIMENSION PLANS.





Western Team Director

Approved Project Director

ARCHITECT
The Ratcliff Architects
5856 Doyle Street
Emeryville, CA 94608
P.O. Box 1022
Berkeley, CA 94701
(510) 666-1972
ASSOCIATE ARCHITECT
Stone, Maccarini and Patterson
One Market Plaza
Spear Street Tower, Suite 400
San Francisco, CA 94105
(415) 227-0100

CONSULTANTS
Structural Engineers
H.J. Degenkolb Associates
Mechanical Engineers
Capital Engineering Consultants, Inc.
Electrical Engineers
The Engineering Enterprise
Cost Estimator
Adamson Associates
Landscape Design/
Land Planning
Oni Lang Associates, Inc.
Civil Engineer
Sandra Hunter Jones
Elevator Consultant
Sykes and Hennessy
Fire Protection
Rolf Jensen and Associates
Food Service Consultant
Cini-Little International, Inc.

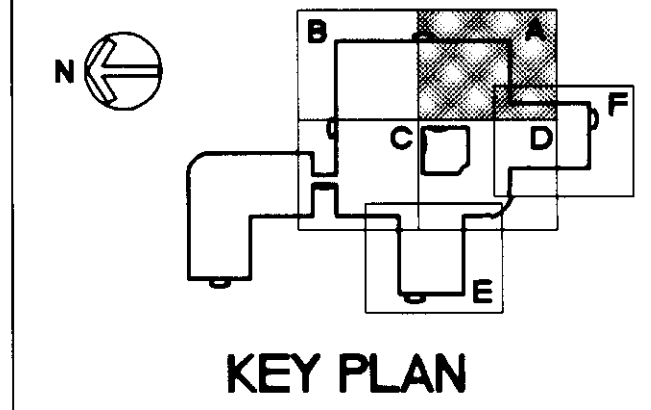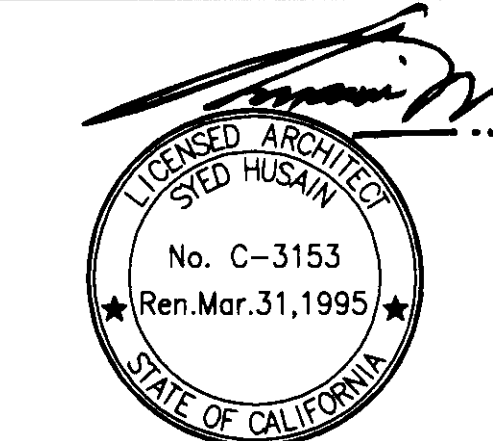

RECORD DRAWINGS
AUG 31 1998

Revisions
Location
VA Medical Center
Palo Alto, CA

Project Title
**REPLACE CLINICAL/
BED TOWER FOR
SEISMIC CORRECTIONS**

FULLY SPRINKLERED

TRA Project No. 93007
Checked
Drawn

Drawing Title
**THIRD FLOOR
DIMENSION PLAN
AREA A**

Scale 1/8" = 1'-0"
VA Project No. 640-042G
Building Number 100
Date 2 MAY 94
Drawing No. 2.3.1A
Dwg. of

