

27

28
29

34

35


 
 
 
36

39



40

41


42

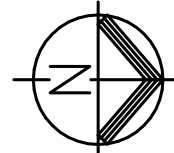








PENTHOUSE KEY PLAN
SCALE: N.T.S.

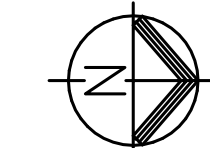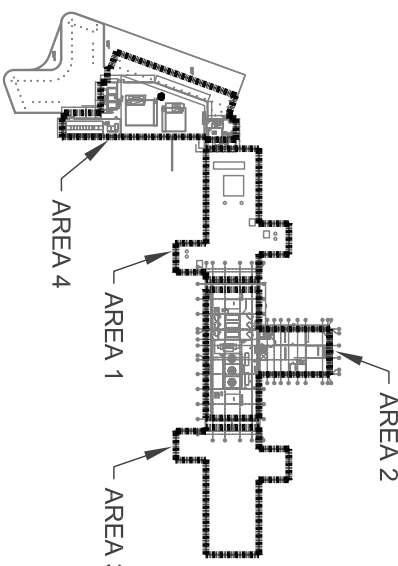

 PARTIAL PENTHOUSE - STEAM PIPING - AREA 3




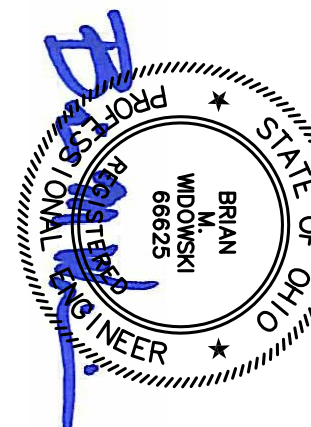
1

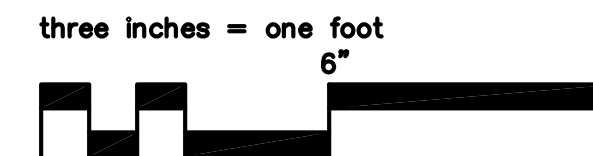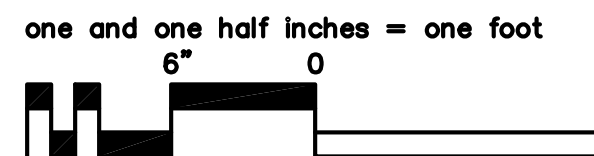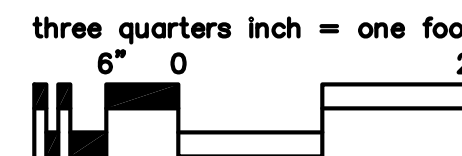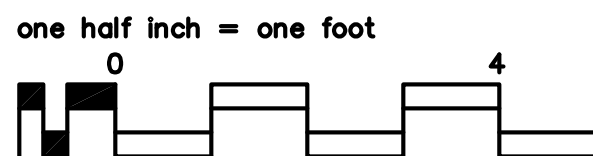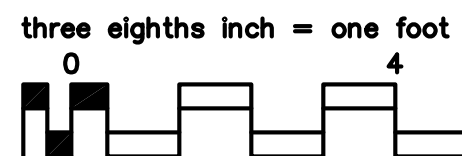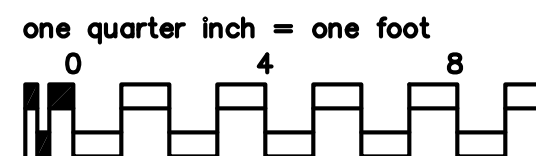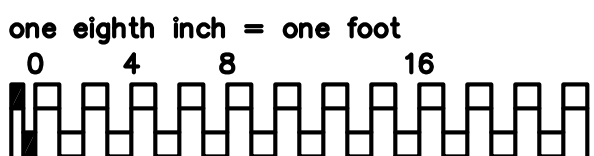

ISSUED FOR REBID	06-23-13
FINAL CD SUBMISSION	12-21-12
85% SUBMISSION	11-30-12
65% SUBMISSION	11-16-12
Revisions:	Date

CONSULTANTS:

 **FREDRICK, FREDRICK & HEILBR**
ENGINEERS, INC.
872 EAST ROYALTON ROAD
BROADVIEW HTS., OHIO 44147
TEL: (440) 346-8888
FAX: (440) 346-8888



ARCHITECT:

Drawing Title
**PARTIAL PENTHOUSE STEAM
PIPING PLAN - AREA 3**

Approved Project Director

Project Title
**STEAM TRAP MONITORING,
INSULATION AND PIPING
UPGRADES**

Location
VAMC - WADE PARK

Date
12-21-12

WFW

JMF

Building Number
1

Drawing Number
3-PH-3

