


BASEMENT KEY PLAN
SCALE: N.T.S.

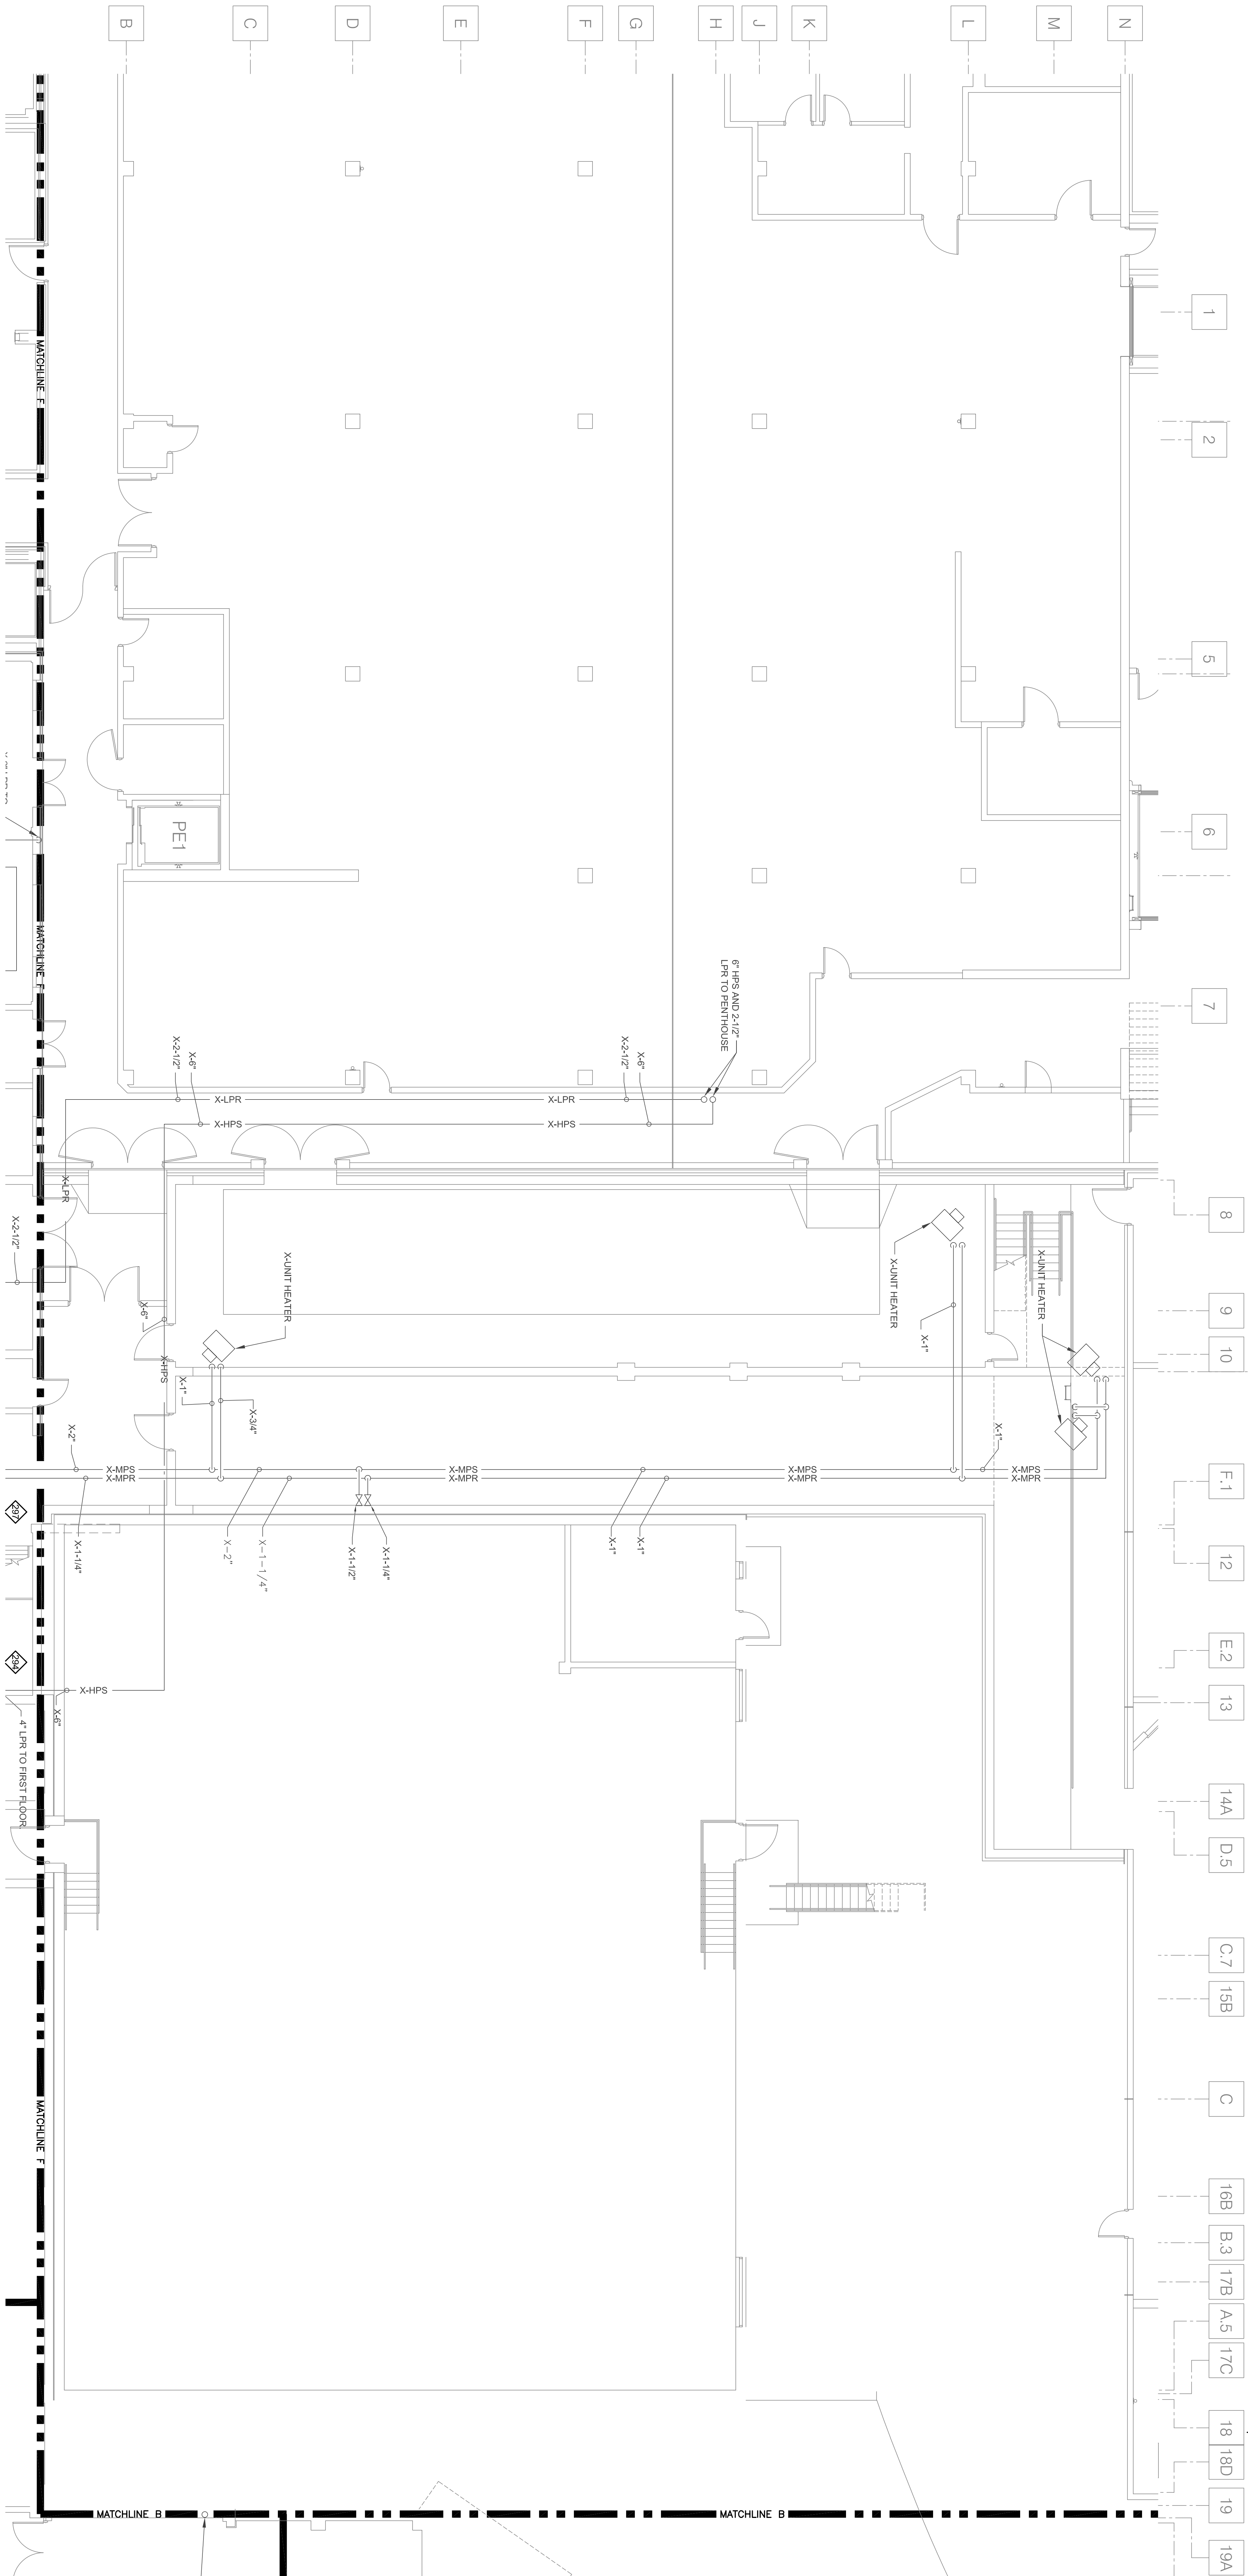

PARTIAL BASEMENT - STEAM PIPING - AREA 6
SCALE: 1/8" = 1'-0"
0' 4' 8' 16' 32'

CONSULTANTS:		ARCHITECT:	
ISSUED FOR PERIOD FINAL CD-SUBMISSION 65% SUBMISSION 65% SUBMISSION		Drawing Title BASEMENT FLOOR PLAN AREA 6	
FREDRICK, FREDRICK & HELLER ENGINEERS, INC. 872 EAST ROYALTON ROAD BROADVIEW HTS., OHIO 44147 PH: (440) 546-8888		Approved Project Director	
Date		Project Title STEAM TRAP MONITORING, INSULATION AND PIPING UPGRADES	
Date		Location VAMC - WADE PARK	
Date		Checked WFW	
Date		Drawn JMF	
Date		Drawing Number 3-B-6	
Date		Building Number 1	
Date		Office of Facilities Management	