



FOURTH FLOOR KEY PLAN
SCALE: N.T.S.

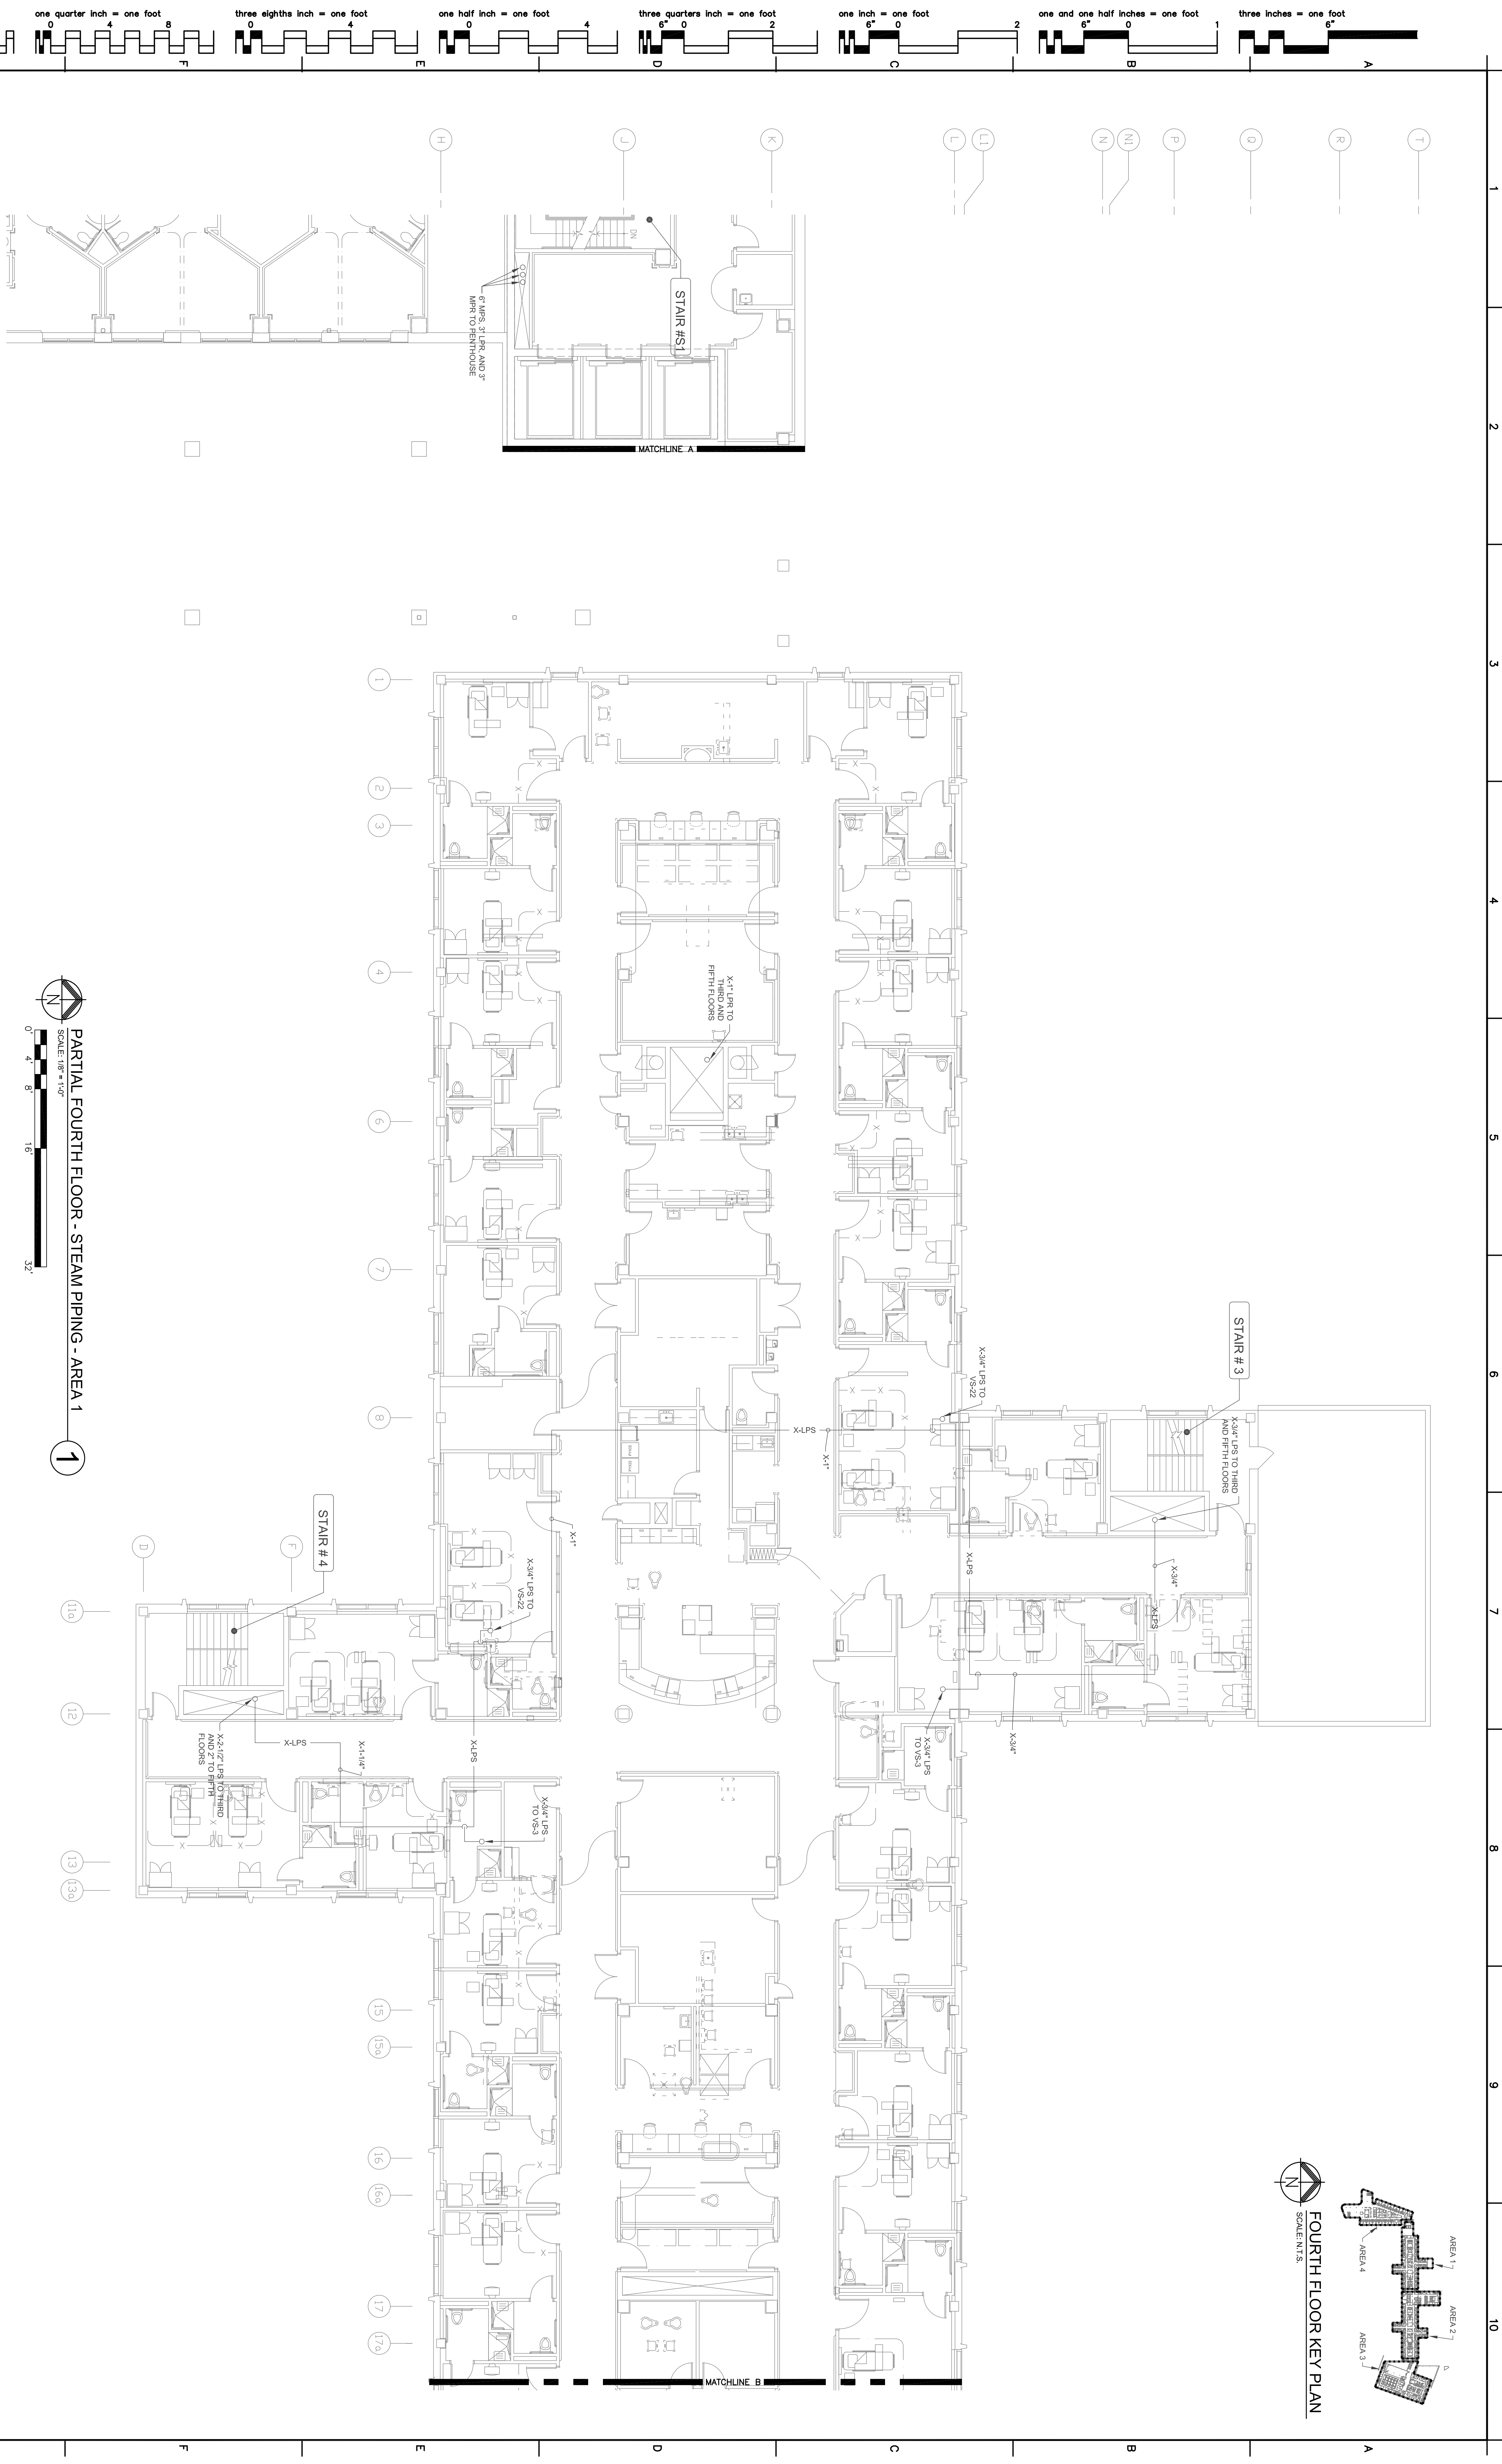

PARTIAL FOURTH FLOOR - STEAM PIPING - AREA 1
SCALE: 1/8" = 1'-0"
0' 4' 8' 16' 32'

CONSULTANTS:

FREDRICK, FREDRICK & HELLER
ENGINEERS, INC.
872 EAST ROYALTON ROAD
BROADVIEW HTS., OHIO 44147
TEL: (440) 344-8800
FAX: (440) 344-8888

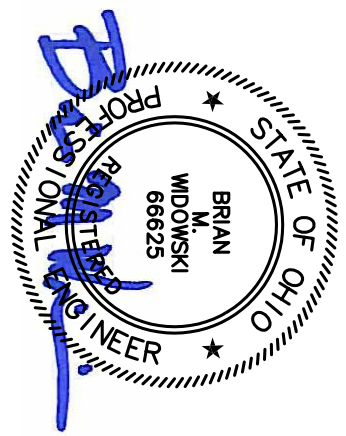

ARCHITECT:

Drawing Title
FOURTH FLOOR PLAN
AREA 6

Approved Project Director

Project Title
STEAM TRAP MONITORING,
INSULATION AND PIPING
UPGRADES
VAMC - WADE PARK

Project Number
541-12-115
Building Number
1

Date
12-21-12

WFW

JWF

Drawing Number
3-4-1

Office of
Facilities
Management

