
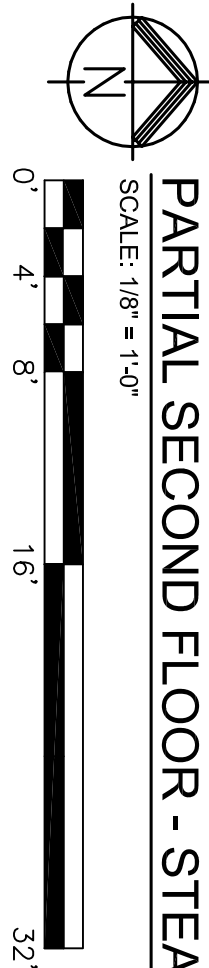


SECOND FLOOR KEY PLAN
SCALE: N.T.S.









- O
- P
- R
- S
- U
- V
- W
- X
- Y

CODED NOTES:

DISCONNECT PIPING TO HEAT EXCHANGER & PASE APPROXIMATELY 2' TO AN ELEVATION WHERE THE DISCHARGE OF TRAP 10A WILL GRAVITY DRAIN INTO THE ADJACENT CONDENSATE RECEIVER.

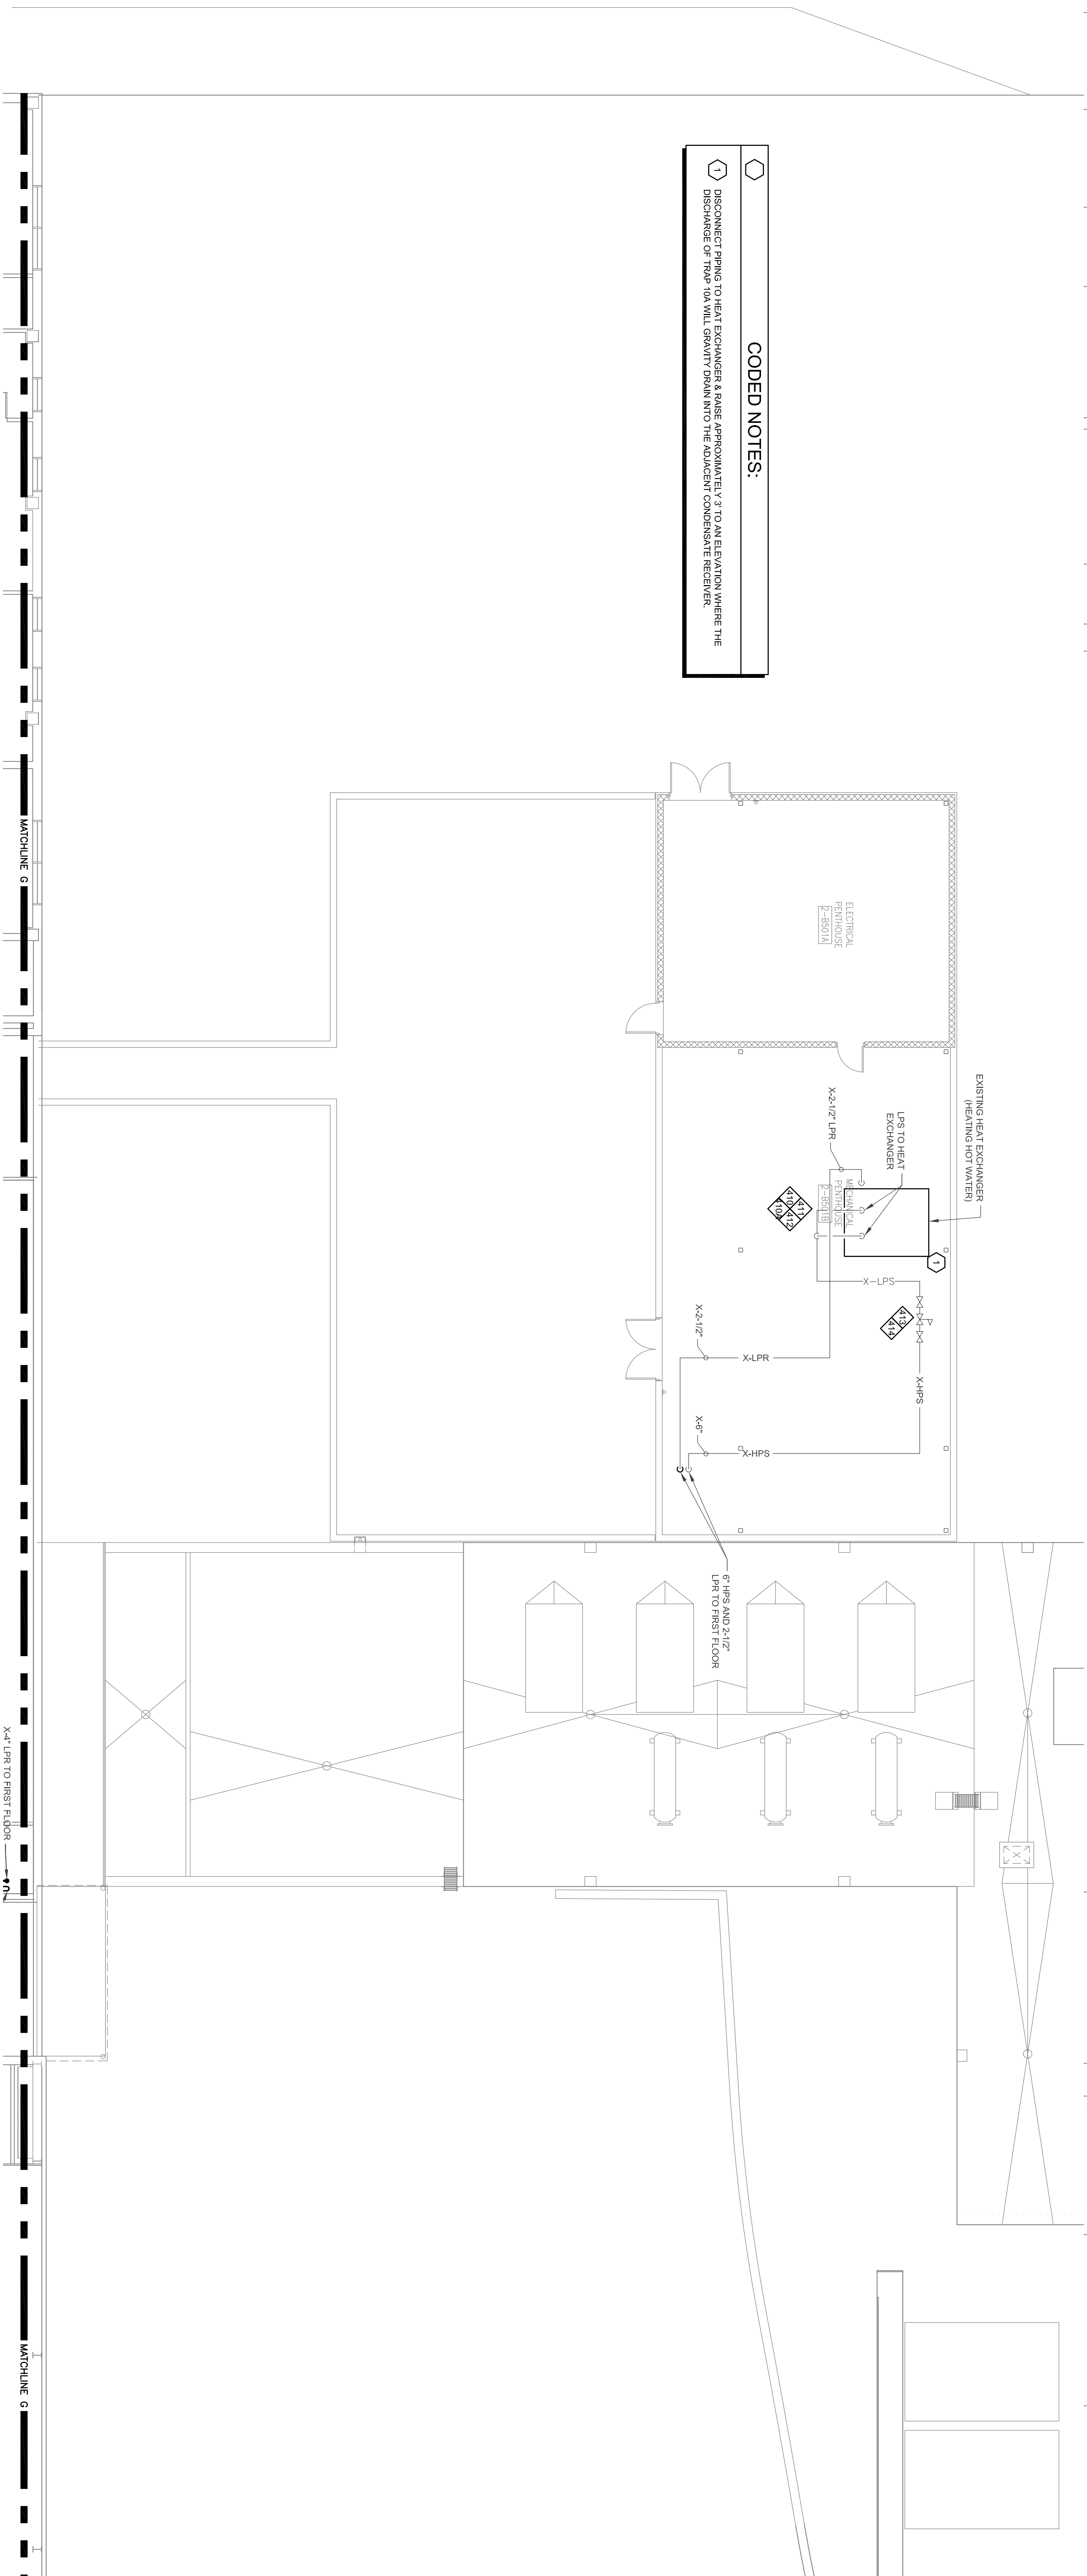


PARTIAL SECOND FLOOR - STEAM PIPING - AREA 6
1

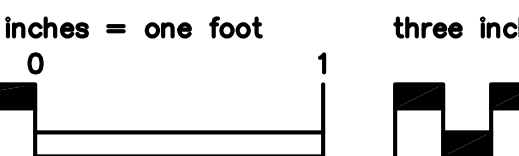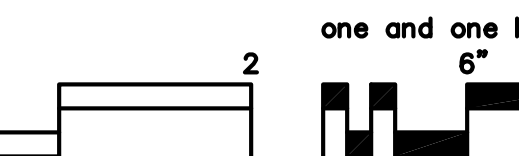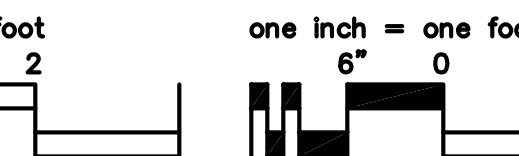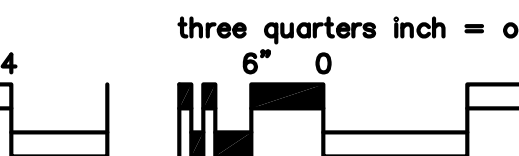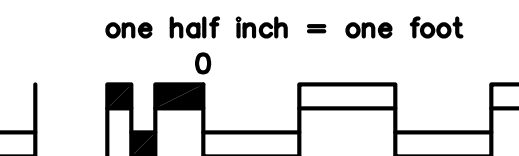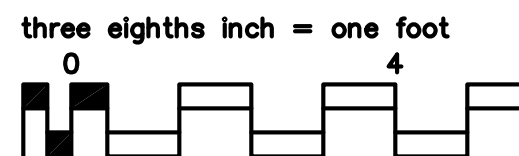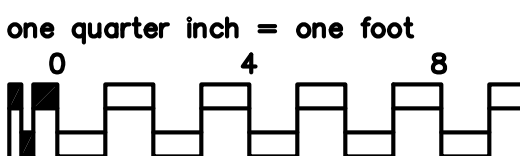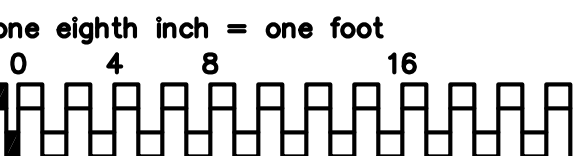


ISSUED FOR REBID	06-23-13
FINAL CD-SUBMISSION	12-21-12
65% SUBMISSION	11-30-12
65% SUBMISSION	11-16-12
Revisions:	Date

CONSULTANTS:



 FREDERICK, FREDRICK & HEILER
ENGINEERS, INC.
672 EAST ROYALTON ROAD
BROADVIEW HTS., OHIO 44147
TEL: (440) 346-8800
FAX: (440) 346-8888



ARCHITECT:

**SECOND FLOOR PLAN
AREA 6**

Approved: Project Director

Drawing Title

Project Title

Location

Date

STEAM TRAP MONITORING,
INSULATION AND PIPING
UPGRADES

VAMC - WADE PARK

Checked: WFW

Drawn: JWF

Project Number: 641-12-115

Building Number: 1

Drawing Number: 3-2-6

Office of
Facilities
Management

