

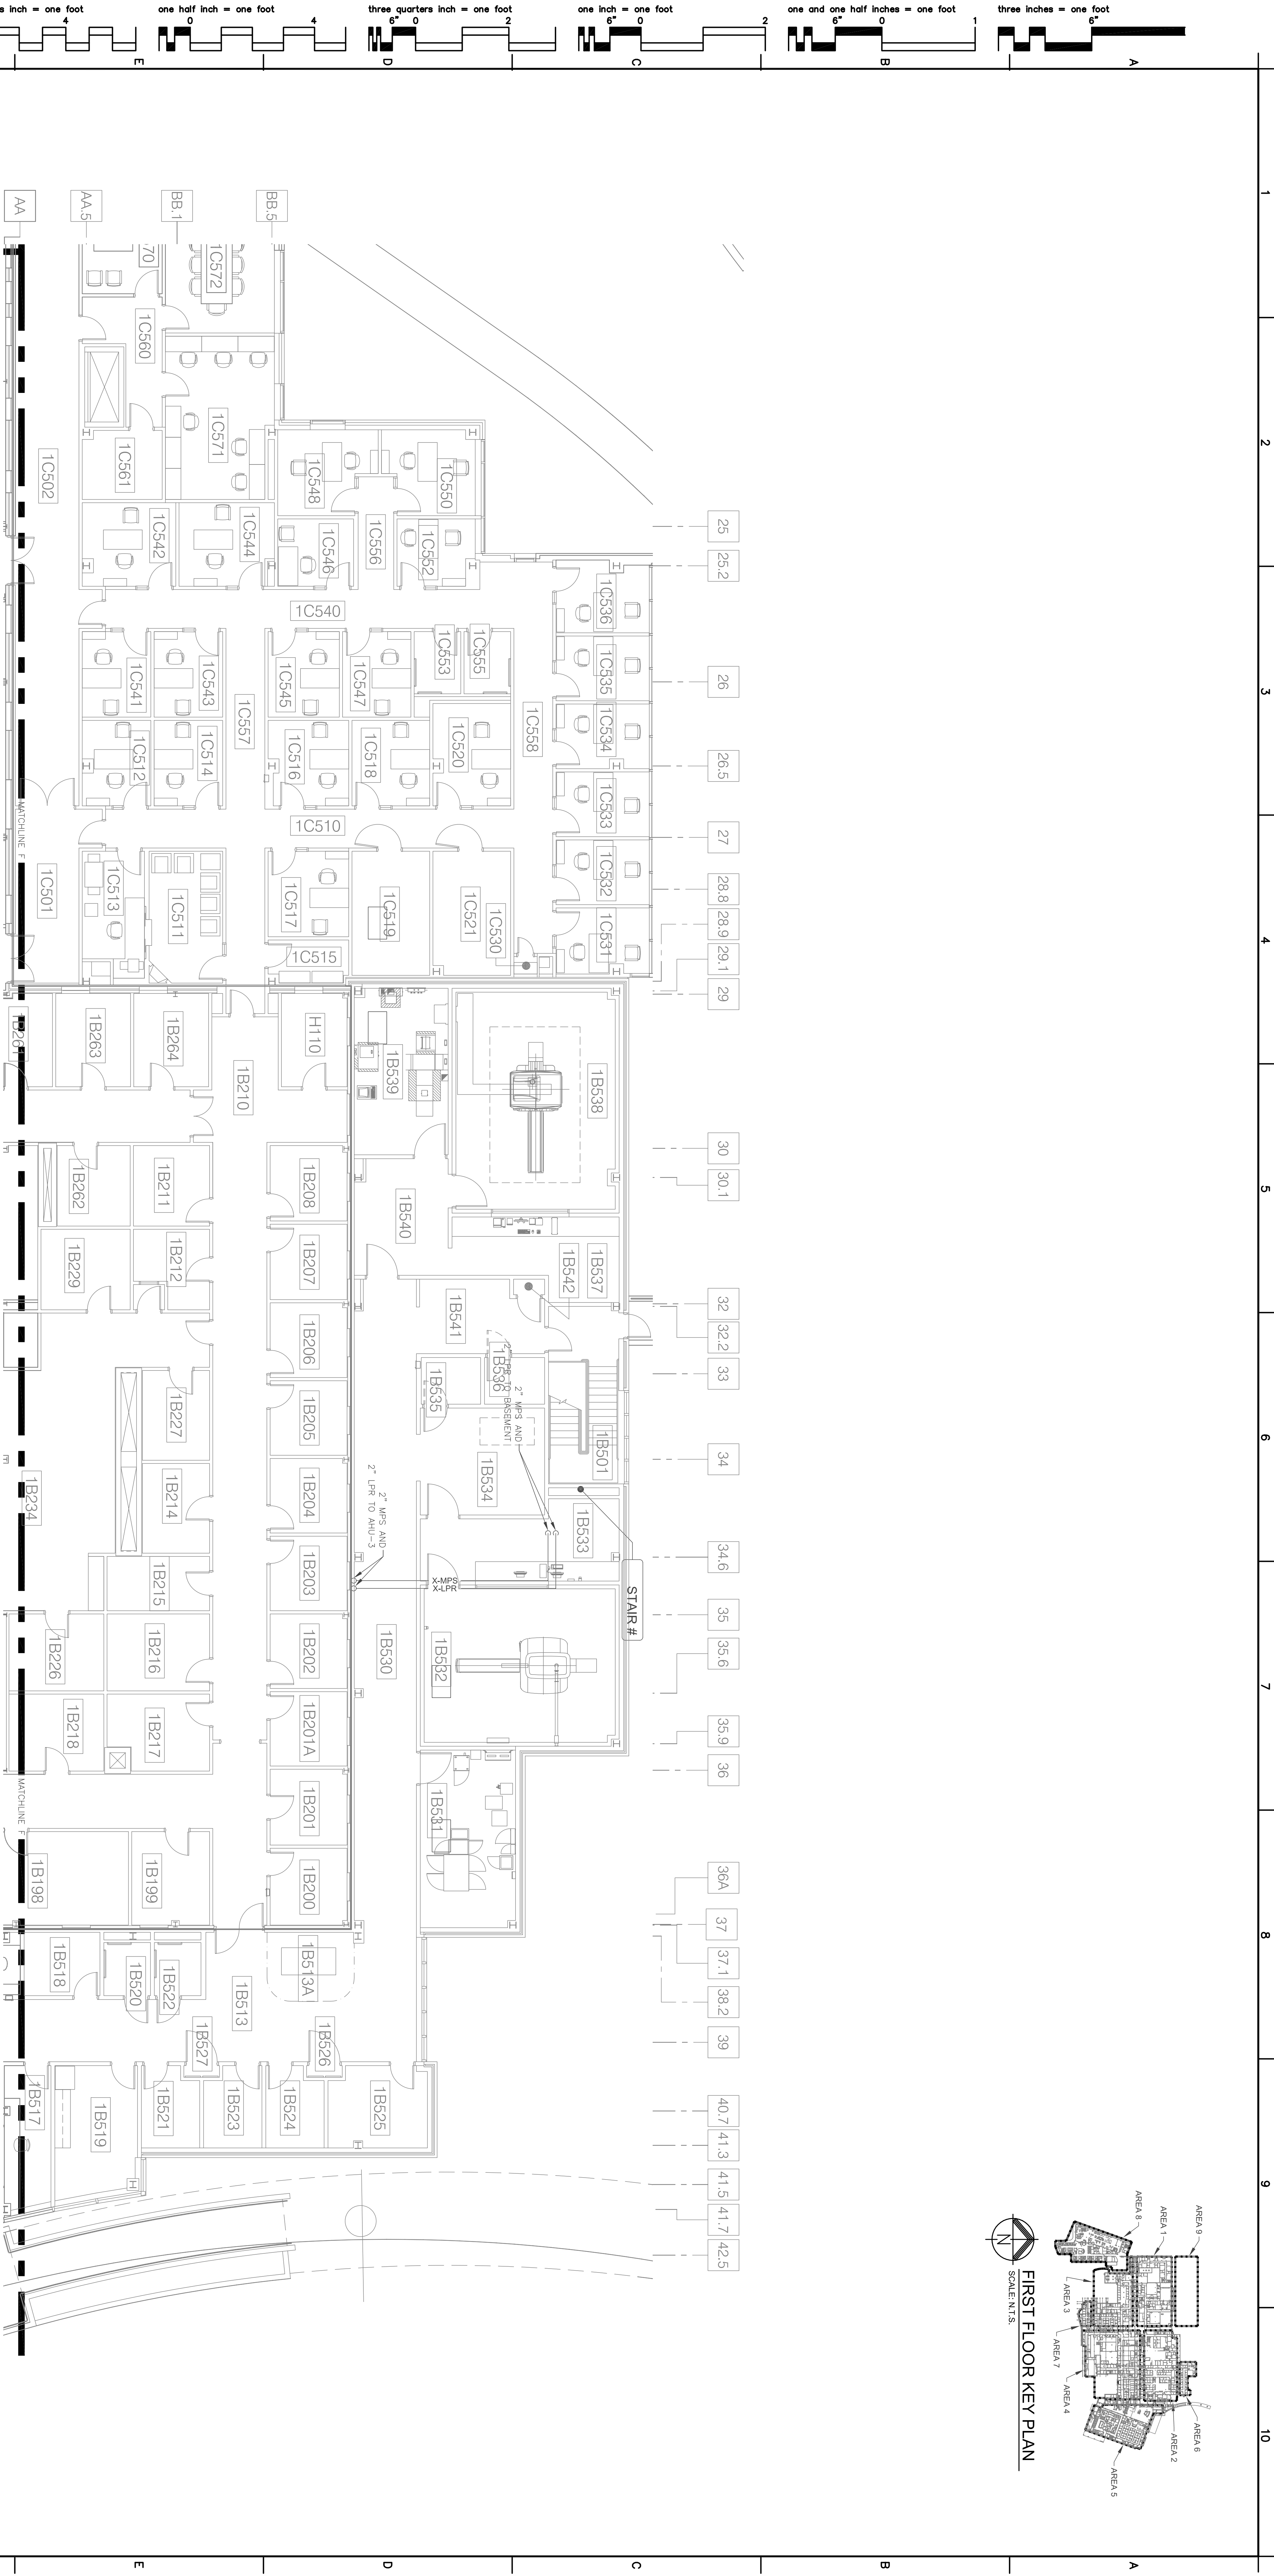
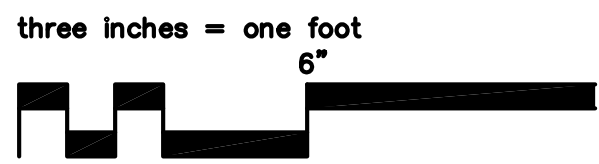
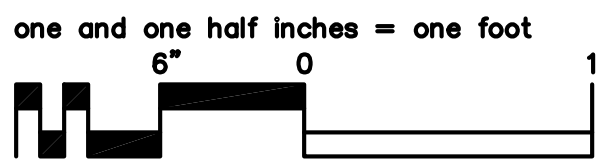
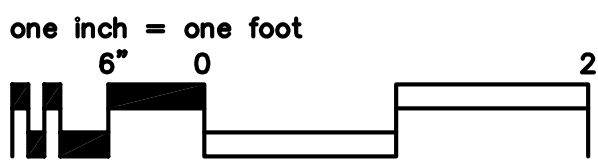
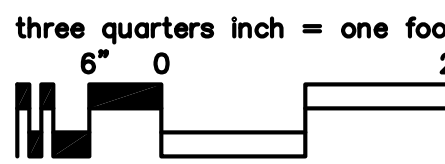
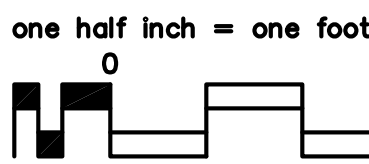
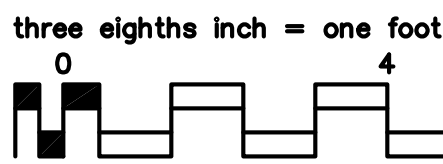


FIRST FLOOR KEY PLAN
SCALE: N.T.S.

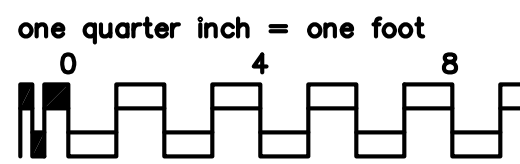


PARTIAL FIRST FLOOR - STEAM PIPING - AREA 6
SCALE: 1/8" = 1'-0"
0 4' 8' 16' 32'

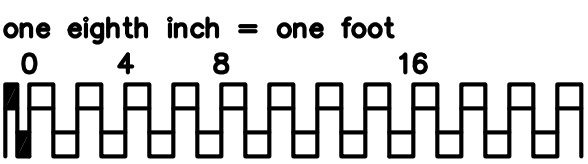

ISSUED FOR PERIOD	06-23-13
FINAL CD. SUBMISSION	12-21-12
85% SUBMISSION	11-30-12
65% SUBMISSION	11-16-12
Revisions:	Date

CONSULTANTS:

FREDRICK, FREDRICK & HELLER
ENGINEERS, INC.
872 EAST ROYALTON ROAD
BROADVIEW HTS., OHIO 44147
TEL: (440) 346-8888
FAX: (440) 346-8888

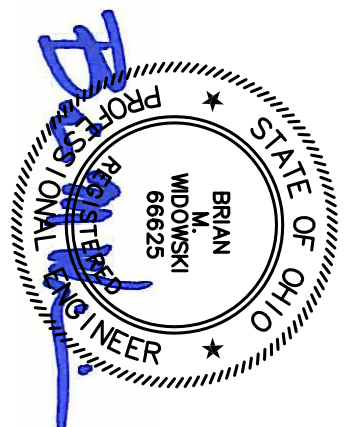

ARCHITECT:

Drawing Title
**FIRST FLOOR PLAN
AREA 6**

Approved Project Director

Project Title
**STEAM TRAP MONITORING,
INSULATION AND PIPING
UPGRADES**

Location
VAMC - WADE PARK

Date
12-21-12

WFW

JMF

Checked
1

Drawn
3-1-6

Project Number
641-12-115

Building Number
1

Drawing Number
3-1-6

Office of
Facilities
Management

