


three inches = one foot
one and one half inches = one foot
one inch = one foot
three quarters inch = one foot
one half inch = one foot
three eighths inch = one foot
one quarter inch = one foot
one eighth inch = one foot




Overall Ground Floor
1/16" = 1'-0"

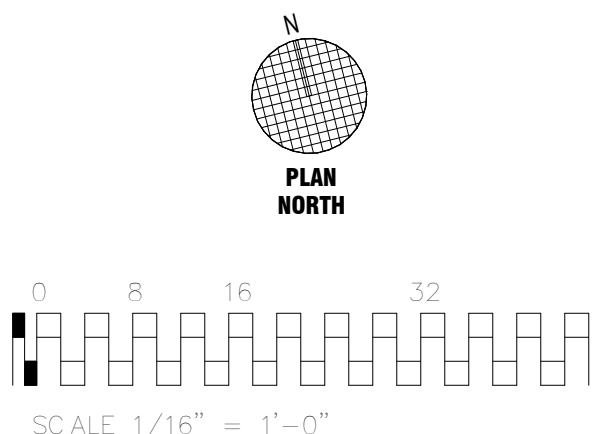

COMPLETE DP II, III and IV COORDINATED SET - AS BUILT

<div>AS BUILT COMPLETE DP II, III and IV SET Revisions: 16 MAY 11 10 MAY 10 Date</div>	<div>CONSULTANTS: JF Ahern Co. N56 W16743 Ridgewood Drive Menomonee Falls, WI 53051 TEL 262 252-5921 FAX 262 252-5927</div>	<div>Roman Electric Co., Inc. 640 South 70th Street Milwaukee, WI 53214 TEL 414 771-5400 FAX 414 471-8693</div>	<div>David J. Frank Design Group N120 W21350 Freistadt Rd PO Box 70 Germantown, WI 53022 TEL (262) 255-4888 FAX (262) 628-4729 email: mail@davidjfrank.com www.davidjfrank.com</div>	<div>CONTRACTOR: C3T Construction Co. 6045 N. 55th St. Suite 102 Milwaukee, WI 53218 TEL 414 464-0382 FAX 414 461-2972</div>	<div>Gilbane Building Company 101 West Pleasant Street, Suite 104 Milwaukee, WI 53212 TEL 414 287-2600 FAX 414 287-2613</div>	<div>ARCHITECT/ENGINEERS: Plunkett Raysich Architects, LLP 11000 West Park Place Milwaukee, WI 53224 TEL 414 359-3060 FAX 414 359-3070 Email: pra@prarch.com Web: http://www.prarch.com PRA PROJECT # 09023</div>	<div>The Sigma Group 1300 West Canal Street Milwaukee, WI 53233 TEL 414 643-4200 FAX 414 643-4210</div>	<div>Komp Engineering, Inc. 1820 S. 1st Street Milwaukee, WI 53204 TEL 414 277-9899 FAX 414 277-9192</div>	<div>Drawing Title Overall Ground Floor Plan</div>	<div>Approved: Project Director</div>	<div>Project Title Spinal Cord Injury and Disorder Center</div>	<div>Project Number 695-401</div>	<div>Building Number 144</div>	<div>Location Milwaukee, Wisconsin</div>	<div>Date 16 MAY 2011</div>	<div>Checked PRA</div>	<div>Drawn PRA</div>	<div>Drawing Number AS-200</div>	<div>Office of Construction and Facilities Management</div>	<div>Department of Veterans Affairs</div>
--	---	---	--	--	---	---	---	--	--	---------------------------------------	---	---------------------------------------	------------------------------------	--	---------------------------------	----------------------------	--------------------------	--------------------------------------	---	---

one eighth inch = one foot
one quarter inch = one foot
three eighths inch = one foot
one half inch = one foot
three quarters inch = one foot
one inch = one foot
one and one half inches = one foot
two inches = one foot
three inches = one foot

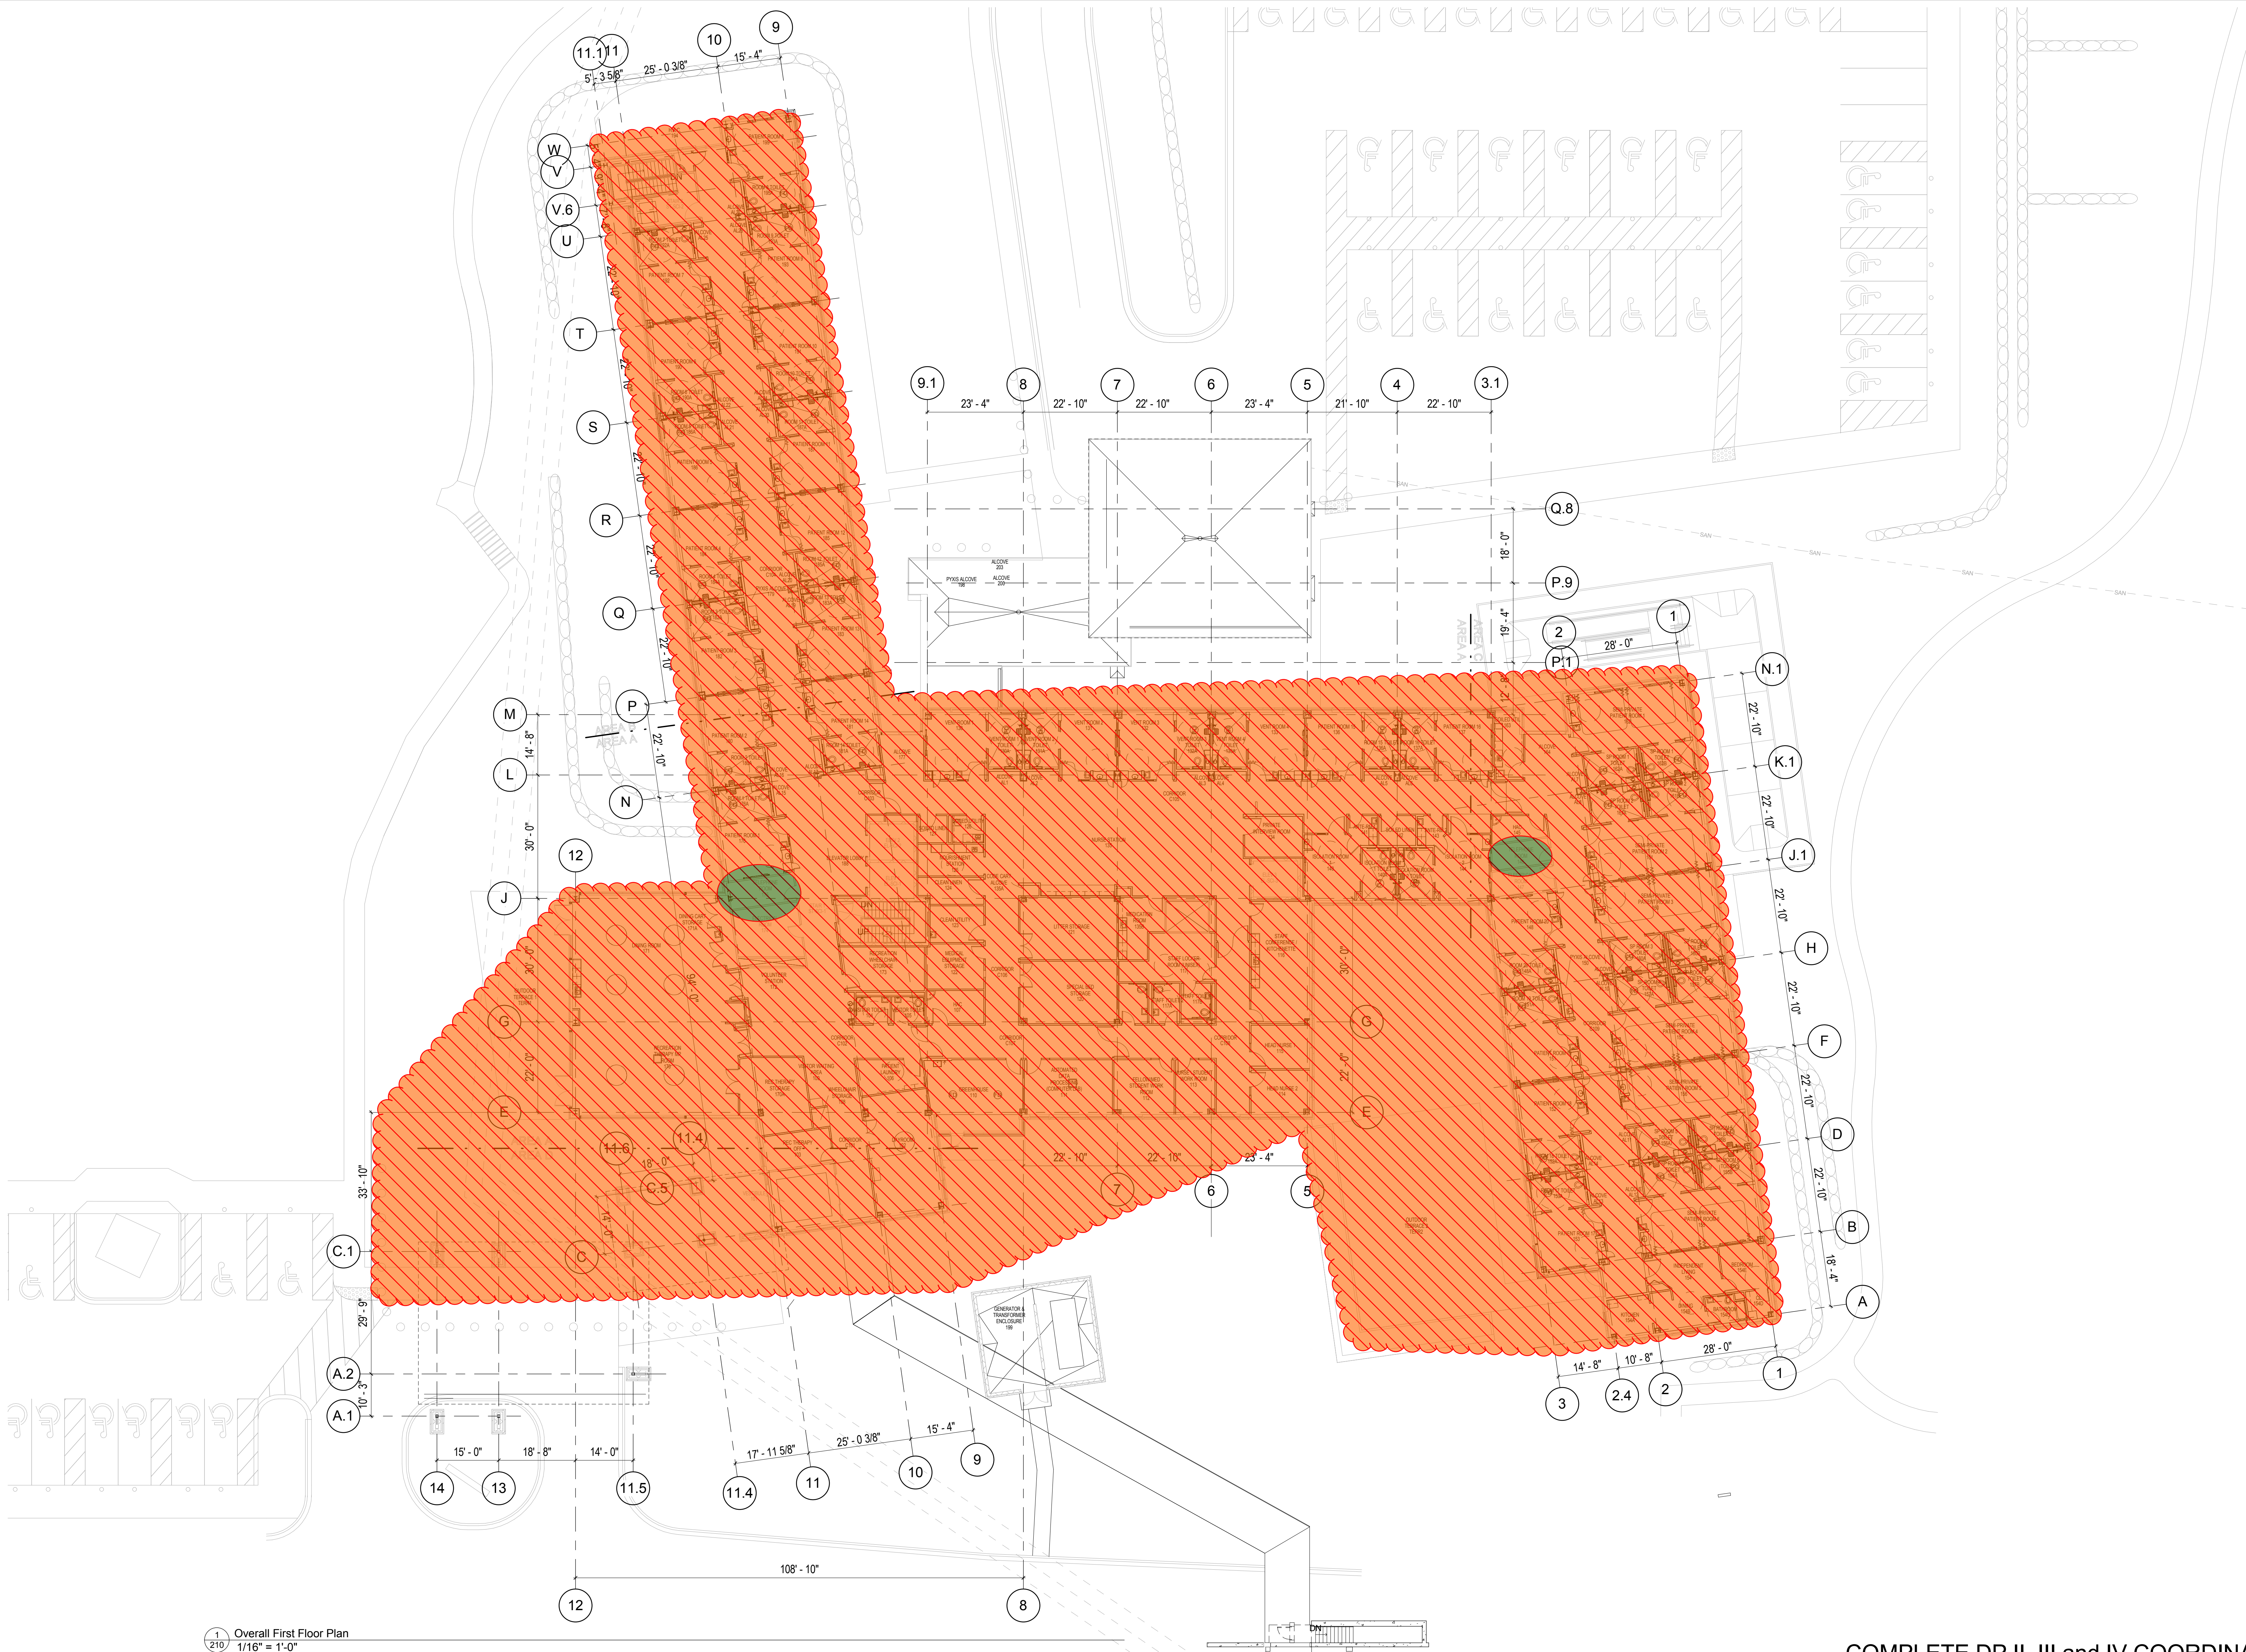

1 Overall First Floor Plan
1/16" = 1'-0"

AS BUILT	16 MAY 11
COMPLETE DP II, III and IV SET	10 MAY 10
Revisions:	Date

CONSULTANTS:

JF Ahern Co.
N56 W16743 Ridgewood Drive
Menomonee Falls, WI 53051
TEL 262 252-5921
FAX 262 252-5927

Roman Electric Co., Inc.
640 South 70th Street
Milwaukee, WI 53214
TEL 414 771-5400
FAX 414 471-8693

David J. Frank Design Group
N120 W21350 Freistadt Rd
PO Box 70
Germantown, WI 53022
TEL (262) 255-4888
FAX (262) 628-4729
email: mail@davidjfrank.com
www.davidjfrank.com

CONTRACTOR:

C3T Construction Co.
6045 N. 55th St, Suite 102
Milwaukee, WI 53218
TEL 414 464-0382
FAX 414 461-2972

Gilbane Building Company
101 West Pleasant Street, Suite 104
Milwaukee, WI 53232
TEL 414 287-2600
FAX 414 287-2613

ARCHITECT/ENGINEERS:

Plunkett Raysich Architects, LLP
11000 West Park Place
Milwaukee, WI 53224
TEL 414 359-3060
FAX 414 359-3070
Email: pra@prarch.com
Web: http://www.prarch.com
PRA PROJECT # 09023

The Sigma Group
1300 West Canal Street
Milwaukee, WI 53233
TEL 414 643-4200 FAX 414 643-4210

Komp Engineering, Inc.
1820 S. 1st Street
Milwaukee, WI 53204
TEL 414 277-9899 FAX 414 277-9192

Drawing Title

Overall First Floor Plan

Approved: Project Director

COMPLETE DP II, III and IV COORDINATED SET - AS BUILT

Project Title
Spinal Cord Injury and Disorder Center

Location
Milwaukee, Wisconsin

Date
16 MAY 2011

Checked
PRA

Drawn
PRA

Project Number
695-401

Building Number
144

Drawing Number

AS-210

Office of
Construction
and Facilities
Management

Department of
Veterans Affairs