



GENERAL NOTES - NURSES CALL, CODE BLUE AND PA SYSTEMS


- EXISTING NURSE CALL, CODE BLUE, EQUIPMENT HAS BEEN RE-MOVED. PROVIDER/INSTALLER SHALL PROVIDE NEW EQUIPMENT/DEVICES AS SHOWN ON THE DRAWINGS. THE NEW INSTALLATION SHALL MATCH AND INTEGRATE WITH THE EXISTING CAMPUS HEAD END SYSTEM (AMCOM).
-
- THIS DRAWING IS DIAGRAMMATIC, THE EXACT LOCATIONS SHALL BE FIELD MODIFIED WHERE NEEDED. PRIOR TO CONSTRUCTION, THE VENDOR/INSTALLER SHALL SUBMIT ANY MODIFICATIONS TO THE COR.
- THE GOVERNING DOCUMENT FOR THE INSTALLATION OF SYSTEM SHALL BE THE NURSES CALL AND CODE BLUE SYSTEMS SPECIFICATION 27 52 23. THIS DRAWING IS A SUPPLEMENTAL DESIGN GUIDE.
- AS PART OF THIS DESIGN, THE VENDOR/INSTALLER SHALL PROVIDE A UPS SYSTEM TO KEEP THE SYSTEM FULLY FUNCTIONAL FOR ONE HOUR UPON LOSS OF POWER.
- VENDOR/INSTALLER SHALL COORDINATE WITH COR FOR THE EXACT LOCATIONS OF THE NURSE CALL AND CODE BLUE MASTER STATION & TERMINAL CABINETS.

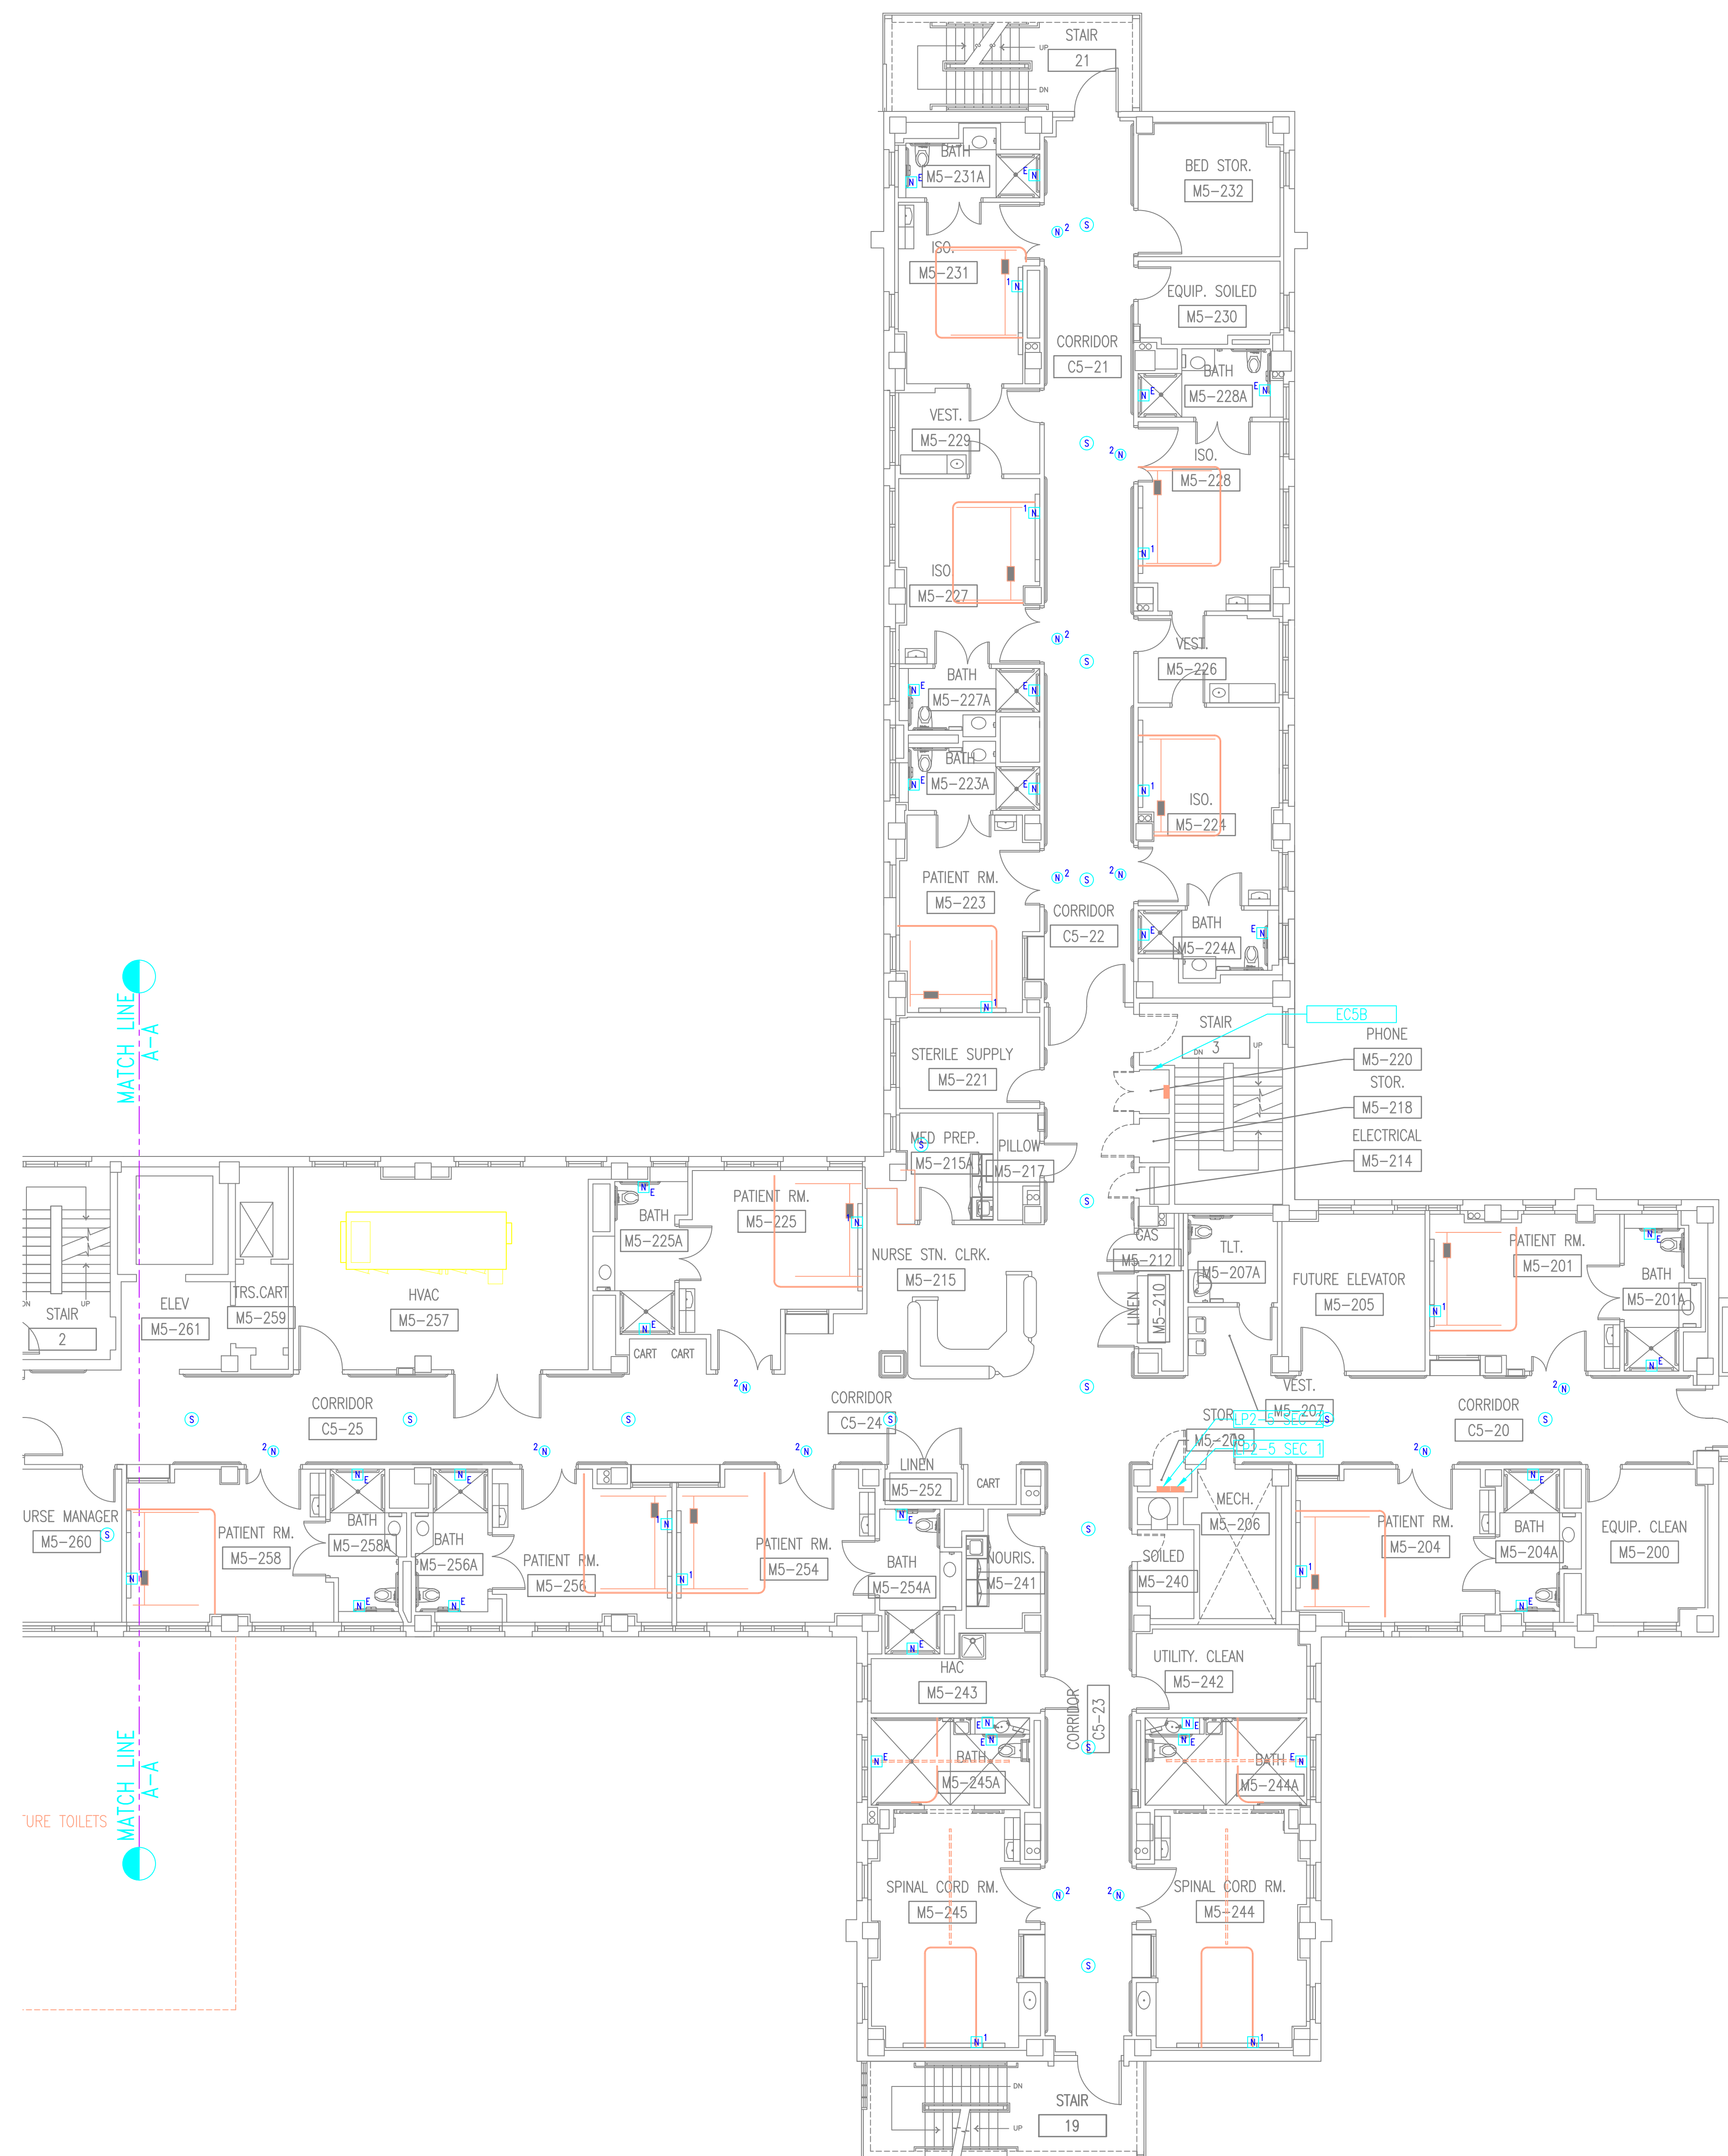

1 PARTIAL FIFTH FLOOR PLAN - INTERCOM/NURSE CALL
SCALE: 1/8"=1'-0"
NORTH

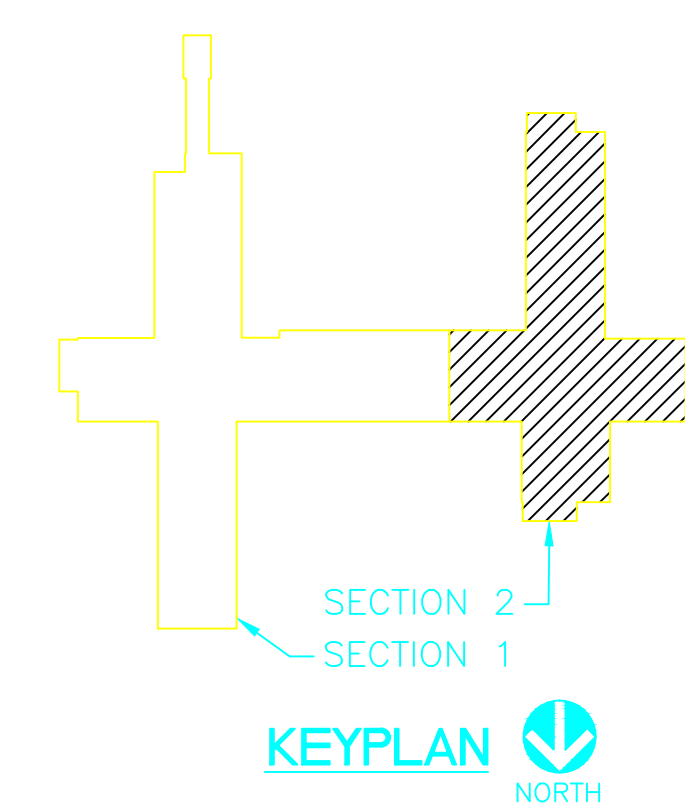

Revisions	Date
ISSUED FOR BID	10/29/11

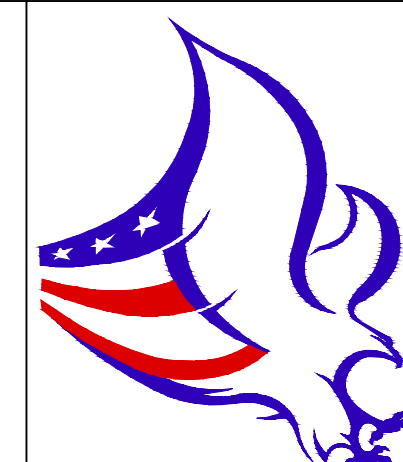

VA HEARTLAND NETWORK HEALTH CARE SYSTEM

KANSAS CITY VA MEDICAL CENTER

Drawing Title: PARTIAL 5th FLOOR INTERCOM/NURSE CALL PLAN		Project Title: KANSAS CITY, MO. INPATIENT SURGERY		Date: 09/11/09
Approved:	Building Number: 1	Checked: -	Drawn: CAC	Project No.: 901001
Approved:	Location: KANSAS CITY VA MEDICAL CENTER 4801 LINWOOD BOULEVARD, KANSAS CITY, MO		DRAWING NO.: ET1102 Dwg. 63 Of 67	

