

GENERAL NOTES - NURSES CALL AND CODE BLUE

- EXISTING NURSE CALL, CODE BLUE, EQUIPMENT HAS BEEN RE-MOVED. PROVIDER/INSTALLER SHALL PROVIDE NEW EQUIPMENT/DEVICES AS SHOWN ON THE DRAWINGS. THE NEW INSTALLATION SHALL MATCH AND INTEGRATE WITH THE EXISTING CAMPUS HEAD END SYSTEM (AMCOM).
-
- THIS DRAWING IS DIAGRAMMATIC, THE EXACT LOCATIONS SHALL BE FIELD MODIFIED WHERE NEEDED. PRIOR TO CONSTRUCTION, THE VENDOR/INSTALLER SHALL SUBMIT ANY MODIFICATIONS TO THE COR.
- THE GOVERNING DOCUMENT FOR THE INSTALLATION OF SYSTEM SHALL BE THE NURSES CALL AND CODE BLUE SYSTEMS SPECIFICATION 27 52 23. THIS DRAWING IS A SUPPLEMENTAL DESIGN GUIDE.
- AS PART OF THIS DESIGN, THE VENDOR/INSTALLER SHALL PROVIDE A UPS SYSTEM TO KEEP THE SYSTEM FULLY FUNCTIONAL FOR ONE HOUR UPON LOSS OF POWER.
- VENDOR/INSTALLER SHALL COORDINATE WITH COR FOR THE EXACT LOCATIONS OF THE NURSE CALL AND CODE BLUE MASTER STATION & TERMINAL CABINETS.

PLAN NOTES


- CONTRACTOR SHALL COORDINATE WITH THE RESIDENT ENGINEER AND THE NURSES STATION PROVIDER FOR THE EXACT LOCATION OF THE NURSES CALL AND CODE BLUE MASTER STATION.
- CONTRACTOR SHALL COORDINATE WITH THE RESIDENT ENGINEER AND THE NURSES STATION PROVIDER FOR THE EXACT LOCATION OF THE NURSES CALL AND CODE BLUE TERMINAL CABINET

NURSES STATION SYMBOLS

- NCS** NURSE'S CALL AND CODE BLUE MASTER STATION MTD ON NURSE'S COUNTER TOP UNLESS OTHERWISE NOTED.
- NCT** NURSE CALL AND CODE BLUE TERMINAL CABINET.
- N** NURSE CALL AND CODE BLUE STATION.
 - 1 = DUPLICATE FACILITIES FOR TWO BEDS (SEPARATE INDICATORS AT MASTER STATION) MTD 5'-0" [1524mm] AFF UNLESS OTHERWISE NOTED.
 - D = DUTY STATION, MTD 5'-0" [1524mm] AFF UNLESS NOTED OTHERWISE.
 - E = MTD 3'-0" [914mm] AFF FOR TOILET LOCATION OR 26" AFF FOR CABINET LOCATIONS BEHIND THE BED/CHAIRS. SEE DRAWING EP102 FOR EXACT CABINET LOCATIONS.
 - S = AUDIO VISUAL MALL STATION (STAFF) MTD 5'-0" [1524mm] AFF UNLESS OTHERWISE NOTED.
 - U = UTILITY CALL STATION, MTD 5'-0" [1524mm] AFF UNLESS OTHERWISE NOTED.
- 1** NURSE CALL AND CODE BLUE STATION.
 - 1 = NURSE'S CALL DOME LIGHT (SUFFIX INDICATES No OF LAMP) MTD 6" [152mm] ABOVE DOOR.
 - D = CORRIDOR DOME LIGHT.
 - C = NURSES CALL INDICATOR LIGHT. CONTRACTOR SHALL LOCATE AND INSTALL THE LIGHT DIRECTLY IN FRONT OF THE CURTAIN FOR EACH BED OR CHAIR. INSTALL PER MANUFACTURER'S INSTRUCTIONS, SURFACE MOUNTED ON CEILING GRID.



1 PARTIAL SEVENTH FLOOR PLAN
SCALE: 1/8"=1'-0"
NORTH

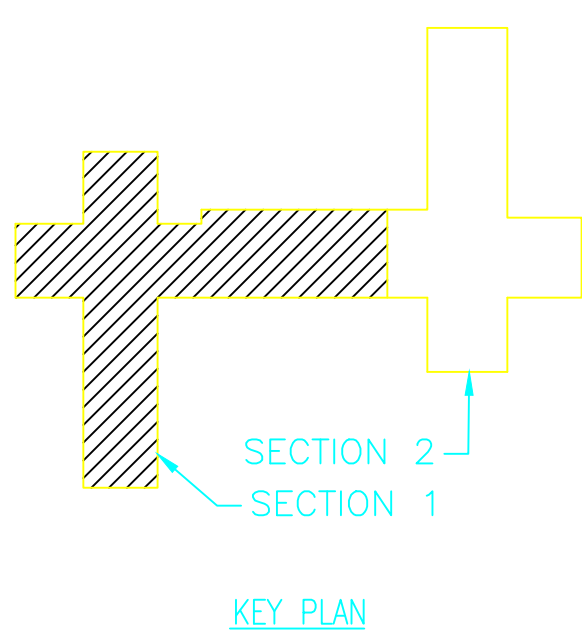

Revisions	Date
ISSUED FOR BID	10/28/11



VA HEARTLAND NETWORK HEALTH CARE SYSTEM

KANSAS CITY VA MEDICAL CENTER

Drawing Title: SEVENTH FLOOR PLAN ELECTRICAL NURSE CALL STATION		Project Title: KANSAS CITY, MO. DIALYSIS CENTER		Date: 07/30/10
Approved:	Building Number: 1	Checked: DAS	Drawn: FCL	Project No.: 901003
Approved:	Location: KANSAS CITY VA MEDICAL CENTER 4801 LINWOOD BOULEVARD, KANSAS CITY, MO			DRAWING NO.: EP105 Dwg. 45 Of 49

Department of Veterans Affairs