






DECORATIVE FENCE DETAIL

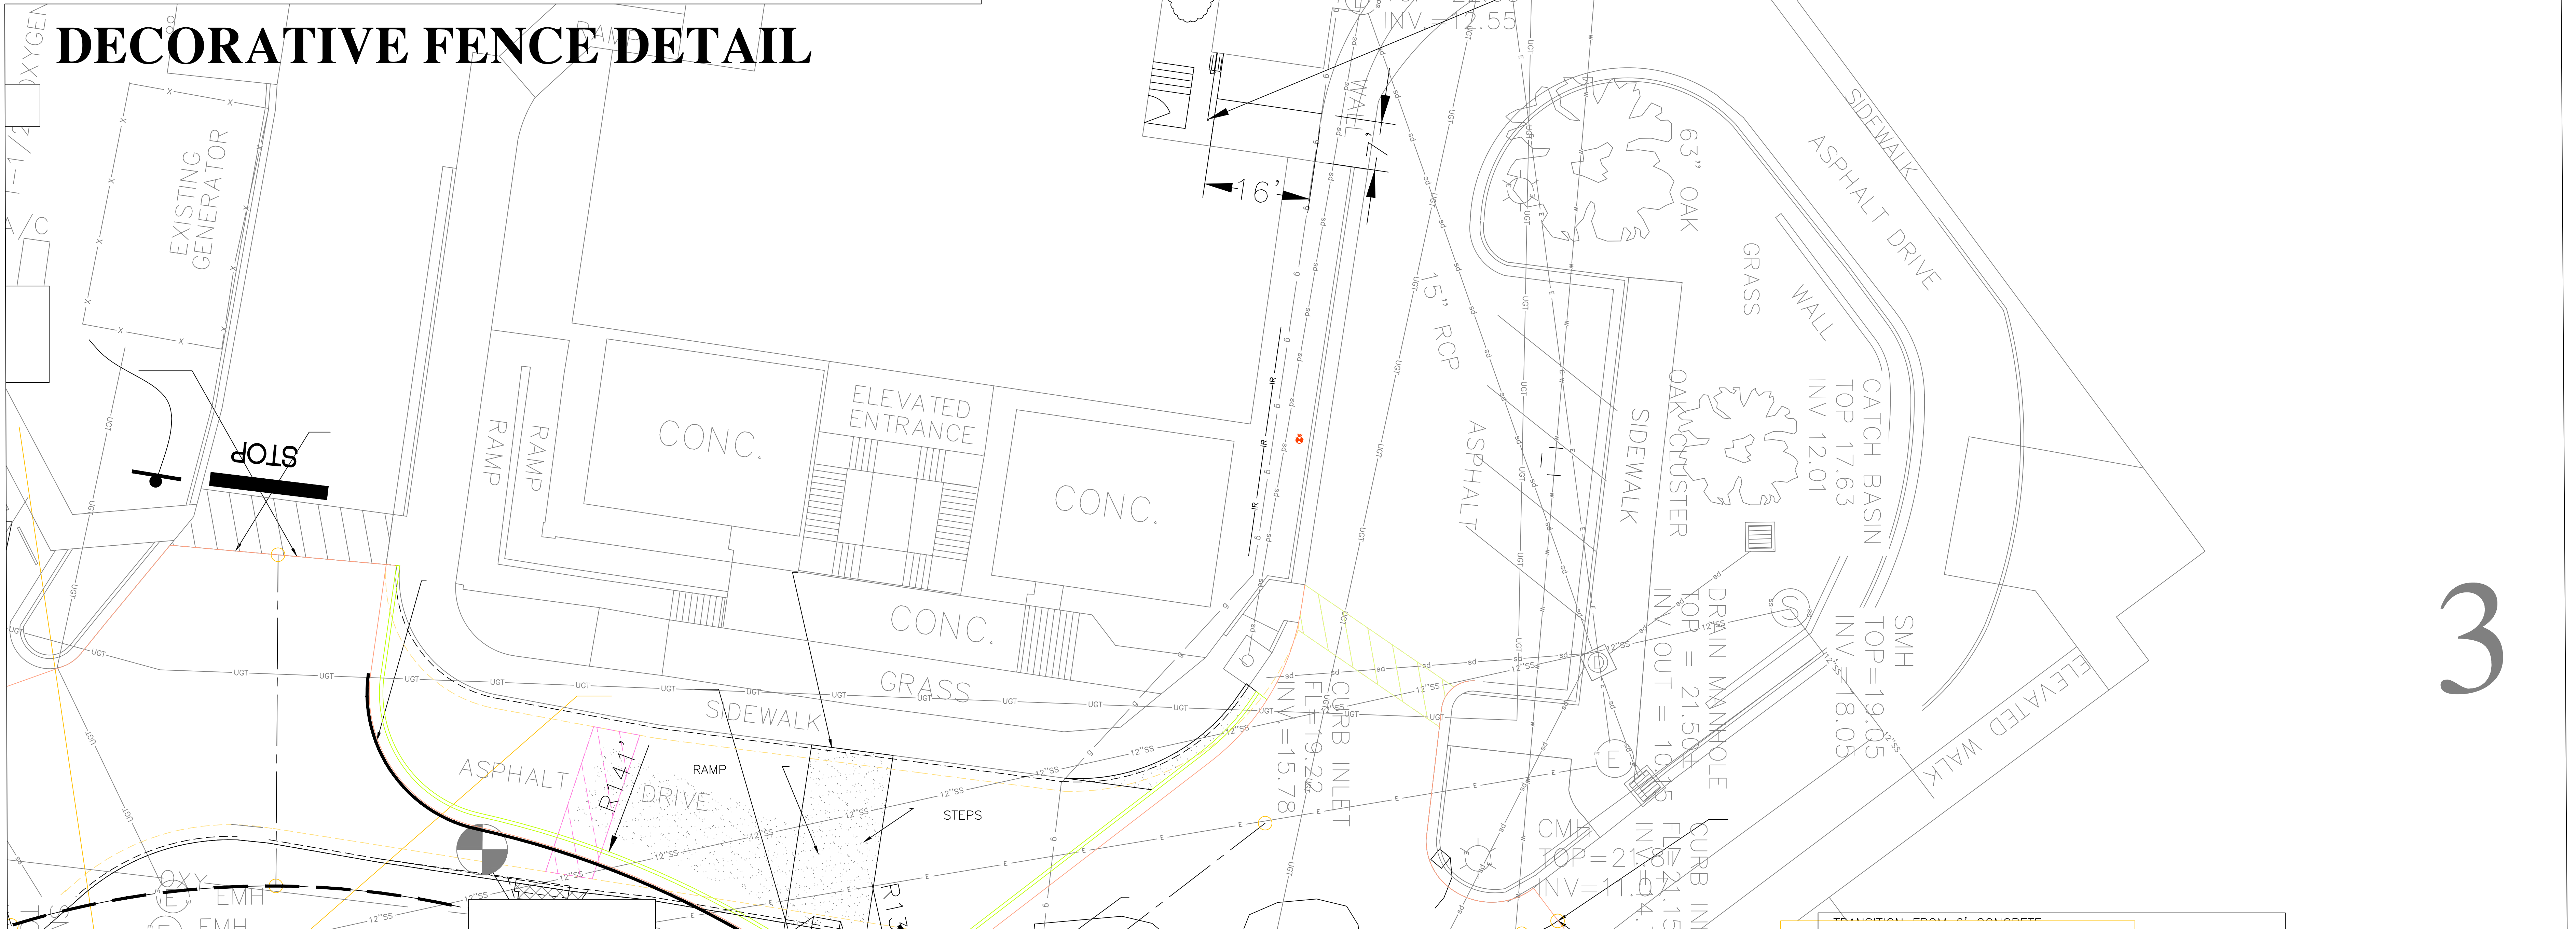

3

		NOTES:	SCALE :	Approved: PROGRAM MANAGER, PROJECTS _____ SAFETY/INDUSTRIAL HYGIENE _____ HEALTH SYSTEM SPECIALIST _____ MAINTENANCE SUPERVISOR _____ MAINTENANCE FOREMAN _____ MAINTENANCE FOREMAN _____	Drawing Title <div style="text-align: center;">BUILDING 1 SITE PLAN</div>	Project Title INSTALL CHARGING STATION BLDG'S. 1, 25 & 48	Date 06/17/13		
Revisions	Date				Approved: Service Engineer	Building Number <div style="text-align: center;">B25</div>	Checked	Drawn	DRAWING NO. <div style="text-align: center;">1-CS1</div>
					Approved: Service Director	Location VAMC BILOXI, MS			Dwg. 1 of 1