

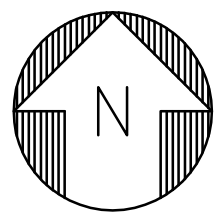


one and one half inches = one foot
one inch = one foot
three quarters inch = one foot
one half inch = one foot
three eighths inch = one foot
one quarter inch = one foot

R:\2013012-00\DWGS\613GG-F101.dwg, 6/26/2013 10:32:14 AM, Tim P. Miller


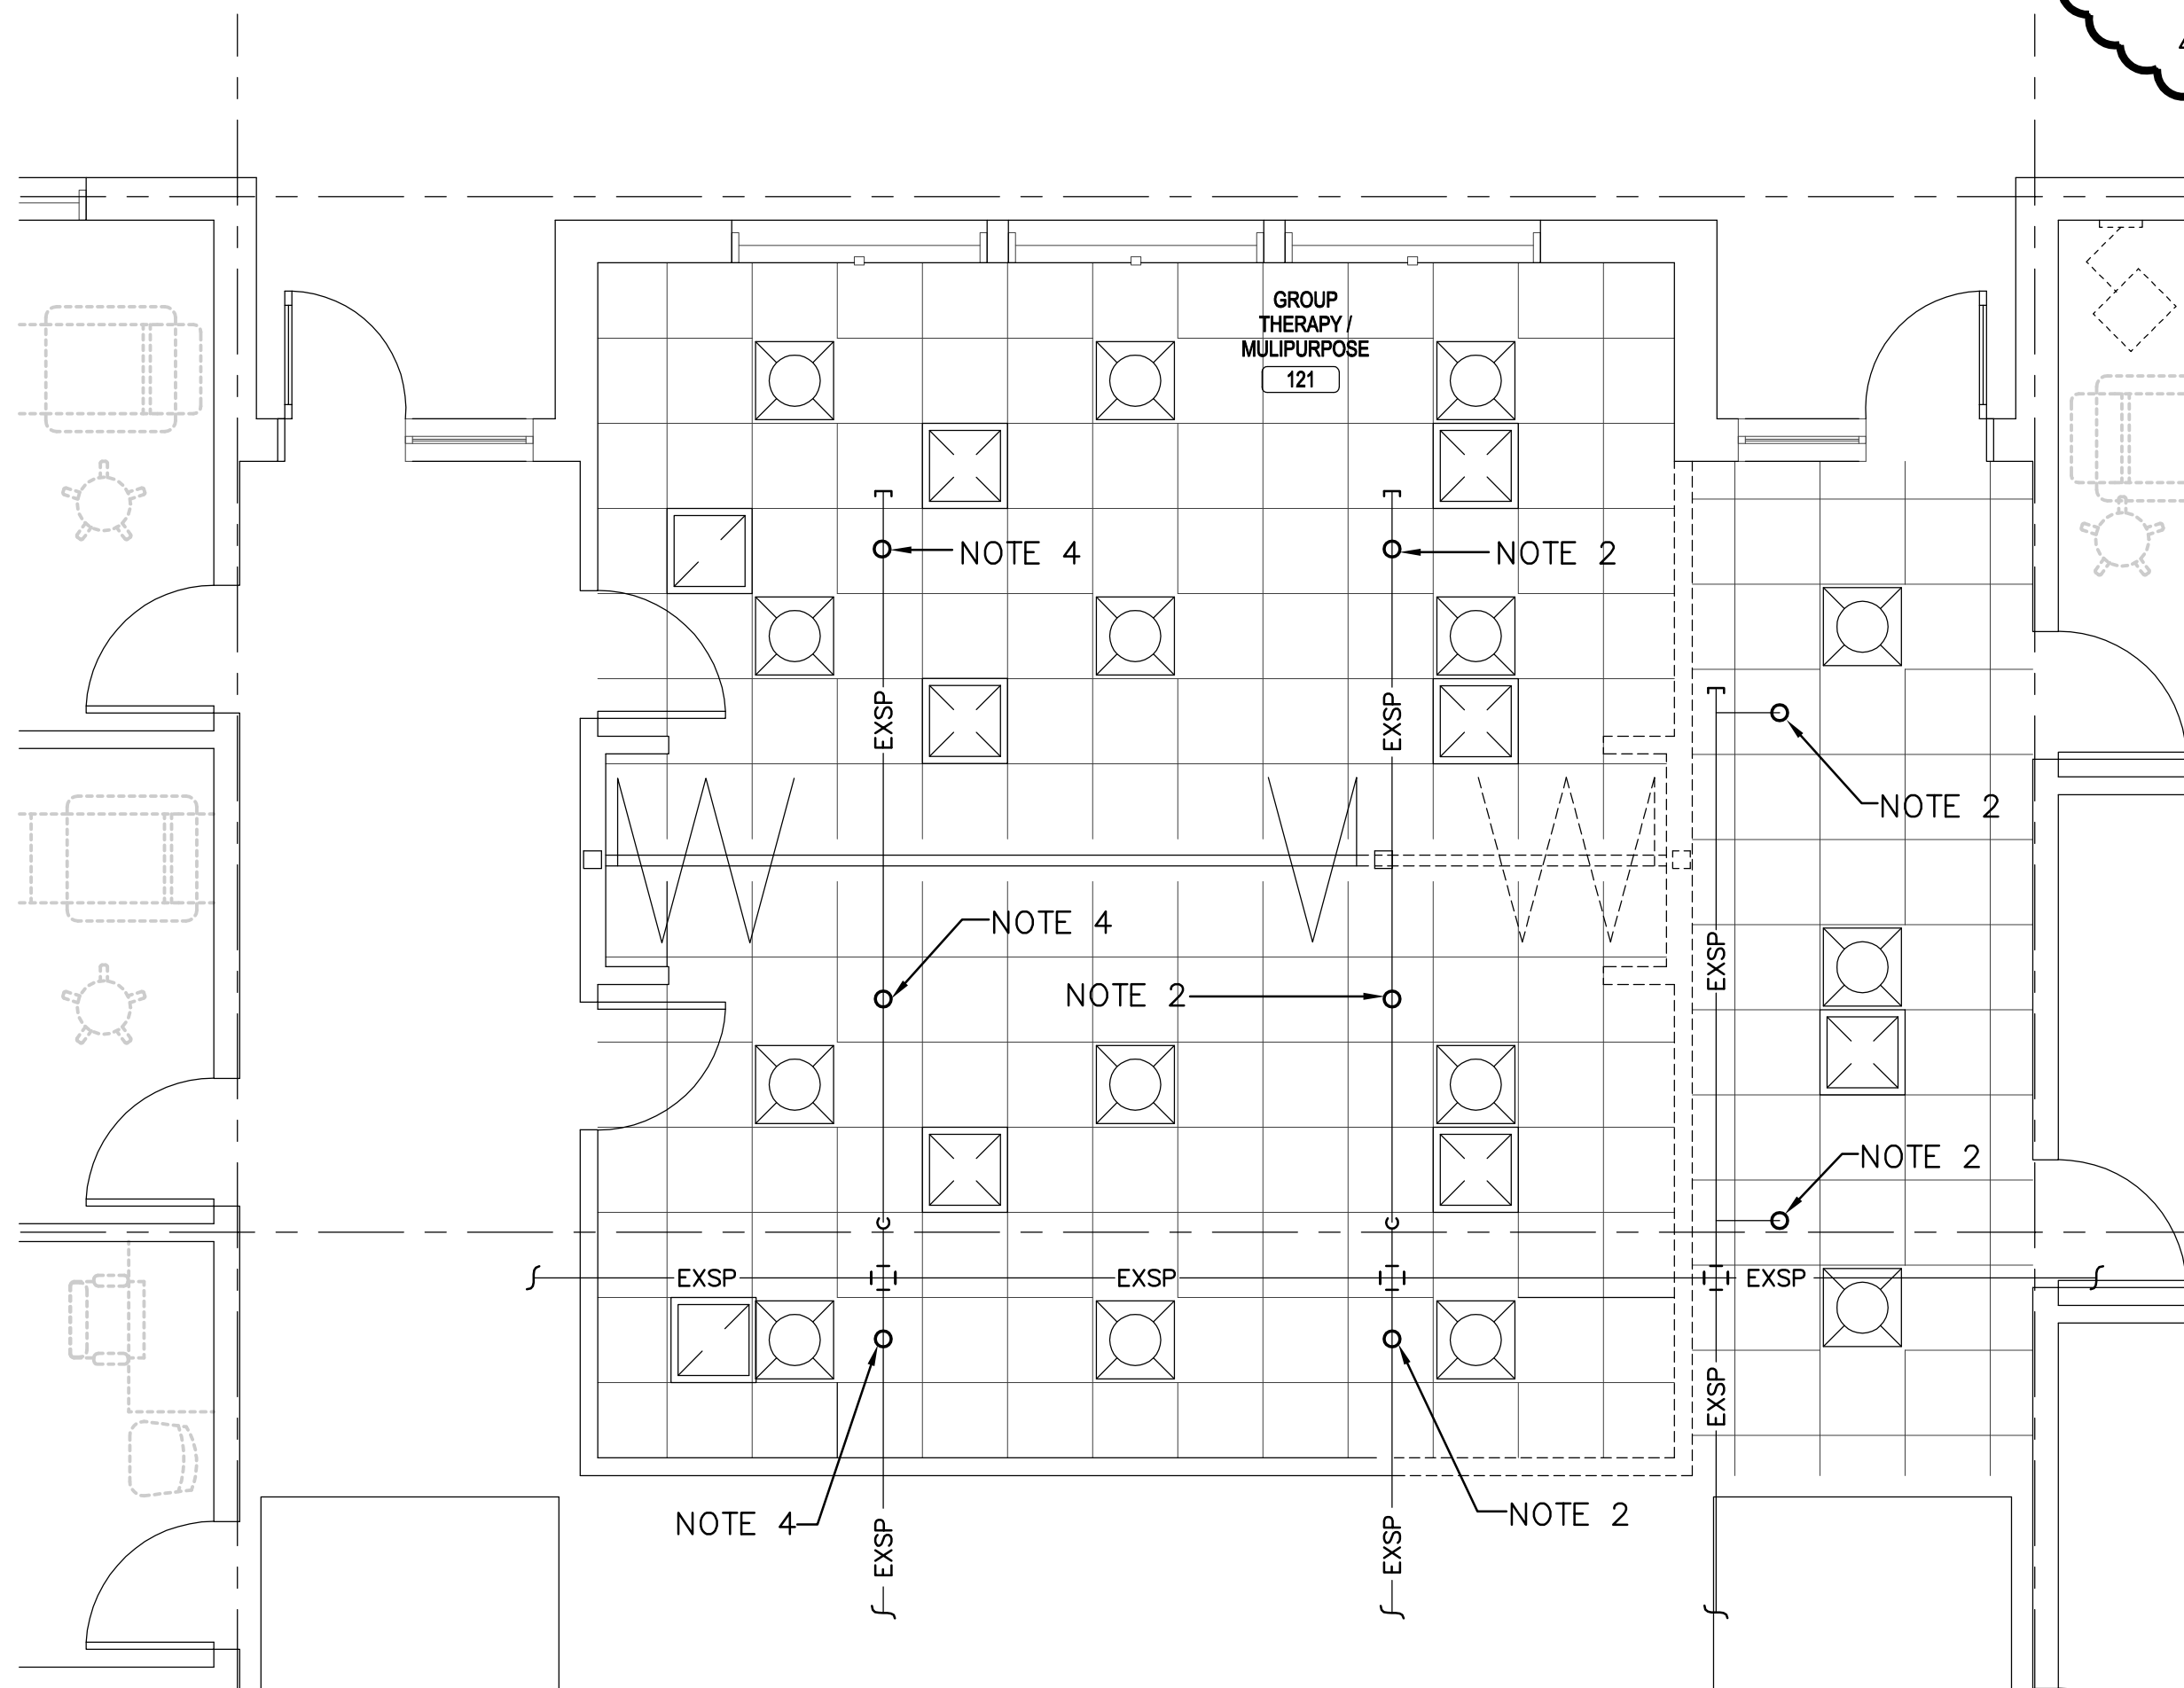


PARTIAL FIRST FLOOR PLAN —
DEMOLITION — FIRE PROTECTION
SCALE: 1/4"=1'-0" NOTE 1

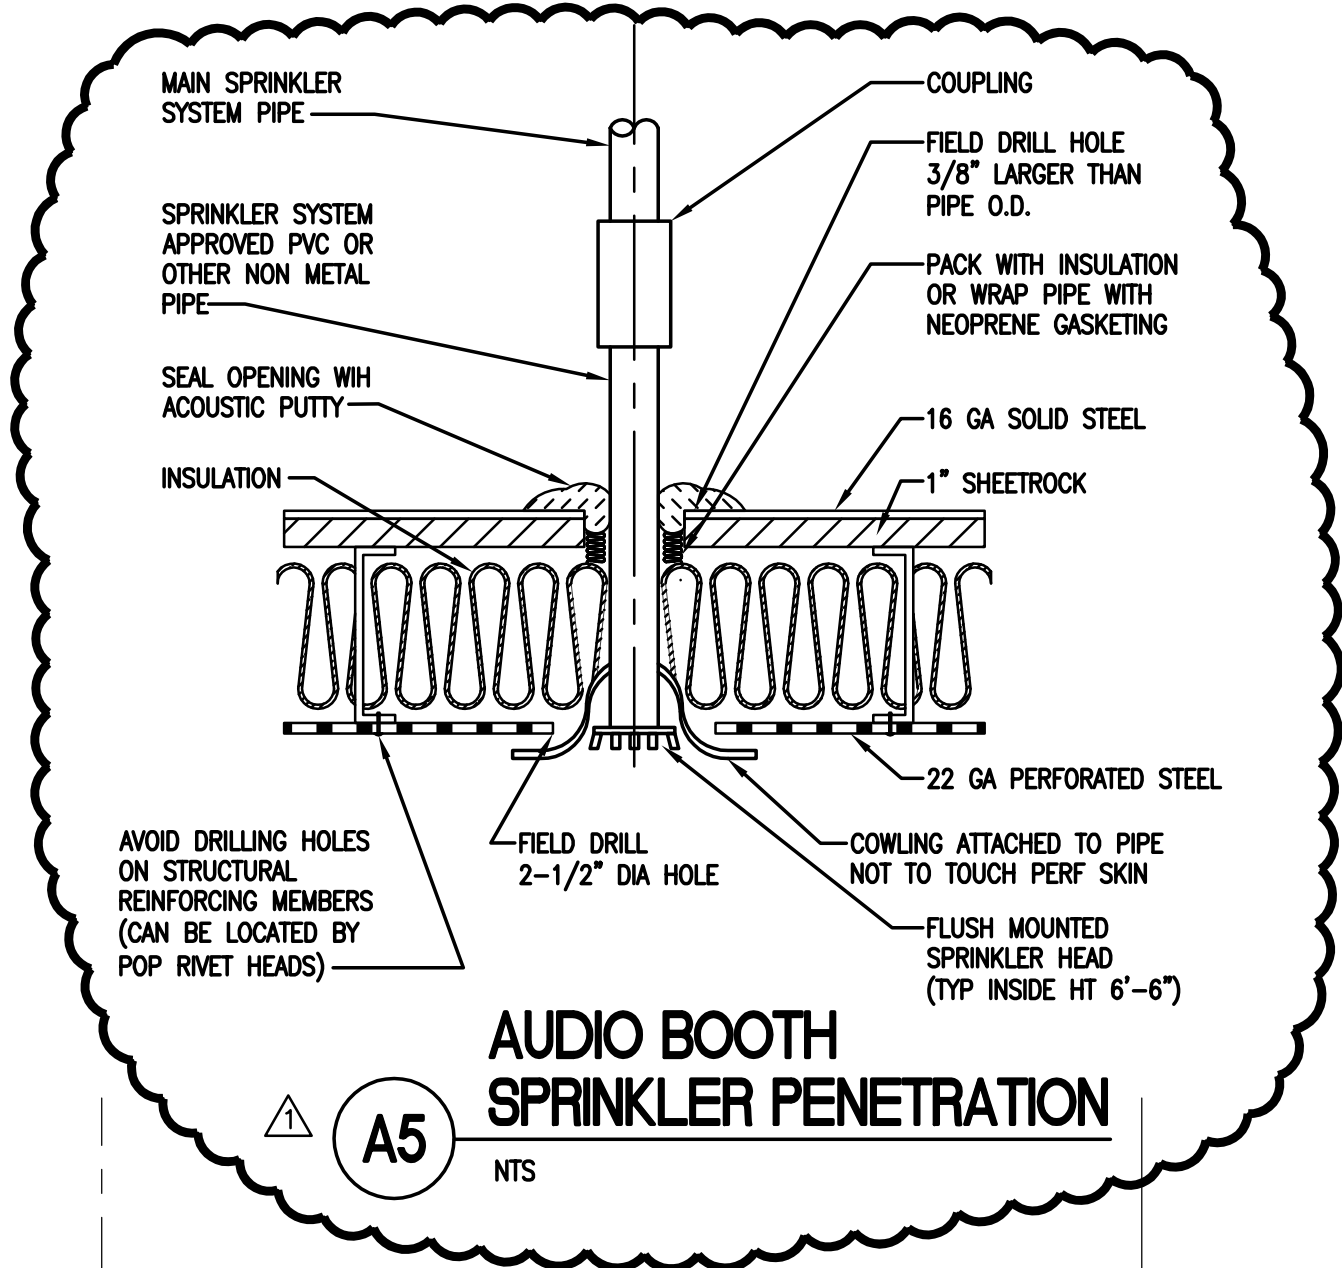




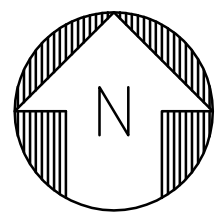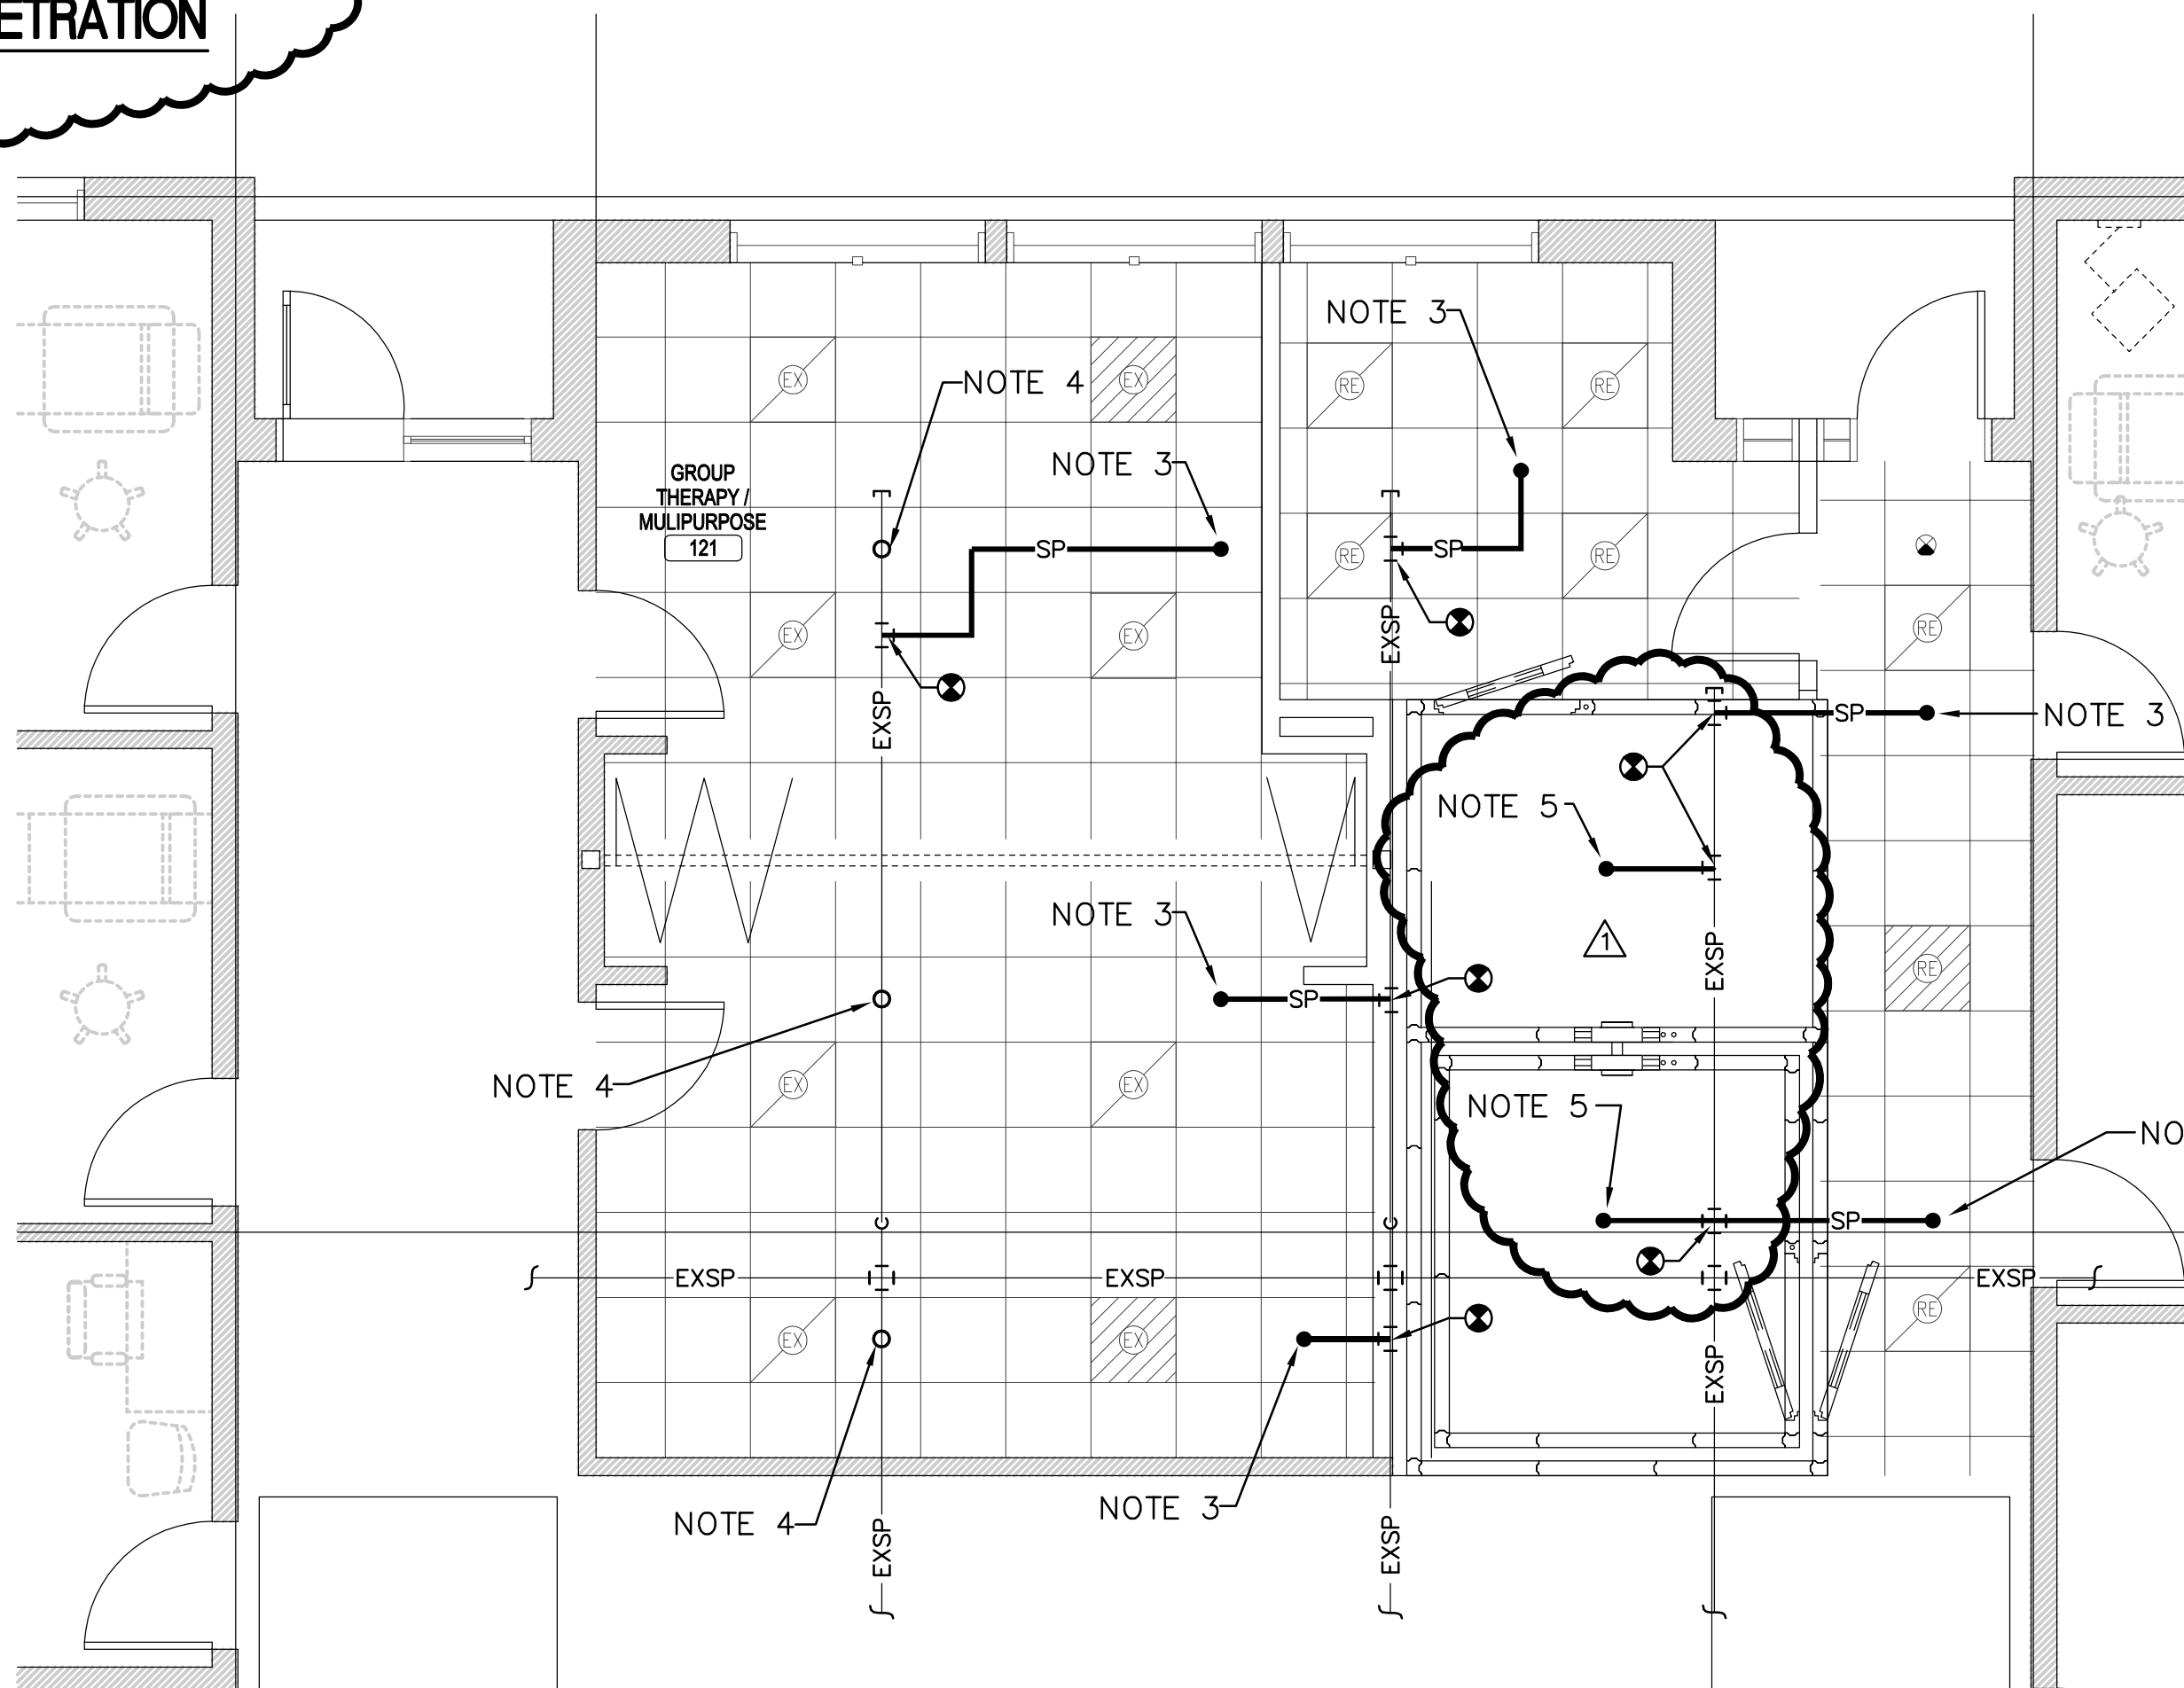

NOTES:

1. ALL EXISTING FIRE PROTECTION EQUIPMENT AND PIPING SHALL REMAIN UNLESS NOTED OTHERWISE.
2. REMOVE EXISTING SPRINKLER HEAD. CAP PIPING AT CONNECTION TO BRANCH MAIN FOR EXTENSION TO NEW SPRINKLER HEAD.
3. EXTEND SPRINKLER PIPING FROM EXISTING BRANCH MAIN TO NEW SPRINKLER HEAD LOCATION.
4. EXISTING SPRINKLER HEAD AND PIPING SHALL REMAIN.
5. FURNISH AND INSTALL SPRINKLER HEAD TO SERVE AUDIO BOOTH. PENETRATE BOOTH IN ACCORDANCE WITH THE MANUFACTURER'S RECOMMENDATIONS AND DETAIL A5 ON THIS SHEET. COORDINATE EXACT LOCATION OF SPRINKLER HEAD WITH AUDIO BOOTH MANUFACTURER.

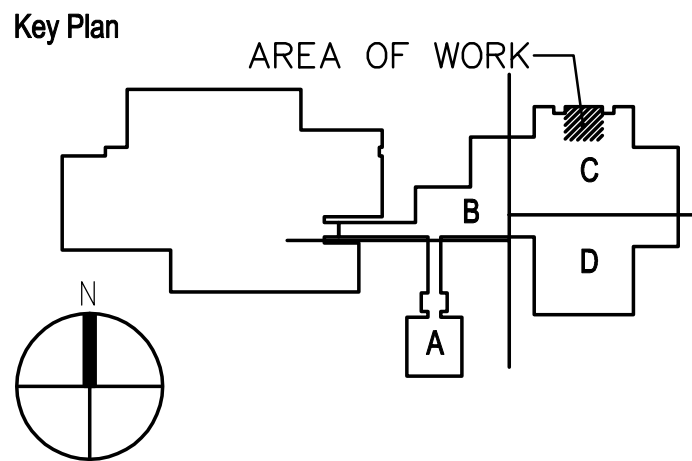

PARTIAL FIRST FLOOR PLAN —
FIRE PROTECTION
SCALE: 1/4"=1'-0"



		CONSULTANTS:				ARCHITECT/ENGINEERS:		Drawing Title		Project Title		Project Number		<div>Office of Construction and Facilities Management</div> <div> Department of Veterans Affairs</div>											
		<div><div>BartonAssociates[™] Consulting Engineers</div><div>Susquehanna Commerce Center Tel.: (717) 845-7654 North Building Web: www.ba-inc.com 221 West Philadelphia Street York, PA 17401</div><div> <i>We Make Buildings Work.</i></div></div>		<div></div>		<div>SAAarchitects</div> <div>600 North Hartley Street, Suite 150 York, PA 17404 T 717.843.3200 F 717.699.0205 www.saaarchitects.com</div>		PARTIAL DEMOLTION & FIRST FLOOR PLAN - FIRE PROTECTION		ADD AUDIOLOGY BOOTH TO FORT DETRICK		Building Number 613GG													
						Approved: Project Director		Location FORT DETRICK, FREDERICK, MD		Drawing Number 613GG-F101															
<div> REVISION 1</div> <div>Revisions:</div>		06.25.13		<div>YORK STATE COLLEGE</div> <div><table><tr><td>PROJECT No:</td><td>DRAWN BY:</td><td>DESIGNED BY:</td><td>CHECKED BY:</td></tr><tr><td>2013012.00</td><td>EPS</td><td>EPS</td><td>DJB</td></tr></table></div>		PROJECT No:	DRAWN BY:	DESIGNED BY:	CHECKED BY:	2013012.00	EPS	EPS	DJB							Date 05.17.2013		Checked -		Drawn -	
PROJECT No:	DRAWN BY:	DESIGNED BY:	CHECKED BY:																						
2013012.00	EPS	EPS	DJB																						