


1 SITE PLAN - OVERALL VIEW
NW-01 SCALE: 1" = 500'

General Notes

1. ALL WORK TO BE COORDINATED WITH VA MC COR AND RESPECTIVE UTILITY COMPANY.

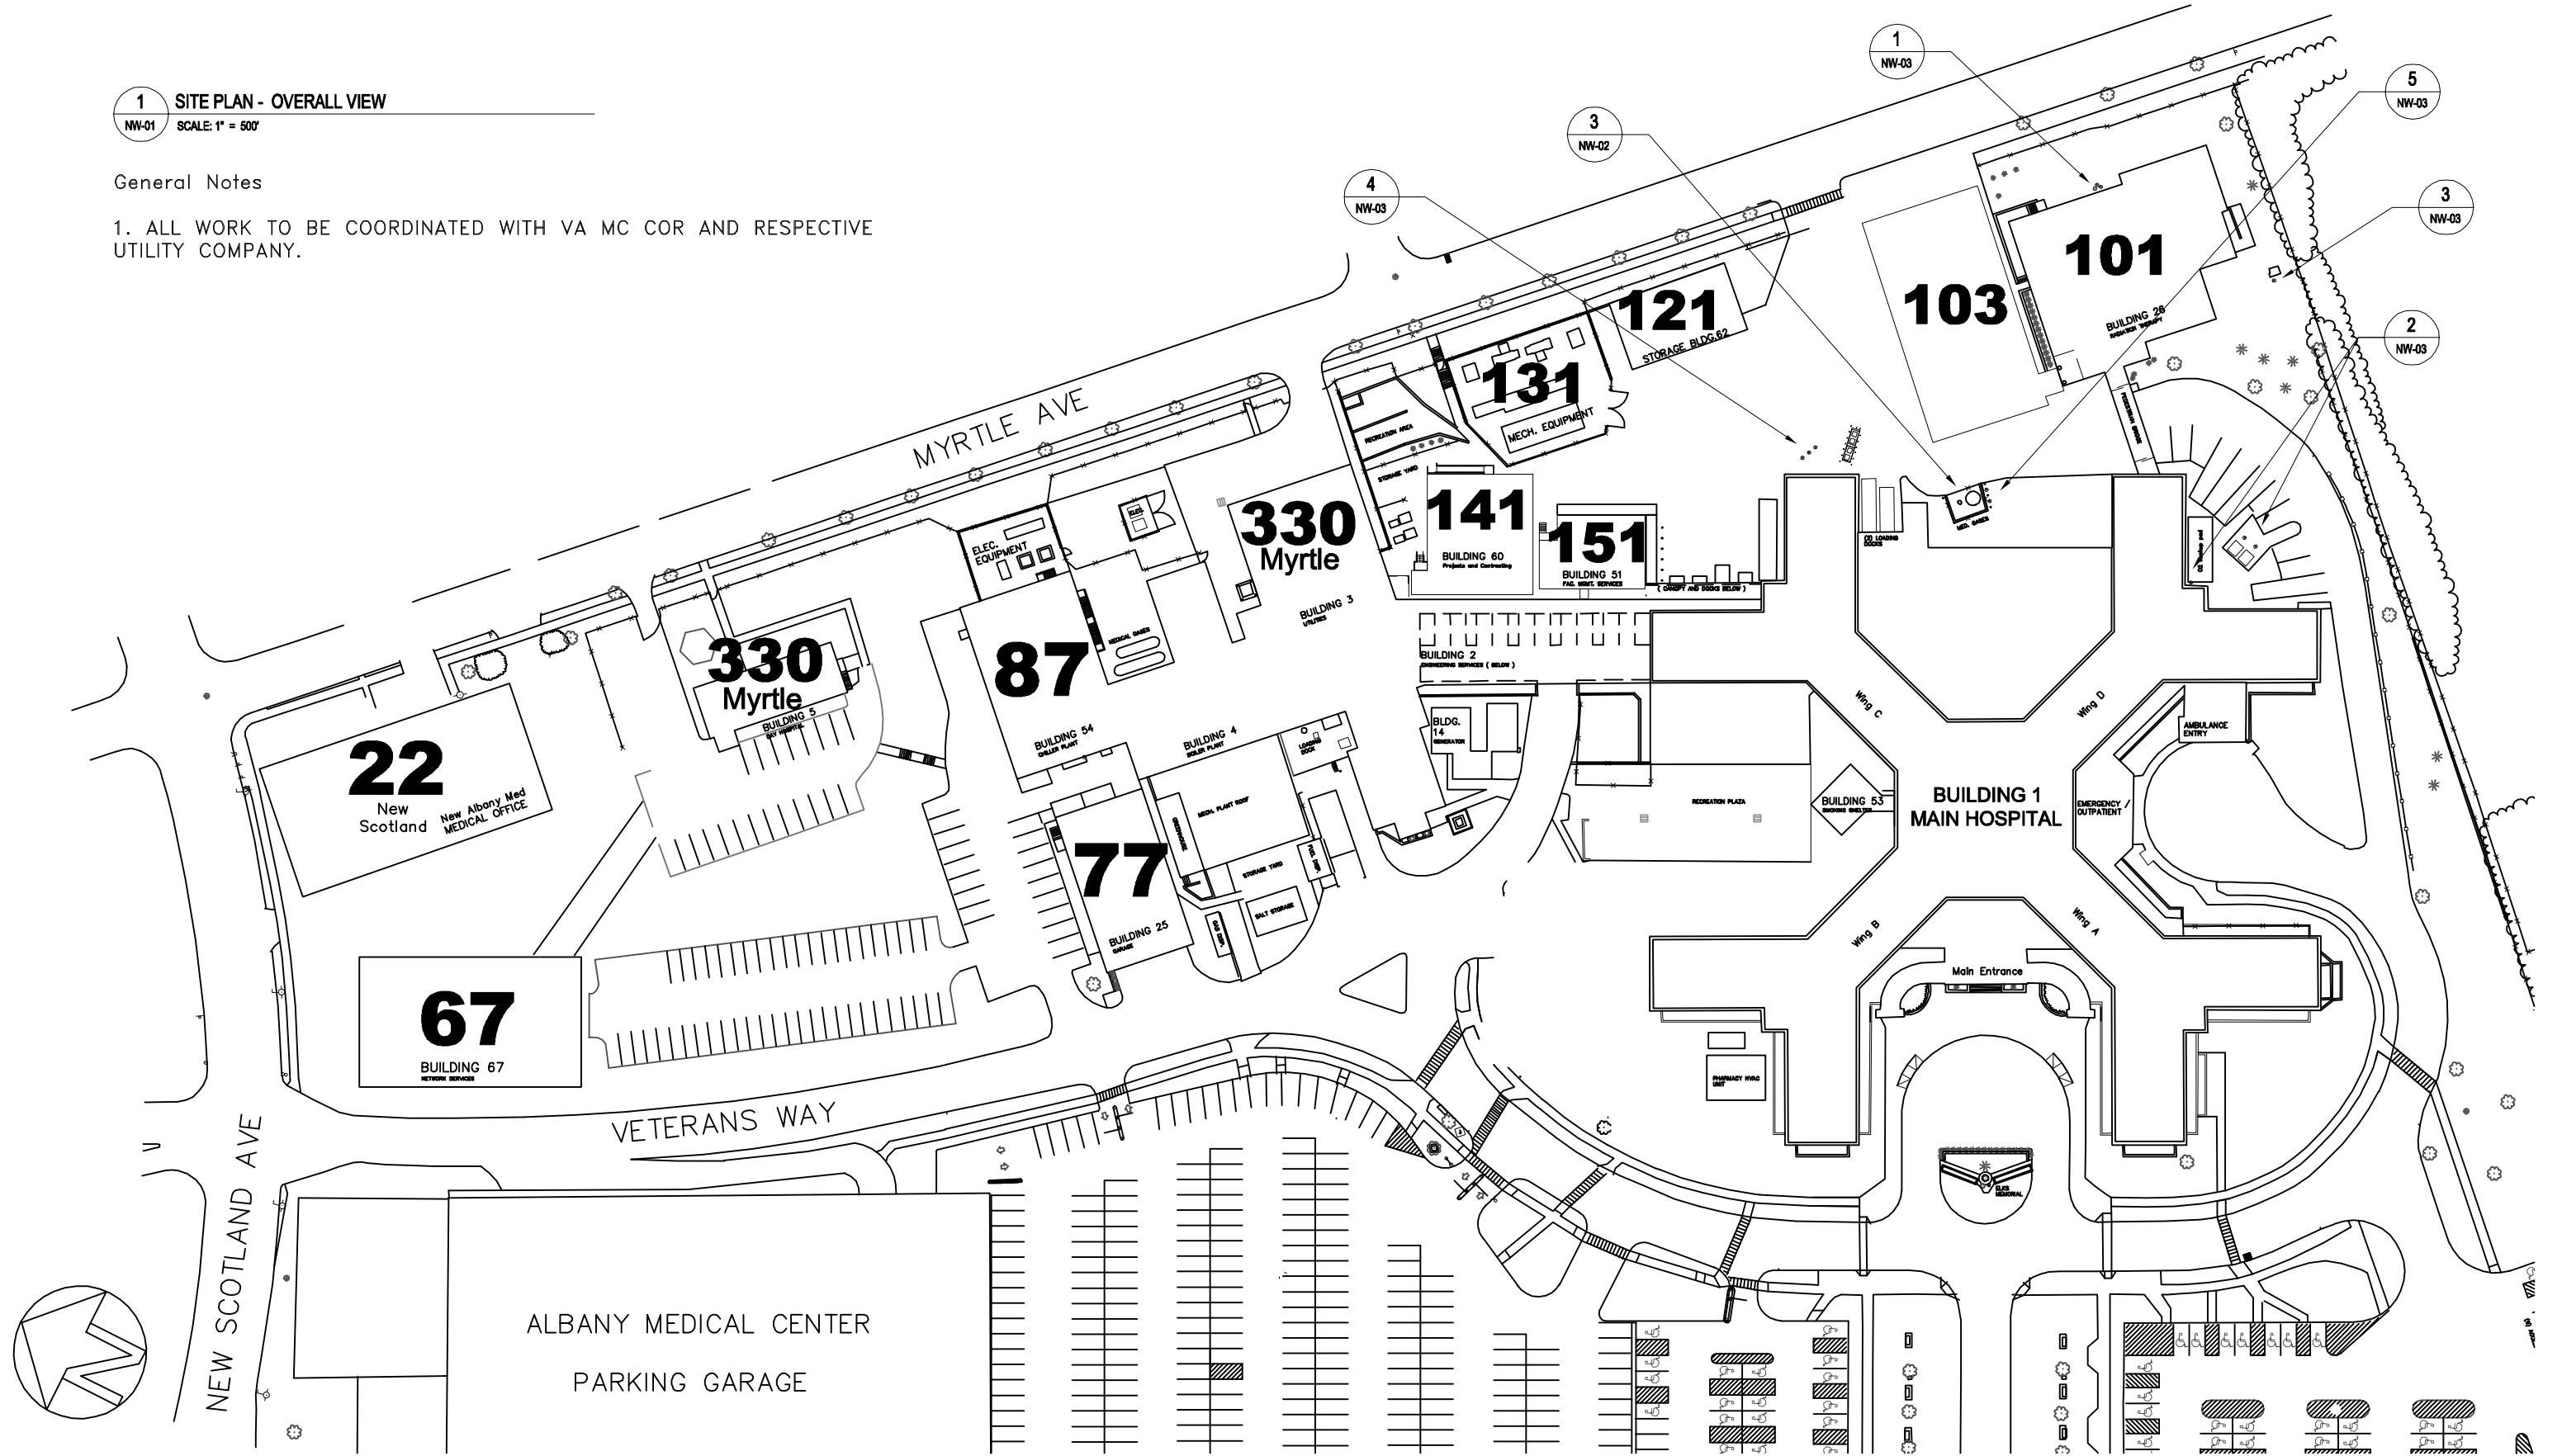

		CONSULTANTS:		ARCHITECT/ENGINEERS:		Drawing Title		Project Title		Project Number		STRATTON VA MEDICAL CENTER
						SITE PLAN - LOCATION OF NEW WORK		SECURITY MEASURES AT BULK OXYGEN TANK CORAL & UTILITY LOCATIONS		UTIL - SECURITY		
										Building Number		
										SITE		
										Drawing Number		
										NW-01		
CLARIFY OPTIONAL LOCATIONS FOR BOLLARDS		07-01-13				Approved: Project Director		Location				
RFP		06-06-13						ALBANY, NEW YORK				
Revisions:		Date						Date	Checked	Drawn		
								MARCH 18, 2013		TEL		Dwg. 2 of 4