


1 SITE PLAN - OVERALL VIEW  
NW-01 SCALE: 1" = 500'

General Notes

1. ALL WORK TO BE COORDINATED WITH VA MC COR AND RESPECTIVE UTILITY COMPANY.

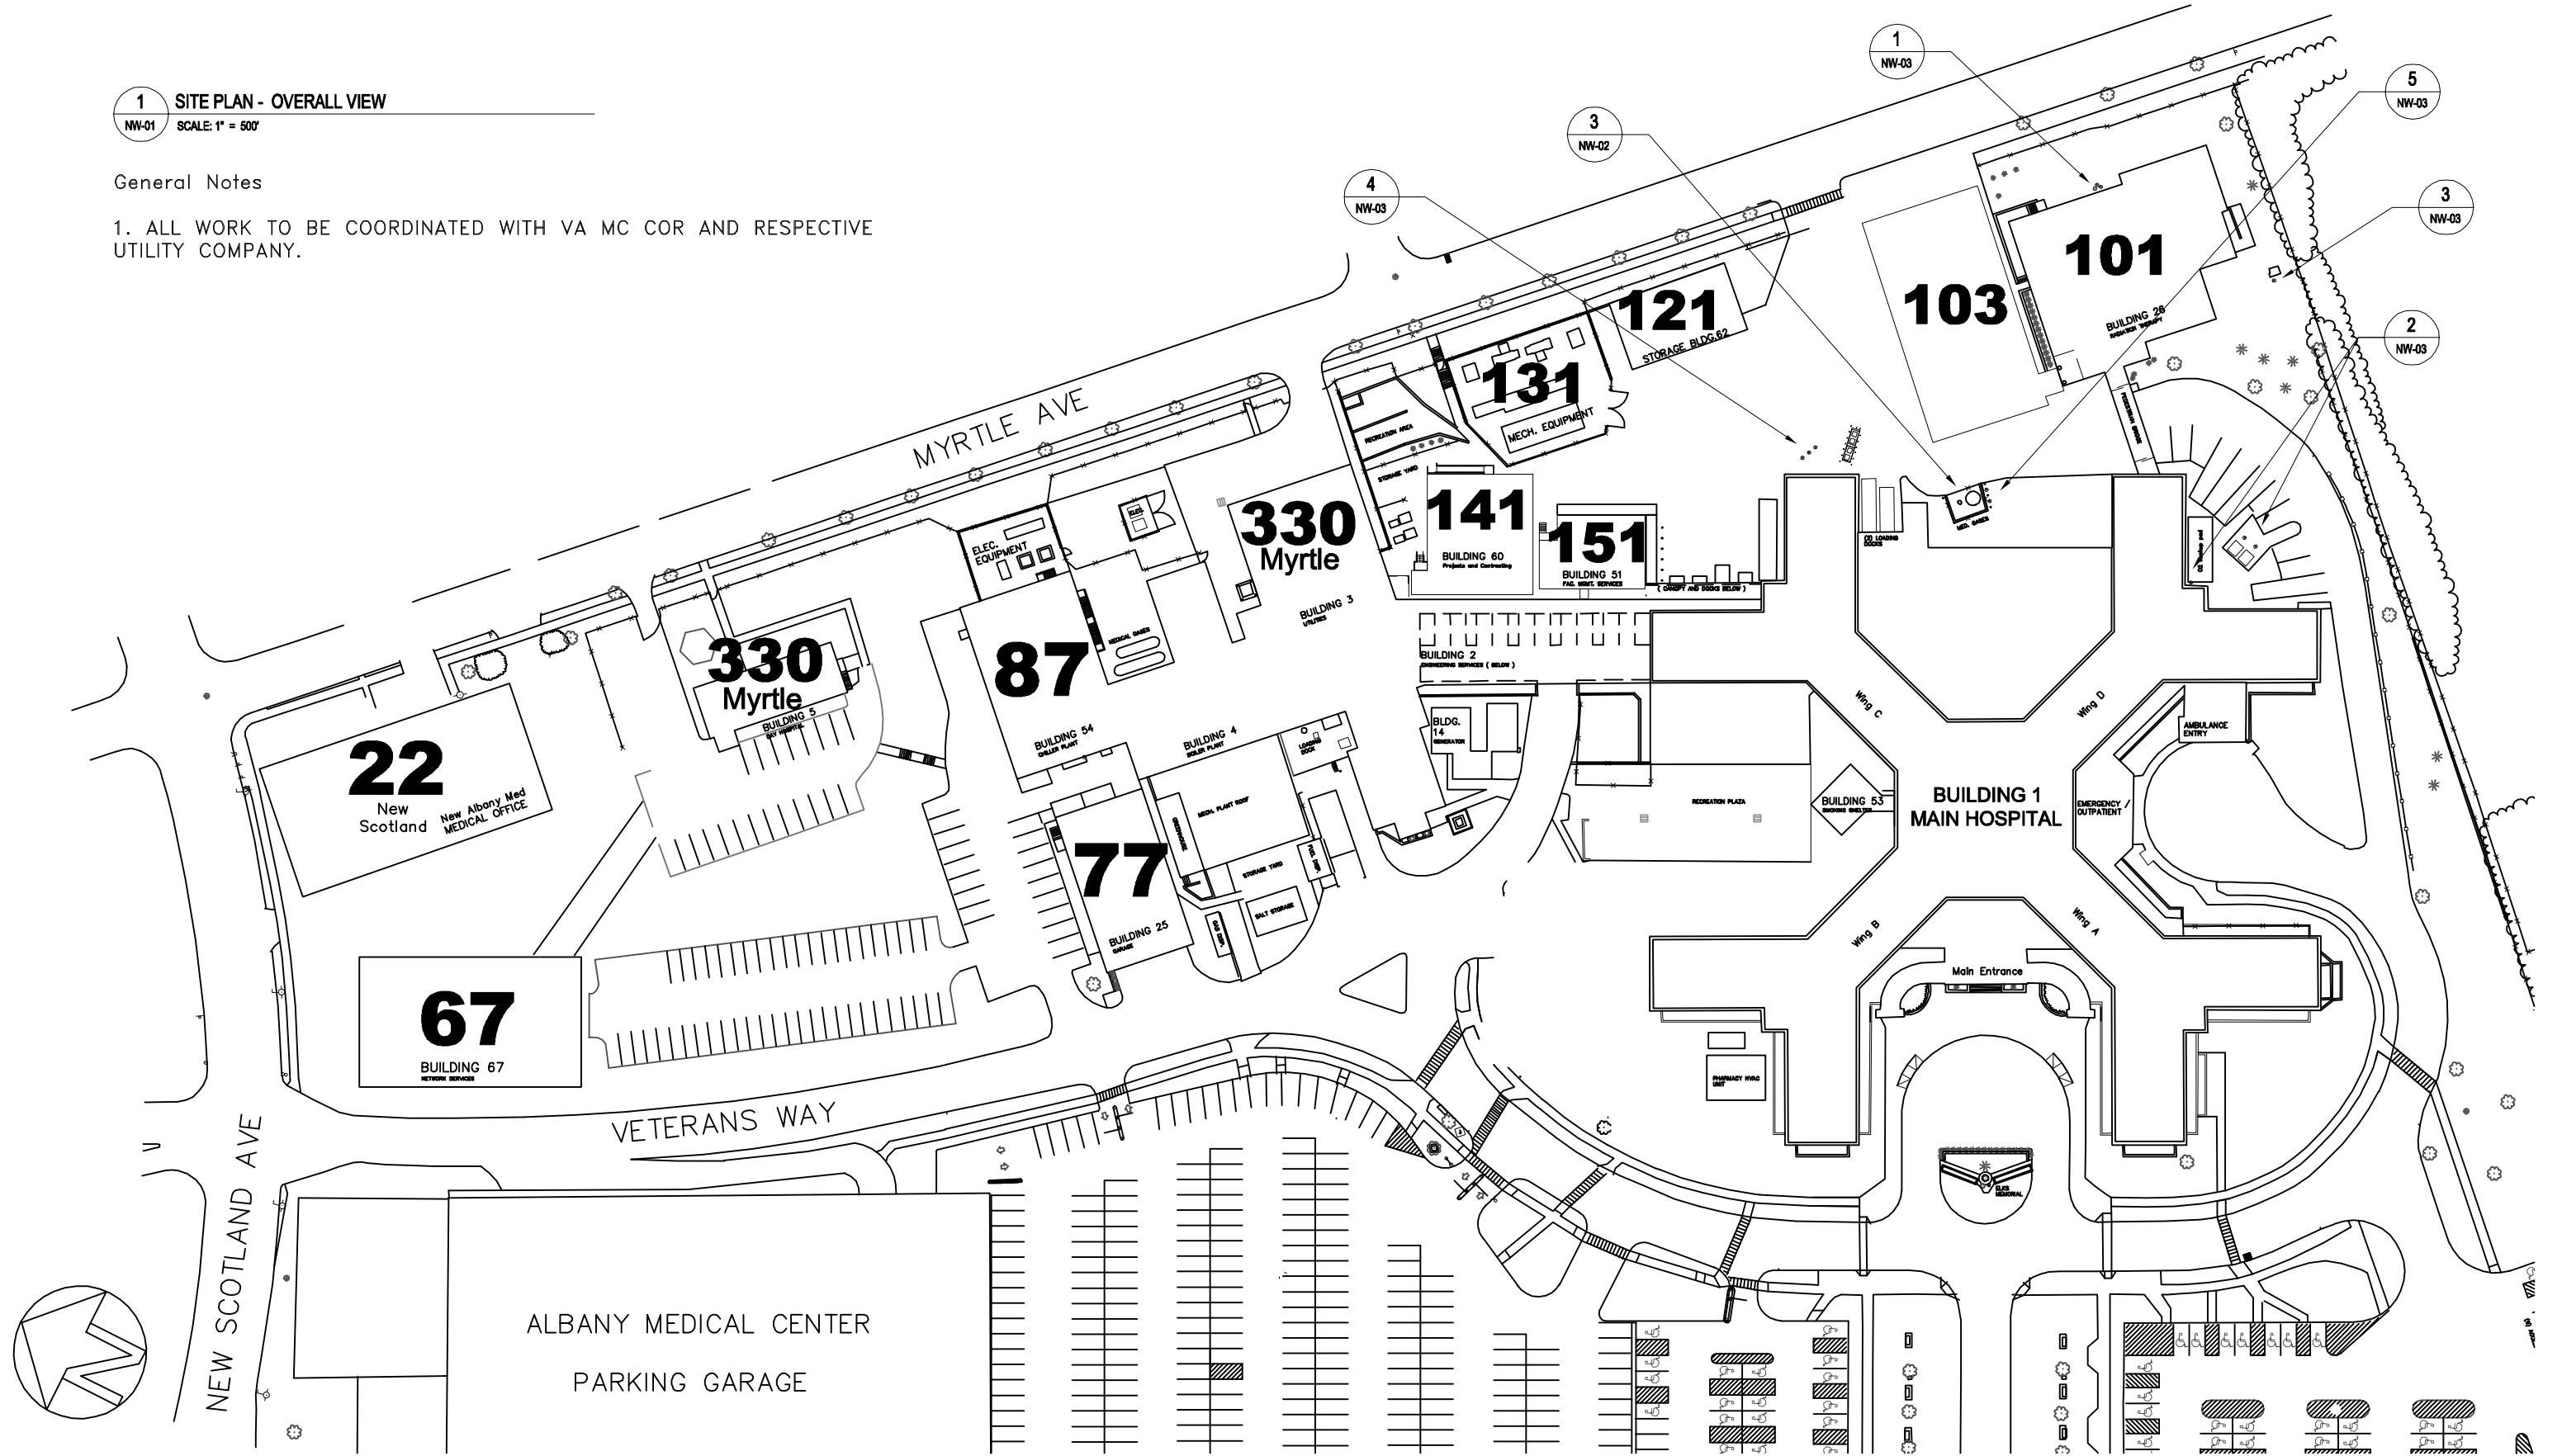

		CONSULTANTS:		ARCHITECT/ENGINEERS:		Drawing Title SITE PLAN - LOCATION OF NEW WORK		Project Title SECURITY MEASURES AT BULK OXYGEN TANK CORAL & UTILITY LOCATIONS		Project Number UTIL - SECURITY		STRATTON VA MEDICAL CENTER
								Building Number SITE				
								Location ALBANY, NEW YORK		Drawing Number NW-01		
CLARIFY OPTIONAL LOCATIONS FOR BOLLARDS		07-01-13			Approved: Project Director	Location ALBANY, NEW YORK		Drawing Number NW-01		Dwg. 2 of 4		
RFP		06-06-13				Date MARCH 18, 2013	Checked	Drawn TEL				
Revisions:		Date										