




CONSTRUCT NAVAL BRANCH HEALTH CLINIC



NAVAL GULF COAST HEALTH CARE
PANAMA CITY, FLORIDA

PROJECT NO. 520-13-200

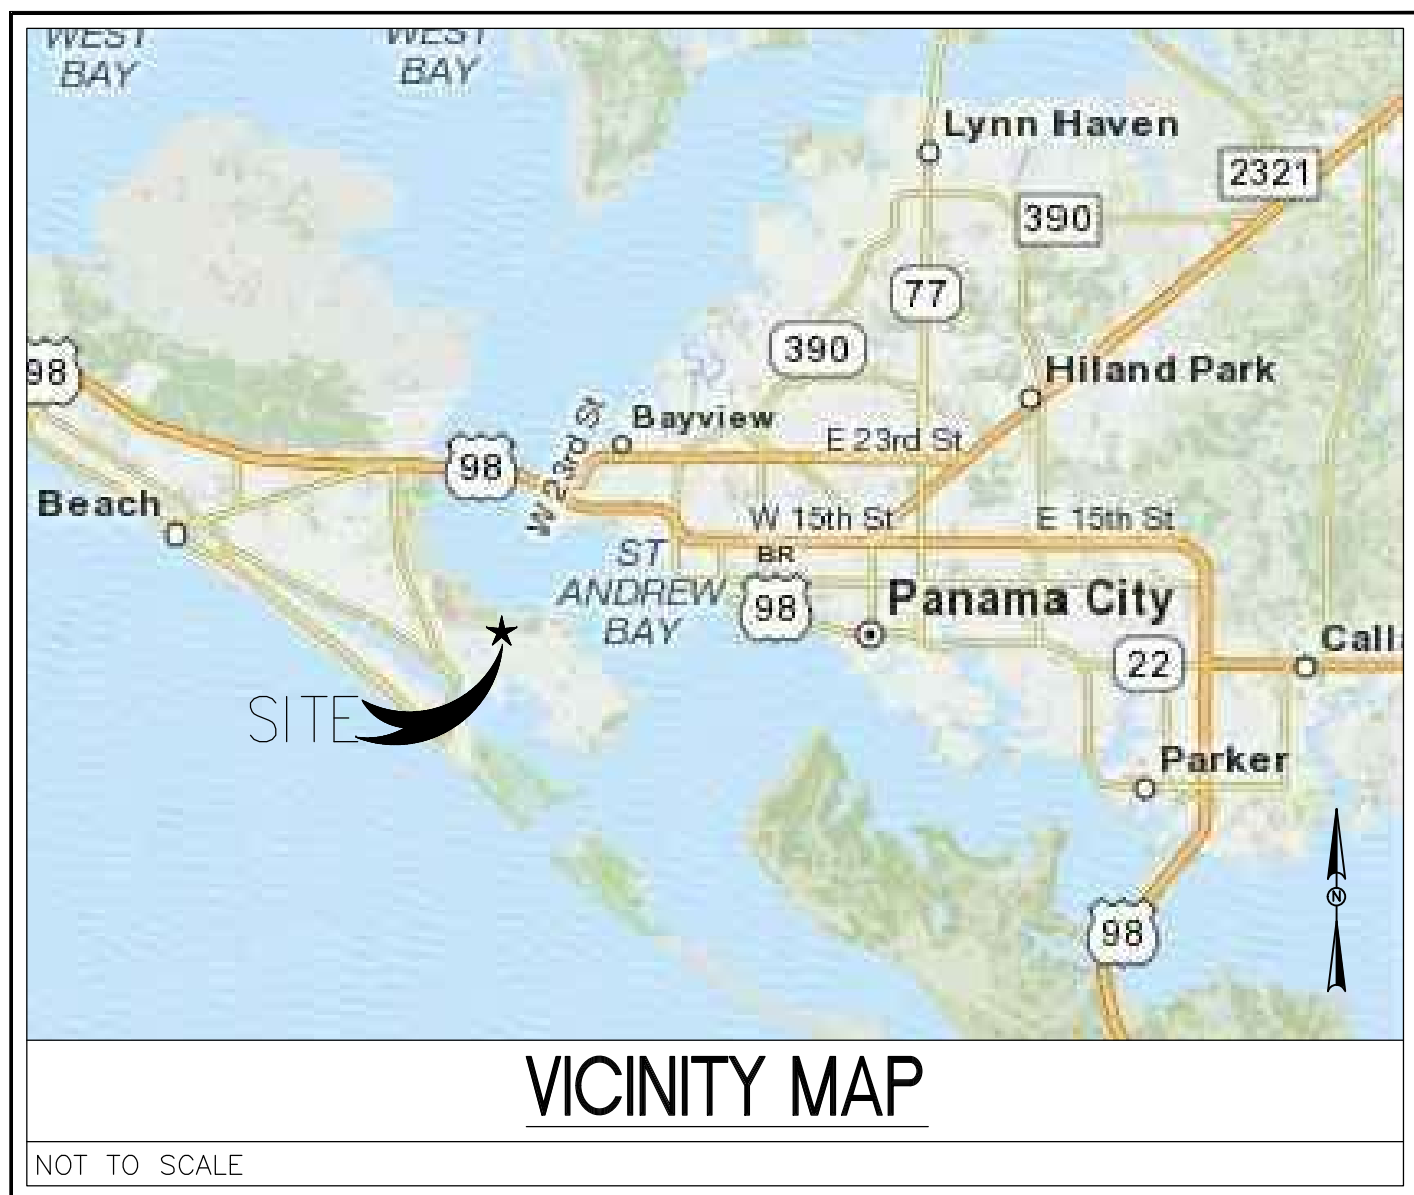

| INDEX OF DRAWINGS | |
|-------------------|--|
| SHEET NO. | DRAWING TITLE |
| GENERAL | |
| G001 | TITLE SHEET |
| CIVIL | |
| CS101 | SITE PLAN |
| CS102 | SITE GEOMETRY PLAN |
| CG101 | GRADING AND STORMWATER PLAN |
| LANDSCAPING | |
| L101 | NAVY CLINIC LANDSCAPE PLAN |
| ARCHITECTURAL | |
| A100 | SITE PLAN |
| A101 | USE PLAN |
| A102 | DIMENSION PLAN |
| A103 | FIRST FLOOR PLAN |
| A104 | CLERESTORY PLAN |
| A105 | CANOPY |
| A106 | PARTITION FLOOR PLAN |
| A140 | REFLECTIVE CEILING PLAN |
| A150 | ROOF PLAN |
| A151 | ROOF DETAILS |
| A201 | ELEVATIONS |
| A301 | BUILDING SECTIONS |
| A302 | BUILDING SECTIONS |
| A303 | BUILDING SECTIONS |
| A360 | WALL SECTION |
| A361 | WALL SECTIONS |
| A362 | WALL SECTIONS |
| A401 | ELEVATION PLAN |
| A402 | ENLARGED PLAN |
| A501 | DETAILS |
| A601 | DOOR FRAME SCHEDULE |
| A602 | WINDOW SCHEDULE |
| A603 | DOOR WINDOW DETAILS |
| A700 | EQUIPMENT SCHEDULE |
| A701 | EQUIPMENT PLAN |
| A721 | INTERIOR ELEVATIONS |
| A722 | INTERIOR ELEVATIONS |
| A723 | INTERIOR ELEVATIONS |
| A724 | INTERIOR ELEVATIONS |
| A725 | INTERIOR ELEVATIONS |
| A751 | CASEWORK SECTIONS |
| A752 | CASEWORK SECTIONS |
| INTERIOR DESIGN | |
| IN101 | FLOOR FINISH LOCATION PLAN |
| IN102 | FINISH SCHEDULE & FLOOR INSTALLATION PATTERN |
| IN103 | TRANSITION DETAIL |
| IN104 | WALL PROTECTION PLAN |
| IN105 | EXTERIOR SIGNAGE PLAN |
| IN106 | INTERIOR SIGNAGE PLAN |
| STRUCTURAL | |
| S001 | GENERAL STRUCTURAL NOTES |
| S101 | FOUNDATION AND SLAB-ON GRADE PLAN |
| S102 | CANOPY FOUNDATION PLAN |
| S103 | ROOF FRAMING PLAN |
| S104 | FRAMING PLAN CANOPY |
| S300 | FOUNDATION DETAILS |
| S301 | TYPICAL DETAILS |
| S302 | TYPICAL DETAILS |
| S501 | TYPICAL DETAILS |
| S502 | TYPICAL DETAILS |

| INDEX OF DRAWINGS (CONT'D) | |
|----------------------------|--|
| SHEET NO. | DRAWING TITLE |
| MECHANICAL | |
| M001 | MECHANICAL GENERAL NOTES SYMBOLS & LEGEND |
| M011 | MECHANICAL SCHEDULES |
| MS101 | MECHANICAL PLAN SITE |
| MH101 | MECHANICAL PLAN SUPPLY |
| MH102 | MECHANICAL PLAN RETURN & EXHAUST |
| MP101 | MECHANICAL PLAN HYDRONICS |
| M501 | MECHANICAL HVAC RISER DIAGRAM & DETAILS |
| M502 | MECHANICAL HVAC RISER DIAGRAM & DETAILS |
| M601 | MECHANICAL DDC POINTS LIST |
| PLUMBING | |
| P001 | PLUMBING LEGEND, ABBREVIATIONS AND SYMBOLS |
| P011 | PLUMBING SCHEDULES |
| P101 | PLUMBING PLAN, WATER |
| P102 | PLUMBING PLAN, DWV |
| P103 | PLUMBING PLAN ROOF |
| P500 | PLUMBING DETAILS |
| P600 | PLUMBING WATER RISER DIAGRAM |
| P601 | PLUMBING SS RISER DIAGRAM |
| FIRE PROTECTION | |
| F101 | LIFE SAFETY PLAN |
| FP101 | FIRE PROTECTION PLAN |
| ELECTRICAL | |
| E001 | GENERAL NOTES SYMBOLS AND LEGENDS |
| ES101 | SITE ELECTRICAL PLAN |
| EL101 | LIGHTING PLAN |
| EL102 | CANOPY LIGHTING PLAN |
| EL200 | LIGHTING CALCULATIONS |
| EP101 | POWER PLAN |
| EP102 | HVAC POWER |
| E501 | ELECTRICAL DETAILS |
| E502 | ELECTRICAL DETAILS |
| E503 | ELECTRICAL DETAILS |
| E601 | ELECTRICAL ONE LINE DIAGRAM |
| E701 | ELECTRICAL SCHEDULES |
| E702 | ELECTRICAL SCHEDULES |
| TELECOMMUNICATIONS | |
| TN001 | TELECOMMUNICATIONS LEGEND & NOTES |
| TN101 | TELECOMMUNICATIONS SITE PLAN |
| TN201 | TELECOMMUNICATIONS PLAN |
| TN401 | TELECOMMUNICATIONS ENLARGED PLANS |
| TN501 | TELECOMMUNICATIONS DETAILS |
| TN502 | TELECOMMUNICATIONS DETAILS |
| TN503 | TELECOMMUNICATIONS DETAILS |
| TN601 | TELECOMMUNICATIONS DATA/VOICE TYP. SINGLE LINE |
| TN602 | TELECOMMUNICATIONS VOICE SINGLE LINE |
| TN603 | TELECOMMUNICATIONS DATA SYSTEMS SINGLE LINE |
| TN604 | TELECOMMUNICATIONS SYSTEM SINGLE LINE |
| TN701 | TELECOMMUNICATIONS ELEVATIONS |
| SECURITY | |
| TY001 | SECURITY LEGEND & NOTES |
| TY201 | SECURITY PLAN |
| TY501 | SECURITY DETAILS |
| TY502 | SECURITY DETAILS |
| TY601 | SECURITY DETAILS |

FINAL SUBMISSION
APRIL 9, 2013

IF SHEET IS LESS THAN (30"x42") IT IS
A REDUCED PRINT; SCALE ACCORDINGLY

G001



| | | | |
|---|---|----------------------|--|
| 766 MOBILE ST., PANORAMA, AL 36532 251-990-5778 ARCH. & ENGR. SEAL | NATURAL RESOURCES & ENVIRONMENTAL AFFAIRS SATISFACTORY TO DATE | P.W. DWG. NO. | DEPARTMENT OF THE NAVY NAVAL SUPPORT ACTIVITY PANAMA CITY, FLORIDA |
| | SAFETY DEPARTMENT | DRAWN BY JLL | CONSTRUCT NAVAL BRANCH HEALTH CLINIC PANAMA CITY |
| | FIRE DEPARTMENT | CHECKED BY WWB | TITLE SHEET |
| | PUBLIC WORKS SUPERVISOR | SUPERVISOR WWB | SIZE F |
| | | APPROVED DATE | CODE IDENT. NO. N/A |
| | | PUBLIC WORKS OFFICER | NAVFAC DRAWING NO. N/A |
| | | | CONSTR. CONTR. NO. |
| | | | SCALE NONE |
| | | | T.O.# |
| | | | SHEET 1 OF 1 |