



three inches = one foot
one and one half inches = one foot
one inch = one foot
three quarters inch = one foot
one half inch = one foot
three eighths inch = one foot
one quarter inch = one foot
one eighth inch = one foot
one eighth inch = one foot

Sheet Notes

KEYNOTES:

① (N) 1/2" O, MA, MV, MV & NO TO CEILING MOUNTED HOSE ASSEMBLY

② (N) 1/2" O, MA & MV BELOW FLOOR TO PEDESTAL HOSE ASSEMBLY

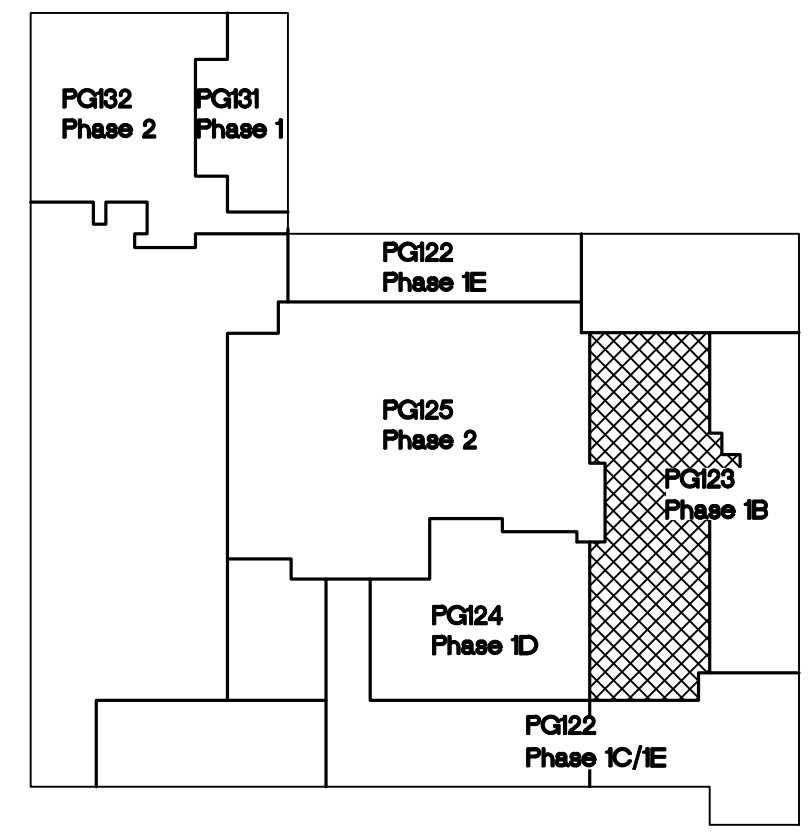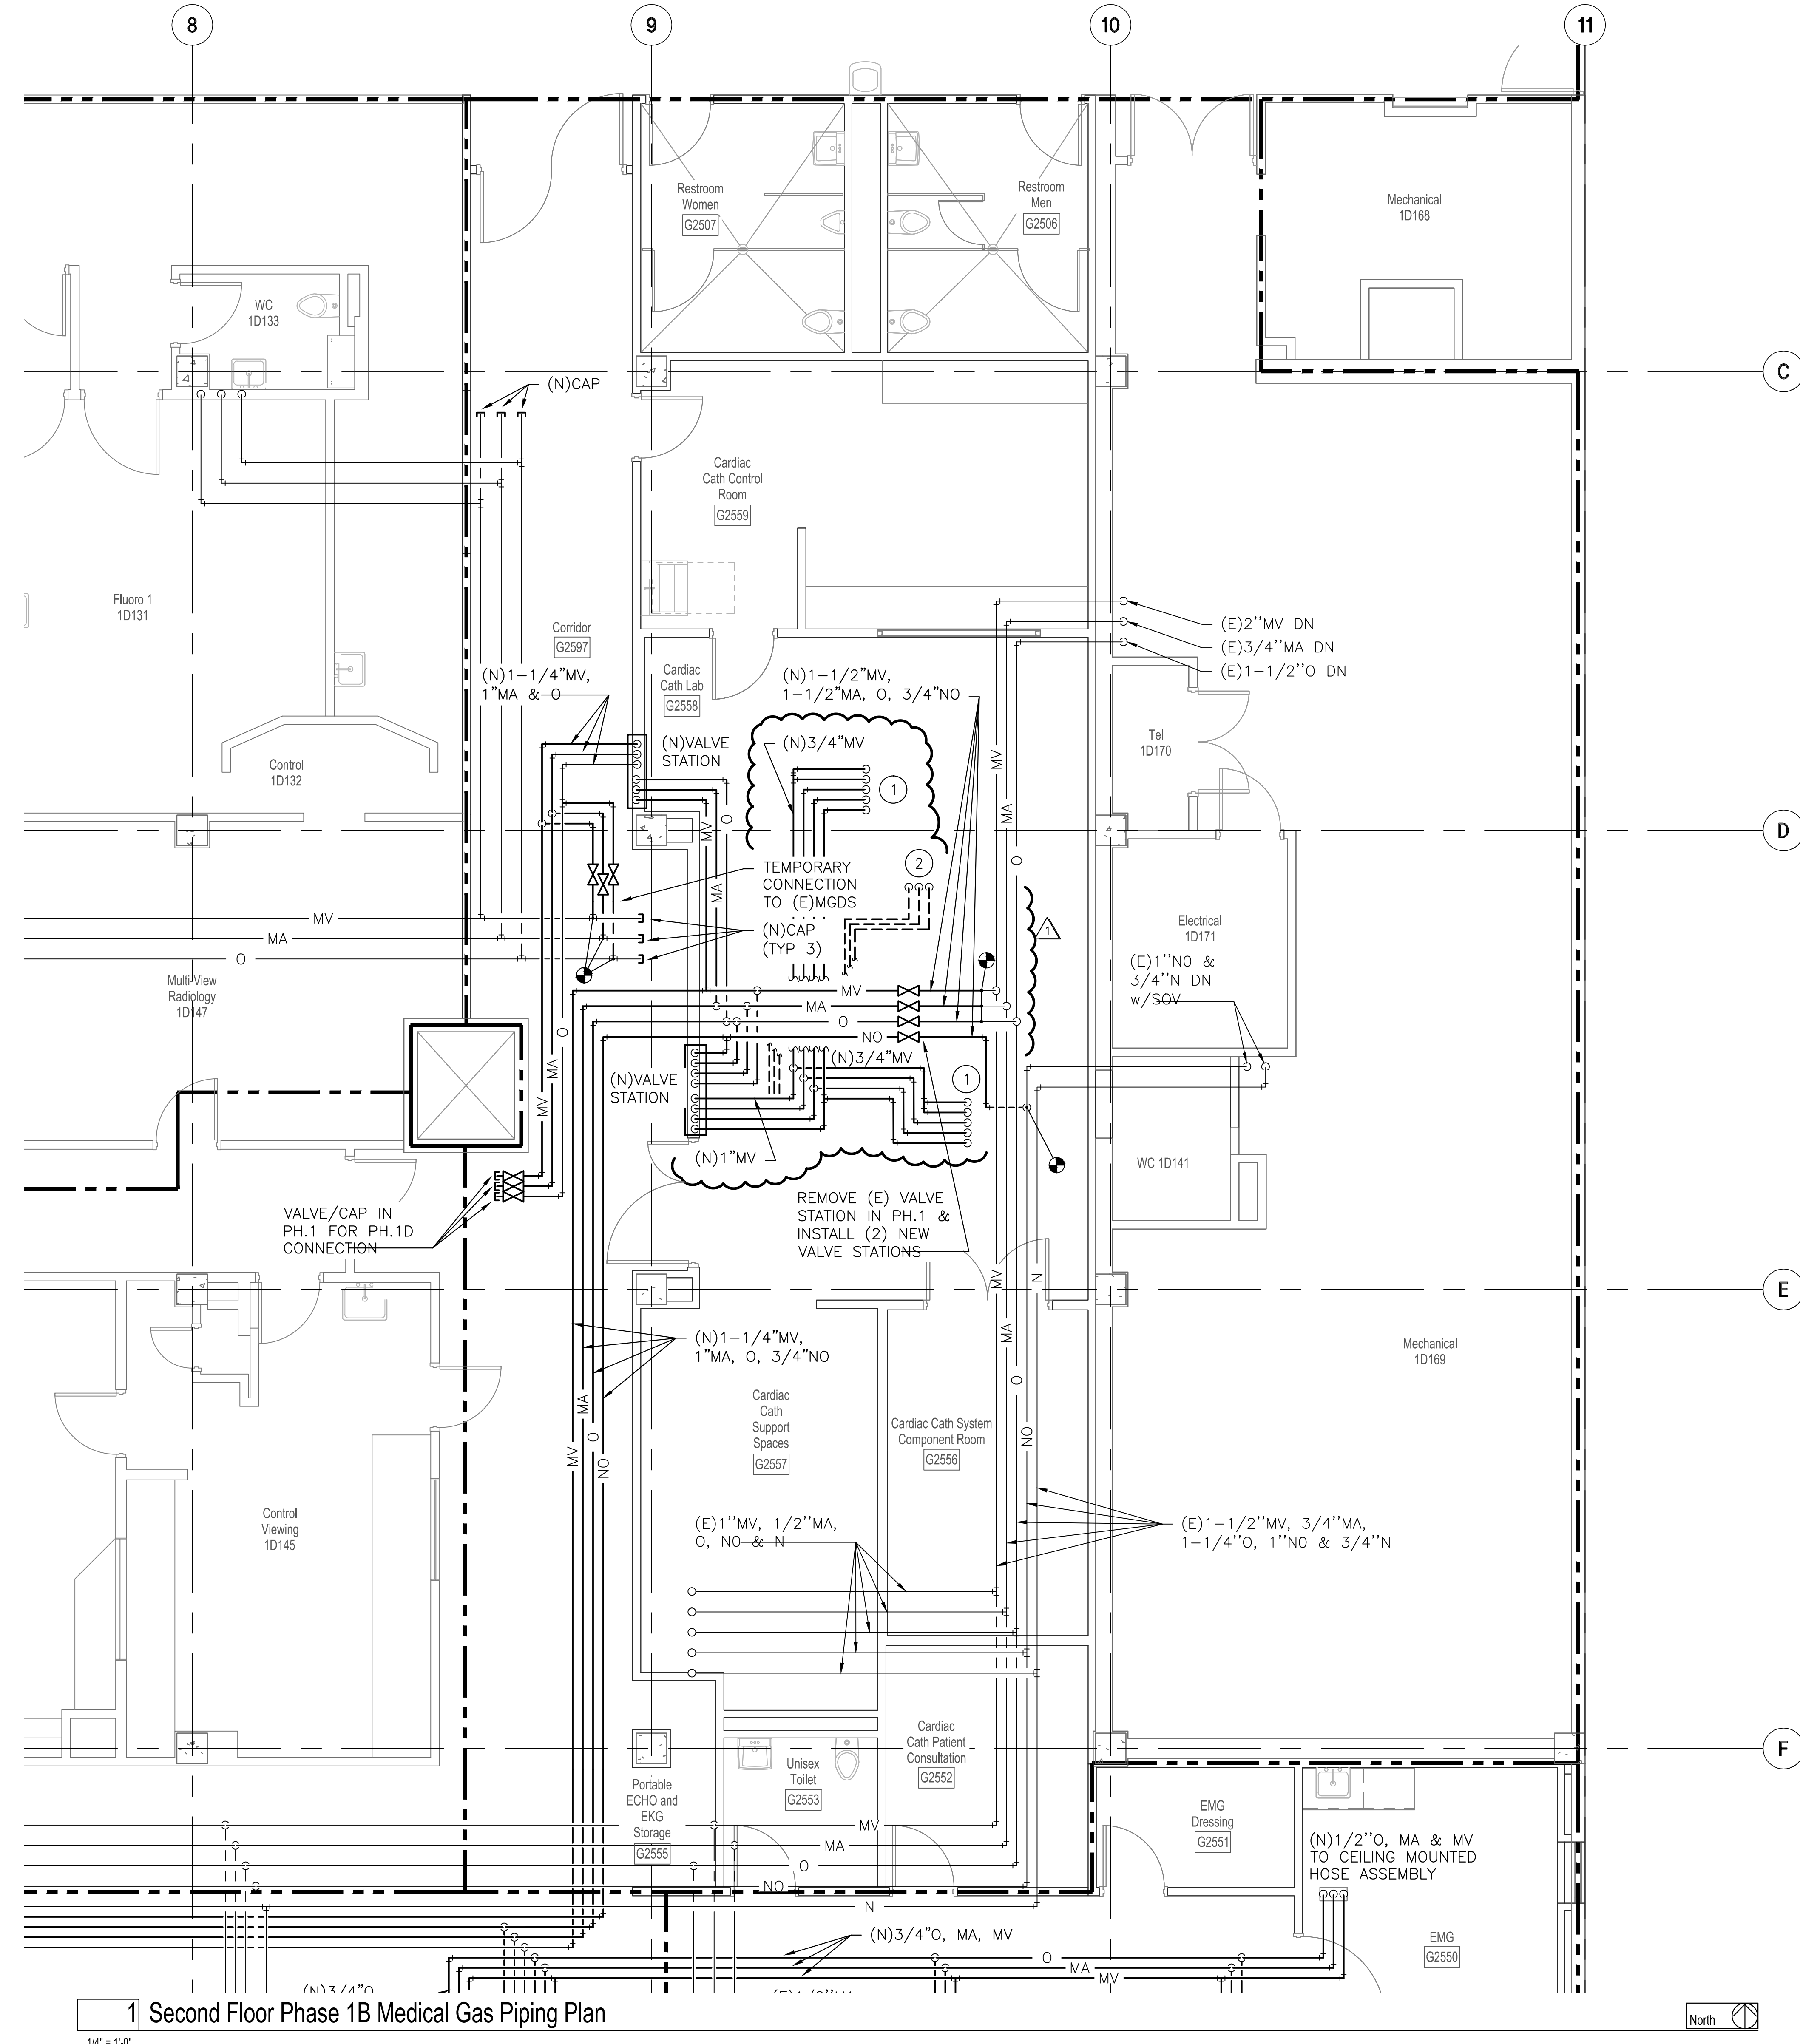


Phasing Keyplan

No Scale

1 Second Floor Phase 1B Medical Gas Piping Plan

 1/4" = 1'-0"



CONSULTANTS:		ARCHITECT/ENGINEERS:		Drawing Title		Project Title		Project Number		Office of Construction and Facilities Management 			
		H+K ARCHITECTS		Second Floor Phase 1B Medical Gas Piping Plan		Remodel and Expansion of DICE Services		654-777					
PETTY & ASSOCIATES, INC. MECHANICAL ENGINEERING CONSULTANTS 1375 GREG STREET, SUITE 108 SPARKS, NEVADA 89431 (775) 359-5777 FAX: 359-1119		5485 Reno Corporate Drive, Suite 100 Reno, Nevada 89511-2262 P 775+332+6640 F 775+332+6642 hkarchitects.com		Approved: Project Director		Location 975 Kirman Ave., Reno, NV. 89502		Building Number 1D					
AMENDMENT DRAWINGS		Date		Date		Date		Checked RA		Drawn EM		Drawing Number PG123	

VA FORM 08-6231

Bid Documents - Final