
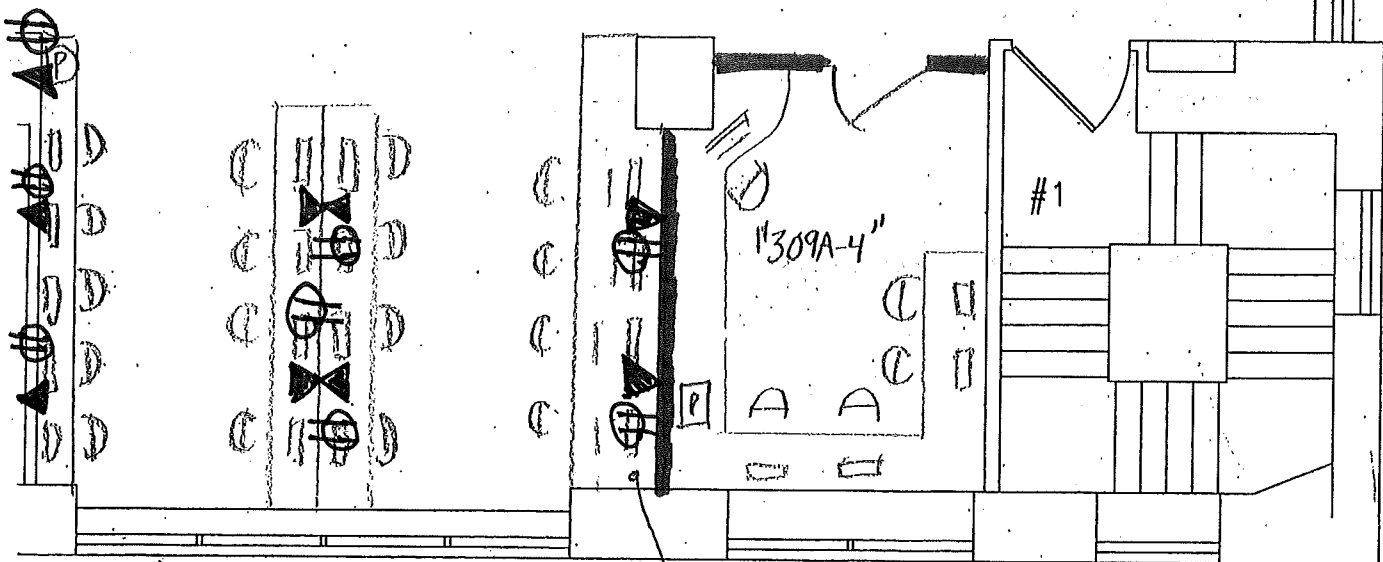


309A-2 MARYVALE  
LEARNING CENTER / CED PREP  
8 NON-NETWORKED Computers  
1 Printer/FAX/SCAN

▲ - Data outlet (3 ports)  
⊕ - Double Duplex Outlet

309A-3 INT VOC REHAB  
COUNSELING + GROUP PREVOC  
EDUCATION OFFICE  
1 VA NETWORKED CPU/TELEHEALTH  
1 VA PRINTER / MULTI  
2-4 NON VA NETWORK COMPUTERS  
1 NON VA NETWORK LAP TOP +  
SMARTBOARD

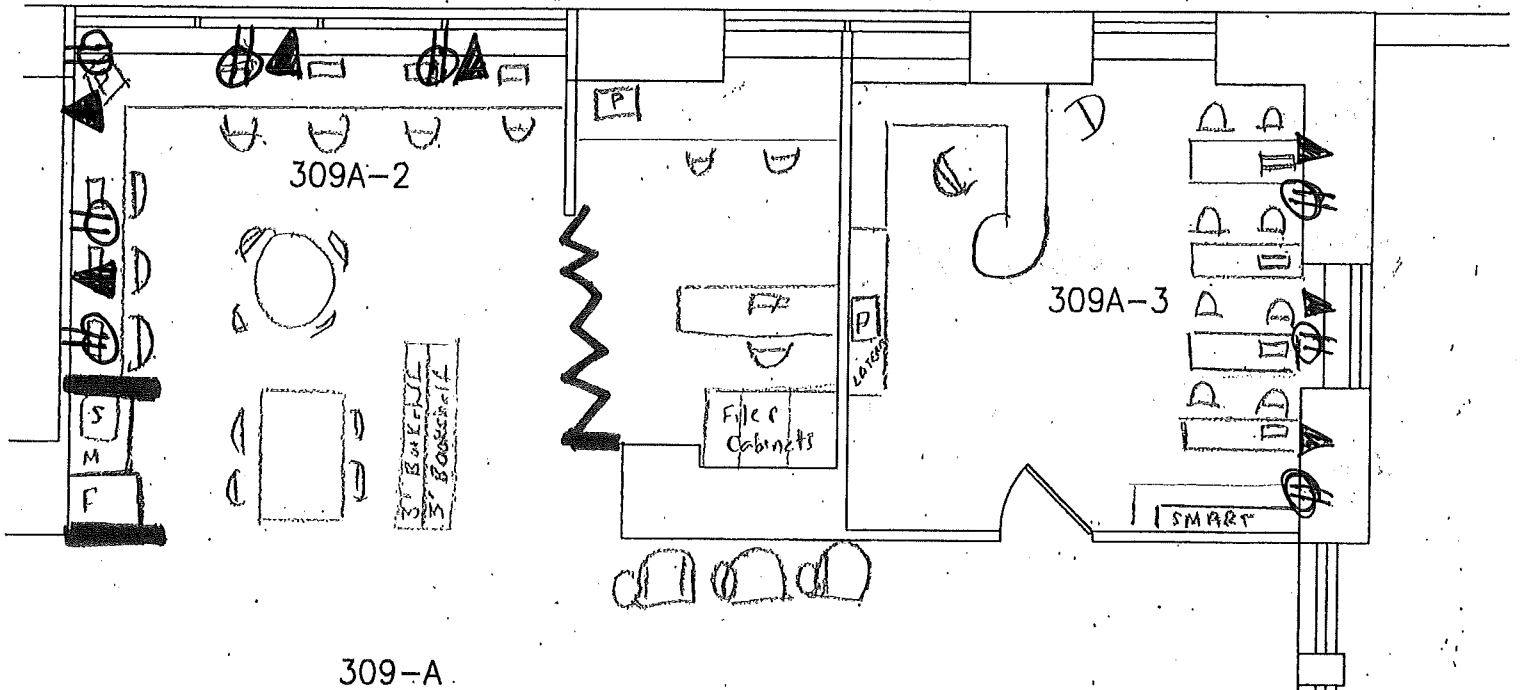

## THIRD FLOOR PLAN

SCALE: 1/8" = 1'-0" NOT TO SCALE

309-A  
OPEN ACCESS AREA  
16+ NON-VA NETWORK COMPUTERS  
2 PRINTERS

NEW 309A-4  
CMT/VOC REHAB COUNSELING-  
GROUP PATIENT EDUCATION OFFICE

1 VA NETWORKED CPU/TELEHEALTH UNIT  
1 NON VA PRINTER  
4+ NON NETWORKED COMPUTERS

SA-1 7/16/13