




PARTIAL 11TH FLOOR PLAN -  
NEW FLOOR PLAN

SCALE: 1/8" = 1'-0"

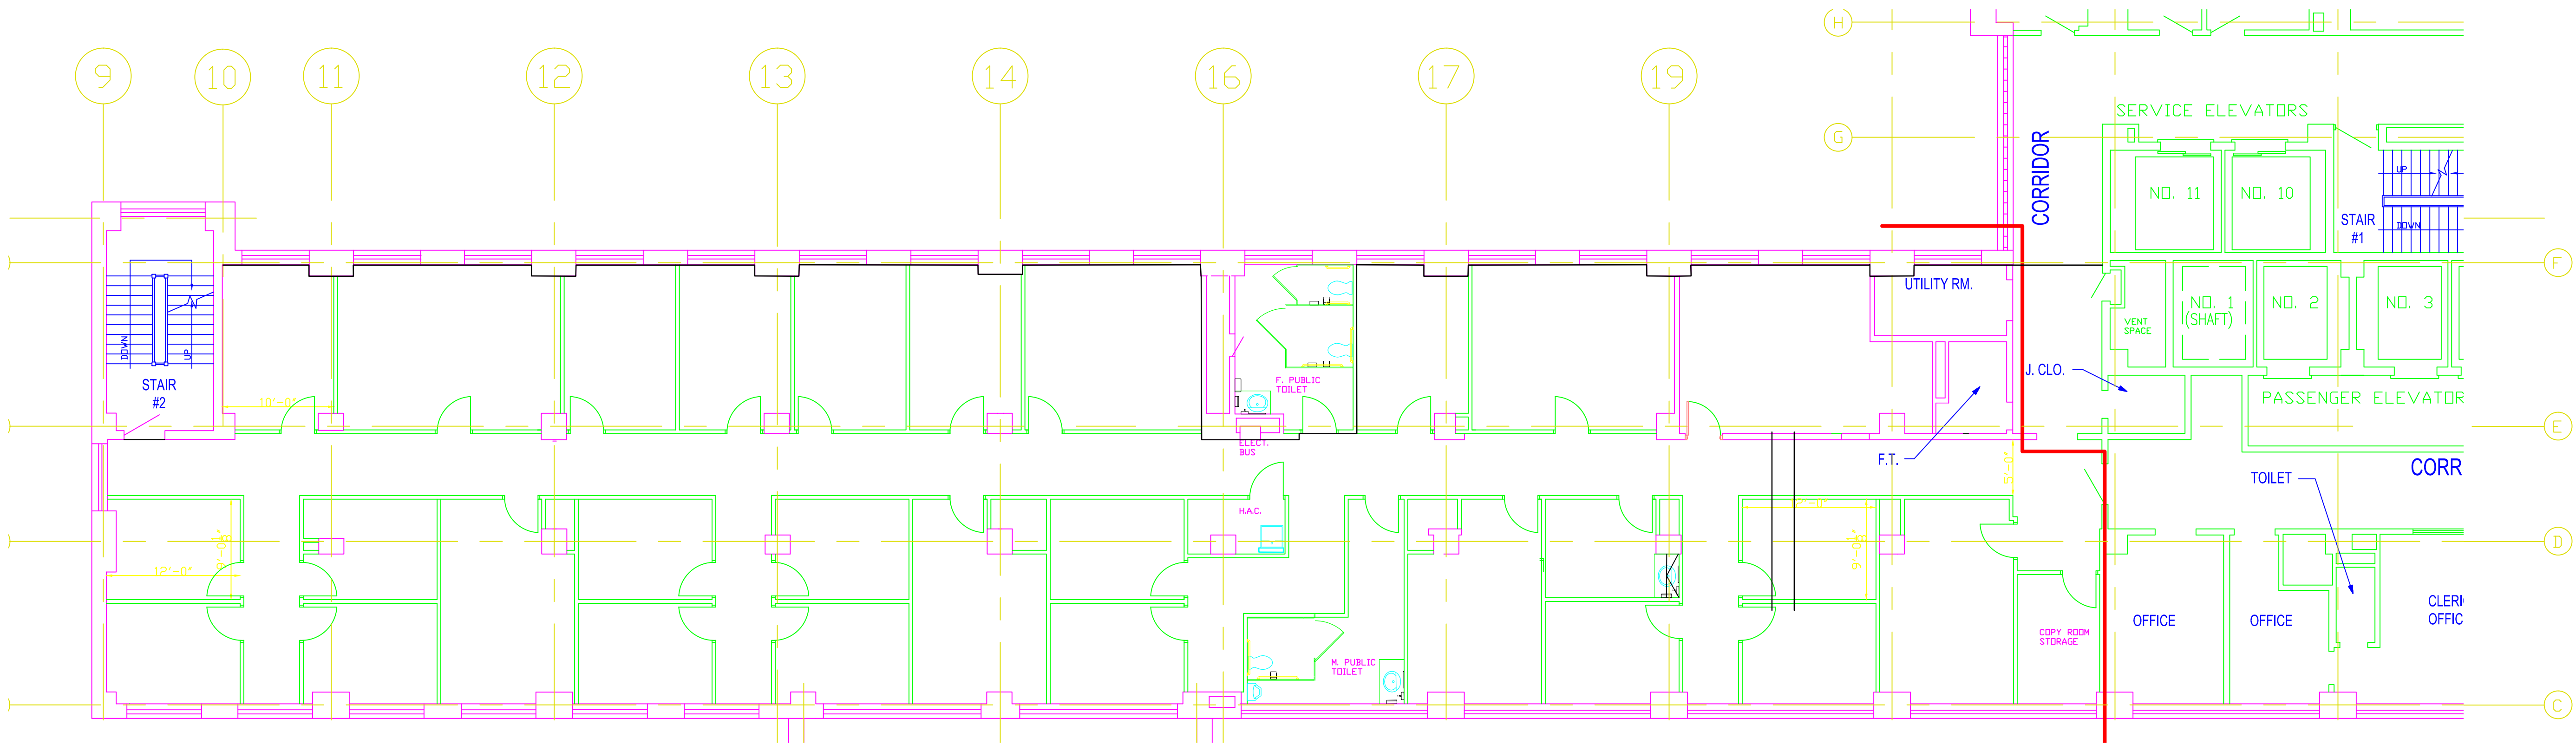

PARTIAL 11TH FLOOR PLAN -  
NEW FLOOR PLAN

SCALE: 1/8" = 1'-0"

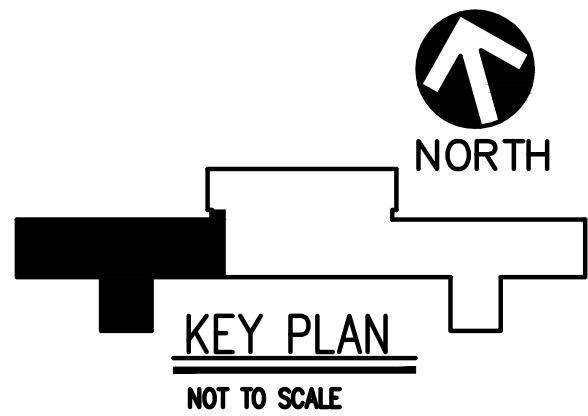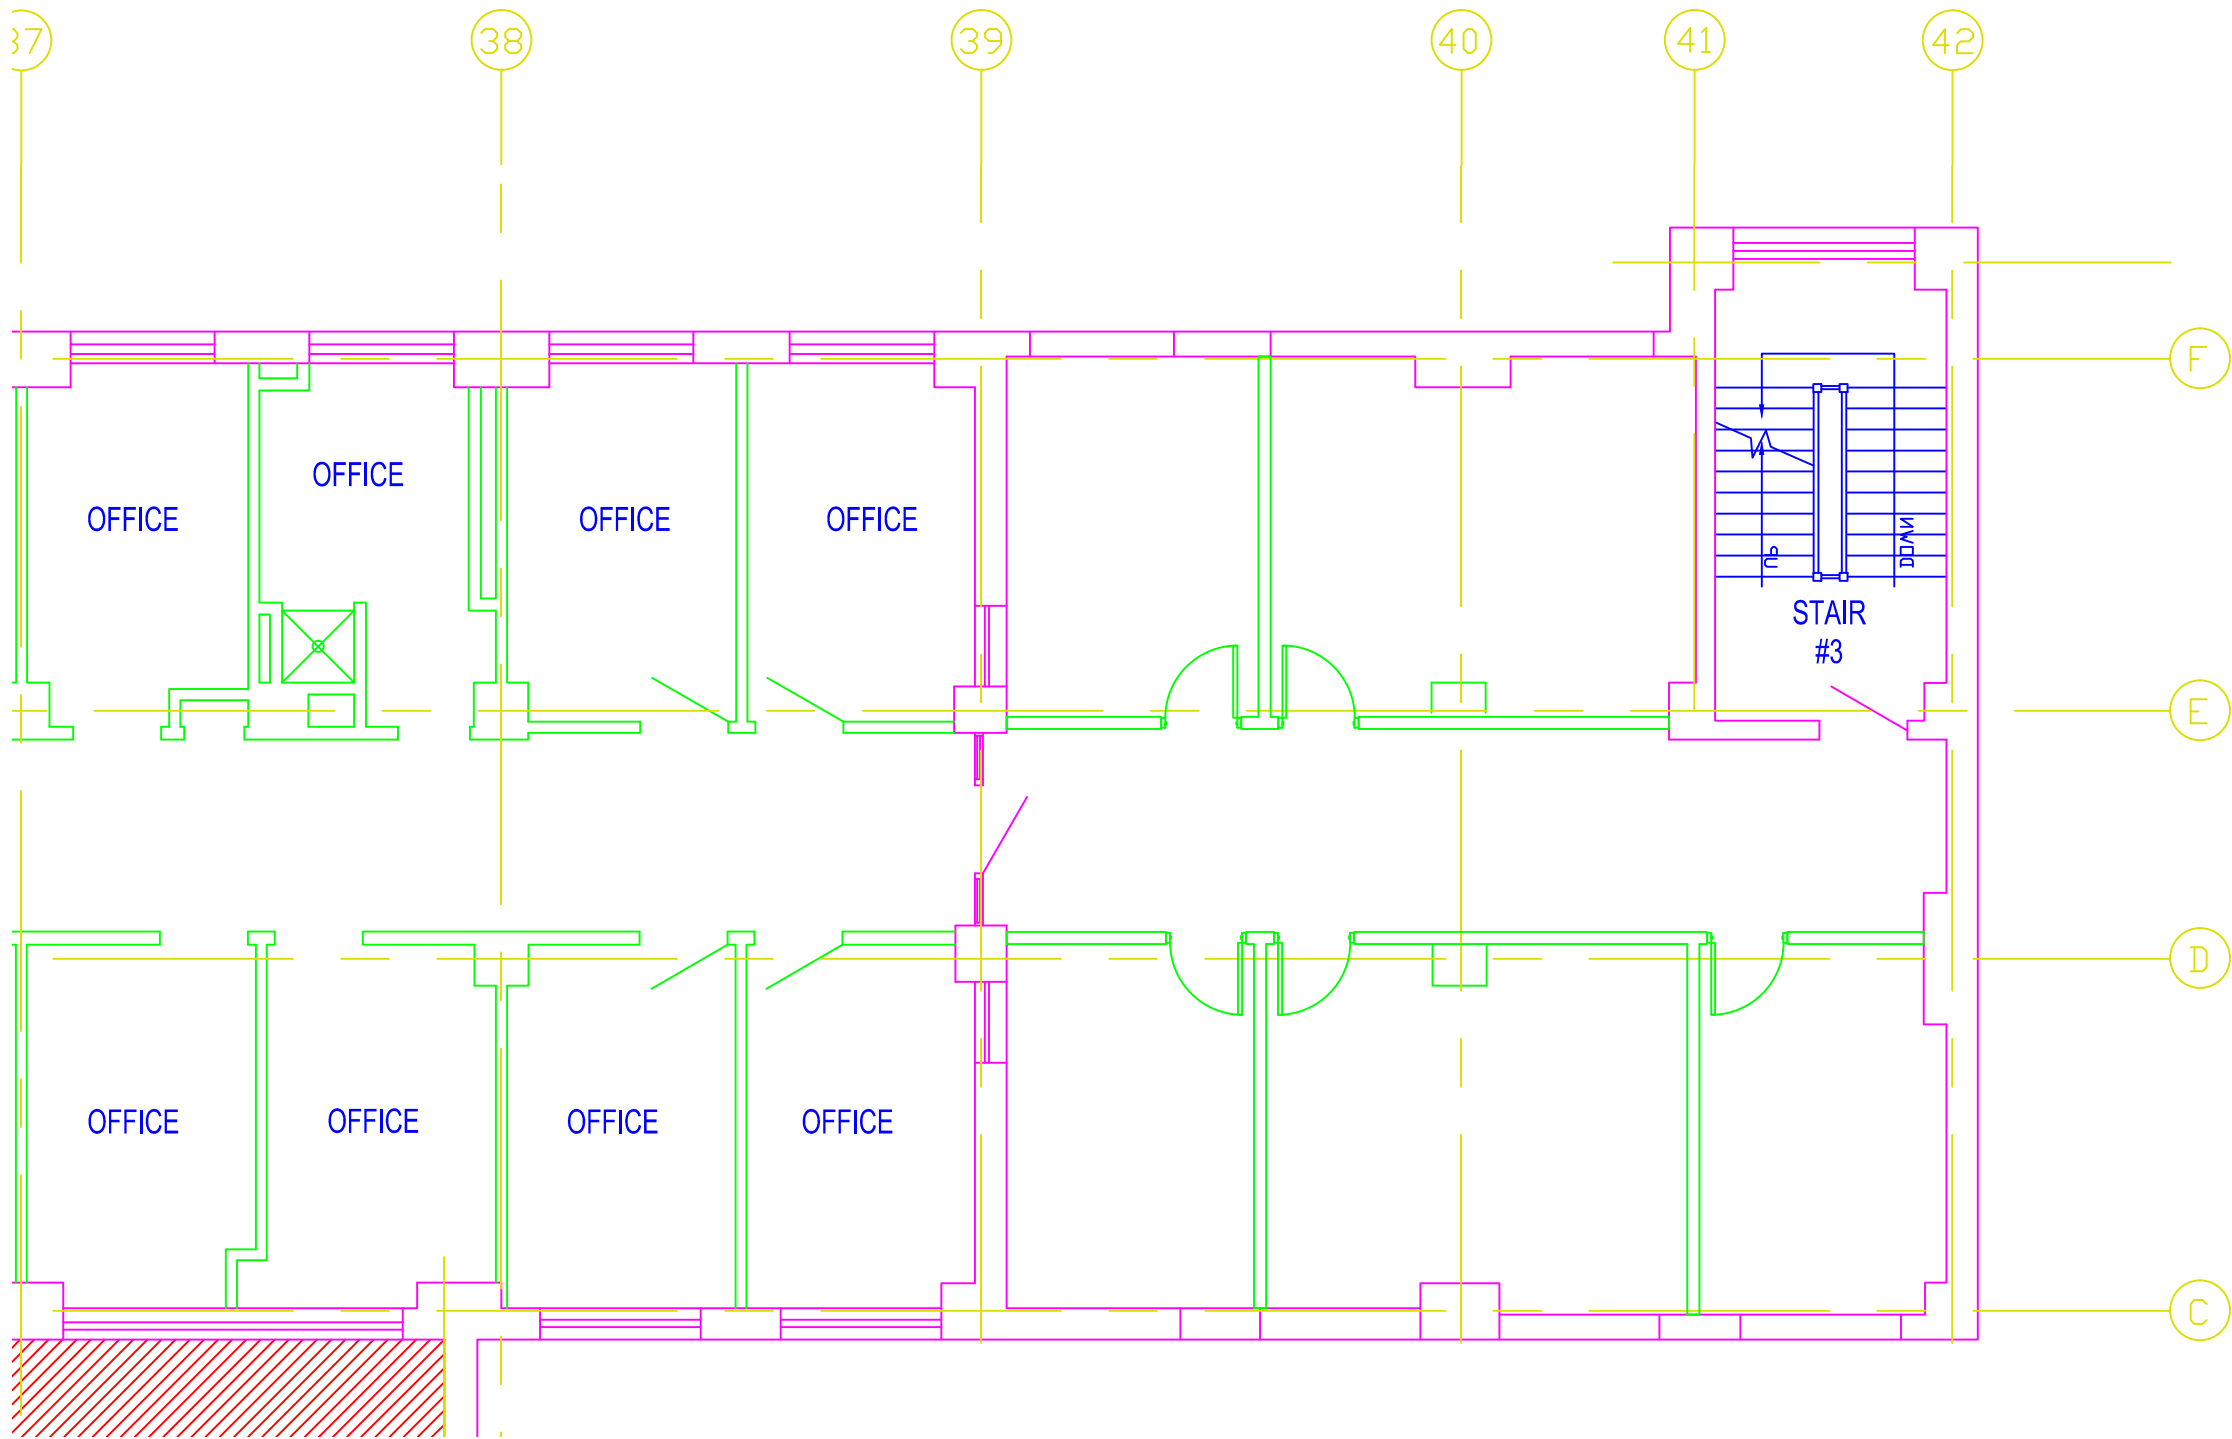

LEVEL 1 DESIGN

NOT FOR CONSTRUCTION

REVISIONS:	DATE



VAPHCS – UD  
University Drive  
Pittsburgh, PA 15240



APPROVED: DIRECTOR	APPROVED: VP, FACILITIES MANAGEMENT
APPROVED: ASSOCIATE DIRECTOR	APPROVED: CHIEF, PROJECTS SECTION
APPROVED: CHIEF OF STAFF	APPROVED: PROJECT ENGINEER
RESERVED	

DRAWING TITLE <b>MODULAR WALL SYSTEM CONCEPT</b>	
PROJECT NO. RESERVED	CONTRACT NO. RESERVED
BUILDING NO. RESERVED	AUTOCAD FILE NAME: R:\Projects\VA University Drive 08047 - 4 East 5373 Drawings\08047 12-1.dwg

PROJECT TITLE <b>RENOVATE 11 WEST</b>		
DESIGNED BY: HHH	DRAWN BY: HHH	CHECKED BY: RESERVED
LOCATION VAMC UNIVERSITY DR. PITTSBURGH, PA		

DATE 7/26/2012
SCALE 1/8" = 1'-0"
DRAWING NO. <b>AS-3</b>

DEPARTMENT OF  
VETERANS AFFAIRS