



PARTIAL 11TH WEST FLOOR PLAN -
REFLECTED CEILING PLAN

SCALE: 1/8" = 1'-0"



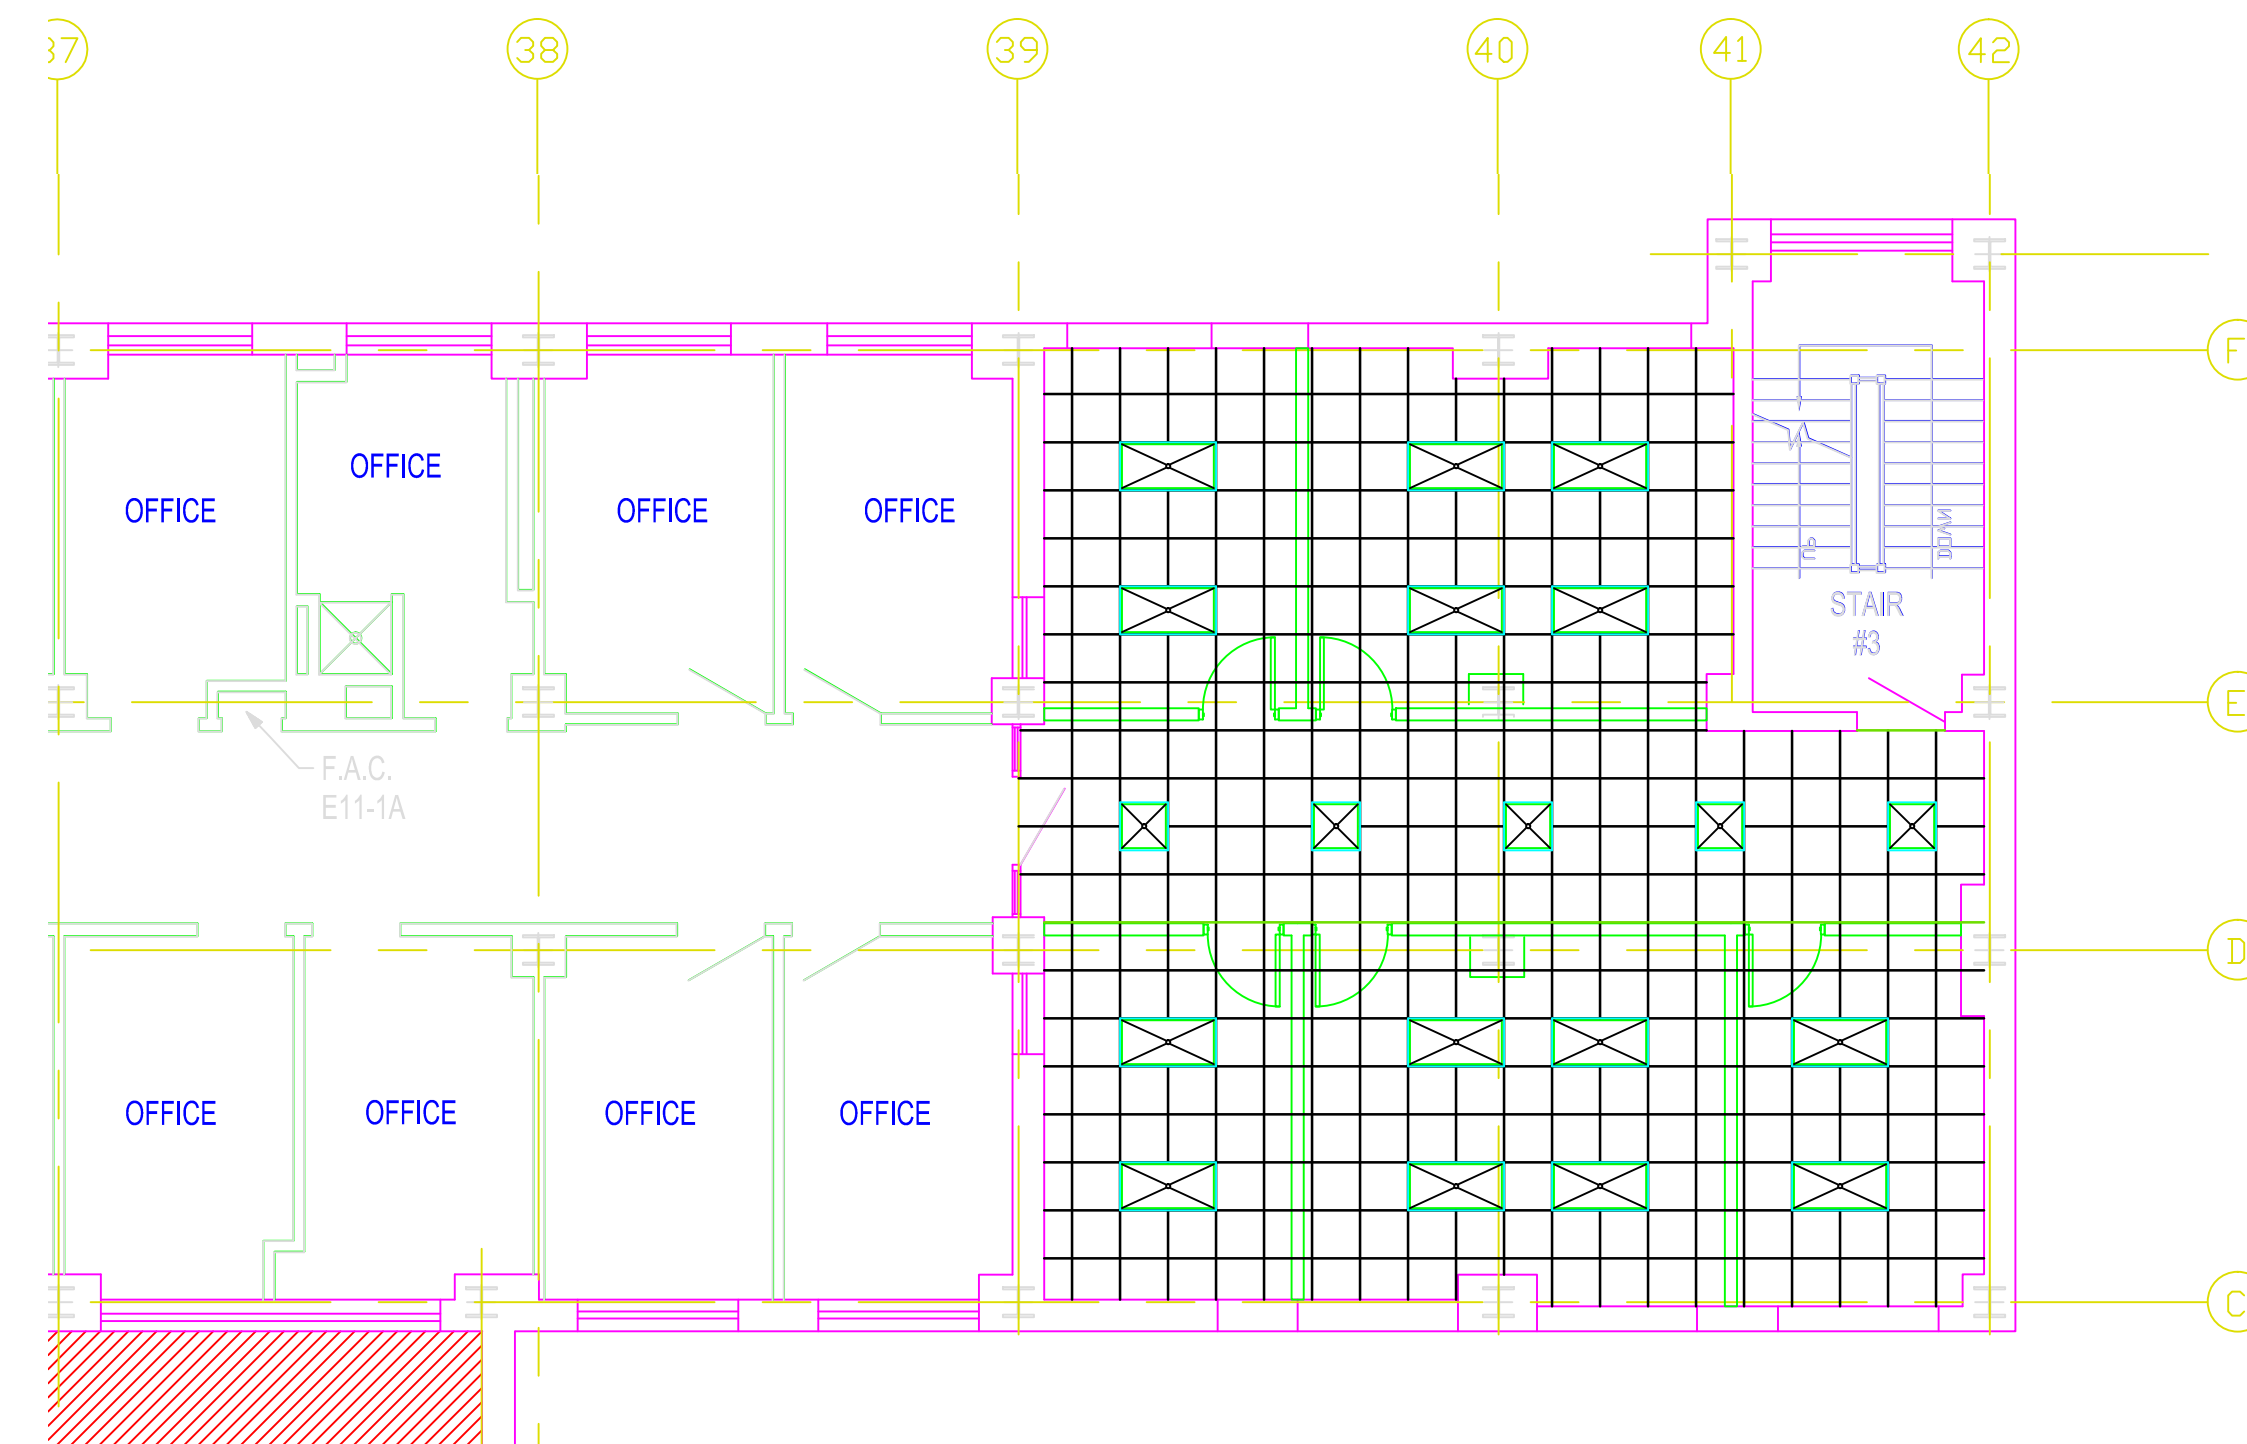

PARTIAL 11TH EAST FLOOR PLAN -
REFLECTED CIELING PLAN

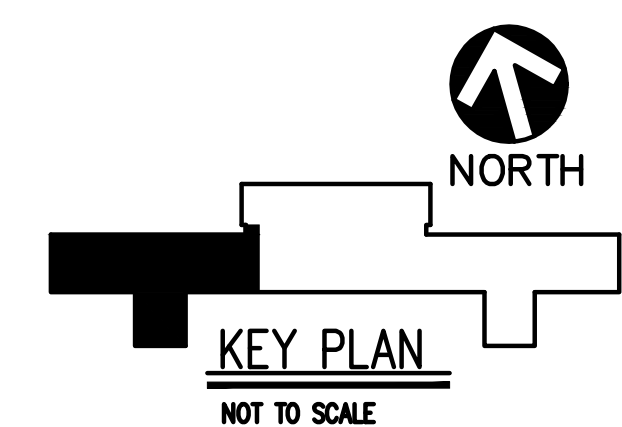SCALE: 1/8" = 1'-0"



LEVEL 1 DESIGN
NOT FOR CONSTRUCTION

REVISIONS: <table border="1"> <tr> <td> </td> <td> </td> </tr> </table>				 <p>VAPHCS - UD University Drive Pittsburgh, PA 15240</p> 		APPROVED: DIRECTOR APPROVED: ASSOCIATE DIRECTOR APPROVED: CHIEF OF STAFF RESERVED		APPROVED: VP, FACILITIES MANAGEMENT APPROVED: CHIEF, PROJECTS SECTION APPROVED: PROJECT ENGINEER		DRAWING TITLE REFLECTED CEILING PLAN PROJECT NO. RESERVED BUILDING NO. RESERVED		CONTRACT NO. RESERVED AUTOCAD FILE NAME: <small>R:\Projects\VA University Drive 08047 - East SPT3 Drawings\08047 12-1.dwg</small>		PROJECT TITLE RENOVATE 11 WEST DESIGNED BY: HHH DRAWN BY: HHH CHECKED BY: RESERVED LOCATION VAMC UNIVERSITY DR. PITTSBURGH, PA		DATE 8/27/2012 SCALE 1/8" = 1'-0" DRAWING NO. AS-5		DEPARTMENT OF VETERANS AFFAIRS