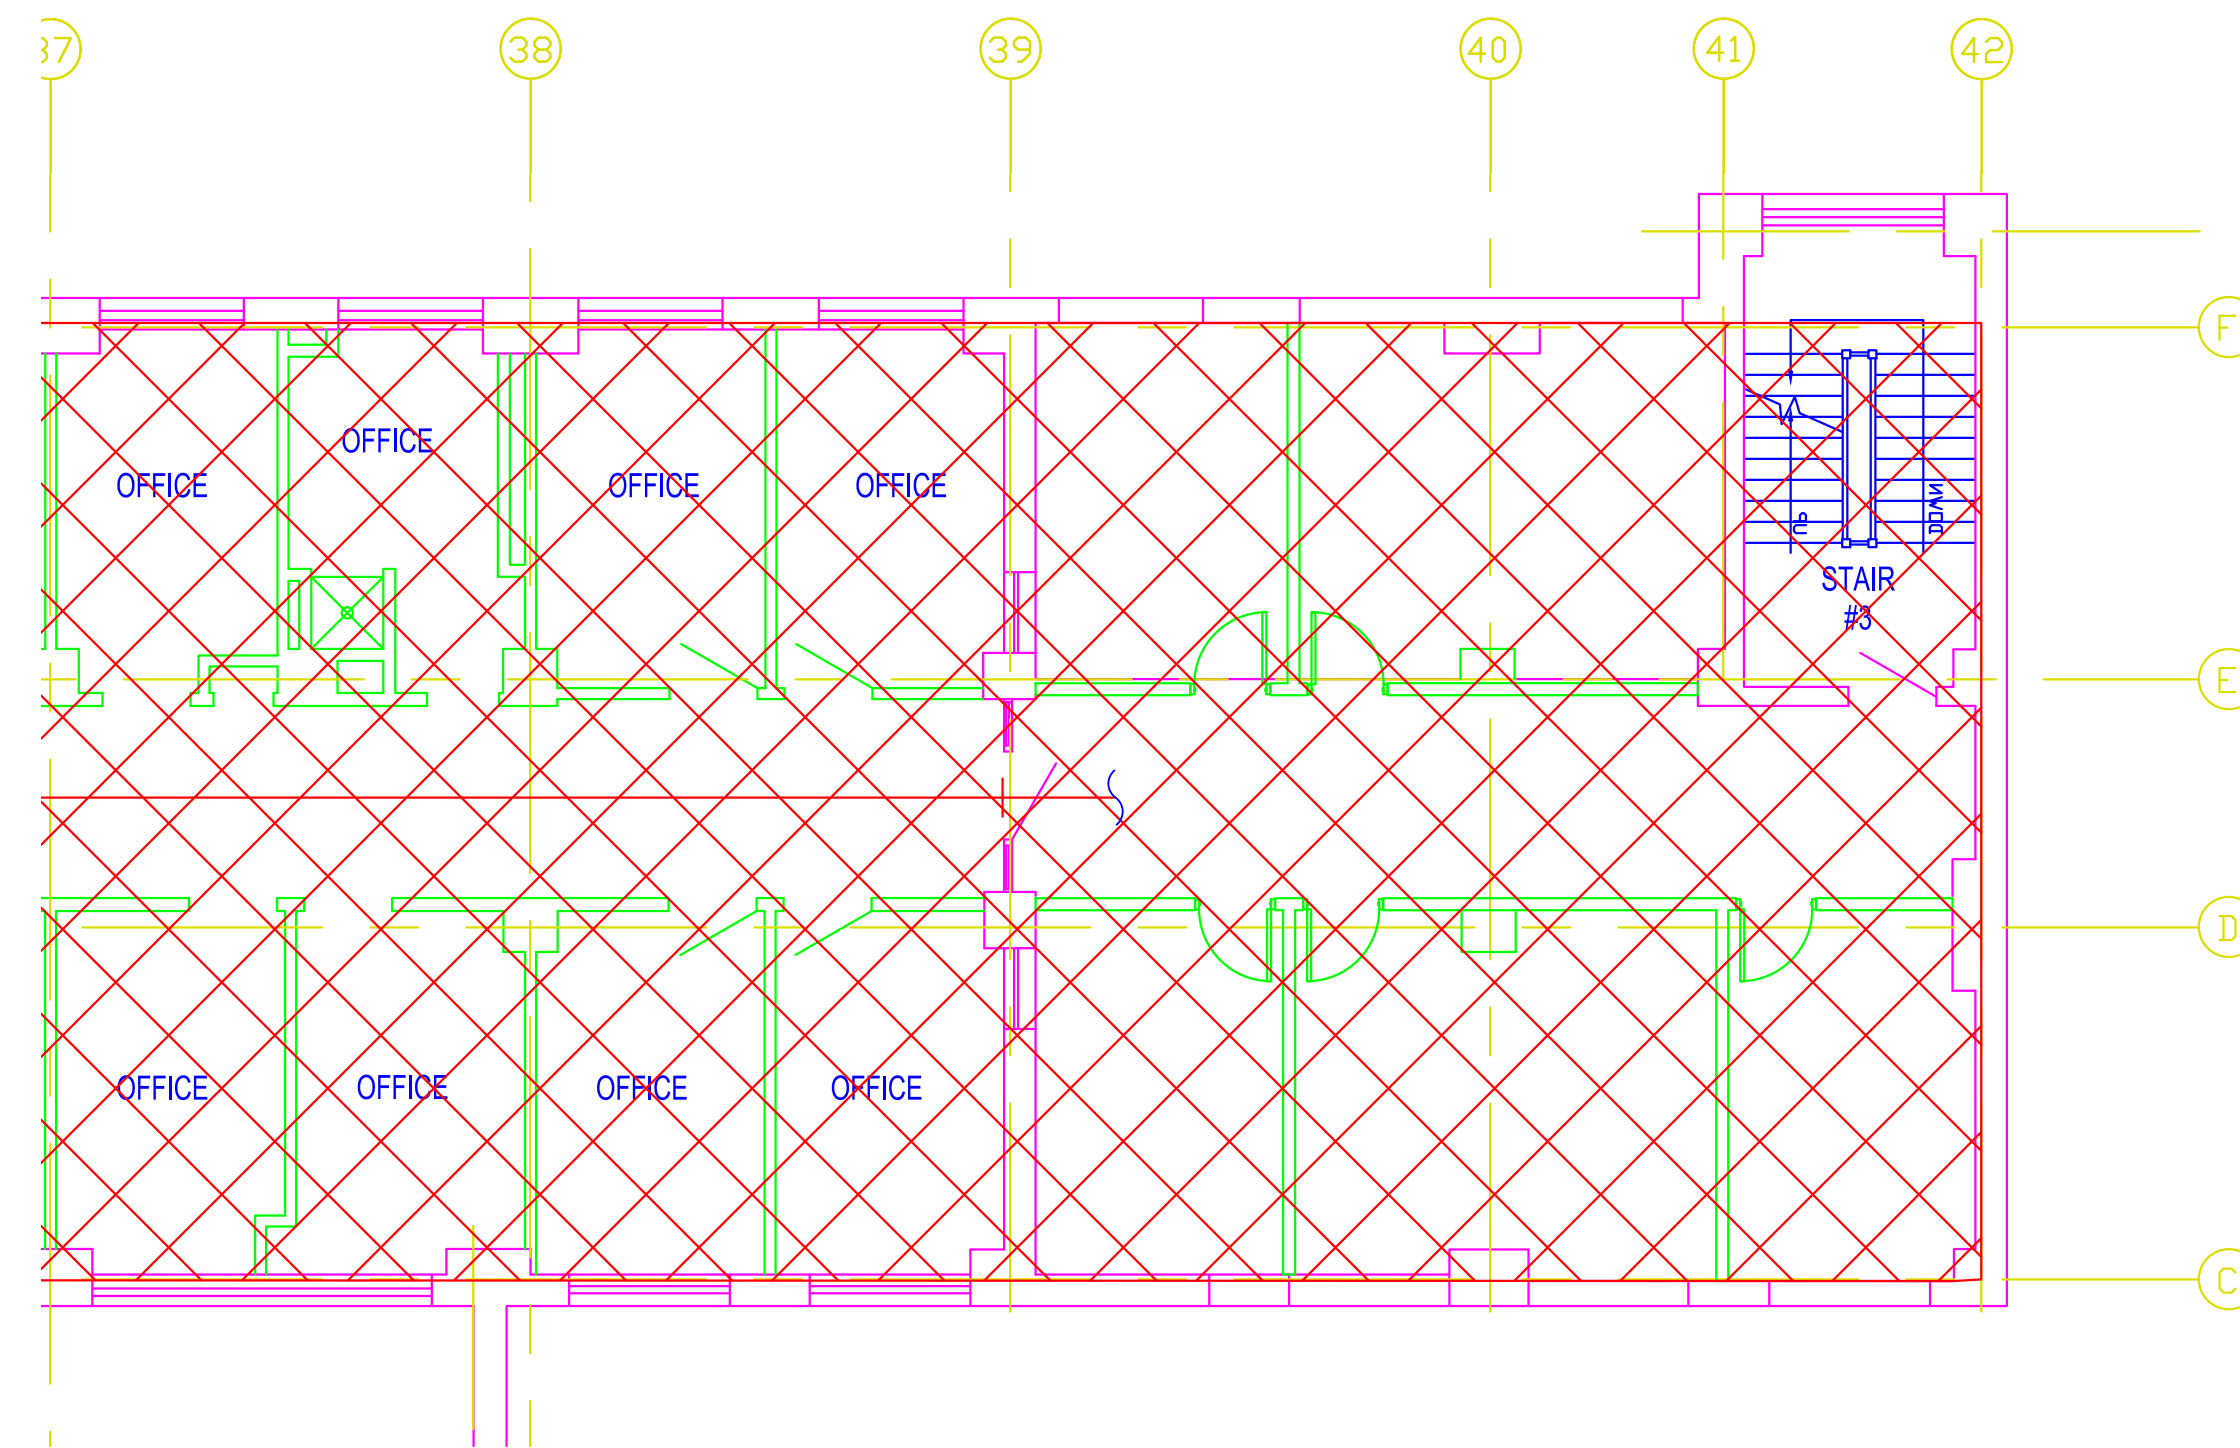


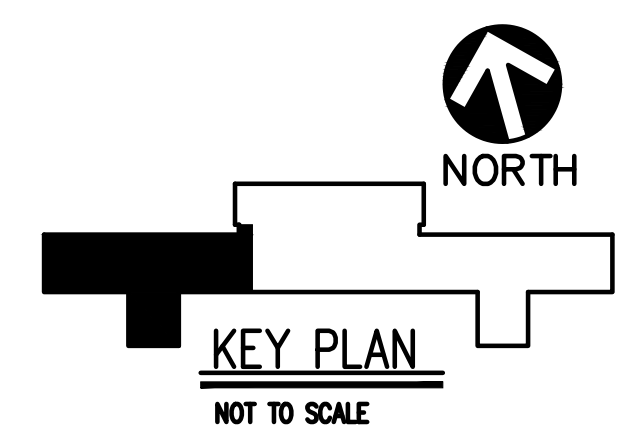
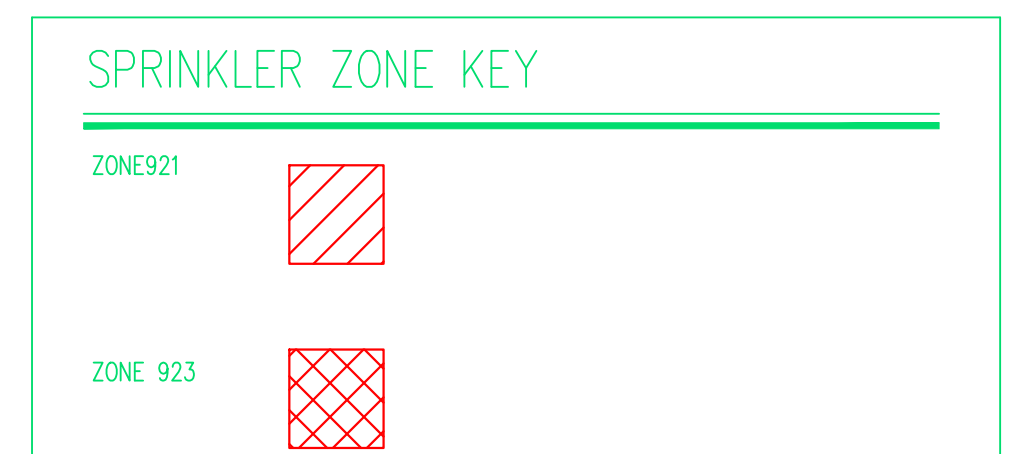
PARTIAL 11TH WEST FLOOR PLAN -
NEW FLOOR PLAN

SCALE: 1/8" = 1'-0"





PARTIAL 11TH EAST FLOOR PLAN -
NEW FLOOR PLAN

SCALE: 1/8" = 1'-0"



LEVEL 1 DESIGN
NOT FOR CONSTRUCTION

REVISIONS: 	DATE 	 <div data-bbox="604 1821 872 1917"> VAPHCS – UD University Drive Pittsburgh, PA 15240 </div> 		APPROVED: DIRECTOR APPROVED: ASSOCIATE DIRECTOR APPROVED: CHIEF OF STAFF RESERVED	APPROVED: VP, FACILITIES MANAGEMENT APPROVED: CHIEF, PROJECTS SECTION APPROVED: PROJECT ENGINEER	<div data-bbox="2029 1772 2292 1862"> FIRE PROTECTION PLAN-SPRINKLER ZONE </div> <div data-bbox="2029 1872 2292 1954"> PROJECT NO. RESERVED CONTRACT NO. RESERVED BUILDING NO. RESERVED <small>AUTOCAD FILE NAME: R:\Projects\VA University Drive 08047.dwg Drawing: 08047 12-1.dwg</small> </div>	<div data-bbox="2346 1772 2728 1841"> PROJECT TITLE RENOVATE 11 WEST </div> <div data-bbox="2346 1872 2728 1954"> DESIGNED BY: HHH DRAWN BY: HHH CHECKED BY: RESERVED LOCATION VAMC UNIVERSITY DR. PITTSBURGH, PA </div>	<div data-bbox="2752 1772 2862 1862"> DATE 8/27/2012 SCALE 1/8" = 1'-0" </div> <div data-bbox="2752 1872 2862 1954"> DRAWING NO. FA-1 </div>	DEPARTMENT OF VETERANS AFFAIRS
----------------	----------	---	--	--	--	--	---	---	-----------------------------------