


Three inches = one foot  
one and one-half inches = one foot  
one inch = one foot  
three-quarters inch = one foot  
one-half inch = one foot  
three-eighths inch = one foot  
one-quarter inch = one foot  
one-eighth inch = one foot

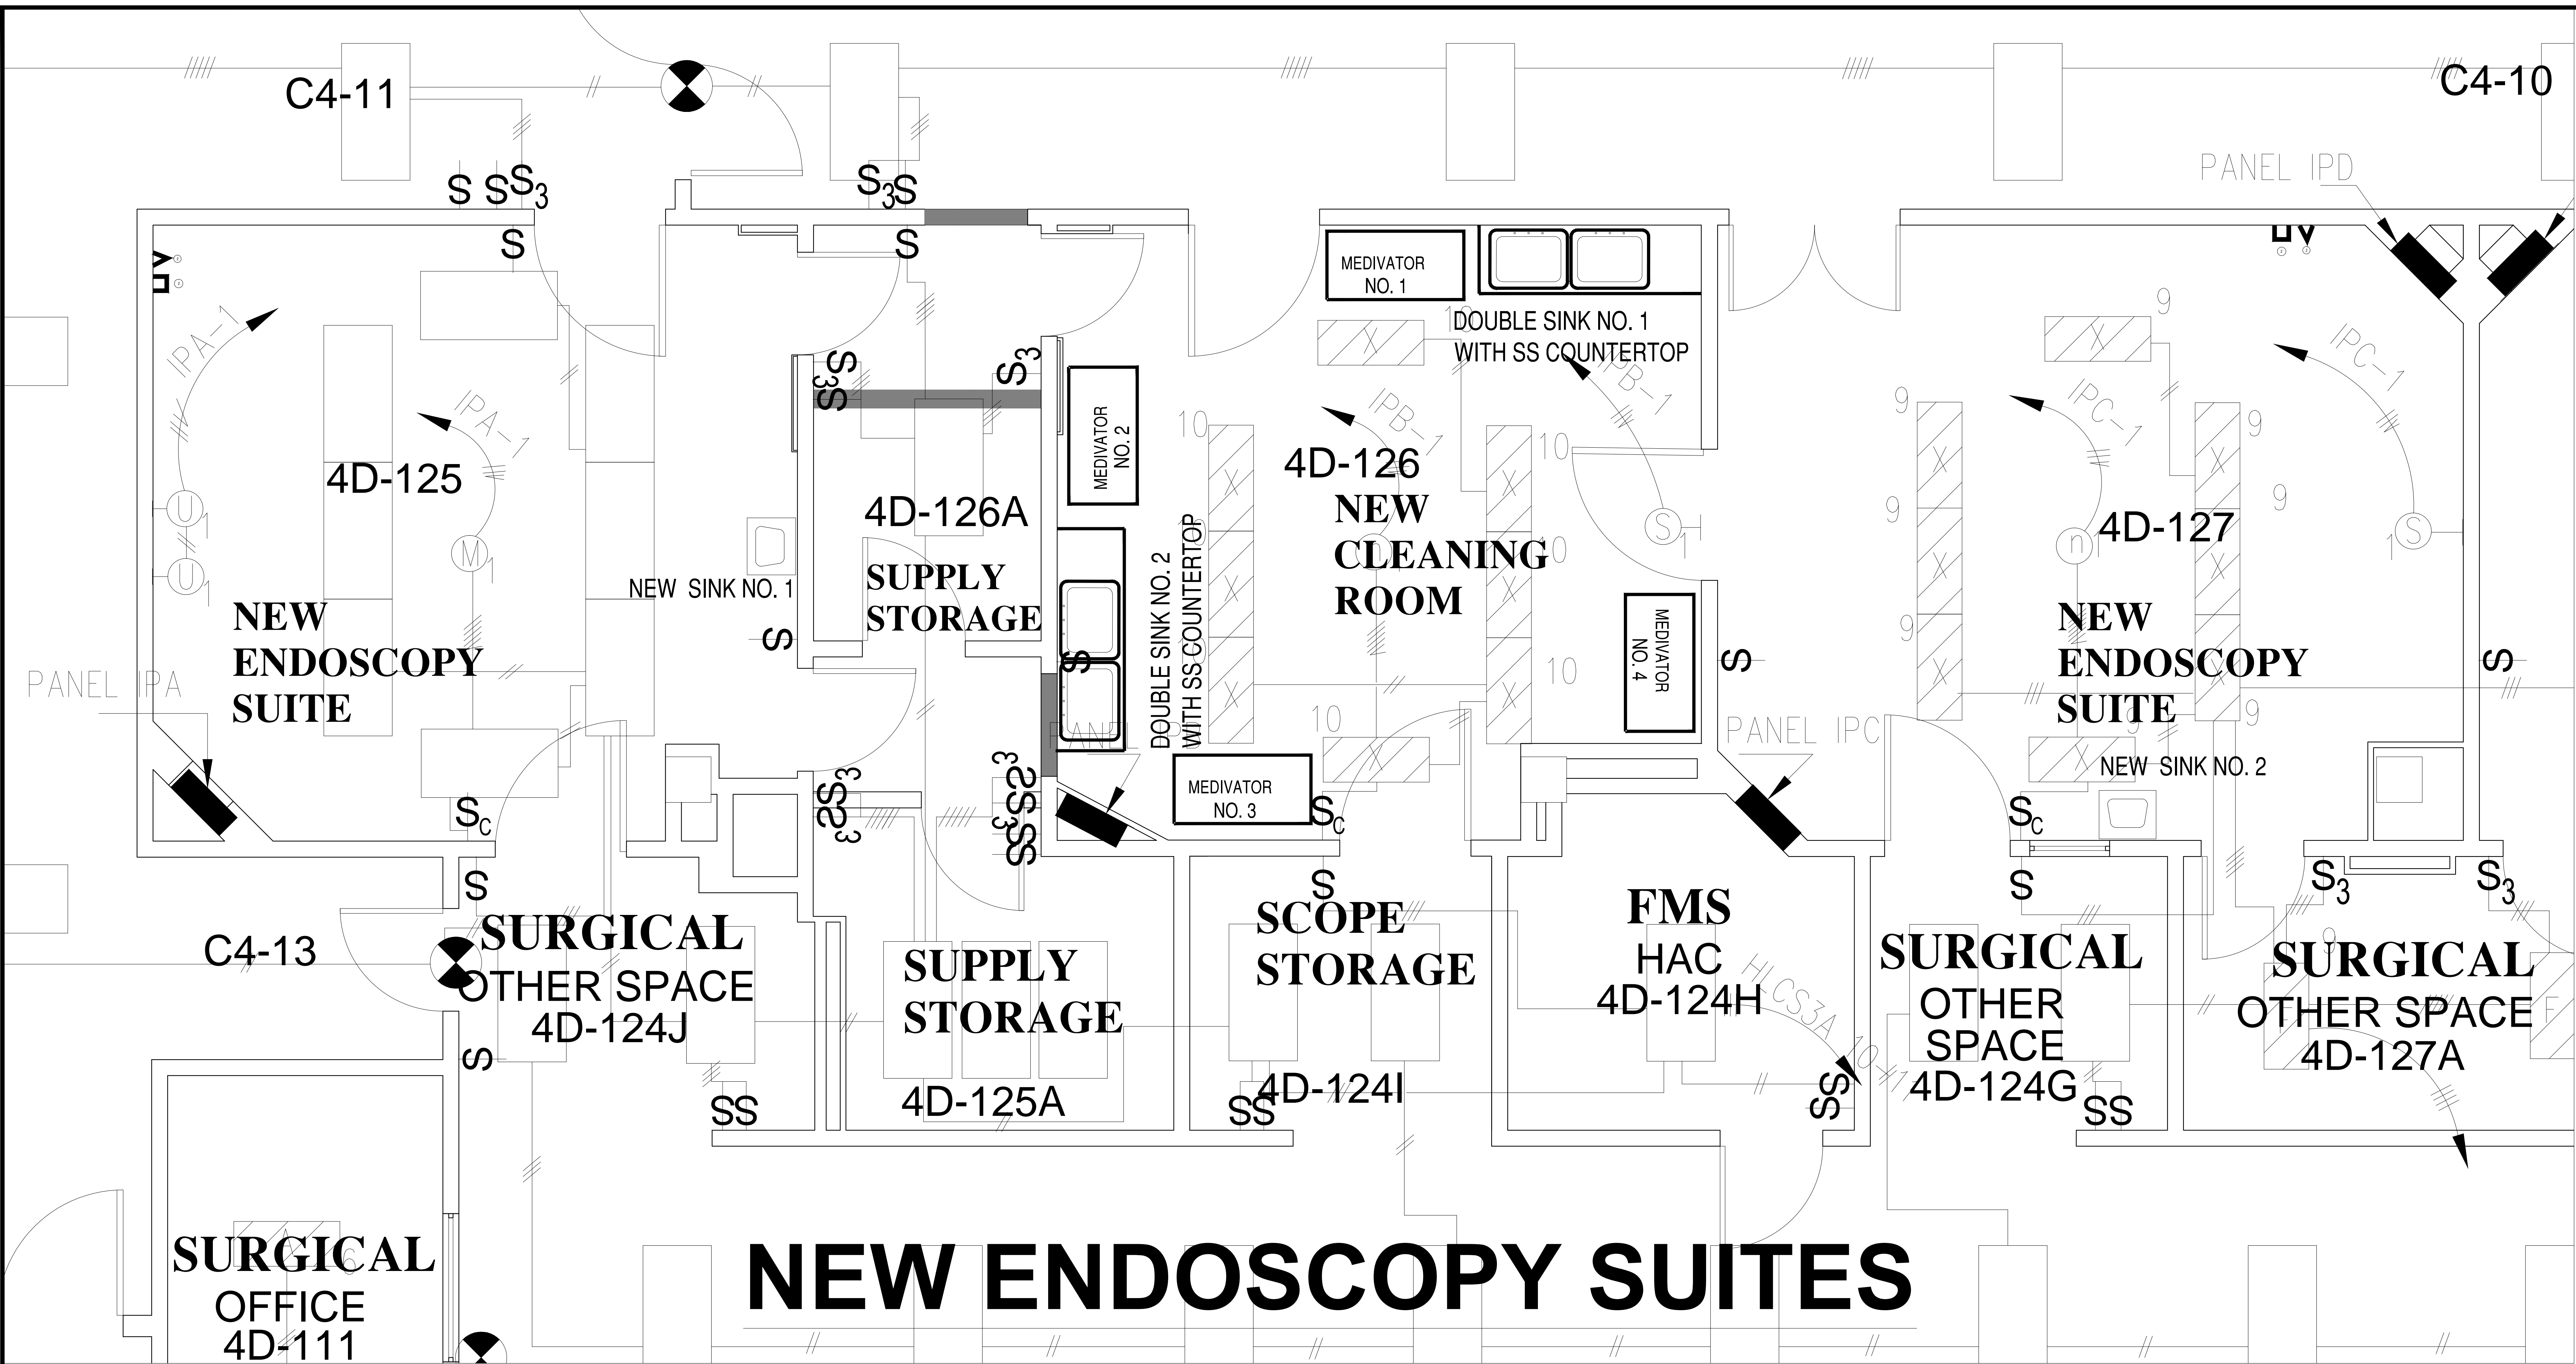

## ELECTRICAL NOTES

1. INSTALL STAINLESS STEEL GFI RECEPTACLES FOR EACH MEDIVATOR SHOWN IN ROOM 4D-126. EACH MEDIVATOR REQUIRES 230 VAC 50/60 Hz, 6 AMP, 1 Ph AND 120 VAC 60 Hz, 12 AMP, 1 Ph POWER.
2. INSTALL DATA AND PHONE OUTLETS WALL MOUNTED AS SHOWN. COORD. WITH COR FOR EXACT LOCATION.
3. PROVIDE AND INSTALL FLOOR-MOUNTED JUNCTION BOX FOR POWERED EXAM AND TREATMENT TABLE IN EACH ENDOSCOPY SUITE, COORDINATE WITH COR FOR EXACT LOCATION.

Revisions	Date	NOTES:	SCALE : 3/8" = 1'-0"	Approved: PROGRAM MANAGER, PROJECTS SAFETY/INDUSTRIAL HYGIENE HEALTH SYSTEM SPECIALIST MAINTENANCE SUPERVISOR MAINTENANCE FOREMAN MAINTENANCE FOREMAN	Drawing Title ELECTRICAL PLAN Approved: Service Engineer Approved: Service Director	Project Title RENOVATE CYSTO TO STERILE CLEANING, BLDG. 3 Building Number B3 Location VAMC BILOXI, MS	Date 07/16/13 Project No. 520-13-130 DRAWING NO. EL 001 Dwg. 1 of 1	Office of Facilities Department of Veterans Affairs
-----------	------	--------	----------------------	---	--	--	---	--