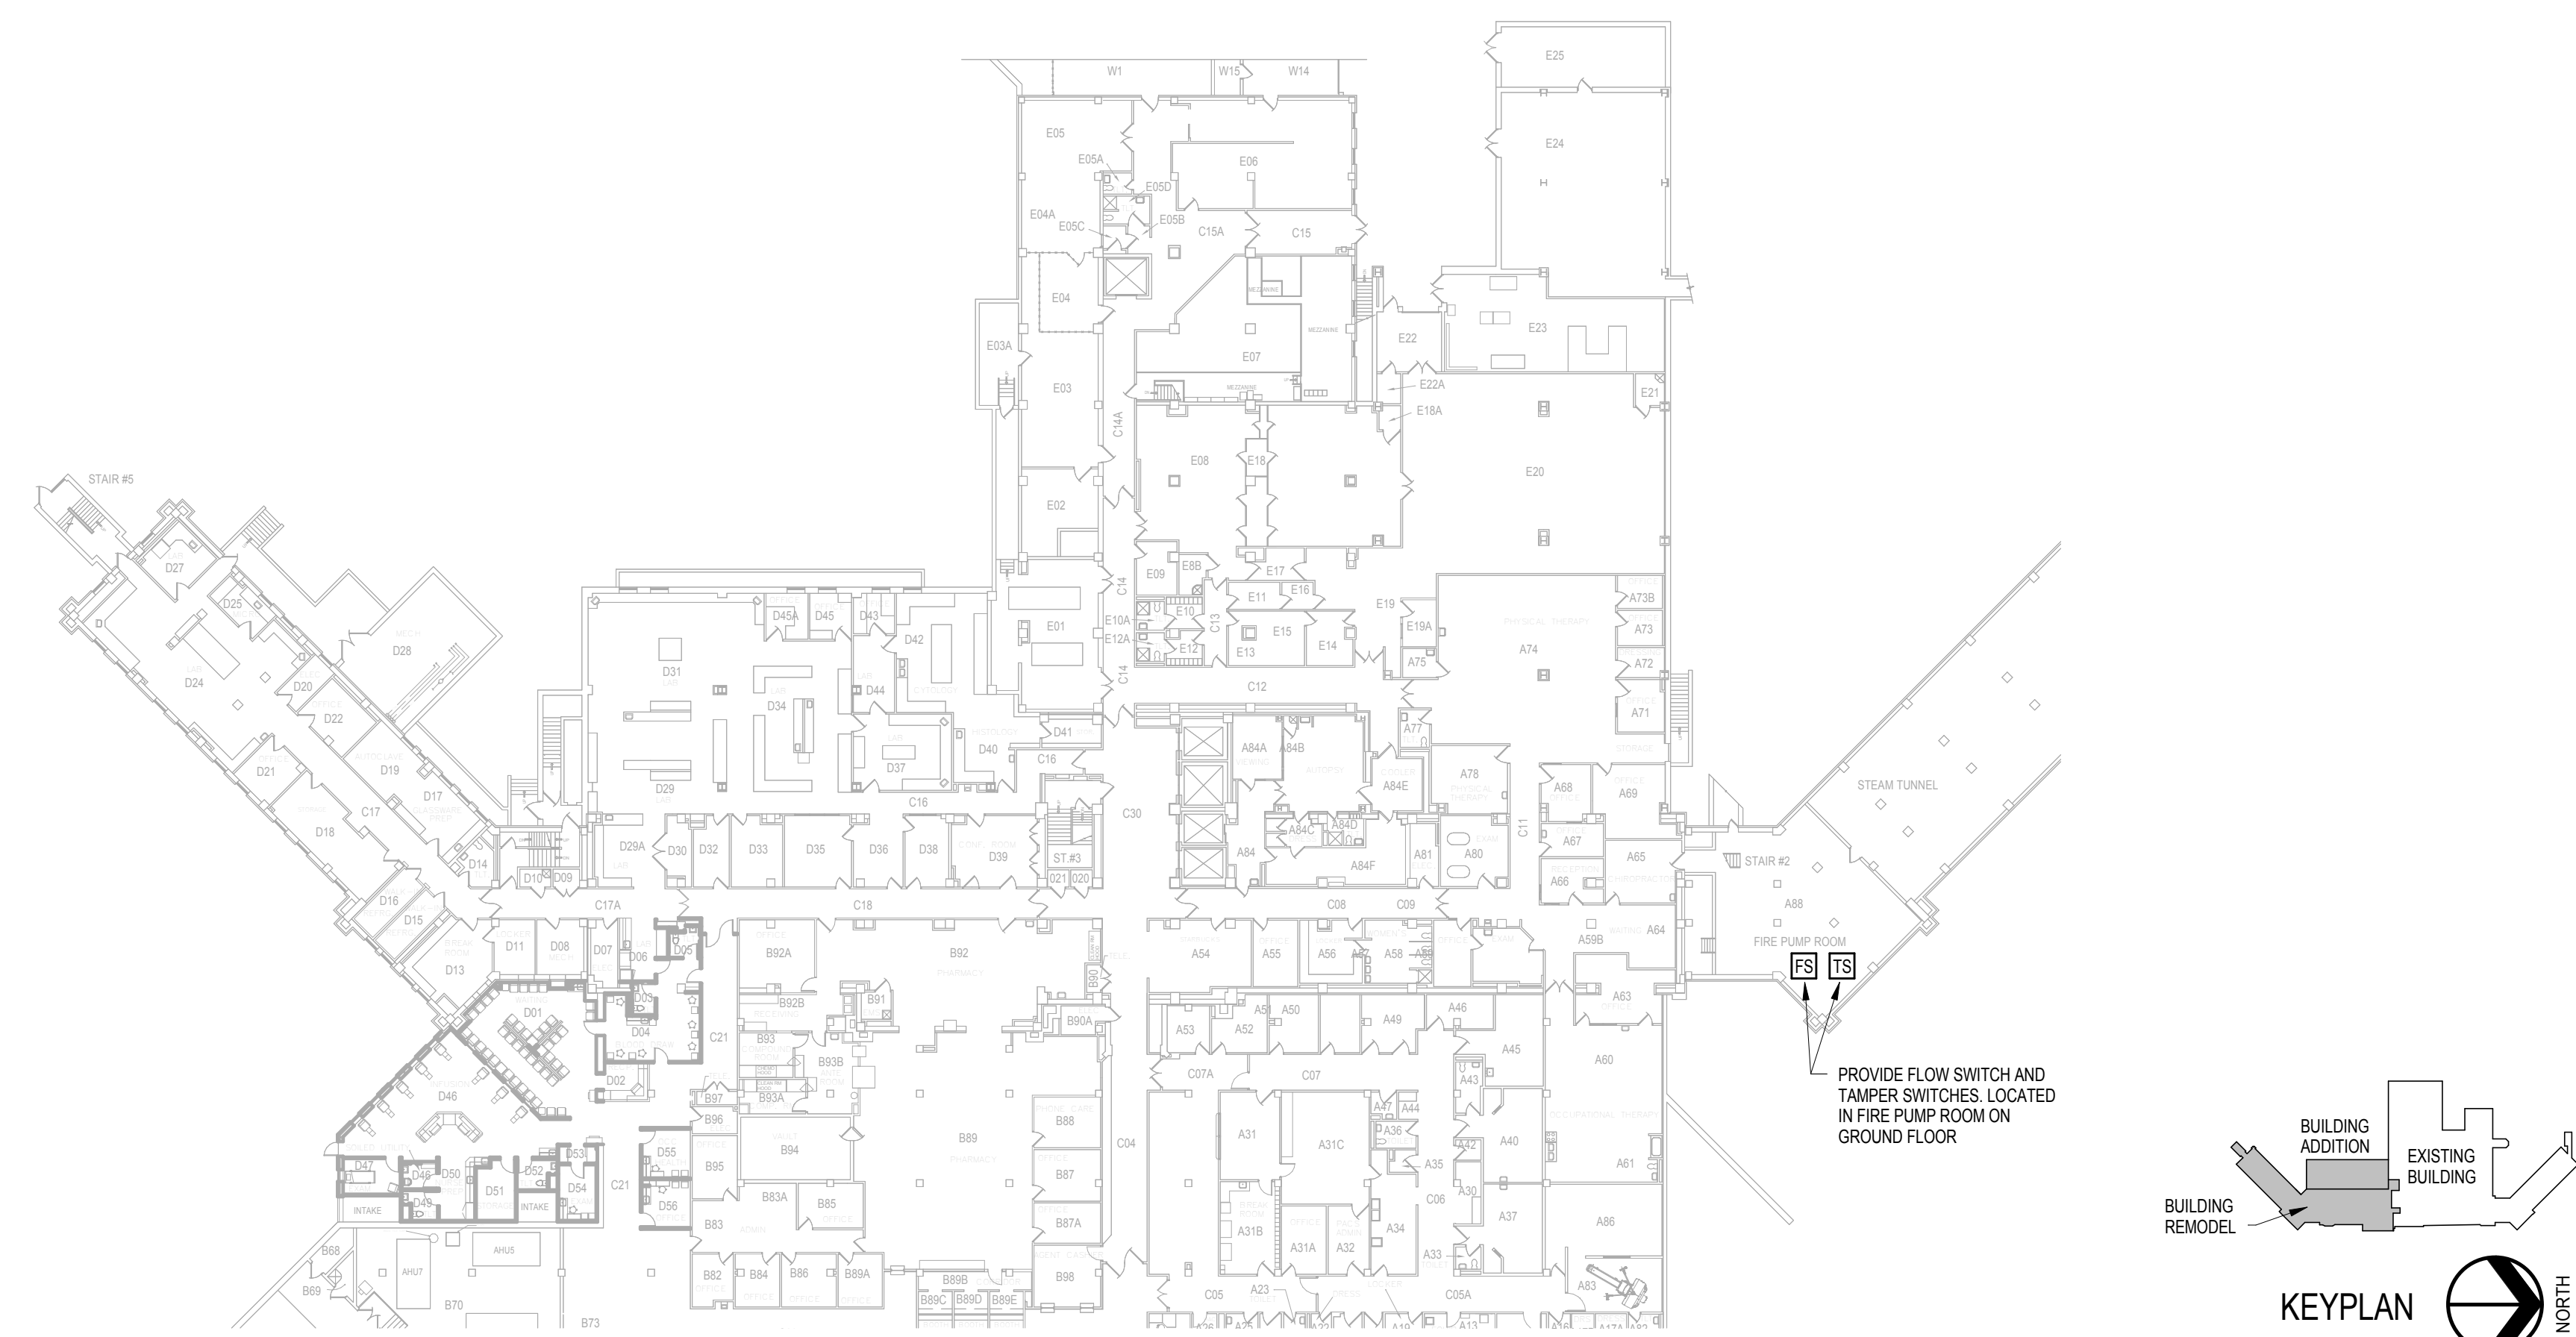
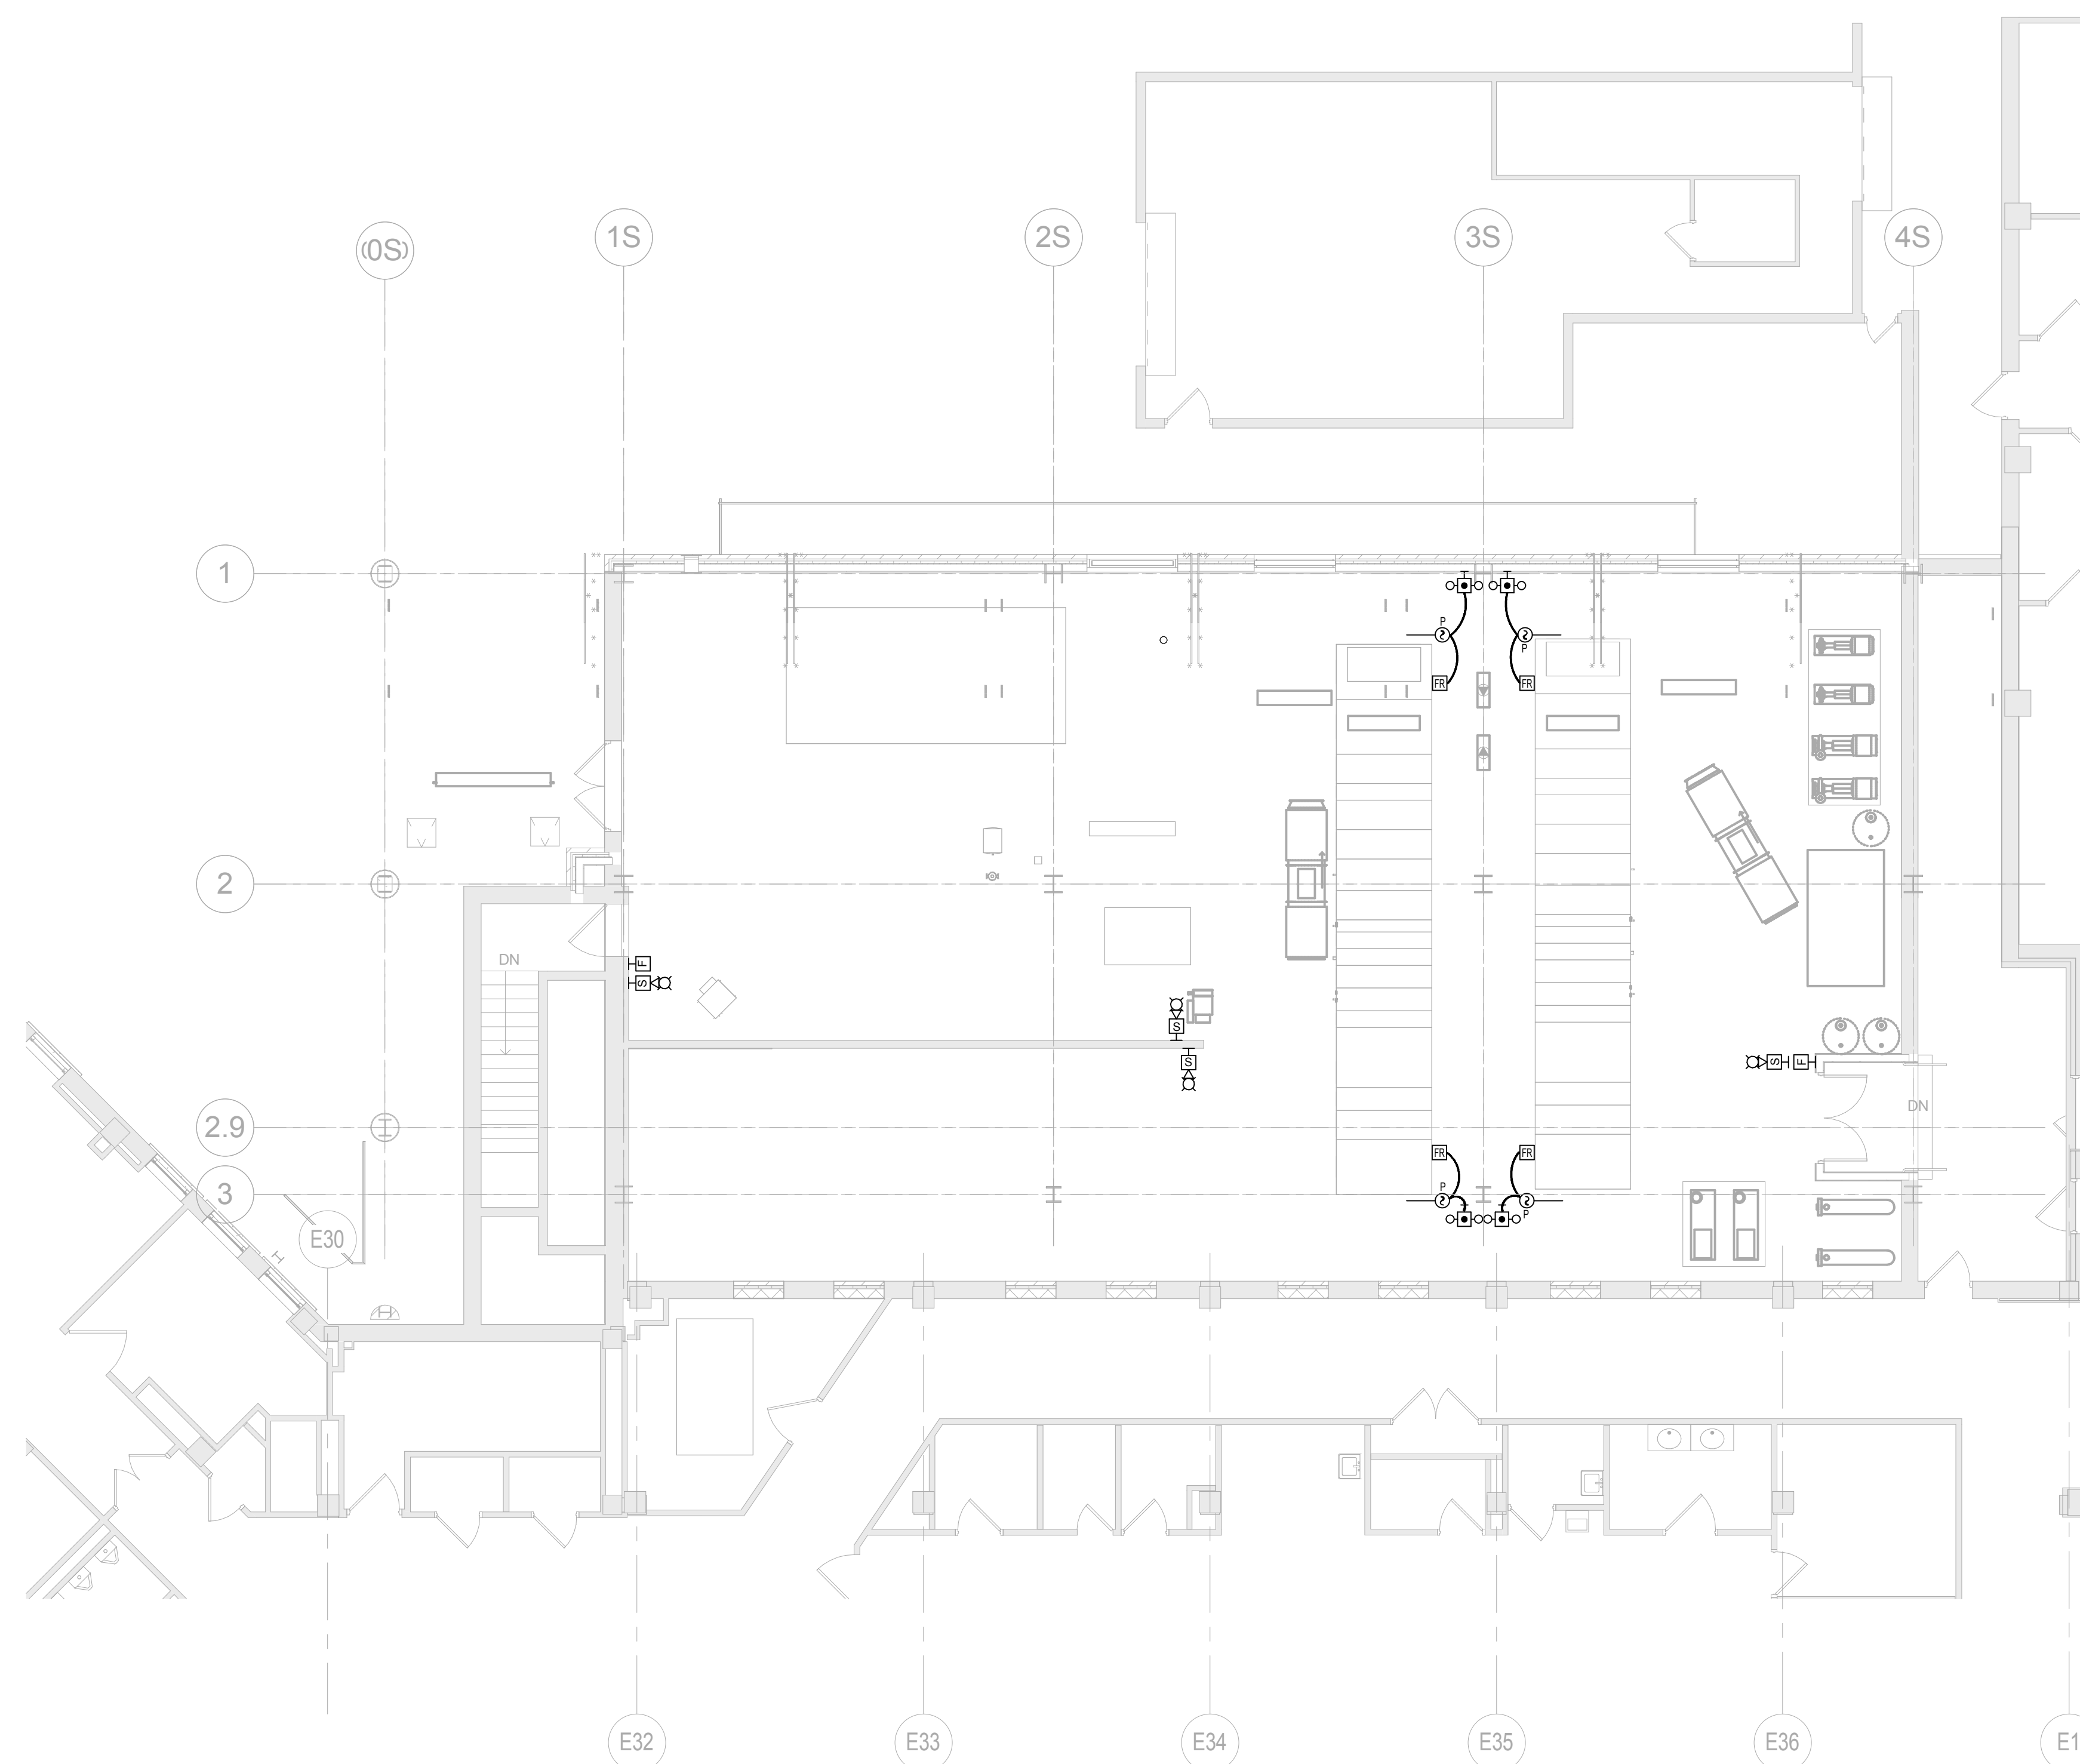


 

 
 

 

 
 
 

 

 
 
 

 
5C FIRE ALARM RISER DIAGRAM



6F **GROUND FLOOR FIRE DETECTION & ALARM PLAN**
1/32" = 1'-0"



1F 1ST FLOOR FIRE DETECTION & ALARM PLAN
1/8" = 1'-0"

	<table><tr><td colspan="3">CONSULTANTS:</td></tr><tr><td colspan="3"></td></tr></table>	CONSULTANTS:						<table><tr><td colspan="3"><table><tr><td colspan="3"></td></tr><tr><td colspan="3">ARCHITECTS/ ENGINEERS:</td></tr><tr><td colspan="3"><div>TSP, Inc. 1112 N. West Ave, Sioux Falls, SD 57104 phone: (605) 336-1160 fax: (605) 336-7926 www.teamtsp.com</div><div> To Solve. To Excel. Together.</div></td></tr></table></td><td><table><tr><td colspan="2">Drawing Title 1ST FLOOR FIRE DETECTION & ALARM PLAN</td><td>Drawing Number 04100857</td></tr><tr><td colspan="2">Approved: Project Director</td><td>Project Title Sioux Falls VA Health Care System Acute Inpatient Medical Unit Addition and Renovation</td></tr><tr><td colspan="2">Location VA Medical Center 2891 W. 32nd Street, PO Box 5046 Sioux Falls, SD 57117-5046</td><td>Building Number 5</td></tr><tr><td>Date 08/06/2012</td><td>Checked MJJ</td><td>Drawn KAK</td></tr></table></td><td><table><tr><td colspan="2">Project Number 04100857</td><td rowspan="2">Office of Construction and Facilities Management</td></tr><tr><td colspan="2">Building Number 5</td></tr><tr><td colspan="2">Drawing Number 5-FA101 Dwg. 115 of 123</td><td rowspan="2"> Department of Veterans Affairs</td></tr><tr><td colspan="2"></td></tr></table></td></tr><tr><td><table><tr><td>MARK</td><td>REVISION DESCRIPTION</td><td>DATE</td></tr><tr><td></td><td></td><td></td></tr></table></td><td></td><td></td><td></td><td></td></tr></table>	<table><tr><td colspan="3"></td></tr><tr><td colspan="3">ARCHITECTS/ ENGINEERS:</td></tr><tr><td colspan="3"><div>TSP, Inc. 1112 N. West Ave, Sioux Falls, SD 57104 phone: (605) 336-1160 fax: (605) 336-7926 www.teamtsp.com</div><div> To Solve. To Excel. Together.</div></td></tr></table>						ARCHITECTS/ ENGINEERS:			<div>TSP, Inc. 1112 N. West Ave, Sioux Falls, SD 57104 phone: (605) 336-1160 fax: (605) 336-7926 www.teamtsp.com</div> <div> To Solve. To Excel. Together.</div>			<table><tr><td colspan="2">Drawing Title 1ST FLOOR FIRE DETECTION & ALARM PLAN</td><td>Drawing Number 04100857</td></tr><tr><td colspan="2">Approved: Project Director</td><td>Project Title Sioux Falls VA Health Care System Acute Inpatient Medical Unit Addition and Renovation</td></tr><tr><td colspan="2">Location VA Medical Center 2891 W. 32nd Street, PO Box 5046 Sioux Falls, SD 57117-5046</td><td>Building Number 5</td></tr><tr><td>Date 08/06/2012</td><td>Checked MJJ</td><td>Drawn KAK</td></tr></table>	Drawing Title 1ST FLOOR FIRE DETECTION & ALARM PLAN		Drawing Number 04100857	Approved: Project Director		Project Title Sioux Falls VA Health Care System Acute Inpatient Medical Unit Addition and Renovation	Location VA Medical Center 2891 W. 32nd Street, PO Box 5046 Sioux Falls, SD 57117-5046		Building Number 5	Date 08/06/2012	Checked MJJ	Drawn KAK	<table><tr><td colspan="2">Project Number 04100857</td><td rowspan="2">Office of Construction and Facilities Management</td></tr><tr><td colspan="2">Building Number 5</td></tr><tr><td colspan="2">Drawing Number 5-FA101 Dwg. 115 of 123</td><td rowspan="2"> Department of Veterans Affairs</td></tr><tr><td colspan="2"></td></tr></table>	Project Number 04100857		Office of Construction and Facilities Management	Building Number 5		Drawing Number 5-FA101 Dwg. 115 of 123		 Department of Veterans Affairs			<table><tr><td>MARK</td><td>REVISION DESCRIPTION</td><td>DATE</td></tr><tr><td></td><td></td><td></td></tr></table>	MARK	REVISION DESCRIPTION	DATE							
CONSULTANTS:																																																							
<table><tr><td colspan="3"></td></tr><tr><td colspan="3">ARCHITECTS/ ENGINEERS:</td></tr><tr><td colspan="3"><div>TSP, Inc. 1112 N. West Ave, Sioux Falls, SD 57104 phone: (605) 336-1160 fax: (605) 336-7926 www.teamtsp.com</div><div> To Solve. To Excel. Together.</div></td></tr></table>						ARCHITECTS/ ENGINEERS:			<div>TSP, Inc. 1112 N. West Ave, Sioux Falls, SD 57104 phone: (605) 336-1160 fax: (605) 336-7926 www.teamtsp.com</div> <div> To Solve. To Excel. Together.</div>			<table><tr><td colspan="2">Drawing Title 1ST FLOOR FIRE DETECTION & ALARM PLAN</td><td>Drawing Number 04100857</td></tr><tr><td colspan="2">Approved: Project Director</td><td>Project Title Sioux Falls VA Health Care System Acute Inpatient Medical Unit Addition and Renovation</td></tr><tr><td colspan="2">Location VA Medical Center 2891 W. 32nd Street, PO Box 5046 Sioux Falls, SD 57117-5046</td><td>Building Number 5</td></tr><tr><td>Date 08/06/2012</td><td>Checked MJJ</td><td>Drawn KAK</td></tr></table>	Drawing Title 1ST FLOOR FIRE DETECTION & ALARM PLAN		Drawing Number 04100857	Approved: Project Director		Project Title Sioux Falls VA Health Care System Acute Inpatient Medical Unit Addition and Renovation	Location VA Medical Center 2891 W. 32nd Street, PO Box 5046 Sioux Falls, SD 57117-5046		Building Number 5	Date 08/06/2012	Checked MJJ	Drawn KAK	<table><tr><td colspan="2">Project Number 04100857</td><td rowspan="2">Office of Construction and Facilities Management</td></tr><tr><td colspan="2">Building Number 5</td></tr><tr><td colspan="2">Drawing Number 5-FA101 Dwg. 115 of 123</td><td rowspan="2"> Department of Veterans Affairs</td></tr><tr><td colspan="2"></td></tr></table>	Project Number 04100857		Office of Construction and Facilities Management	Building Number 5		Drawing Number 5-FA101 Dwg. 115 of 123		 Department of Veterans Affairs																						
																																																							
ARCHITECTS/ ENGINEERS:																																																							
<div>TSP, Inc. 1112 N. West Ave, Sioux Falls, SD 57104 phone: (605) 336-1160 fax: (605) 336-7926 www.teamtsp.com</div> <div> To Solve. To Excel. Together.</div>																																																							
Drawing Title 1ST FLOOR FIRE DETECTION & ALARM PLAN		Drawing Number 04100857																																																					
Approved: Project Director		Project Title Sioux Falls VA Health Care System Acute Inpatient Medical Unit Addition and Renovation																																																					
Location VA Medical Center 2891 W. 32nd Street, PO Box 5046 Sioux Falls, SD 57117-5046		Building Number 5																																																					
Date 08/06/2012	Checked MJJ	Drawn KAK																																																					
Project Number 04100857		Office of Construction and Facilities Management																																																					
Building Number 5																																																							
Drawing Number 5-FA101 Dwg. 115 of 123		 Department of Veterans Affairs																																																					
<table><tr><td>MARK</td><td>REVISION DESCRIPTION</td><td>DATE</td></tr><tr><td></td><td></td><td></td></tr></table>	MARK	REVISION DESCRIPTION	DATE																																																				
MARK	REVISION DESCRIPTION	DATE																																																					