


1F 2ND FLOOR FIRE SUPPRESSION PLAN
1/8" = 1'-0"

MARK	REVISION DESCRIPTION	DATE

CONSULTANTS:

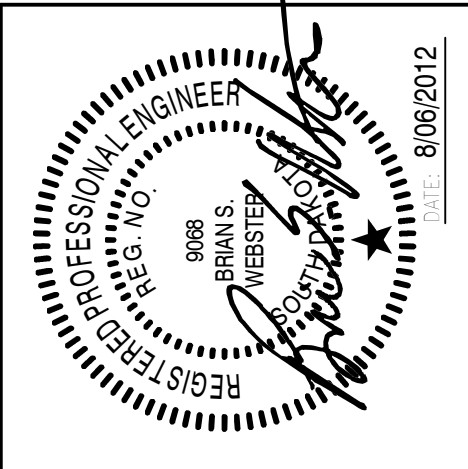

ARCHITECTS/ENGINEERS:



TSP Inc.
1112 N. West Ave.
Sioux Falls, SD 57104
phone: (605) 336-1160
fax: (605) 336-9295
www.tspinc.com
To Solve. To Excel. Together.

Drawing Title
2ND FLOOR FIRE SUPPRESSION PLAN

Project Title Sioux Falls VA Health Care System Acute Inpatient Medical Unit Addition and Renovation		Approved: Project Director	
Location 1112 N. West Ave. Sioux Falls, SD 57104	Drawing Number 5-FX102	Checked BSW	Drawn RAK
Date 08/06/2012	Dwg. 55 of 123		

Project Number 04100857	Building Number 5
Office of Construction and Facilities Management	
Department of Veterans Affairs	

100% CONSTRUCTION DOCUMENTS
FULLY SPRINKLERED

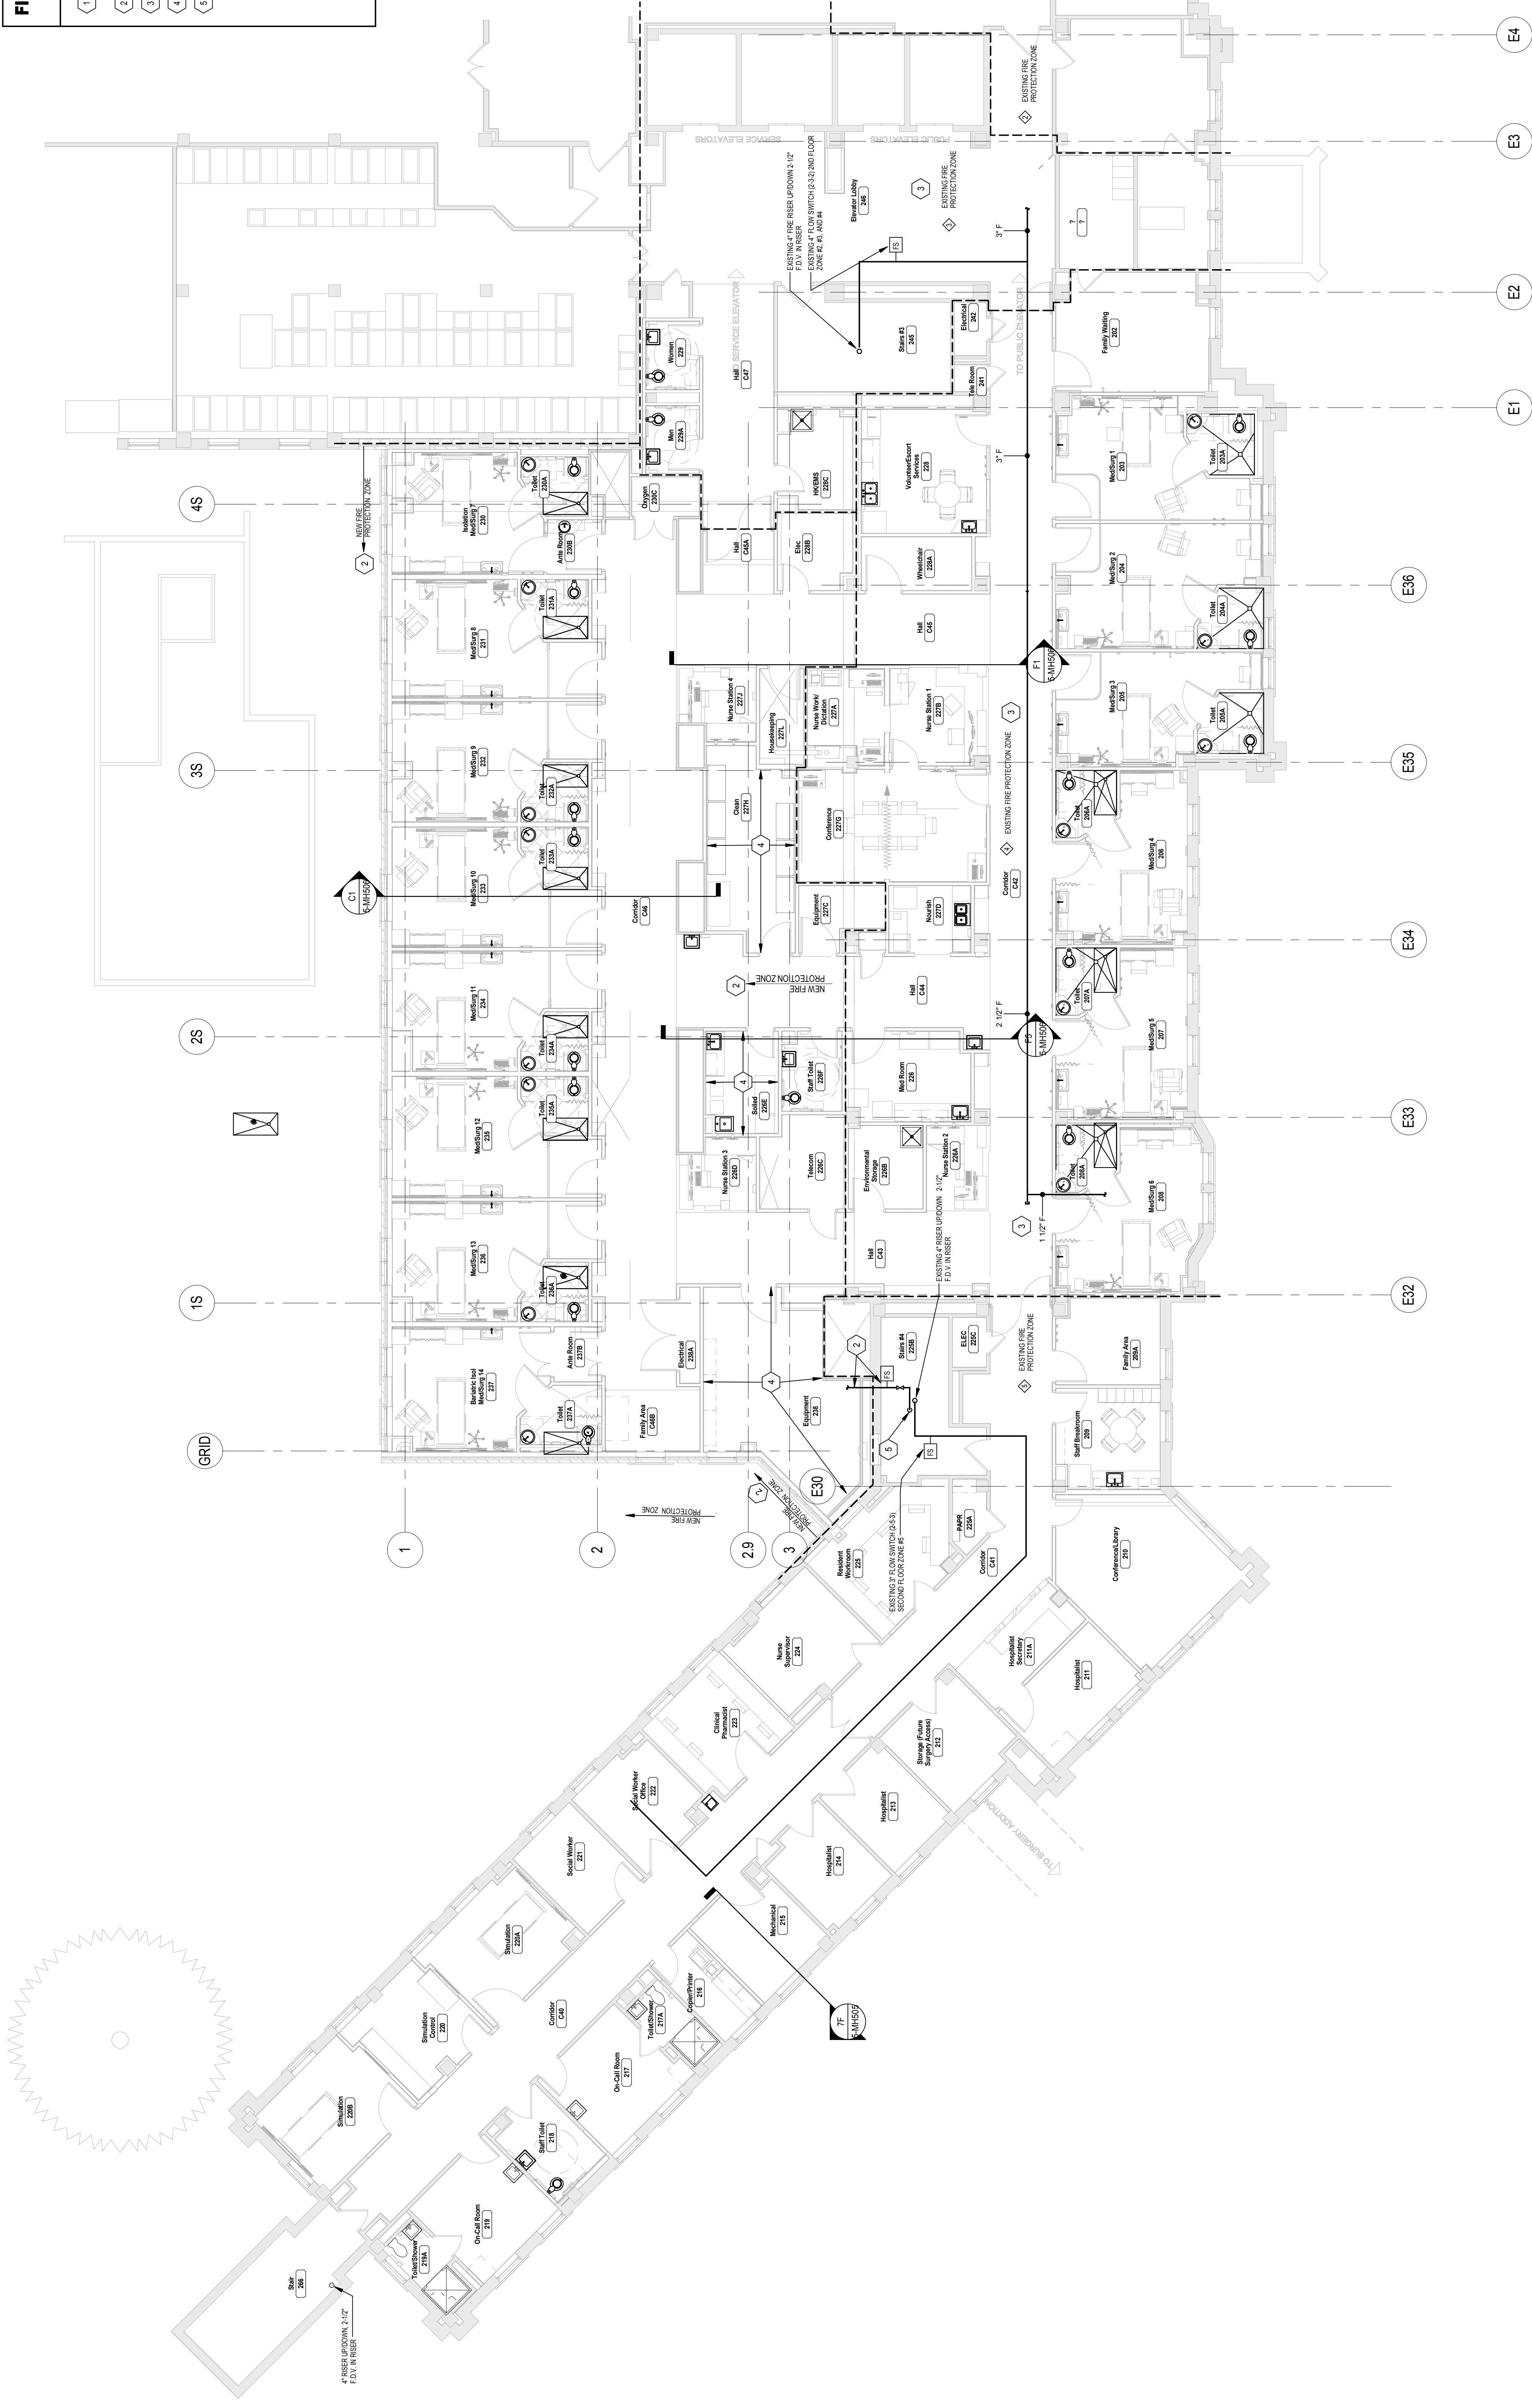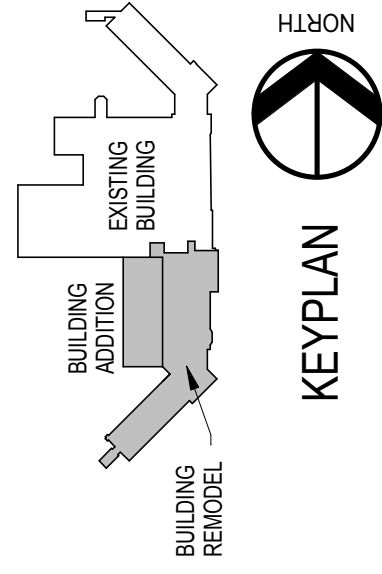

- FIRE SPRINKLER KEYNOTES**
- 1 REMOVE EXISTING FIRE SPRINKLER BACK TO MAINS. INSTALL NEW PIPING, FLOW SWITCH AND VALVES FOR EXPANDED FIRE PROTECTION ZONE. OCCUPY 4 HOURS TO PREVENT DISRUPTION TO THE MEDICAL CENTER.
 - 2 PROVIDE NEW FIRE PROTECTION SPRINKLER ZONE WITH PIPING, FLOW SWITCH AND VALVES.
 - 3 REMOVE AND REPLACE FIRE PROTECTION SPRINKLER SYSTEM IN REMODEL AREA TO PROVIDE NEW COVERAGE.
 - 4 ORDINARY HAZARD GROUP I AREA.
 - 5 NEW P.P. SPRINKLER PIPING TO NEW CONSTRUCTION AREA.
- NOTE: NOT ALL KEYNOTES MAY BE USED ON EACH PLAN.