

1 2 3 4 5 6 7 8 9

A

B

C

D

E

F


MECH DEMO GENERAL NOTES

- WHERE EQUIPMENT AND/OR FIXTURES ARE INDICATED TO BE REMOVED, THE EXISTING SERVICES SHALL BE CAPPED AND CONCEALED BEHIND FINISHED CEILING, WALLS, FLOORS, OR PARTITION WALLS. ALL DEMO WORK SHALL BE REMOVED BACK TO THE MAINS AND CAPPED, UNLESS OTHERWISE INDICATED.
- CAP ANY ABANDONED OR UNUSED PIPE AND/OR DUCT OPENINGS.
- THIS CONTRACTOR SHALL BE RESPONSIBLE FOR PATCHING AND PAINTING TO MATCH EXISTING FINISHES. ALL DEMO WORK SHALL BE THOROUGHLY CLEANED BEFORE PUTTING INTO PERMANENT SERVICES.
- WORKING AND SAFETY OF PERSONS SHALL BE PROTECTED AND THOROUGHLY CLEANED BEFORE PUTTING INTO PERMANENT SERVICES.

PIPING DEMO KEYNOTES


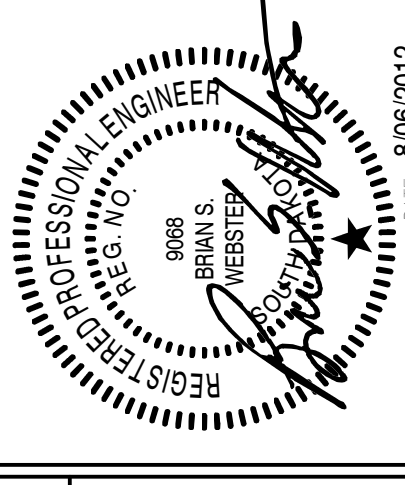
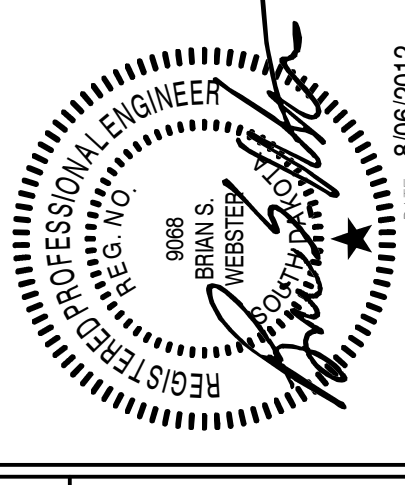
- DEMO ALL PLUMBING FIXTURES SHOWN IN DASHED LINES. REMOVE PIPING AND FITTINGS TO MAINS AND CAP. TYPICAL ALL.
- DEMO HYDRONIC PIPING SHOWN IN DASHED LINES BACK TO MAINS AND CAP. TYPICAL ALL.
- DEMO RADIANT CEILING PANELS, ASSOCIATED PIPING AND CONTROLS. REMOVE PIPING BACK TO MAINS AND CAP. TYPICAL ALL.
- DEMO RADIANT CEILING PANELS, ASSOCIATED PIPING AND CONTROLS. REMOVE PIPING BACK TO MAINS AND CAP. TYPICAL ALL.
- DEMO EXISTING CABINET UNIT HEATERS. REMOVE PIPING BACK TO MAINS AND CAP. TYPICAL ALL.
- EXISTING CABINET UNIT HEATER TO REMAIN.

NOTE: NOT ALL KEYNOTES MAY BE USED ON EACH PLAN

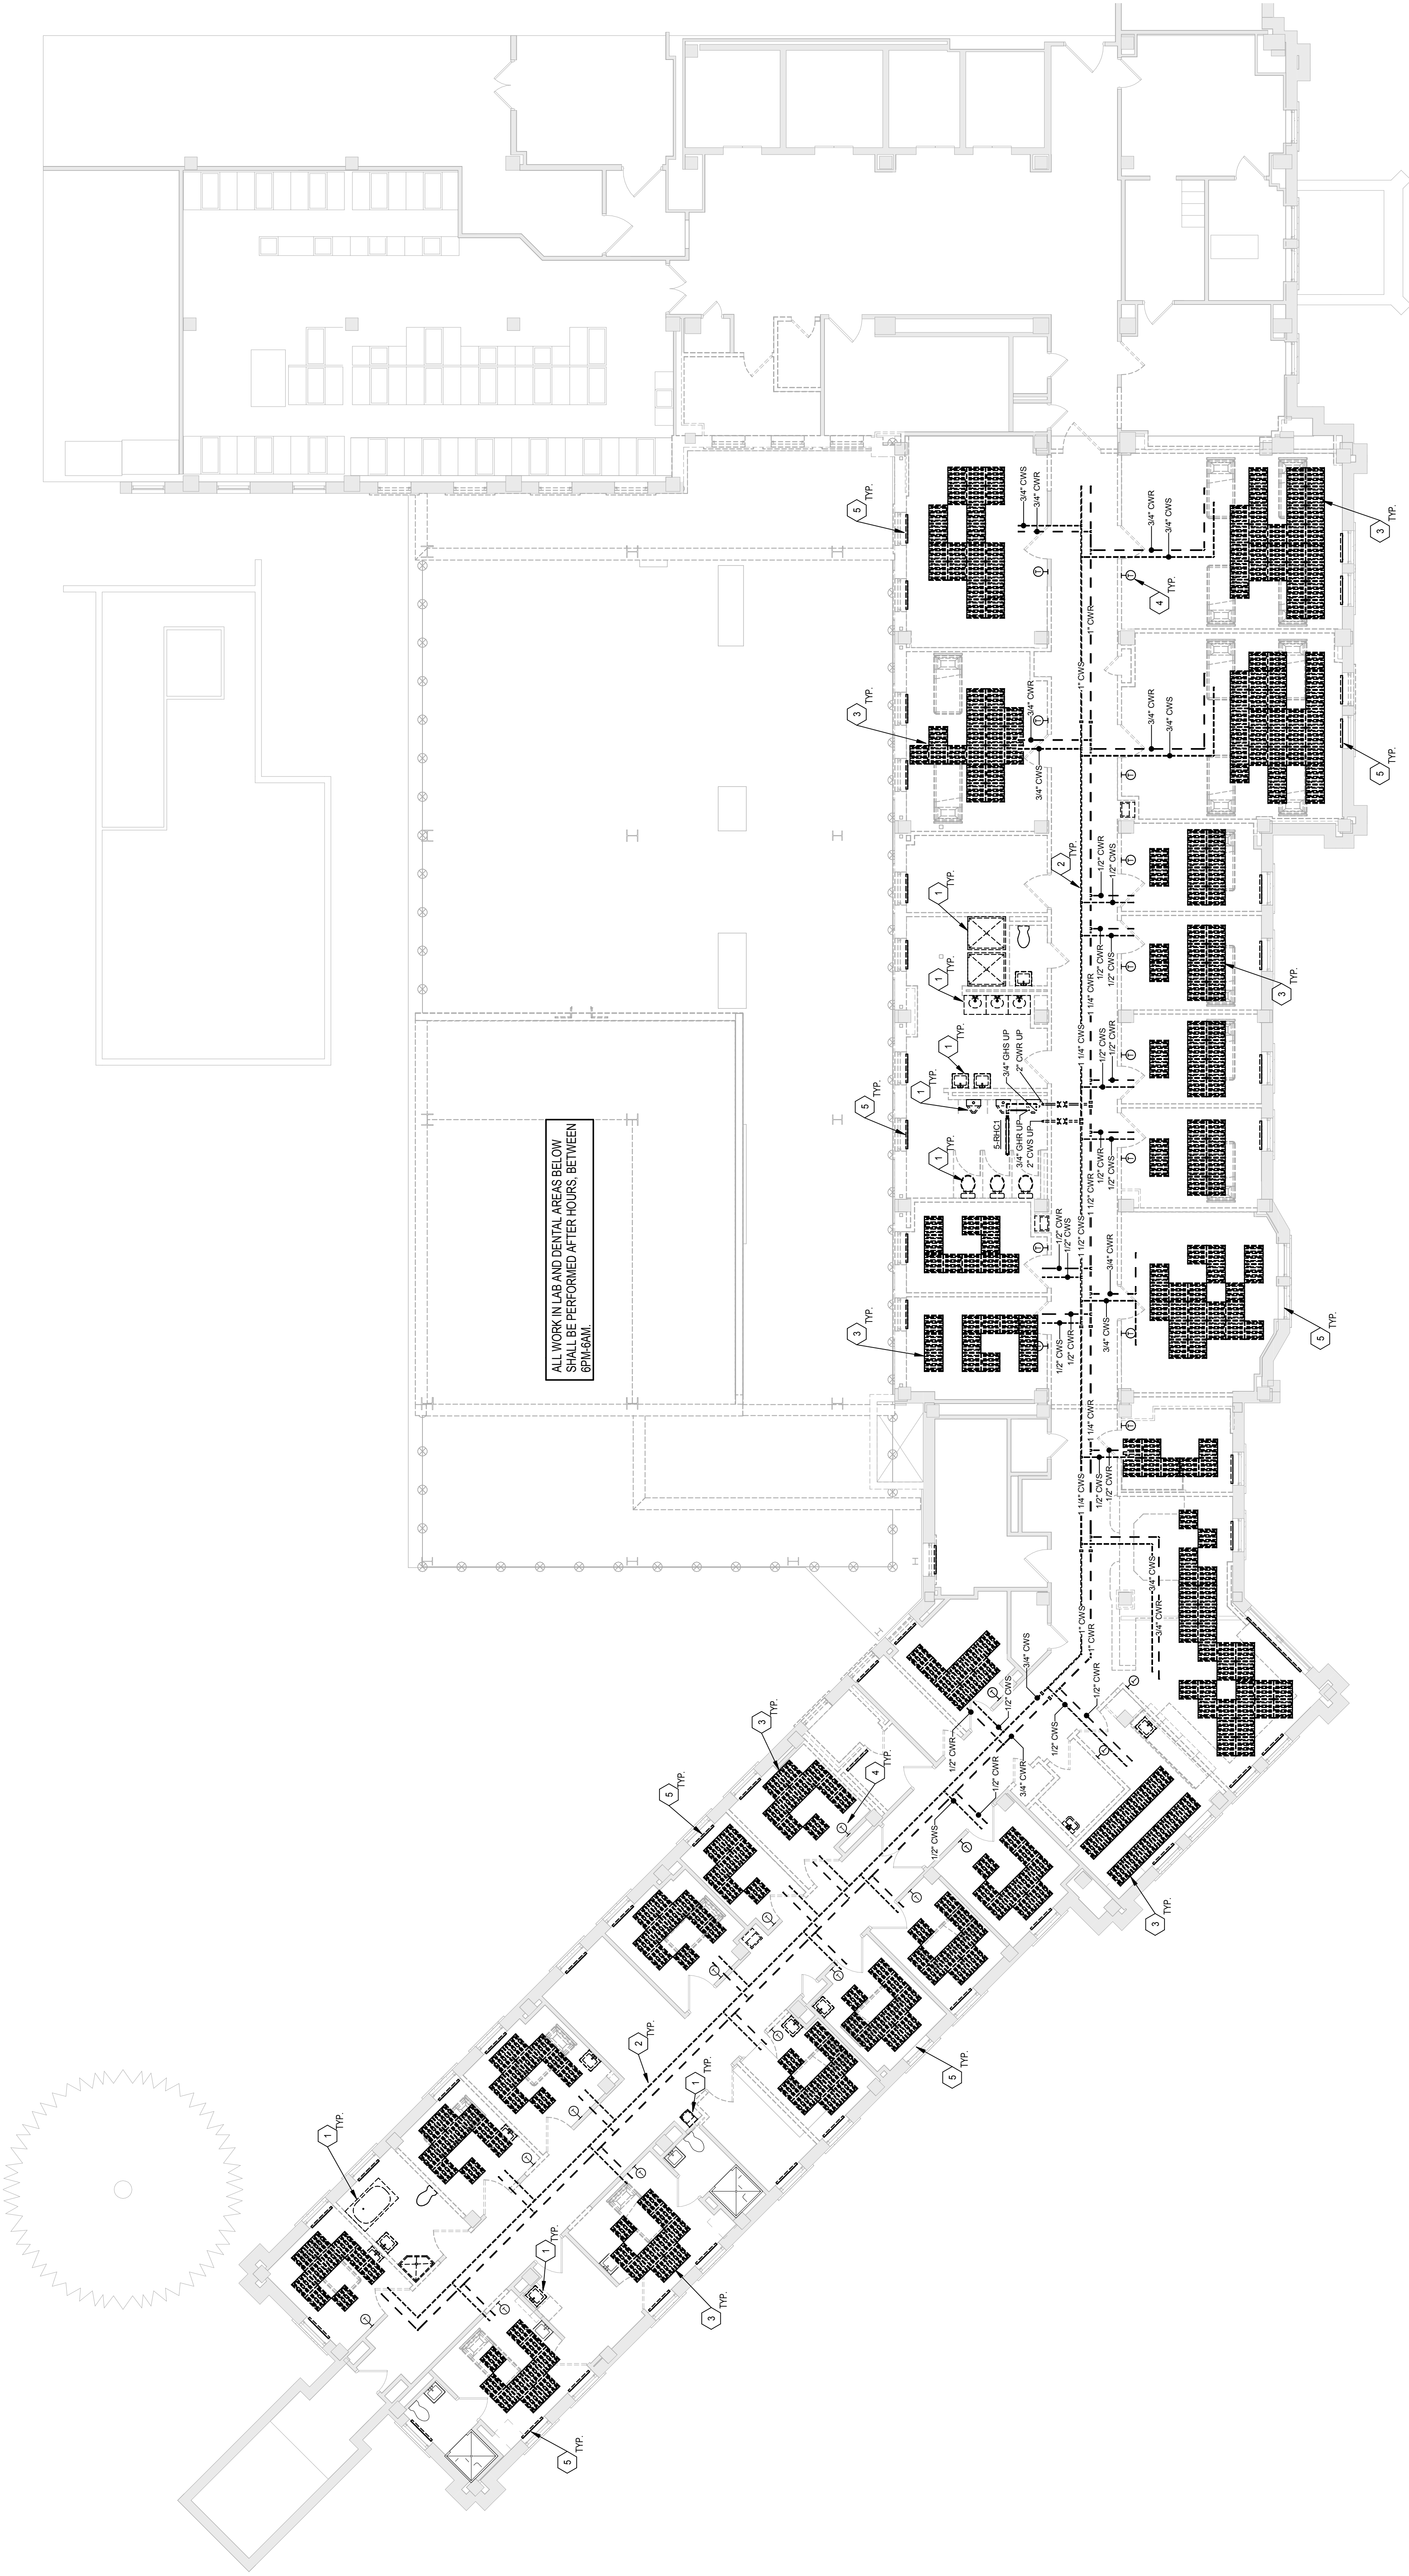

1F 2ND FLOOR PIPING DEMOLITION PLAN
10'-0" = 1'-0"

FULLY SPRINKLERED
100% CONSTRUCTION DOCUMENTS

CONSULTANTS:	ARCHITECTS/ENGINEERS:		Project Title		Project Number		Office of	
	 TSP Inc. 1112 N. West Ave. Sioux Falls, SD 57104 phone: (605) 336-1160 fax: (605) 336-7926 www.tspinc.com To Solve. To Excel. Together.		Sioux Falls VA Health Care System Acute Inpatient Medical Unit Addition and Renovation		04-100987		Construction	
			2ND FLOOR PIPING DEMOLITION PLAN		Building Number 5		and Facilities	
		Location		Drawing Number		Department of		
		200 W. 2nd Street, PO Box 946 Sioux Falls, SD 57117-5406		5-MD102		Veterans Affairs		
		Date		Checked		Drawn		
		08/06/2012		BSW		JTC		

