
















**A1 DIALYSIS PIPING DIAGRAM**
1/16" = 1'-0"**B2 INTEGRAL CASEWORK SINKS**
SCALE: NONE**B3 STAFF TOILET ROOMS**
SCALE: NONE**B6 PATIENT TOILET ROOM**
SCALE: NONE**B8 PATIENT TOILET ROOM**
SCALE: NONE**B9 PATIENT TOILET ROOM**
SCALE: NONE**D2 INTEGRAL CASEWORK SINKS**
SCALE: NONE**D3 PUBLIC TOILET ROOMS**
SCALE: NONE**D6 PATIENT TOILET ROOM**
SCALE: NONE**D8 PATIENT TOILET ROOM**
SCALE: NONE**D9 PATIENT TOILET ROOM**
SCALE: NONE**F2 STACKED MOP SINKS**
SCALE: NONE**F3 TYPICAL MOP SINK**
SCALE: NONE**F4 TYPICAL SINGLE SINK**
SCALE: NONE**F6 TYPICAL STACKED SINKS**
SCALE: NONE**F8 TYPICAL PATIENT TOILET ROOM**
SCALE: NONE**F9 TYPICAL PATIENT TOILET ROOM**
SCALE: NONE**CONSULTANTS:****ARCHITECTS/ ENGINEERS:**

TSP, Inc.
1112 N. West Ave.
Sioux Falls, SD 57104
phone: (605) 336-1160
fax: (605) 336-7926
www.teamtsp.com

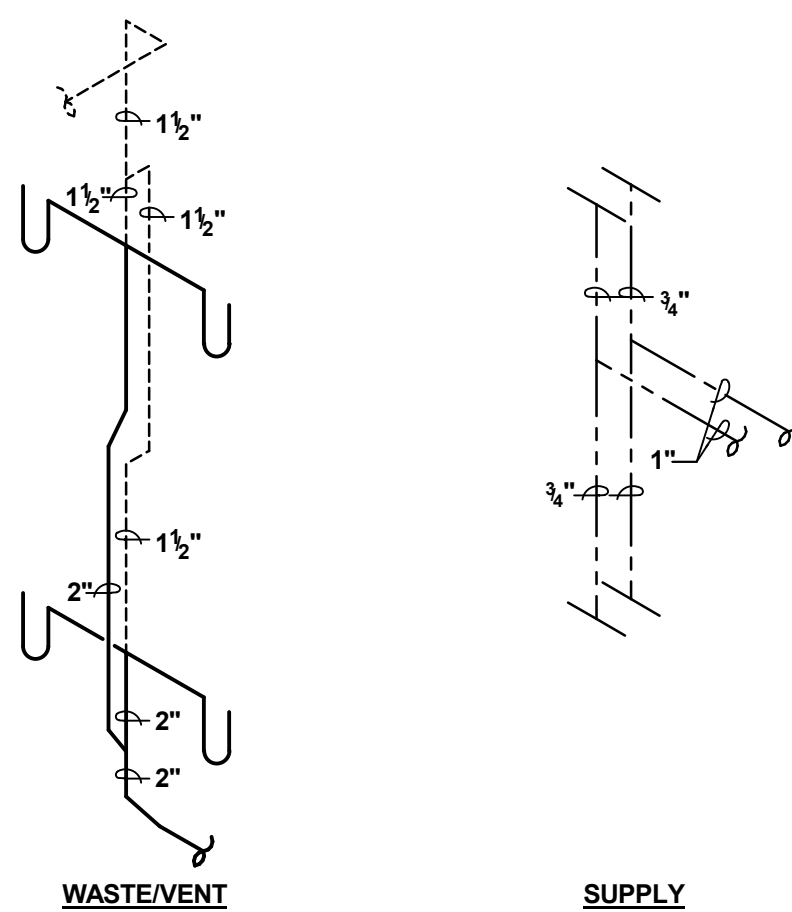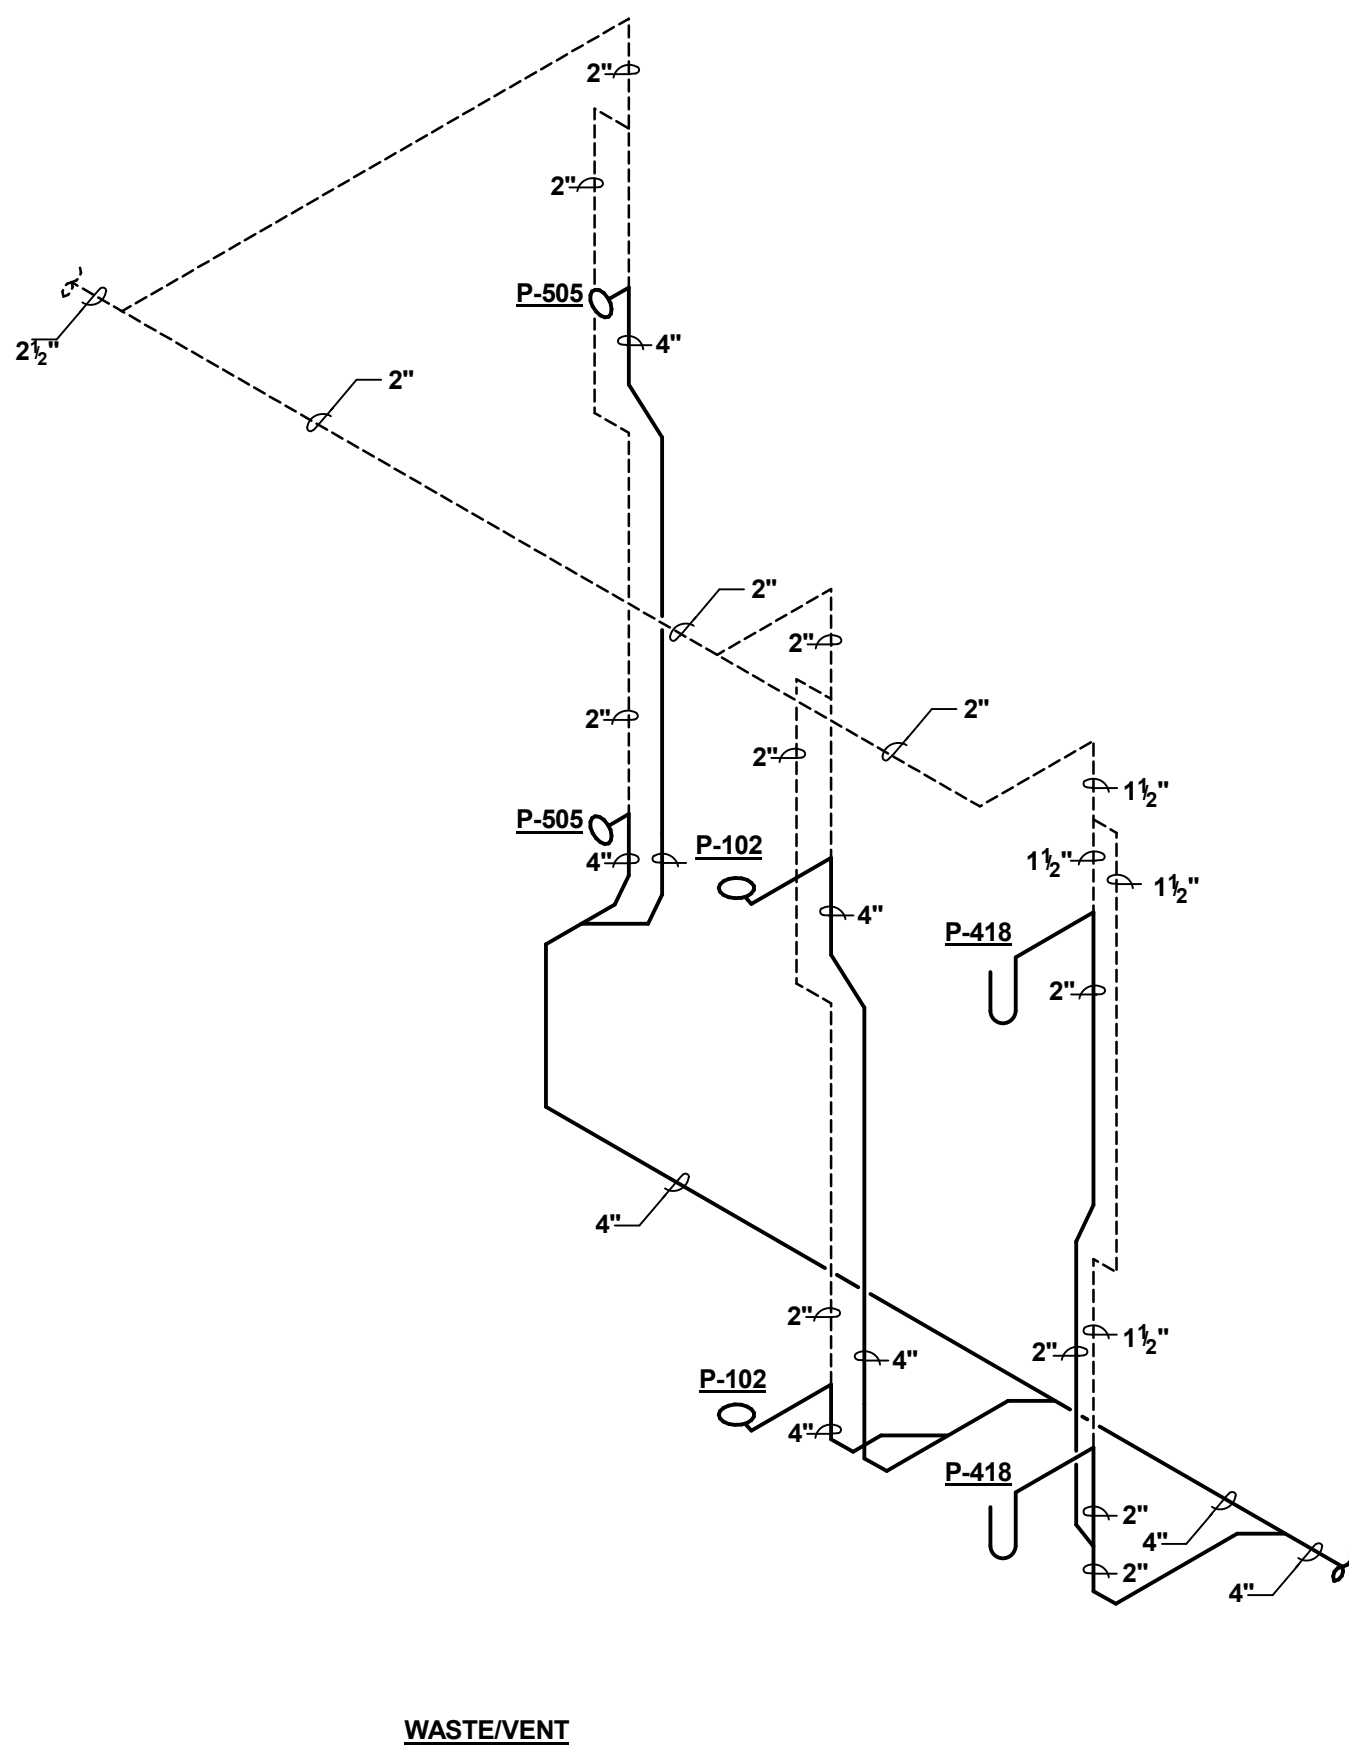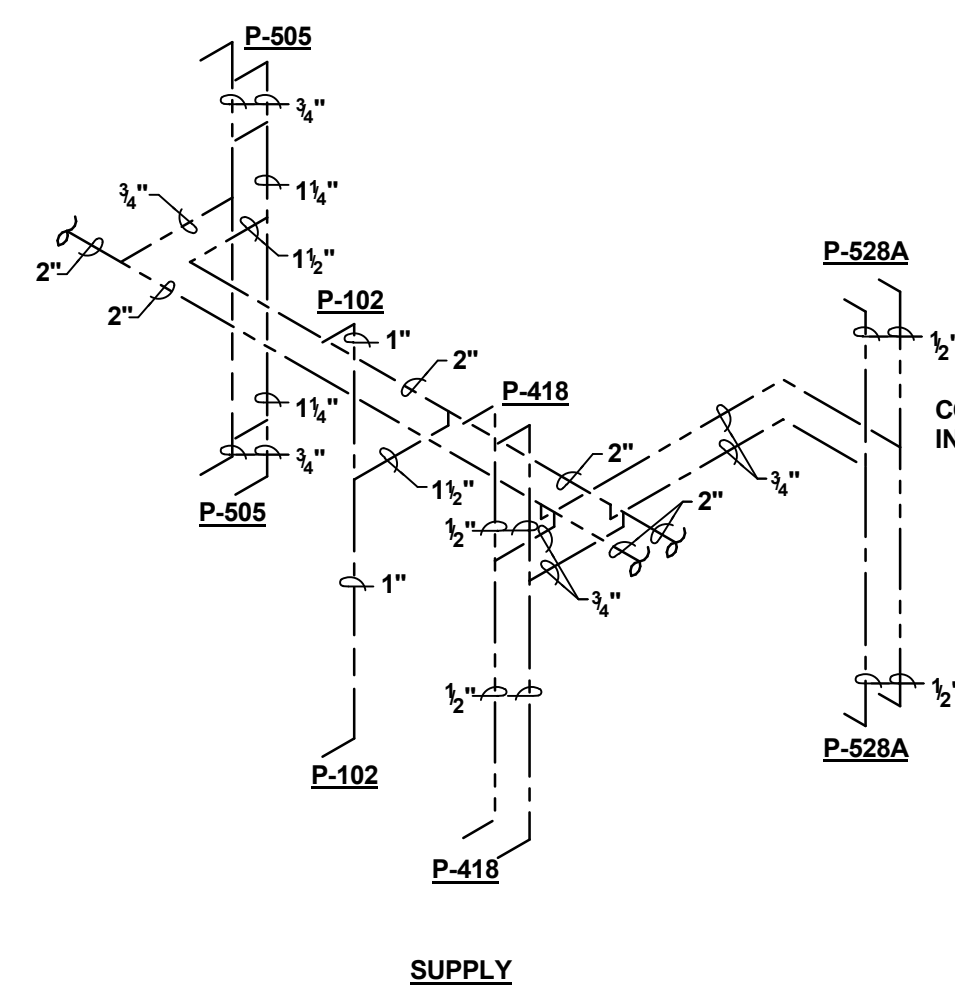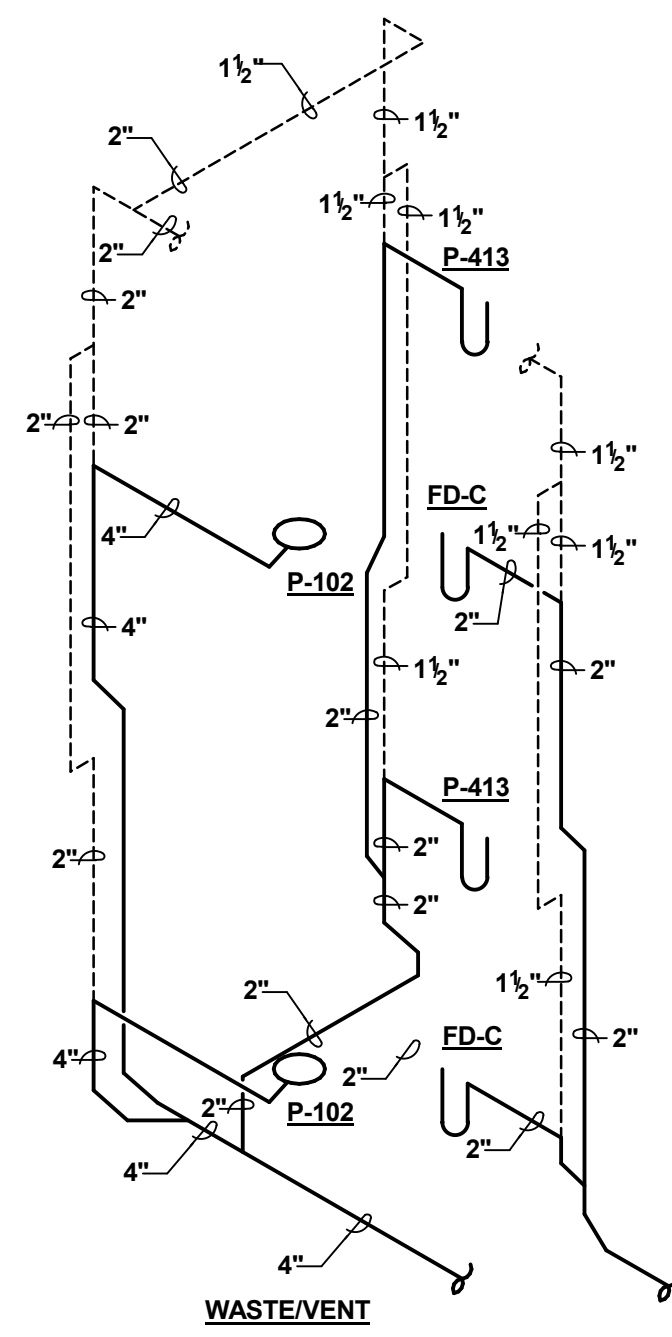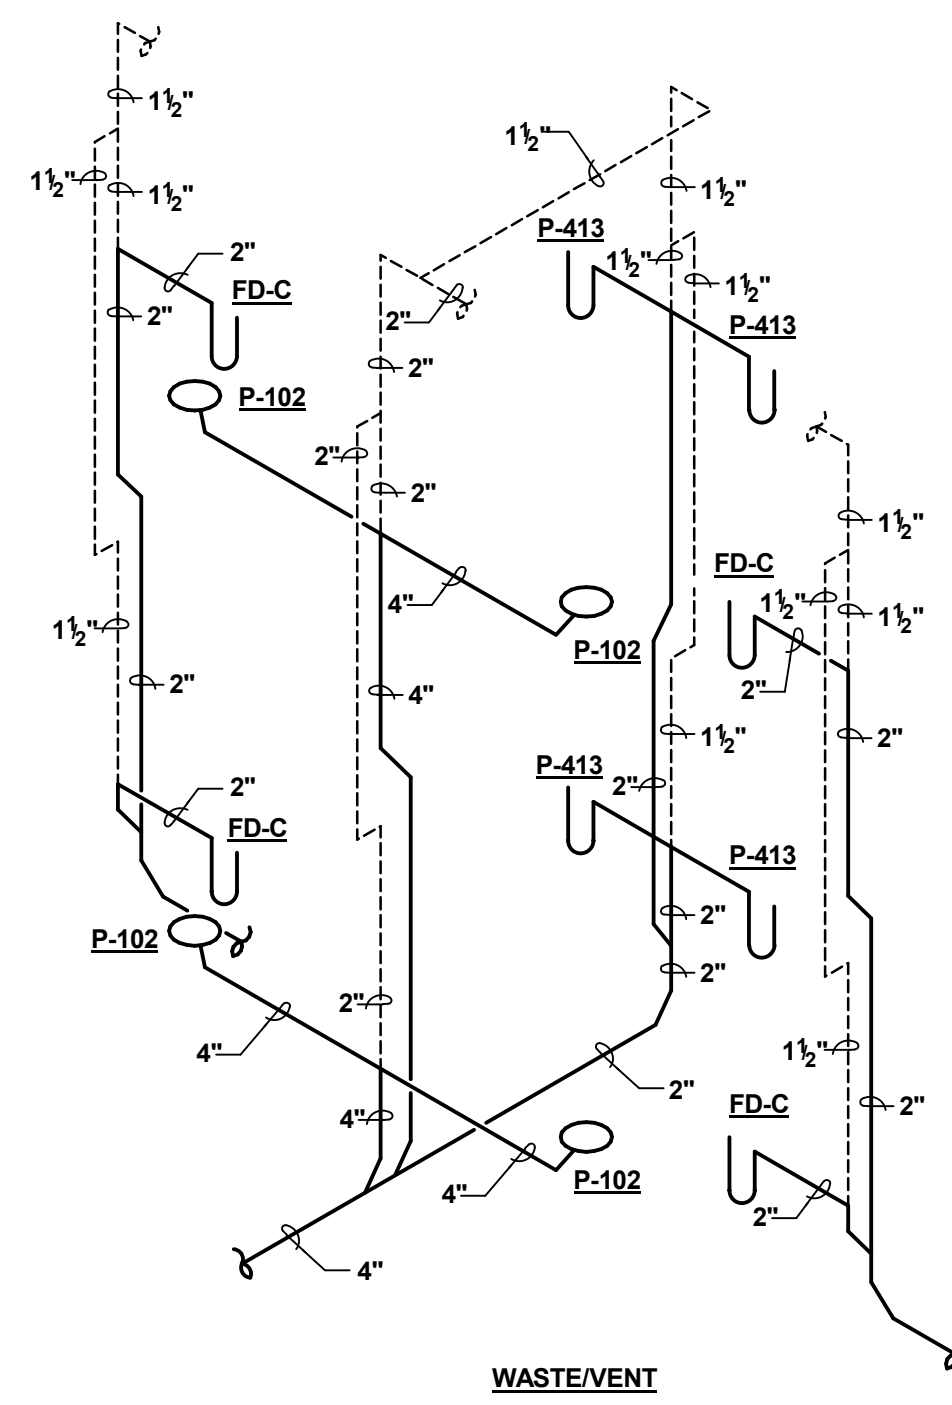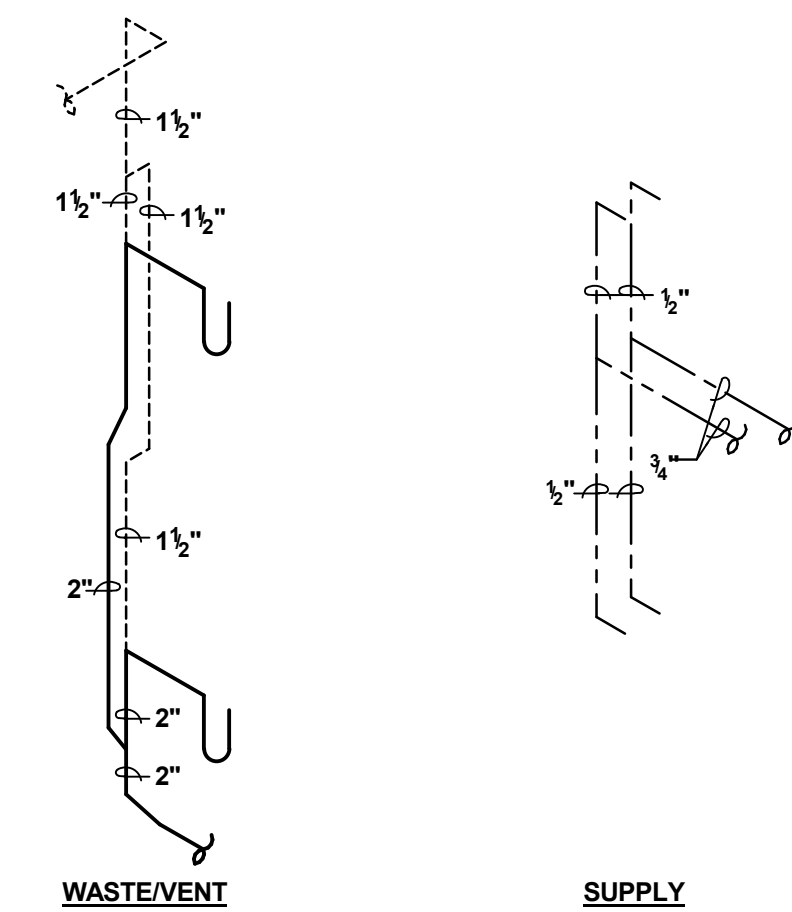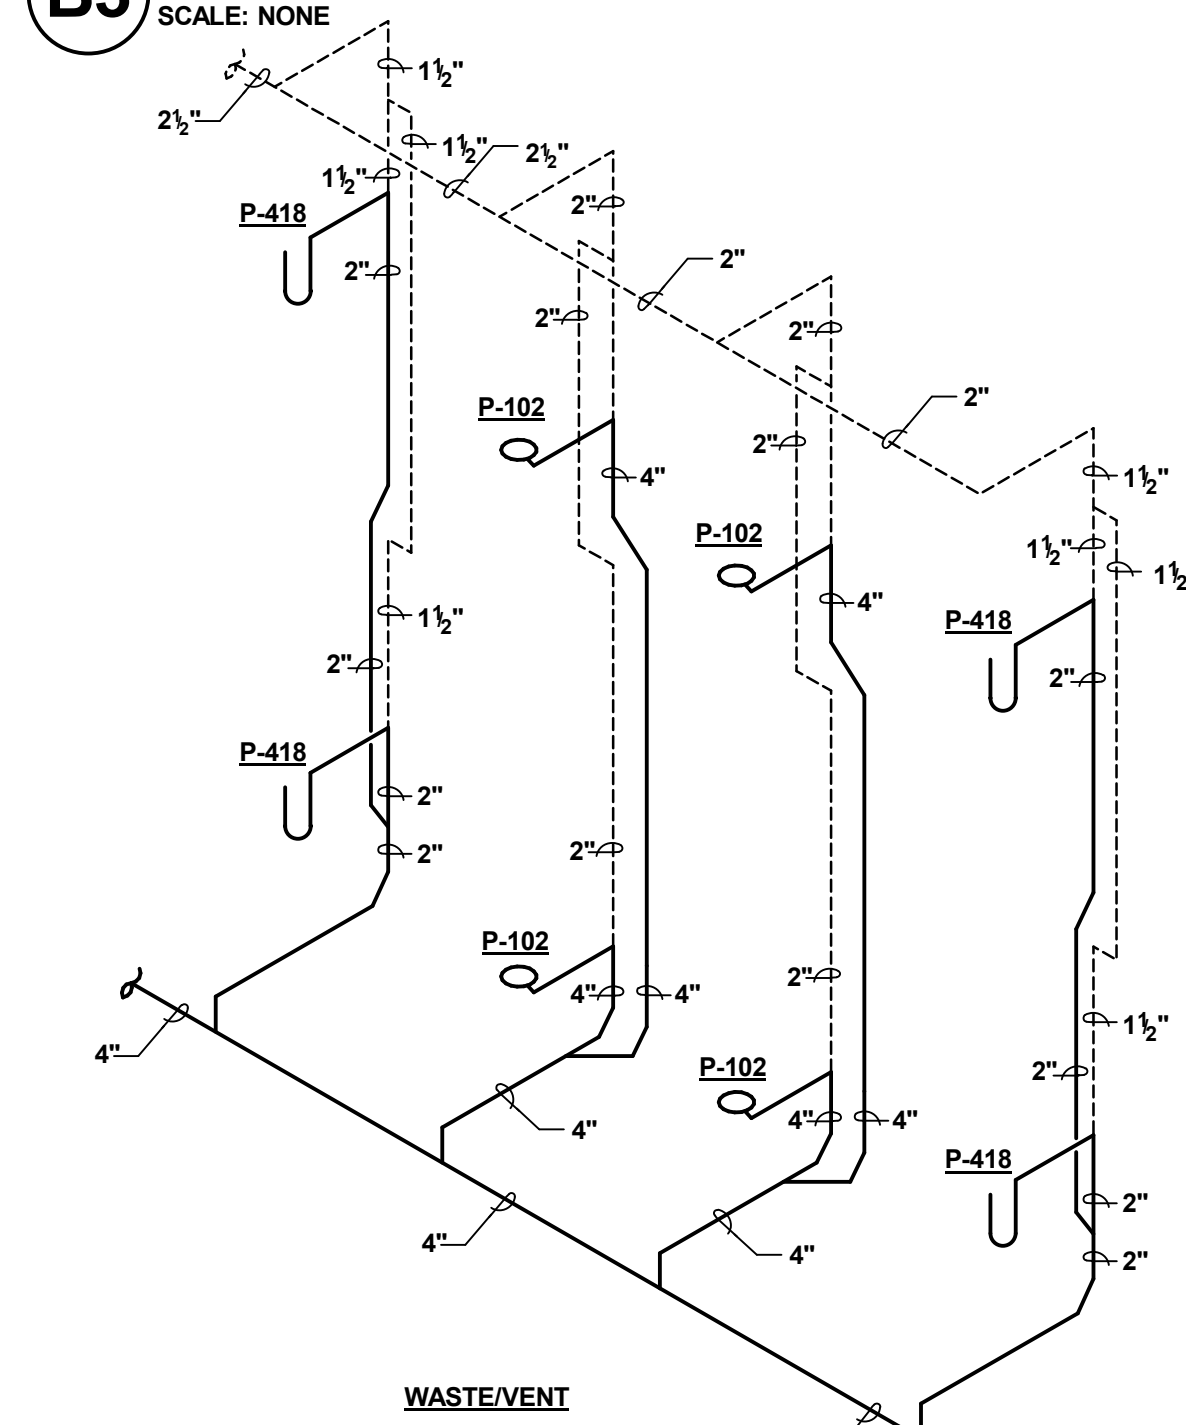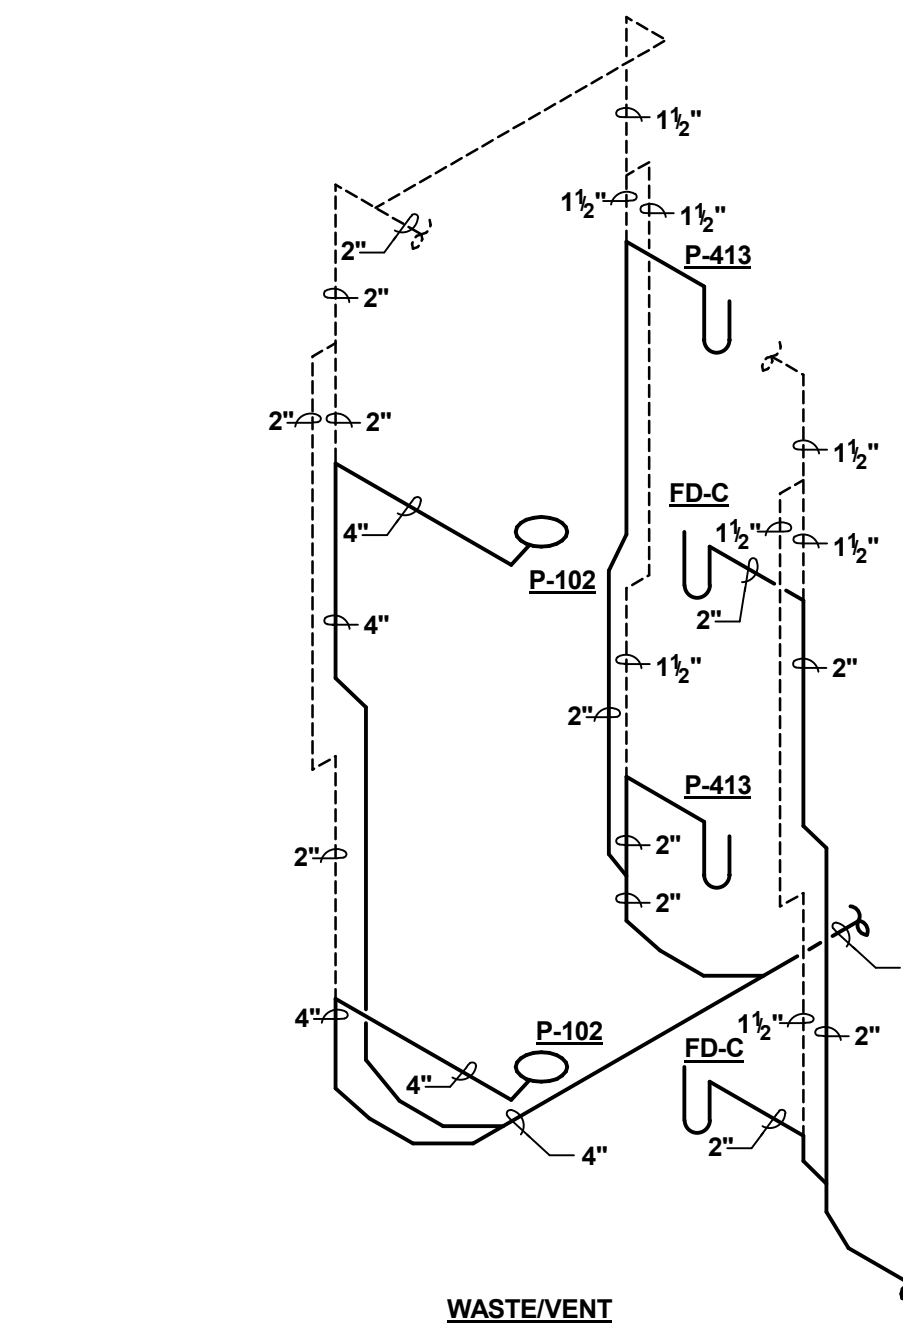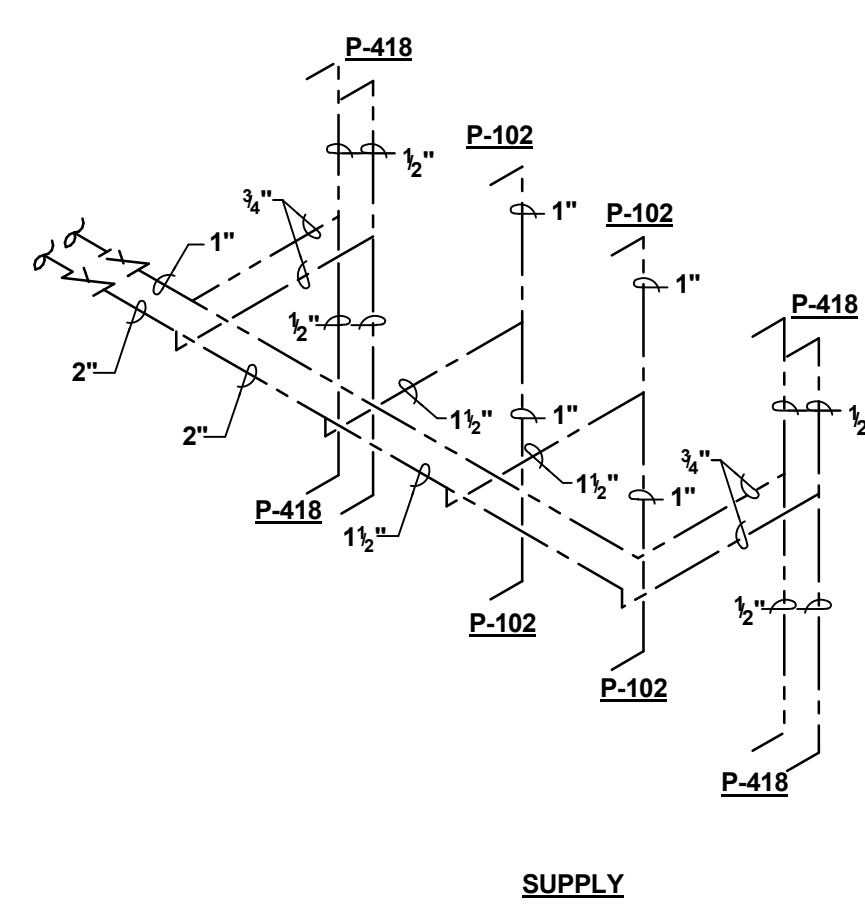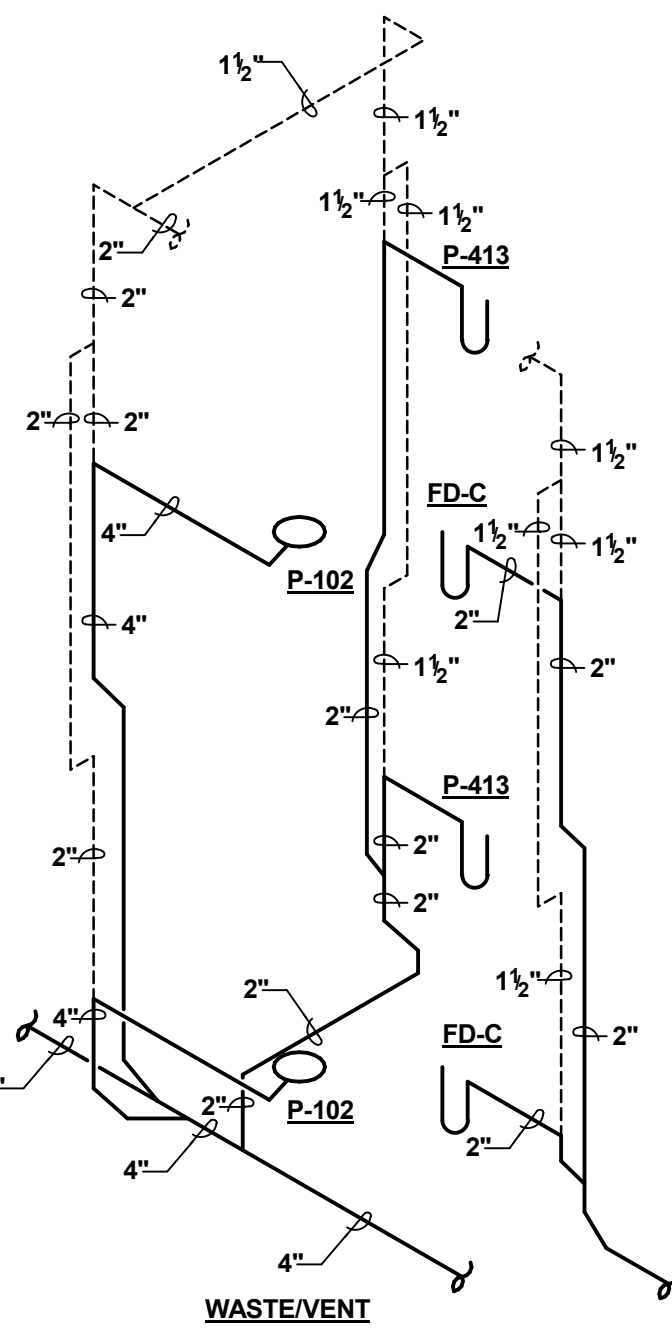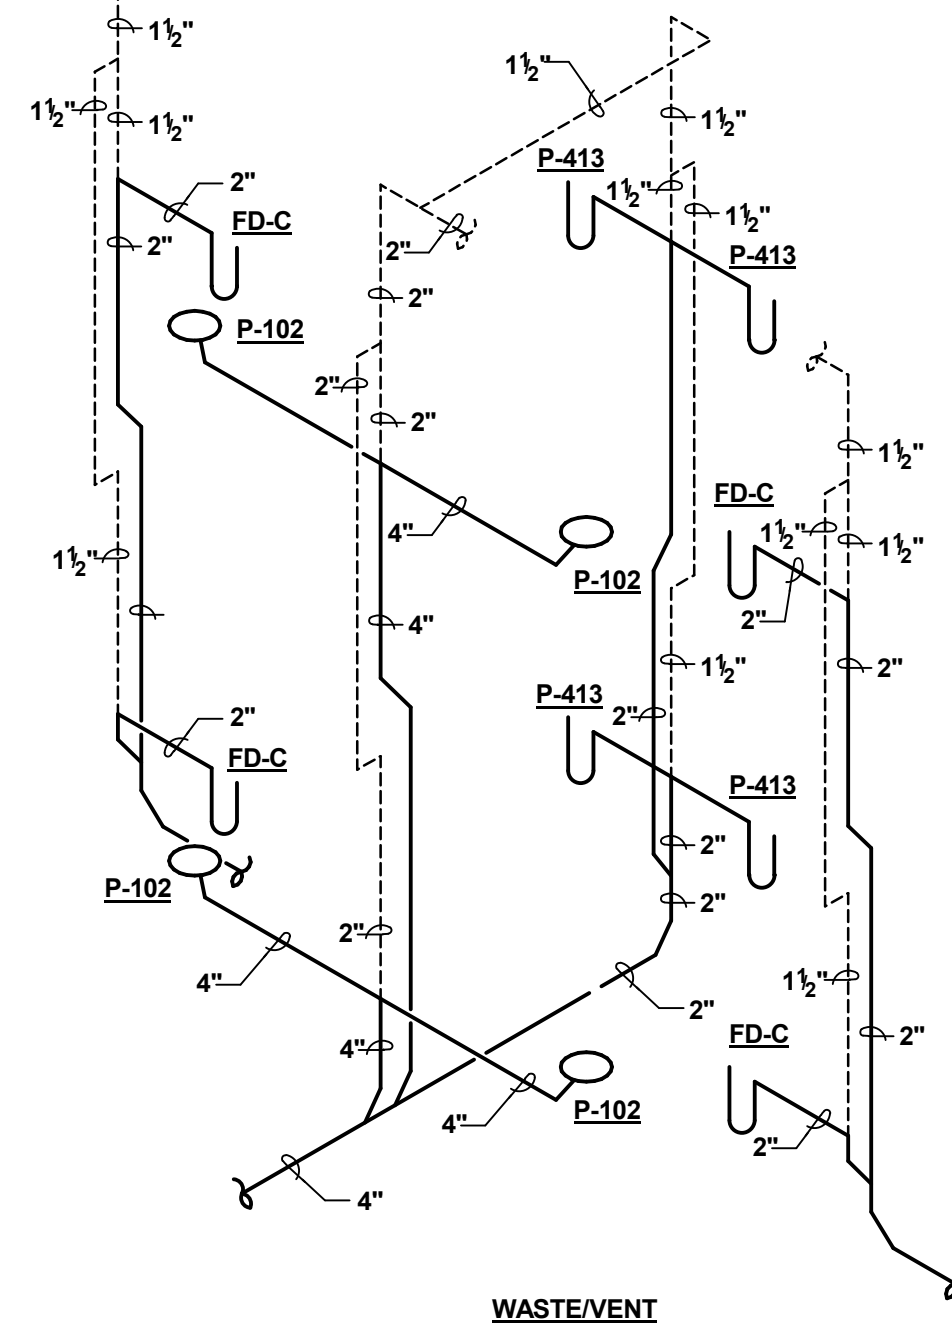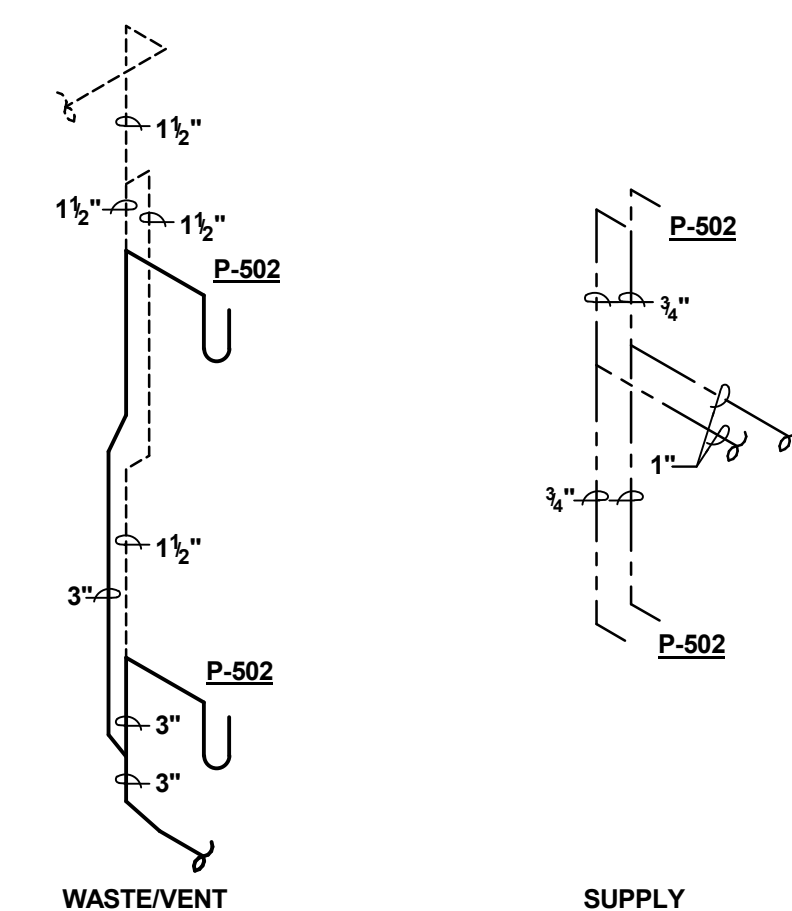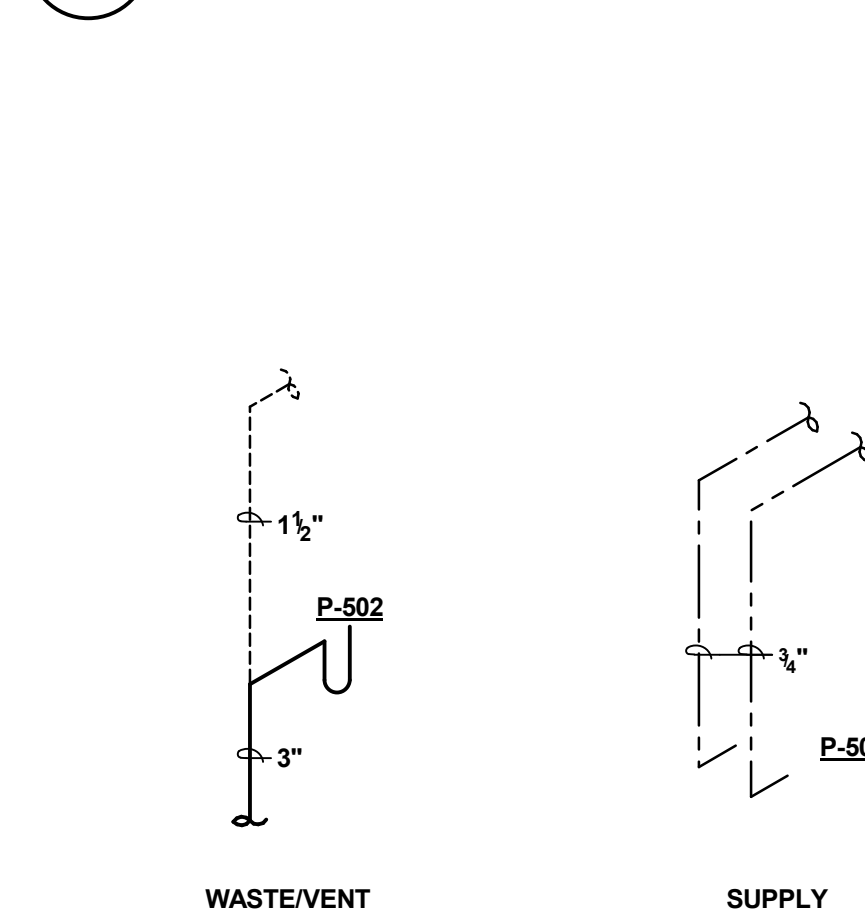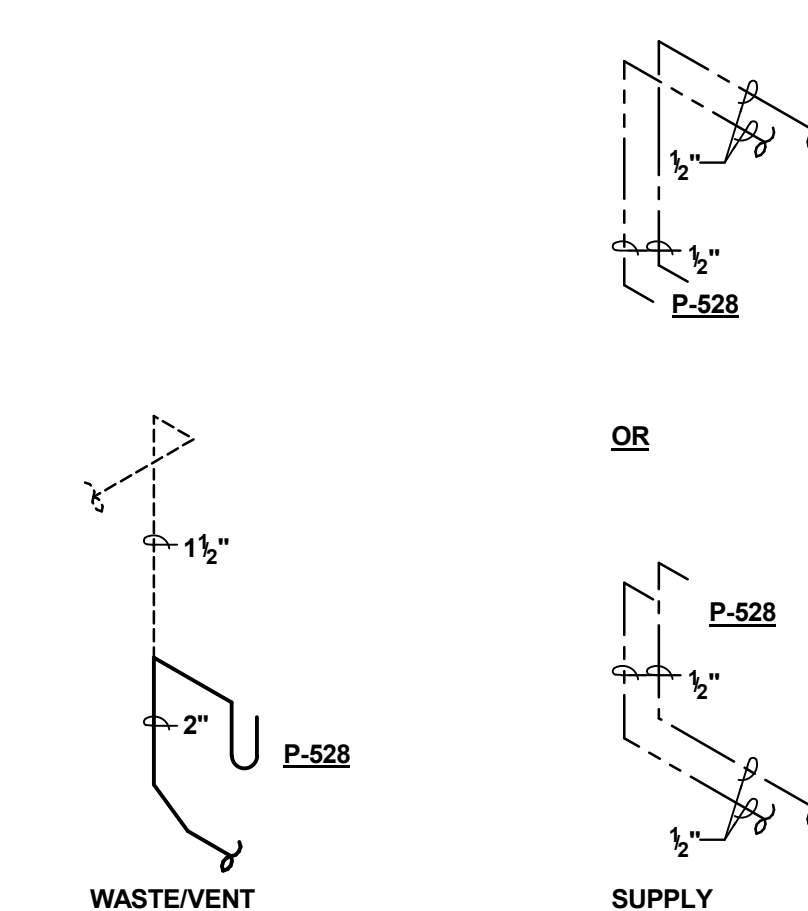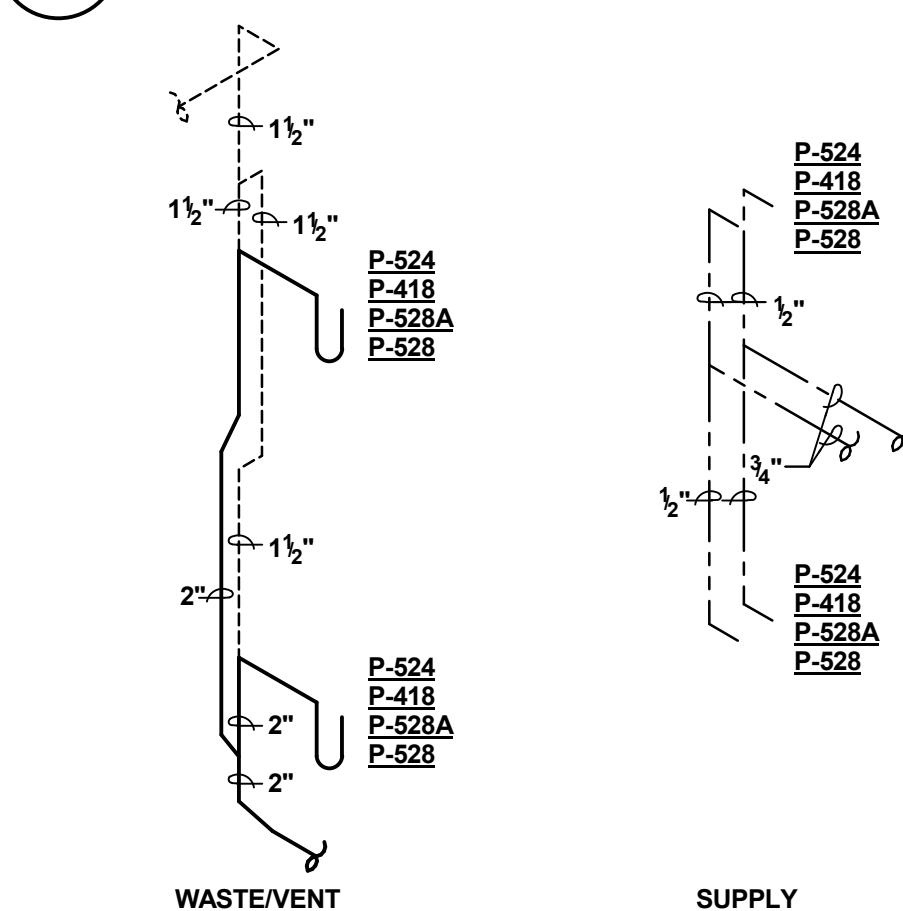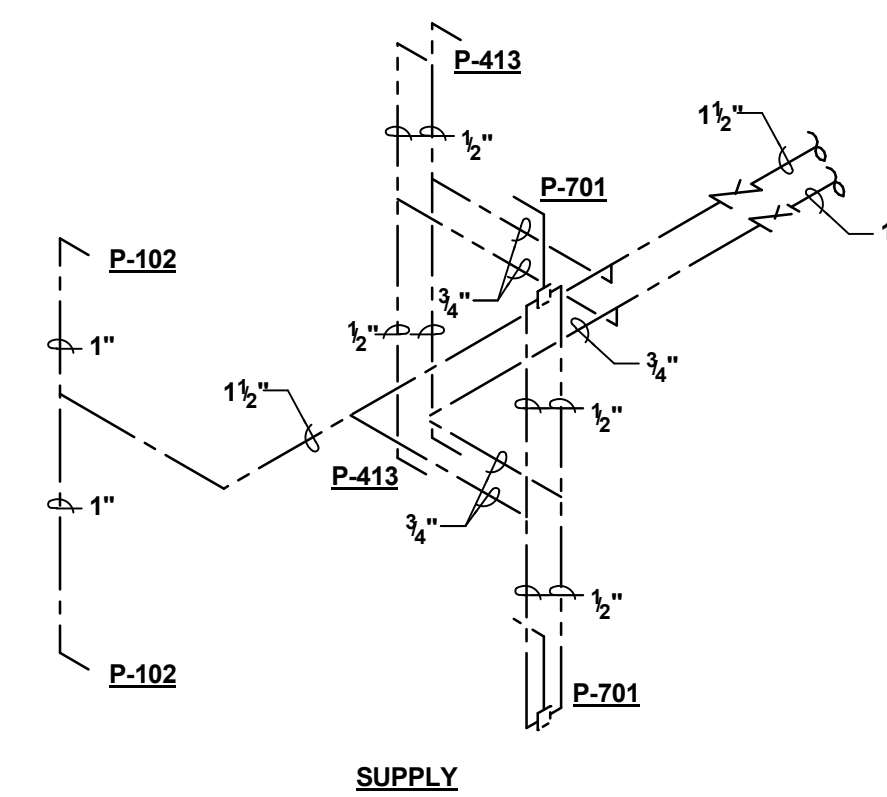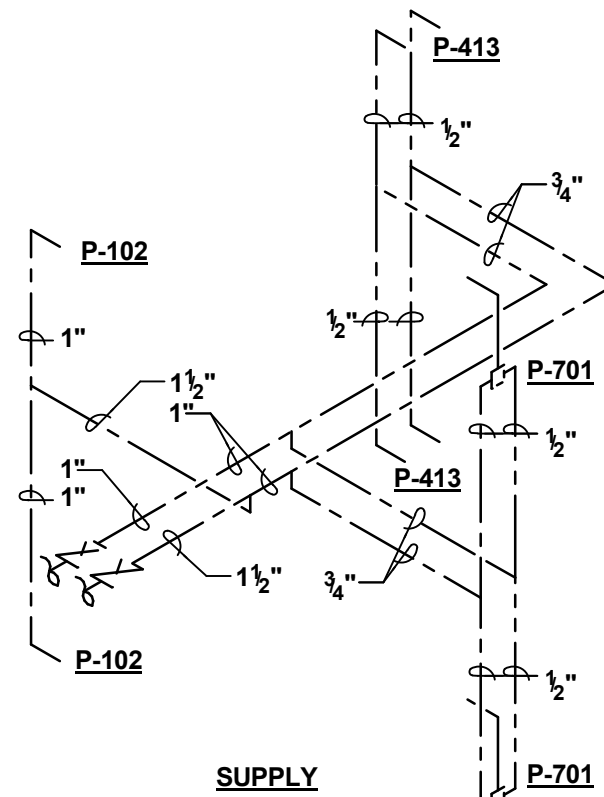

Drawing Title
PLUMBING RISER DIAGRAMS

Approved: Project Director

Project Title
**Sioux Falls VA Health Care System
Acute Inpatient Medical Unit Addition
and Renovation**

Location
VA Medical Center
2801 W. 22nd Street, PO Box 5046
Sioux Falls, SD 57117-5046

Date
08/06/2012

Checked
BSW

Drawn
RAK

Project Number
04100857

Building Number
5

Drawing Number

5-PL601
Dwg. 70 of 123

Office of
Construction
and Facilities
Management



**FULLY SPRINKLERED
100% CONSTRUCTION DOCUMENTS**