

1 UNDERGROUND CONCRETE PULLBOX
SCALE: NONE
INSTALLATION IN TUFF AREAS

SCALE: NONE

INSTALLATION IN TURF AREAS



2 UNDERGROUND CONCRETE PULLBOX
SCALE: NONE
INSTALLATION IN PAVE

SCALE: NONE

INSTALLATION IN PAVED AREAS

9 DRY TYPE PAD-MOUNTED STEP-UP TRANSFORMER DETAIL
NTS

NTS

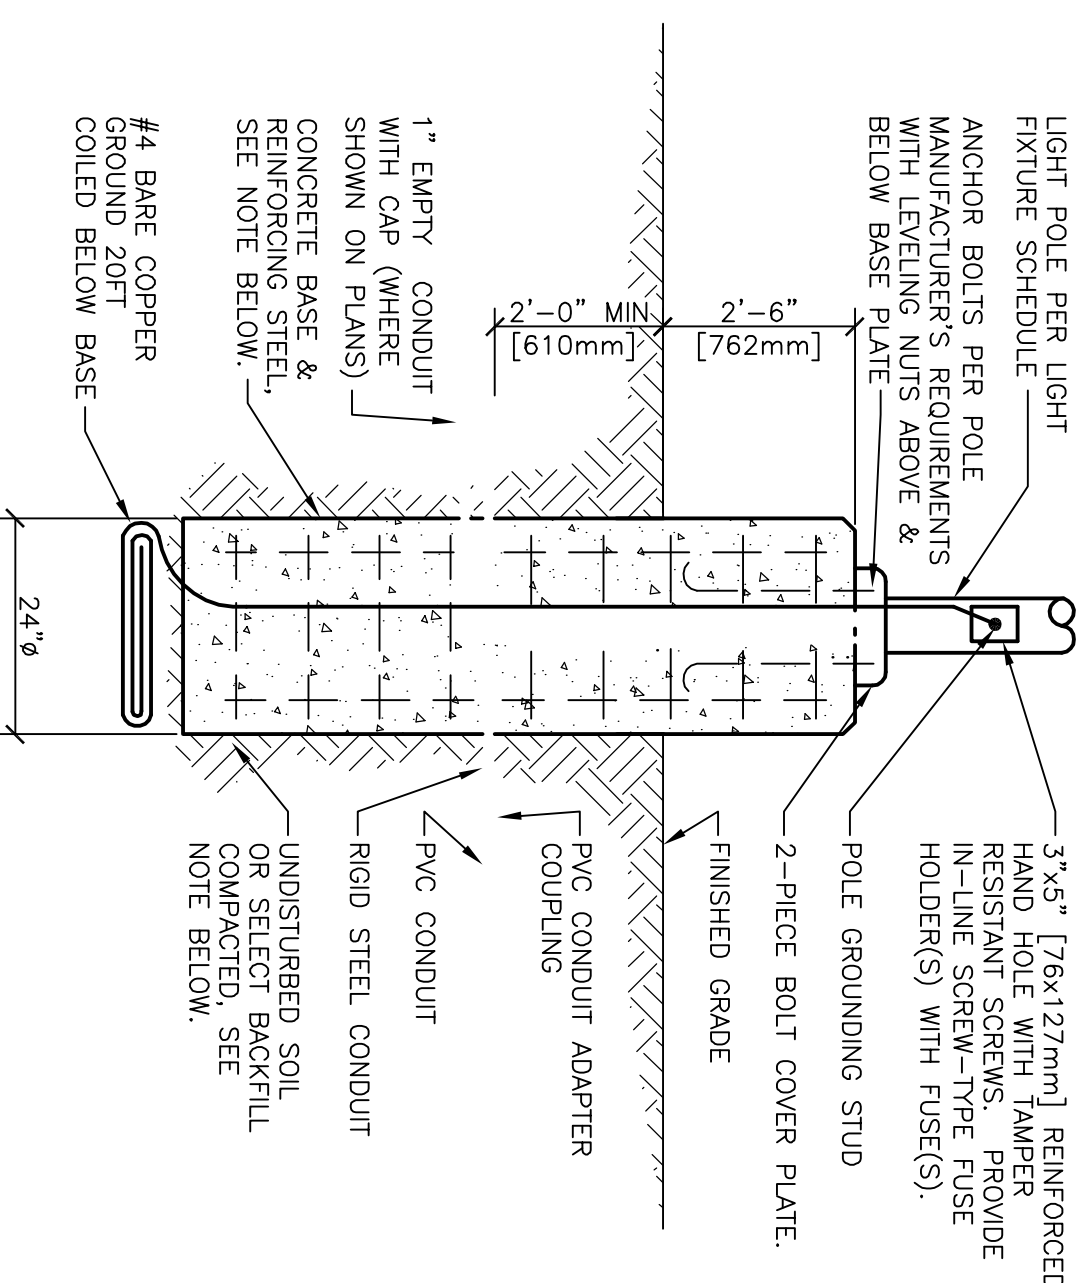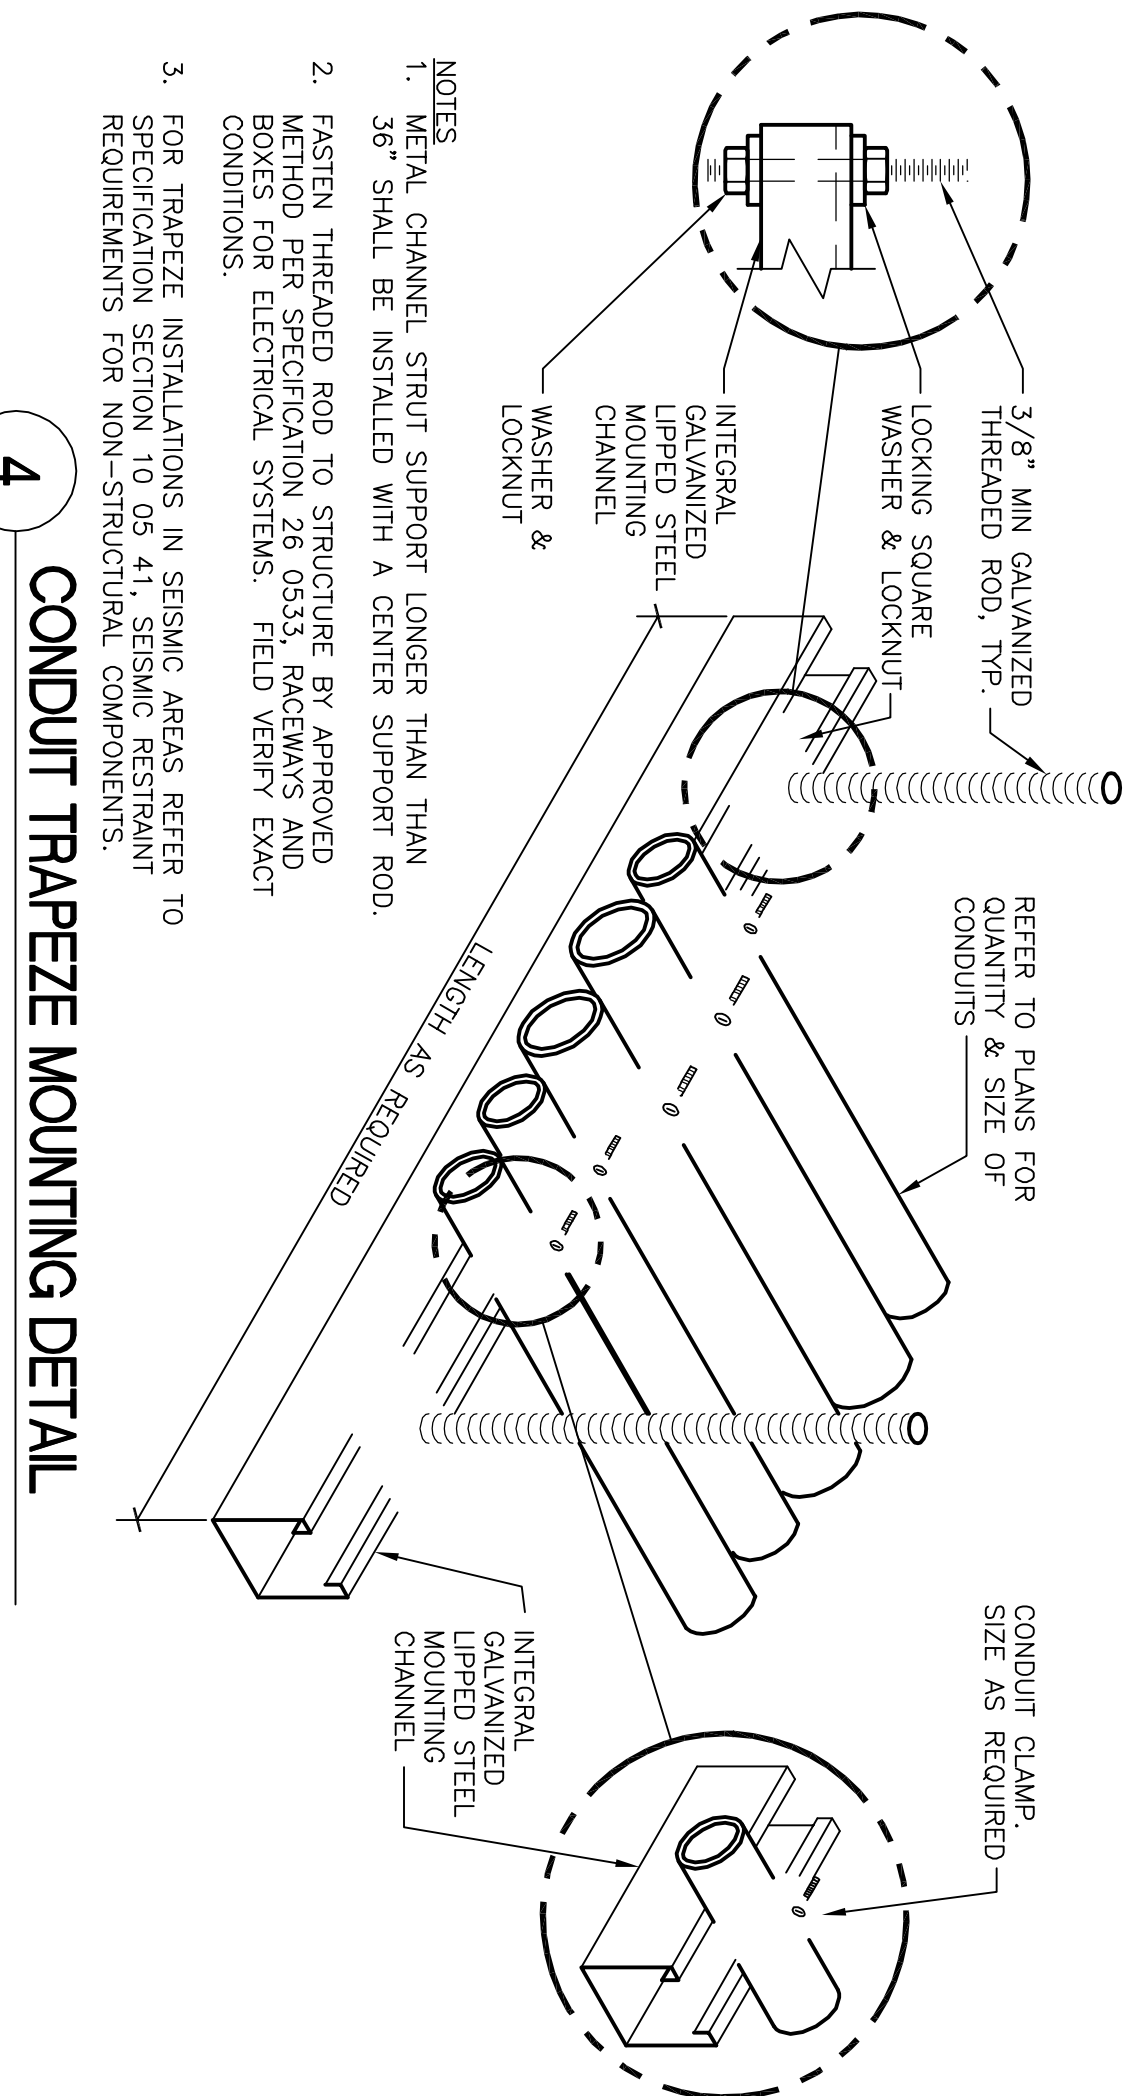

4 CONDUIT TRAPEZE MOUNTING DETAIL

NTS

3 POLE BASE DETAIL
NTS

NTS

[illegible]


CONSULTANTS:

LANDSCAPE ARCHITECT:
2030 PICCOLLOTTI SQUARE DRIVE
MOBILE, ALABAMA 36689
PH: (251) 344-4023
FX: (251) 344-4032

STRUCTURAL ENGINEERS, INC.
10401 FLORENDA MANOR DRIVE, SUITE 120
TAMPA, FLORIDA 33610
PH: (813) 740-2300
FX: (850) 432-8631

SCHEWITZ CONSULTING, INC.
40 S. PALMER PLACE, STE. 300
PENSACOLA, FLORIDA 32502
PH: (904) 471-0093
FX: (850) 471-0093

ARCHITECT/ENGINEERS:

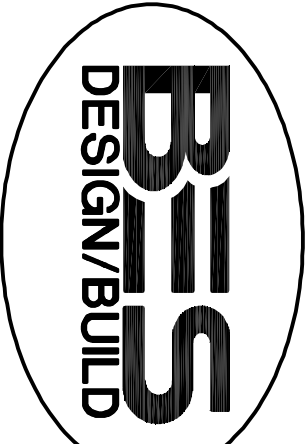

BES DESIGN/BUILD, LLC
766 Middle St, Fairhope, AL 36532
Phone: 251.990.5778 Fax: 251.990.3716

Drawing Title	ELECTRICAL DETAILS
Approved Project Director	

Project Title CONSTRUCT VA OUTPATIENT CLINIC, PANAMA CITY		Project Number 520-326	
Location PANAMA CITY, FLORIDA		Building Number -	
Date APRIL 2018	Observed KOE	Drawing Number EP300	
Pain GMS		Date 13 of 19	

**Office of
Construction
and Facilities
Management**

