


1 ENLARGED PLUMBING PLAN
PL101A10 SCALE: 1/4"=1'-0"

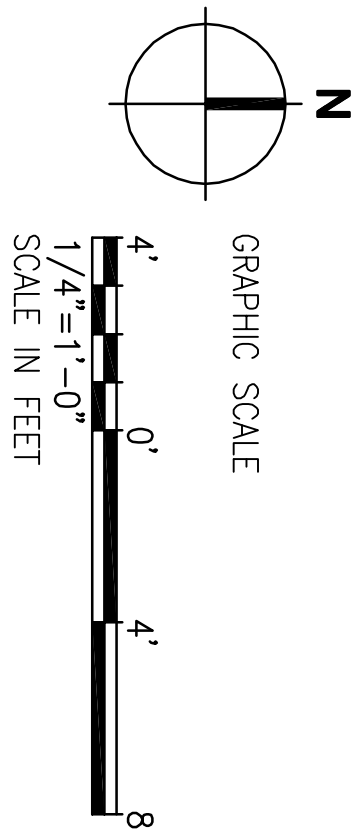

FINAL SUBMISSION / FULLY SPRINKLERED

| | | | |
|---|--|---|--|
| <div>one eighth inch = one foot</div> <div>one quarter inch = one foot</div> <div>three eighths inch = one foot</div> <div>one half inch = one foot</div> <div>three quarters inch = one foot</div> <div>one inch = one foot</div> <div>one and one half inches = one foot</div> <div>three inches = one foot</div> | | | |
| <div>VA FORM 08-6231</div> | | | |
| <div>Project Name</div> | | <div>Date</div> | |
| <div>CONSULTANTS:</div> | | | |
| <div>OWNER: KONNETH HORNE & ASSOCIATES 7201 NORTH 9TH AVENUE, STE. 6 DENVER, CO 80231 Ph: (850) 471-8005 Fx: (850) 471-0093</div> | | <div>CONSULTING GROUP, INC. 40 S. PALMER PARK, STE. 300 DENVER, CO 80231 Ph: (850) 438-0950 Fx: (850) 432-8831</div> | |
| <div>DESIGNER: JANUSKATZ ARCHITECT 6800 PROUDLY SQUARE DRIVE DENVER, CO 80231 Ph: (303) 344-4023 Fx: (203) 344-4023</div> | | <div>SUPERVISOR: JANUSKATZ ARCHITECT, INC. 10401 HIGHLAND AVENUE DRIVE, SUITE 120 DENVER, CO 80231 Ph: (613) 749-2200</div> | |
| <div>ARCHITECT/ENGINEERS:</div> | | <div>PLUMBING</div> | |
| <div>BES DESIGN/BUILD, LLC 766 Middle St., Fairhope, AL 36532 Phone: 251.990.5778 Fax: 251.990.3716</div> | | <div>PL101A10</div> | |
| <div>Drawing Title ENLARGED PLUMBING PLAN, WATER OVERALL LAYOUT ALTERNATE WORK</div> | | <div>Project Title CONSTRUCT VA OUTPATIENT CLINIC, PANAMA CITY</div> | |
| <div>Approved Project Director</div> | | <div>Project Number 520-926</div> | |
| <div>Location PANAMA CITY, FLORIDA</div> | | <div>Building Number -</div> | |
| <div>Date APRIL 2018</div> | | <div>Drawing Number PL401A10</div> | |
| <div>Checked WMB</div> | | <div>Dwg. 2 of 4</div> | |
| <div>Drawn JLL</div> | | <div>Department of Veterans Affairs</div> | |
| <div>Office of Construction and Facilities Management</div> | | | |